


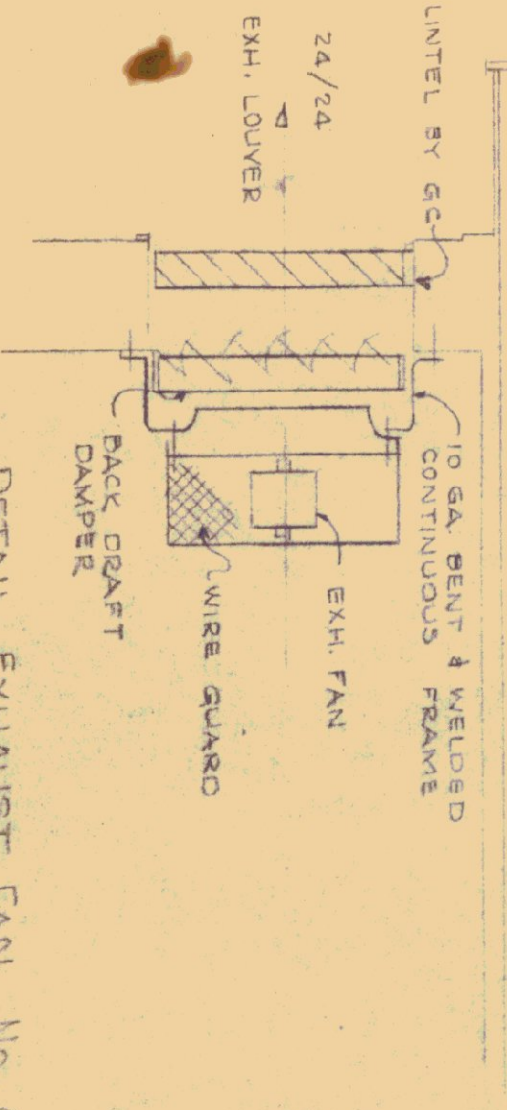

MARK	VENTILATING	EQUIPMENT	SCHEDULE	REMARKS							
EF-1	CENT.	EF-2	CENT.	EF-3	CENT.	EF-4	CENT.	EF-5	CENT.	EF-6	PROPELLER
GREENHECK	GREENHECK	GREENHECK	GREENHECK	GREENHECK	GREENHECK	GREENHECK	GREENHECK	GREENHECK	GREENHECK	GREENHECK	COOK
100 M	100 M	100 M	100 M	100 M	100 M	100 M	100 M	100 M	100 M	100 M	AWD-16
450	700	900	2100	250	2500/1000						
3/8"	3/8"	3/8"	1/2"	1/2"	1/2"	1/2"	1/2"	1/2"	1/2"	1/2"	1/2"
1160	1160	1160	1153	1162	1162	1162	1162	1162	1162	1162	1162
120	120	120	120	120	120	120	120	120	120	120	120
Bottom Hoist	Bottom Hoist	Bottom Hoist	Bottom Hoist	Bottom Hoist	Bottom Hoist	Bottom Hoist	Bottom Hoist	Bottom Hoist	Bottom Hoist	Bottom Hoist	Bottom Hoist

- NOTES:
- 1 ALL EXHAUST FANS TO BE TOTALLY ENCLOSED FAN-COOLED BALL BEARINGS.
 - 2 EF-3 PROVIDE ACCESS DOOR IN FAN INSTALLATION ENCLOSURE.
 - 3 ALL EXHAUST FAN LOCATIONS SHALL BE PROVIDED WITH ACCESS PANELS THROUGH CEILING AND A VISUAL OF ACCESS THROUGH INSULATION WITHOUT DEFERRING FROM BUILDING MATERIAL APPEARANCE AND INSULATION VALUE.
 - 4 EF-6 TWO-SPEED MOTOR AND STARTER; FAN GUARD.
 - 5 PROVIDE PULS AND BIRD SCREEN AT SOFFIT GRILLES - 1/2" MESH REMOVABLE EXTERIOR SCREEN.
 - 6 HEATING AND VENTILATING CONTRACTOR SHALL PROVIDE INSULATION ON ALL DUCTWORK PASSING THROUGH AND ABOVE BUILDING INSULATION TYPE AND QUALITY AS SPECIFIED.
 - 7 ALL DUCT WORK AT SOFFIT - OUTSIDE WALL KEEP 9" OR LESS IN HEIGHT.



REVISIONS	DATE	BY	DESCRIPTION

STATE OF VERMONT
DEPARTMENT OF ADMINISTRATION
VERMONT

ST. JOHNSBURY OFFICE BUILDING
Ventilating Plan and Schedule

DATE: 6-18-72
DESIGNED BY: G.M.H.
DRAWING BY: P.W.

APPROVED BY: DIRECTOR
DATE: 6/30/72

DWG. NO. HV-3
17 OF 17

ELEVATION
DETAIL EXHAUST FAN No. 3
NTS.

FLOOR PLAN
STATE BUILDINGS DIVISION

DETAIL EXHAUST FAN No. 6
SCALE 3/4" = 1'-0"