



SECTION A-A ROOF PAKE EDGE
SCALE: 3/8"=1'-0"

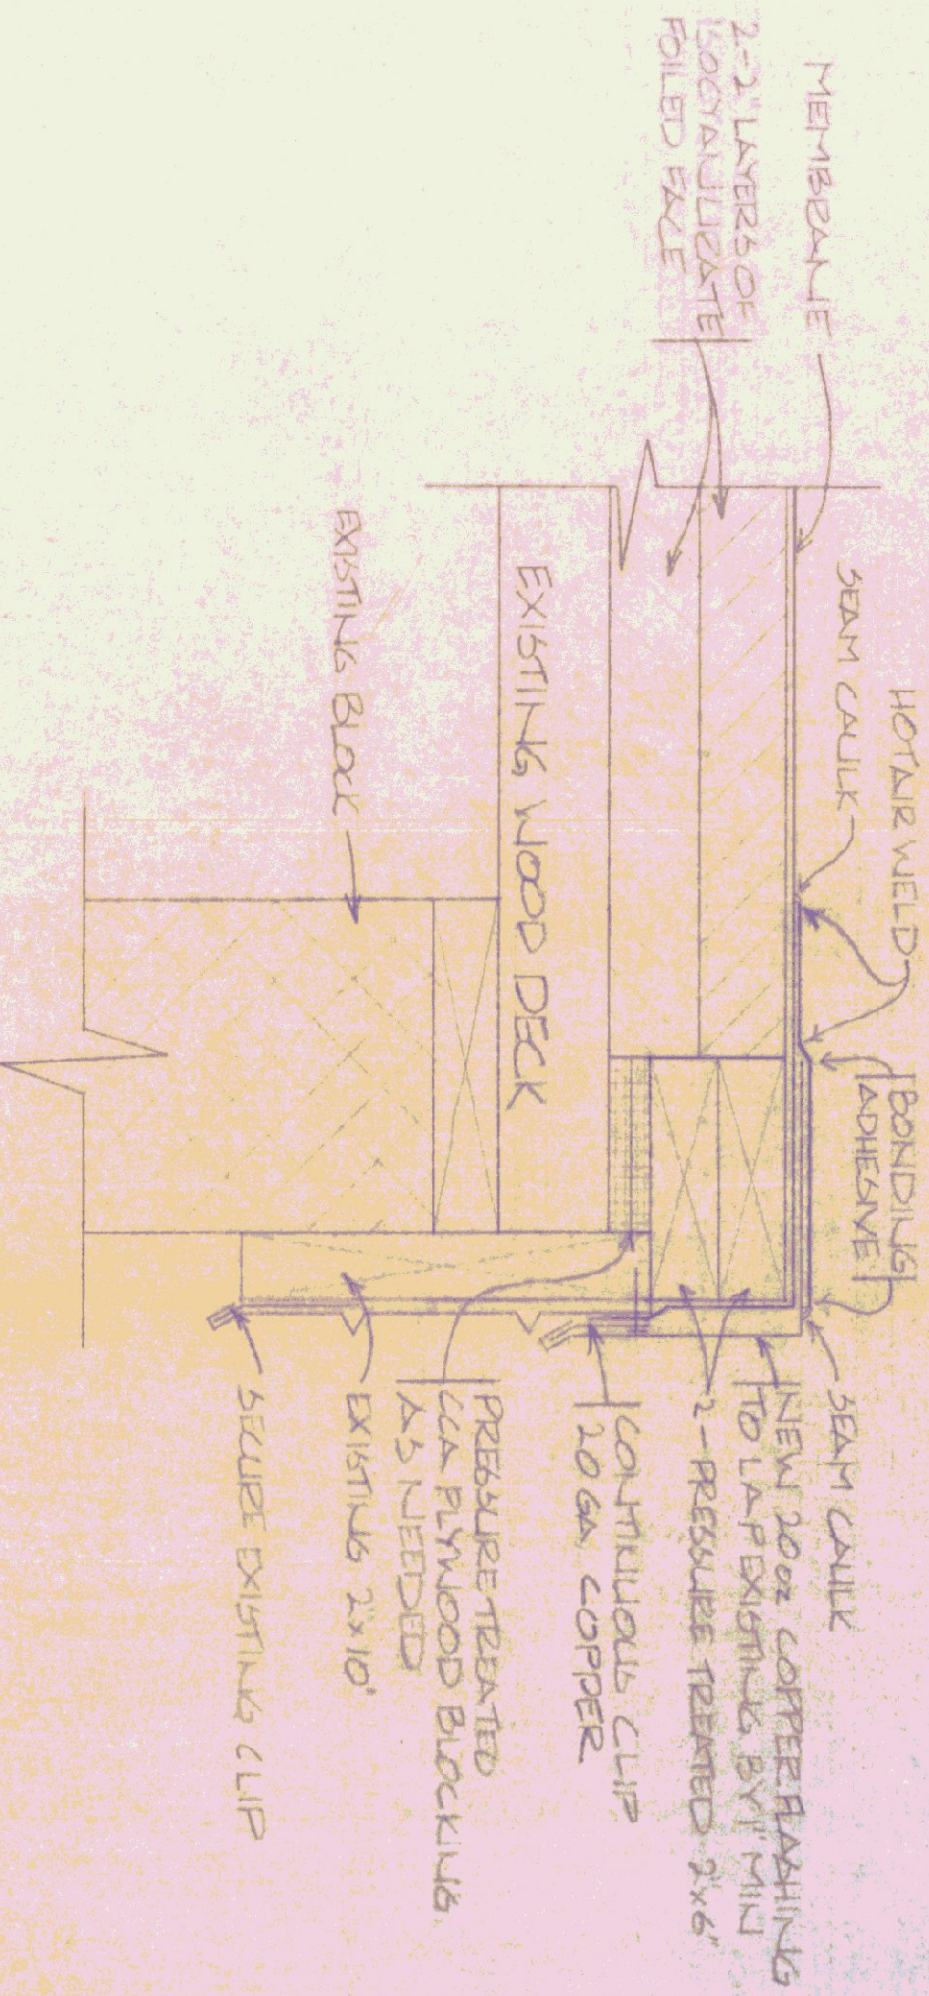


SECTION B-B ROOF DRIP EDGE
SCALE: 3/8"=1'-0"




CHIMNEY FLASHING DETAIL
SCALE: 3/8"=1'-0"

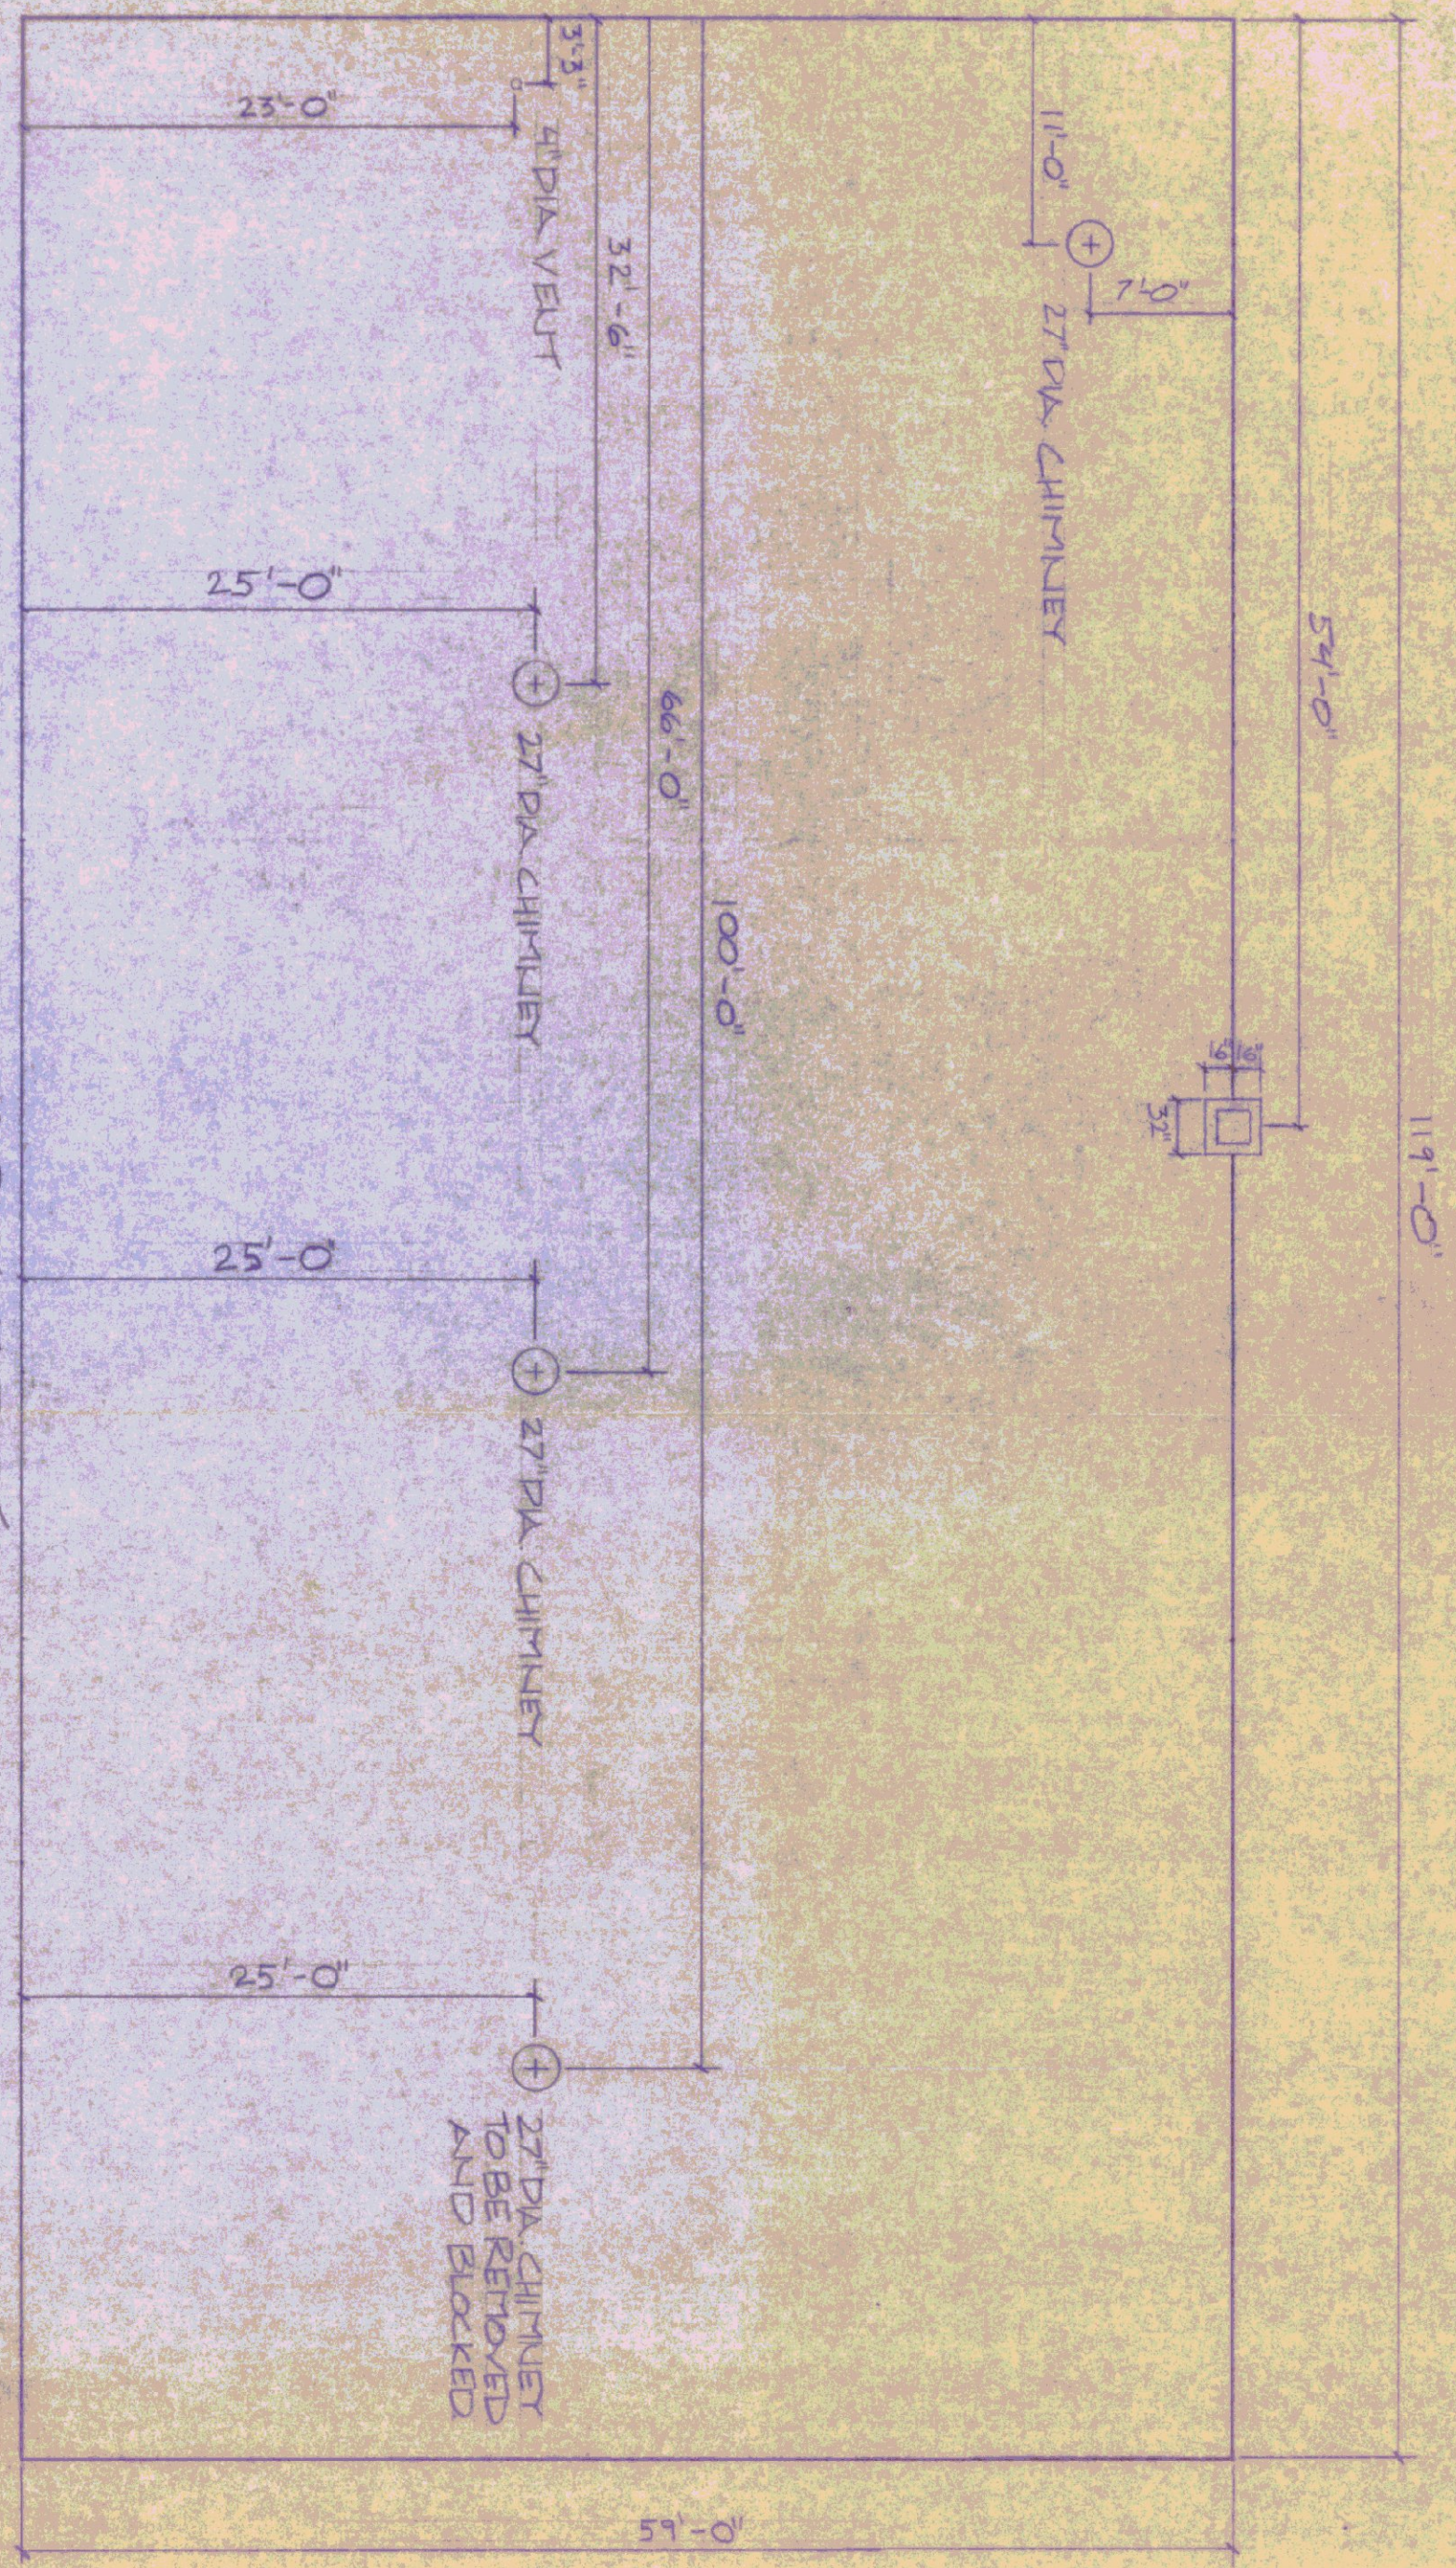


6-BAY GARAGE ROOF PLAN
SCALE: 1/8"=1'-0"

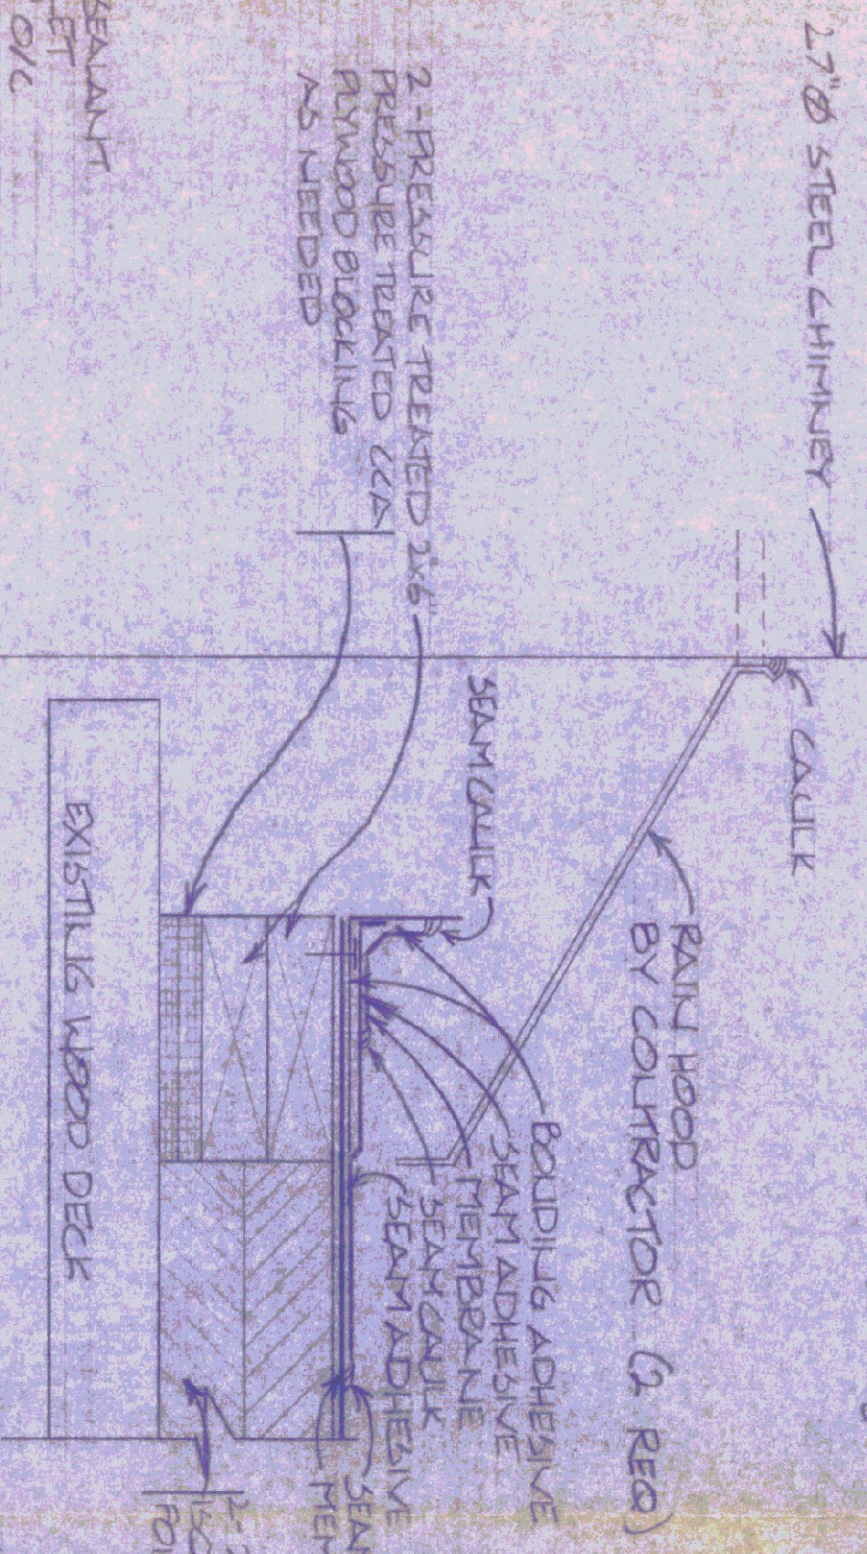

STEEL CHIMNEY DETAIL
SCALE: 3/8"=1'-0"

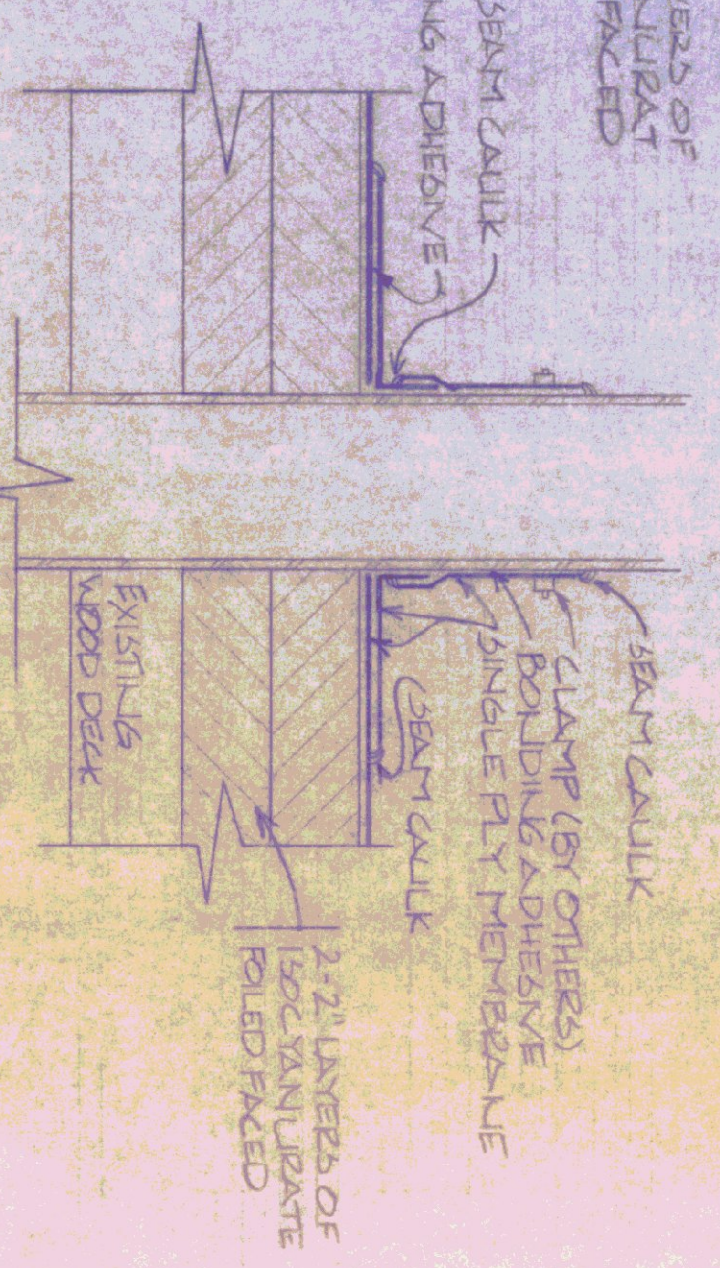

VENT STACK DETAIL
SCALE: 3/8"=1'-0"

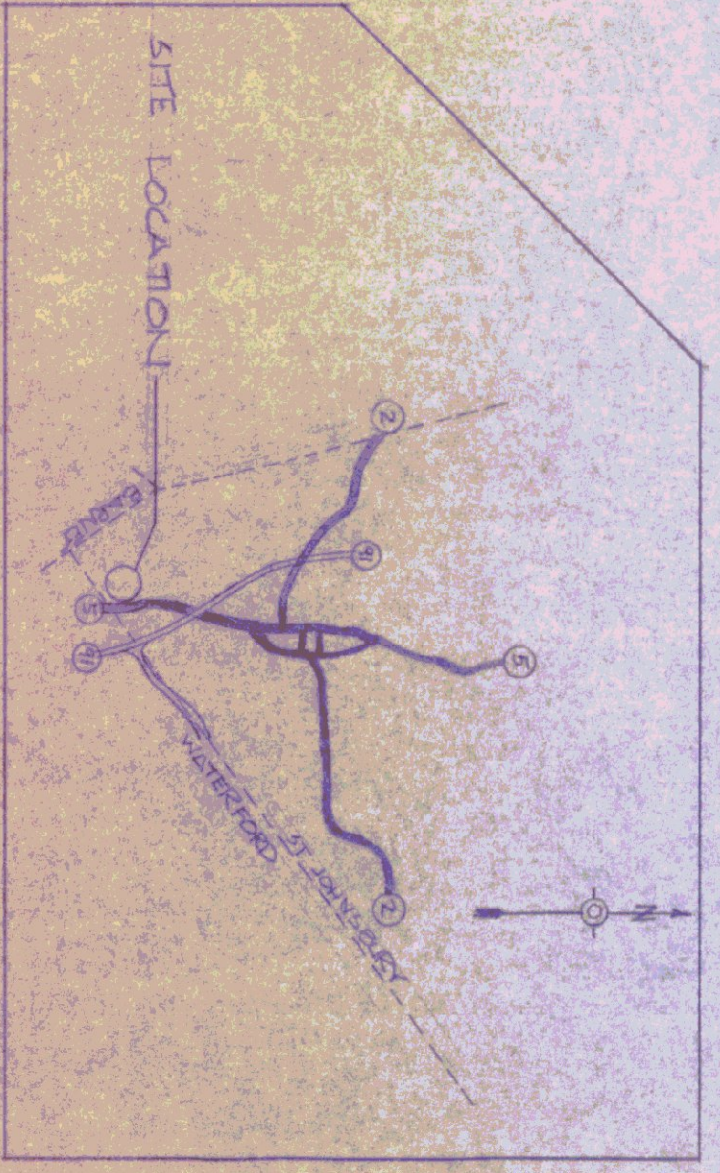

STATE OF VERMONT DEPARTMENT OF STATE BUILDINGS AGENCY OF ADMINISTRATION MONTPELIER, VERMONT			
A.O.T. ST JOHNSBURY 6-BAY GARAGE RE ROOFING PROJECT			
DATE 10-29-84	SCALE AS SHOWN	REVISIONS	DWG NO.
DRAWN BY [Signature]	APPROVED BY [Signature]		