



**LP GAS SUPPLY PIPE TRENCHING DETAIL**  
NOT TO SCALE

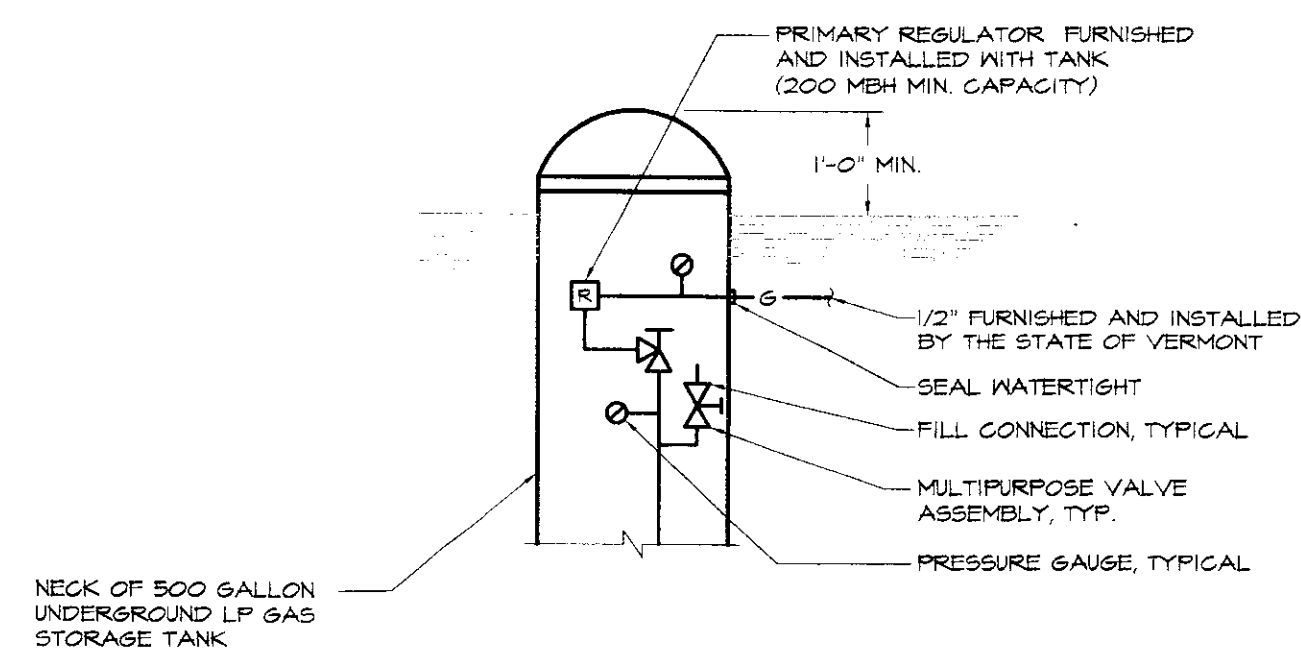


**LP GAS SUPPLY PIPING DETAIL**  
NOT TO SCALE

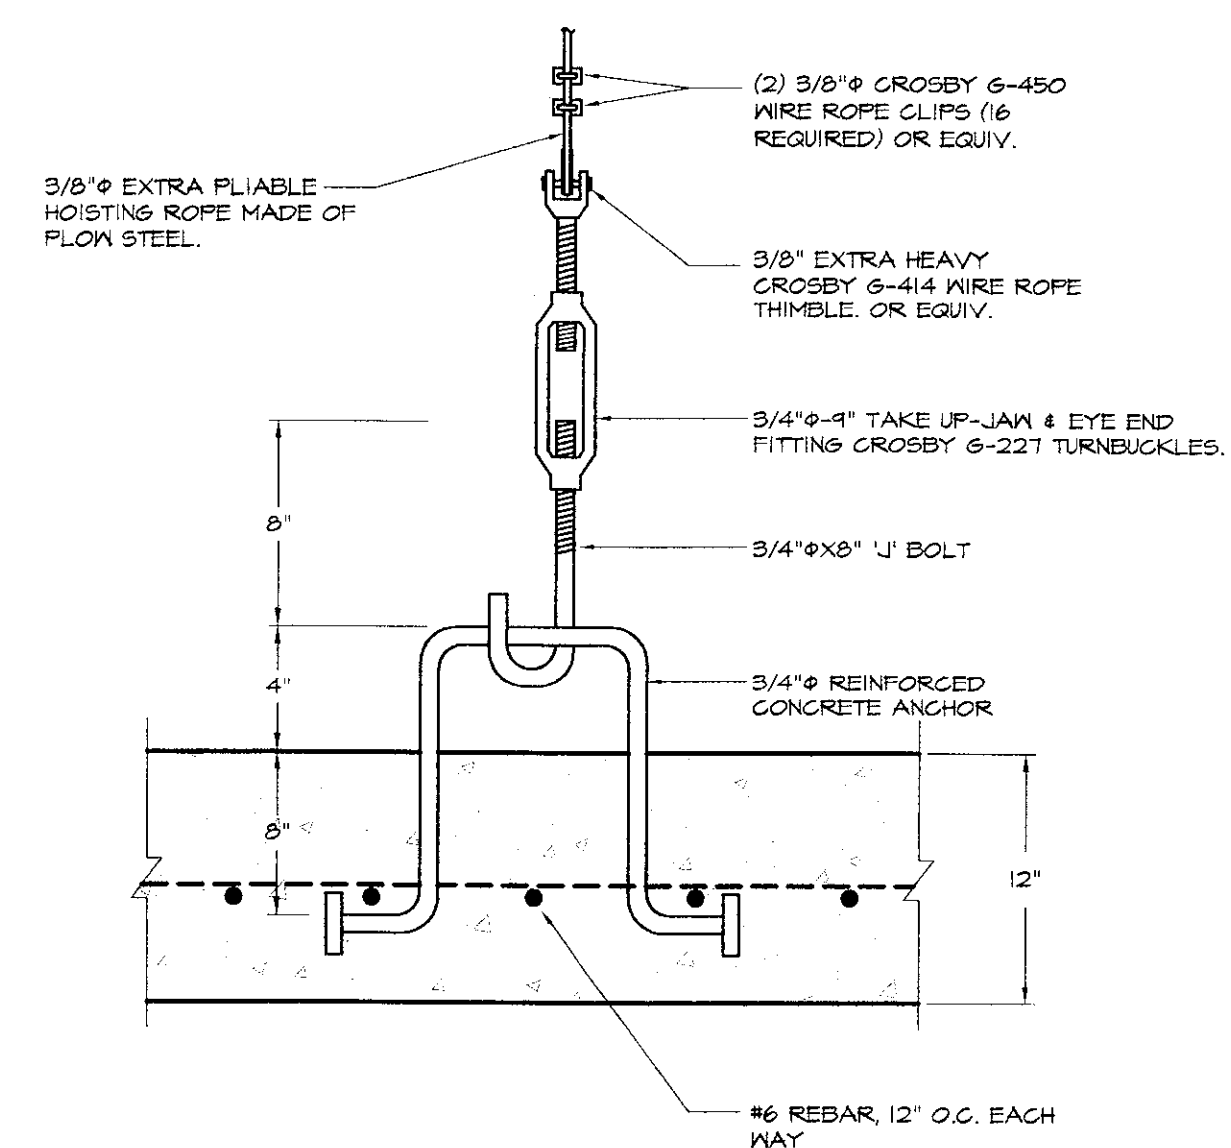

**TANK ANCHOR BOLT DETAIL**  
NOT TO SCALE


NOTE:  
TANK ANCHOR BOLTS TO BE FURNISHED AND INSTALLED BY THE STATE OF VERMONT.

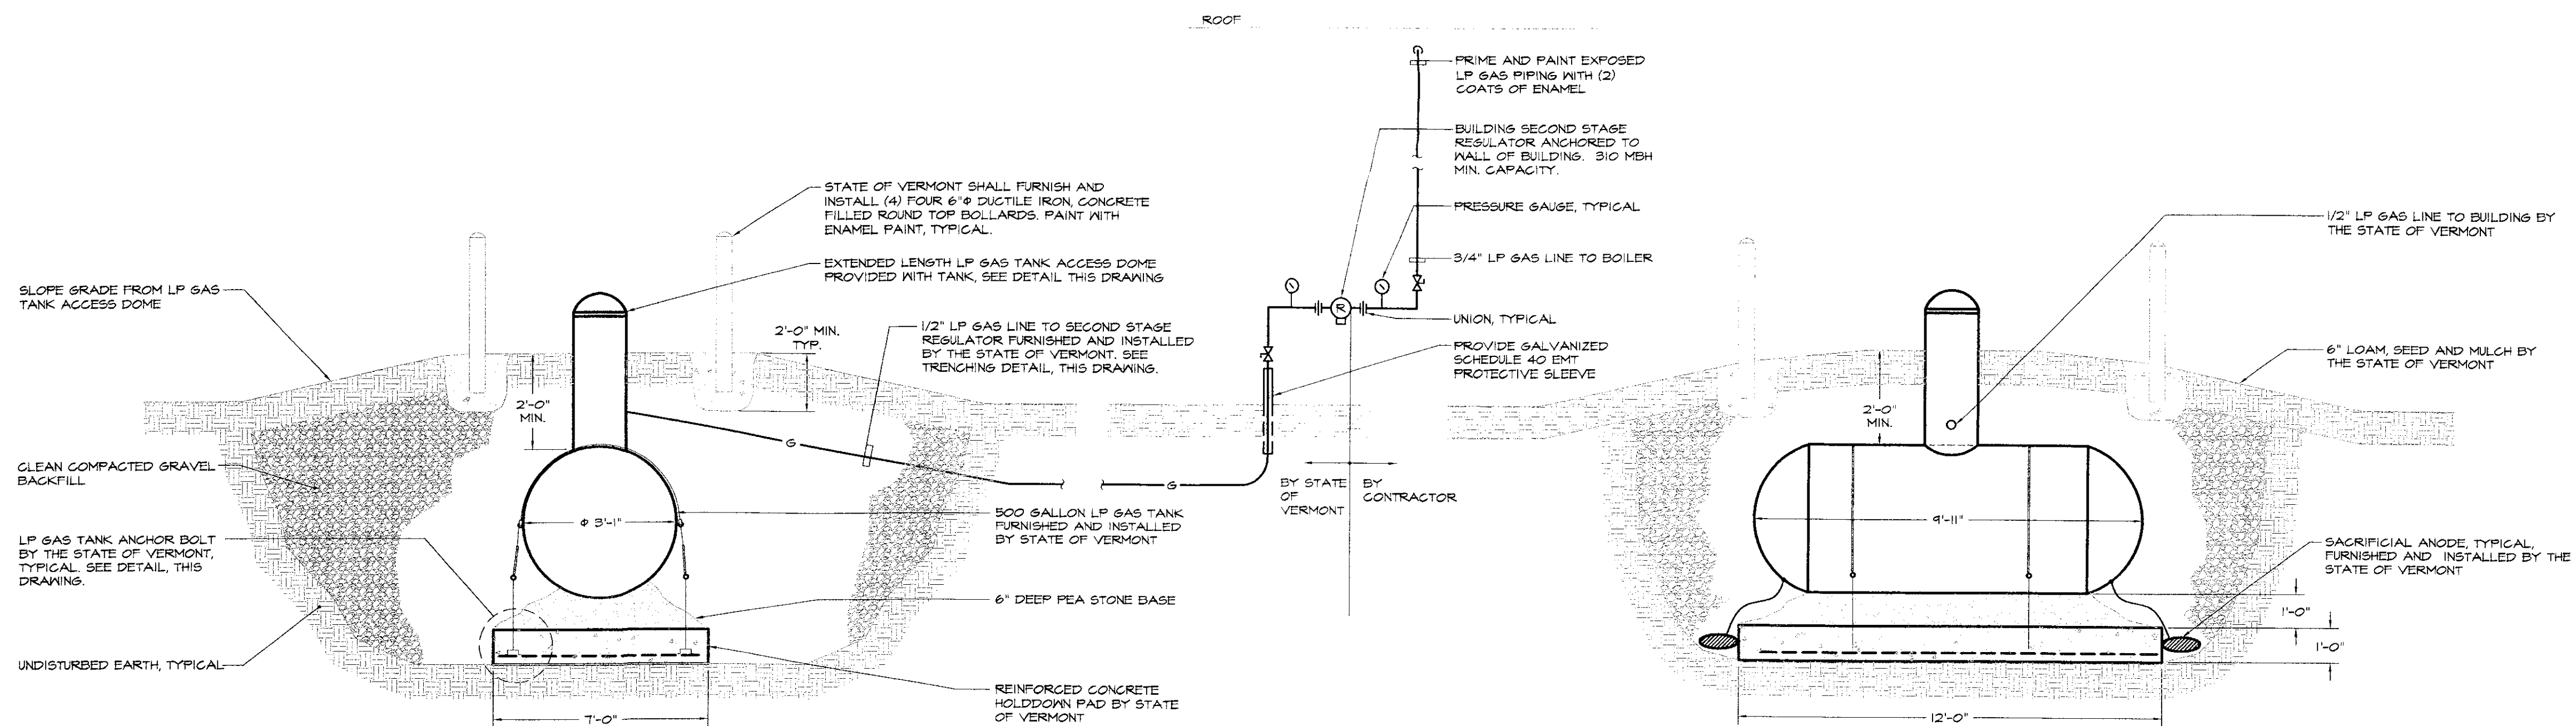


**UNDERGROUND LP GAS TANK DETAILS**  
NOT TO SCALE

NOTE:  
TANK REGULATORS, PIPING AND ACCESSORIES, INCLUDING FIRST AND SECOND STAGE REGULATORS, TO BE FURNISHED AND INSTALLED BY STATE OF VERMONT.

X:\031226\Drawings\Mech\031226M03.dwg, M3, 12/27/2005 1:52:58 PM, © LANE ASSOCIATES CONSULTING ENGINEERS P.C. 2005

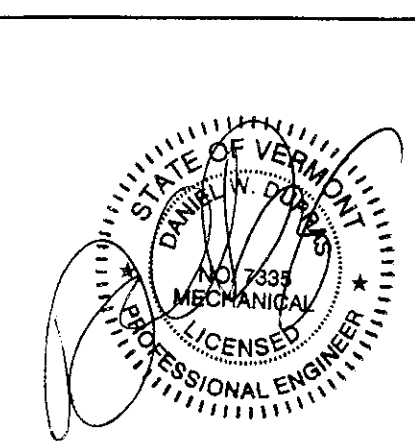

NO.	ISSUED FOR	DATE
2	REVISED FOR BIDDING	12/21/2005
1	BIDDING	10/20/2005

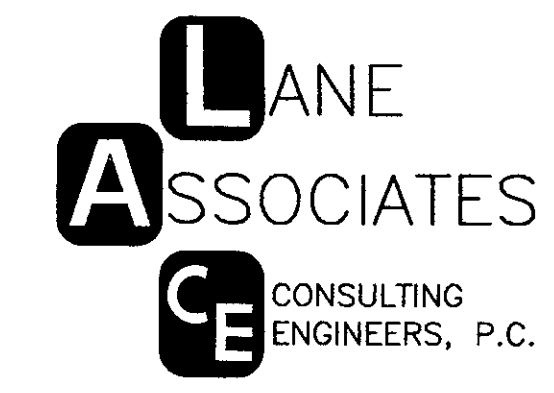

HEATING, VENTILATION, & AIR CONDITIONING,  
PLUMBING, FIRE PROTECTION, & ELECTRICAL

CHARLES F. LANE, P.E.  
DANIEL W. DUPRAS, P.E.

51 HILLINGTON AVENUE,  
RUTLAND, VERMONT 05701  
TELEPHONE: (802)747-3346  
FAX/MODEM: (802)747-3356

MECHANICAL DETAILS

NEW HEATING SYSTEM  
BRIDGE SHOP/STOCK BUILDING  
ST. JOHNSBURY AOT  
ST. JOHNSBURY, VT

APPR: DWD DRAWN: DWD/GJT SCALE: AS NOTED PROJ. NO. 0312-26

M  
3