




- FIXTURE SCHEDULE**
- F-1 WALL MOUNTED CERAMIC LAVATORY
 - F-2 WALL MOUNTED URINAL WITH VACUUM BREAKER ON FLUSH VALVE
 - F-3 FLOOR MOUNTED CERAMIC TOILET FIXTURE WITH ELONGATED FRONT (16" HIGH)
 - F-4 WALL MOUNTED DRINKING FOUNTAIN WITH ELECTRIC COOLER

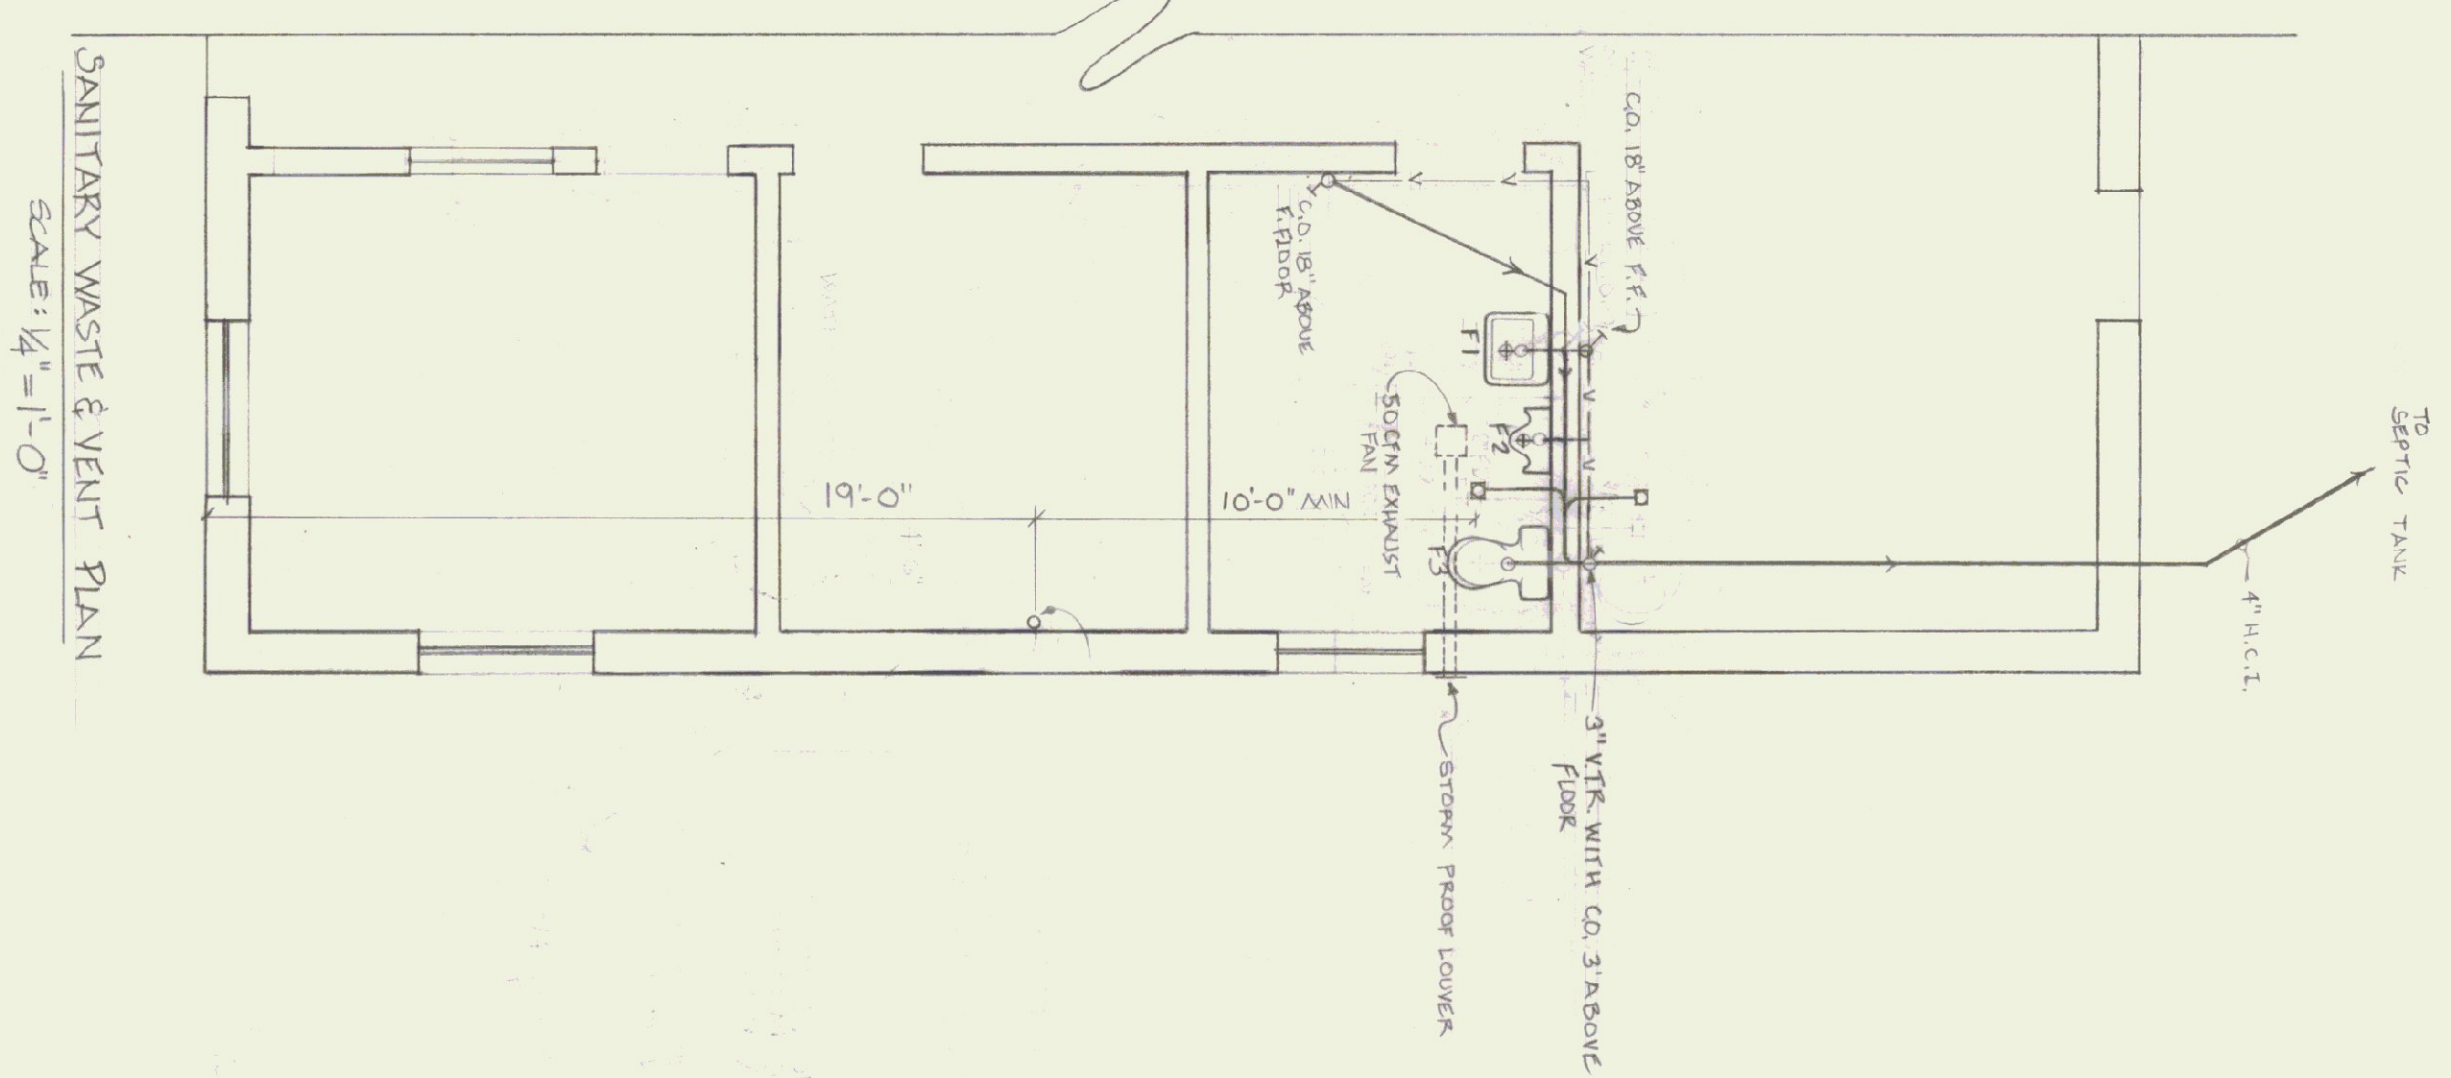


SANITARY WASTE & VENT PLAN
SCALE: 1/4" = 1'-0"

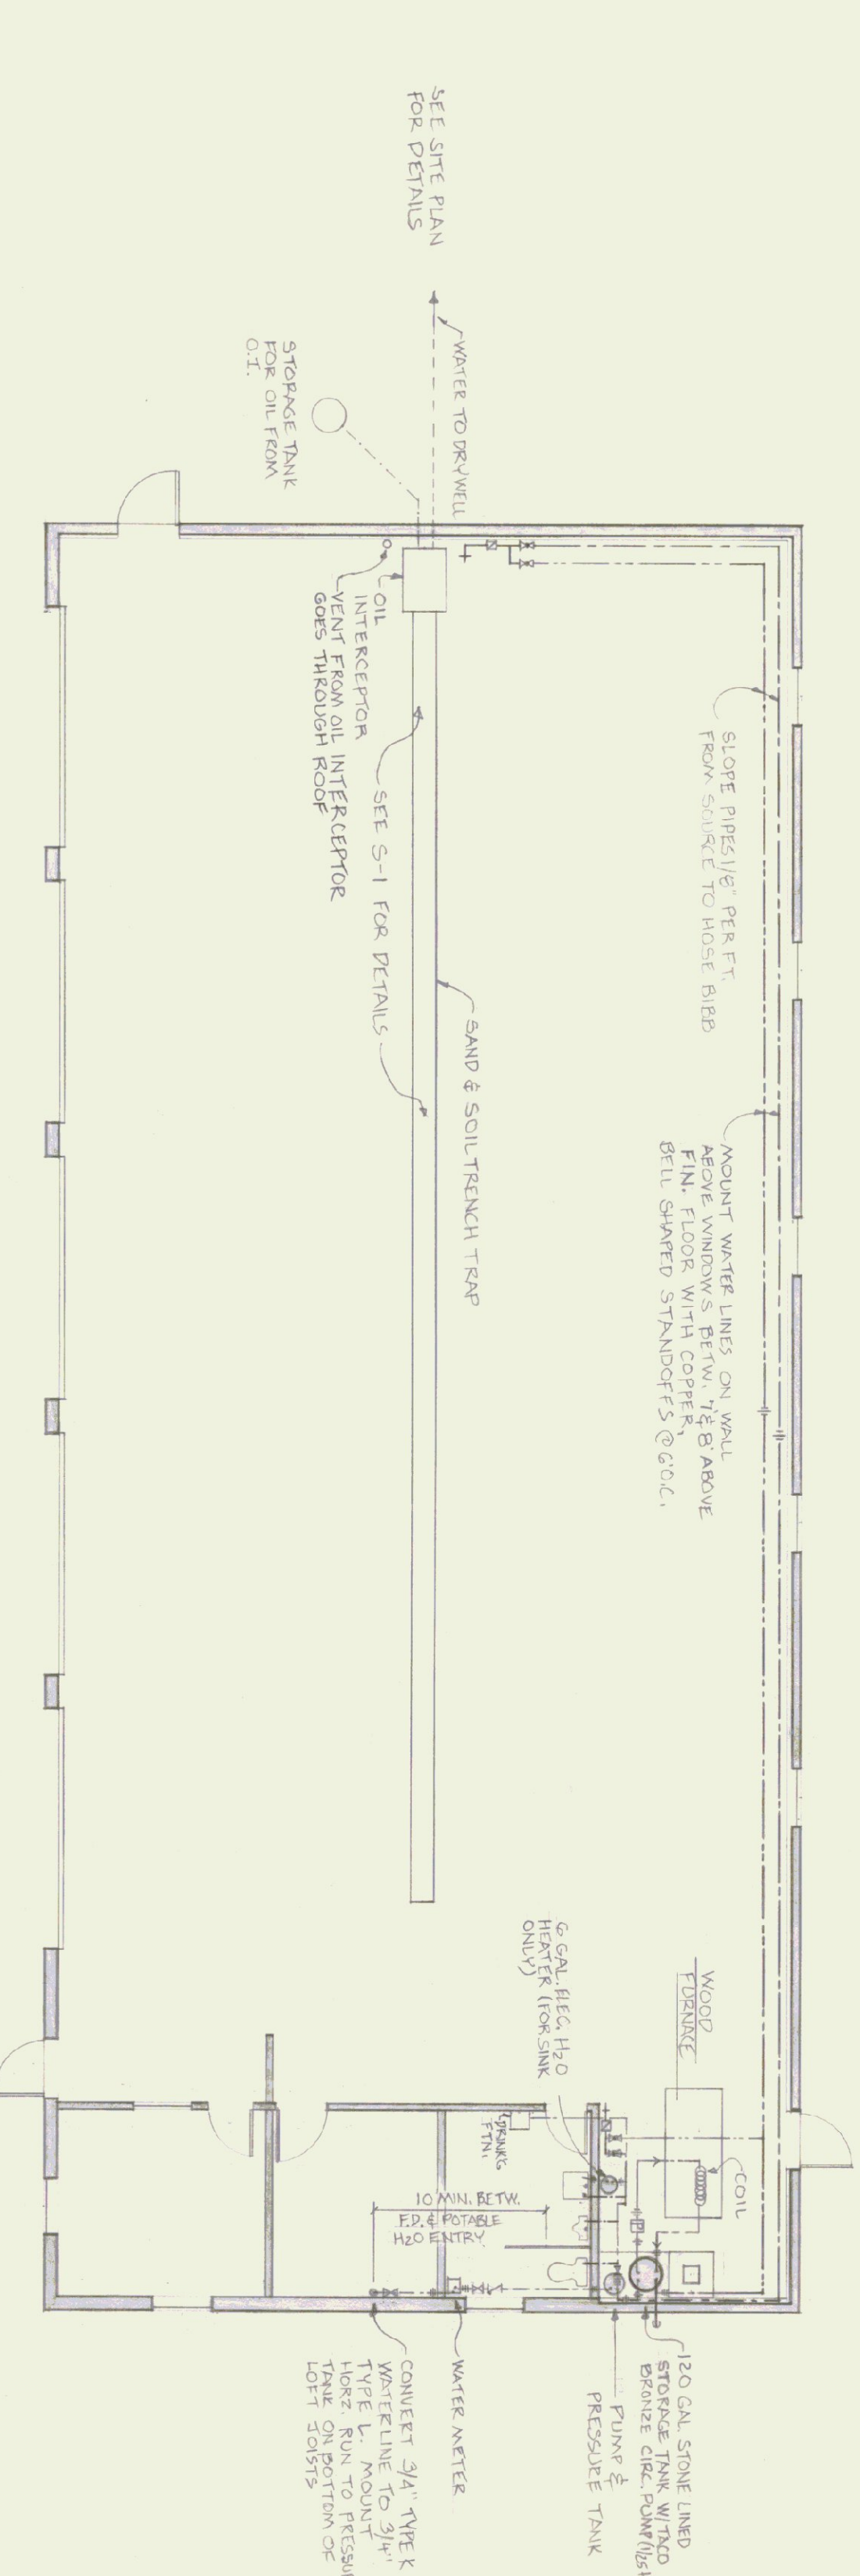

HOT & COLD WATER PIPING PLAN
SCALE: 1/8" = 1'-0"
NOTE: SEE PIPING RISER DIAGRAM BELOW FOR DEFINITION OF VALVES & FITTINGS

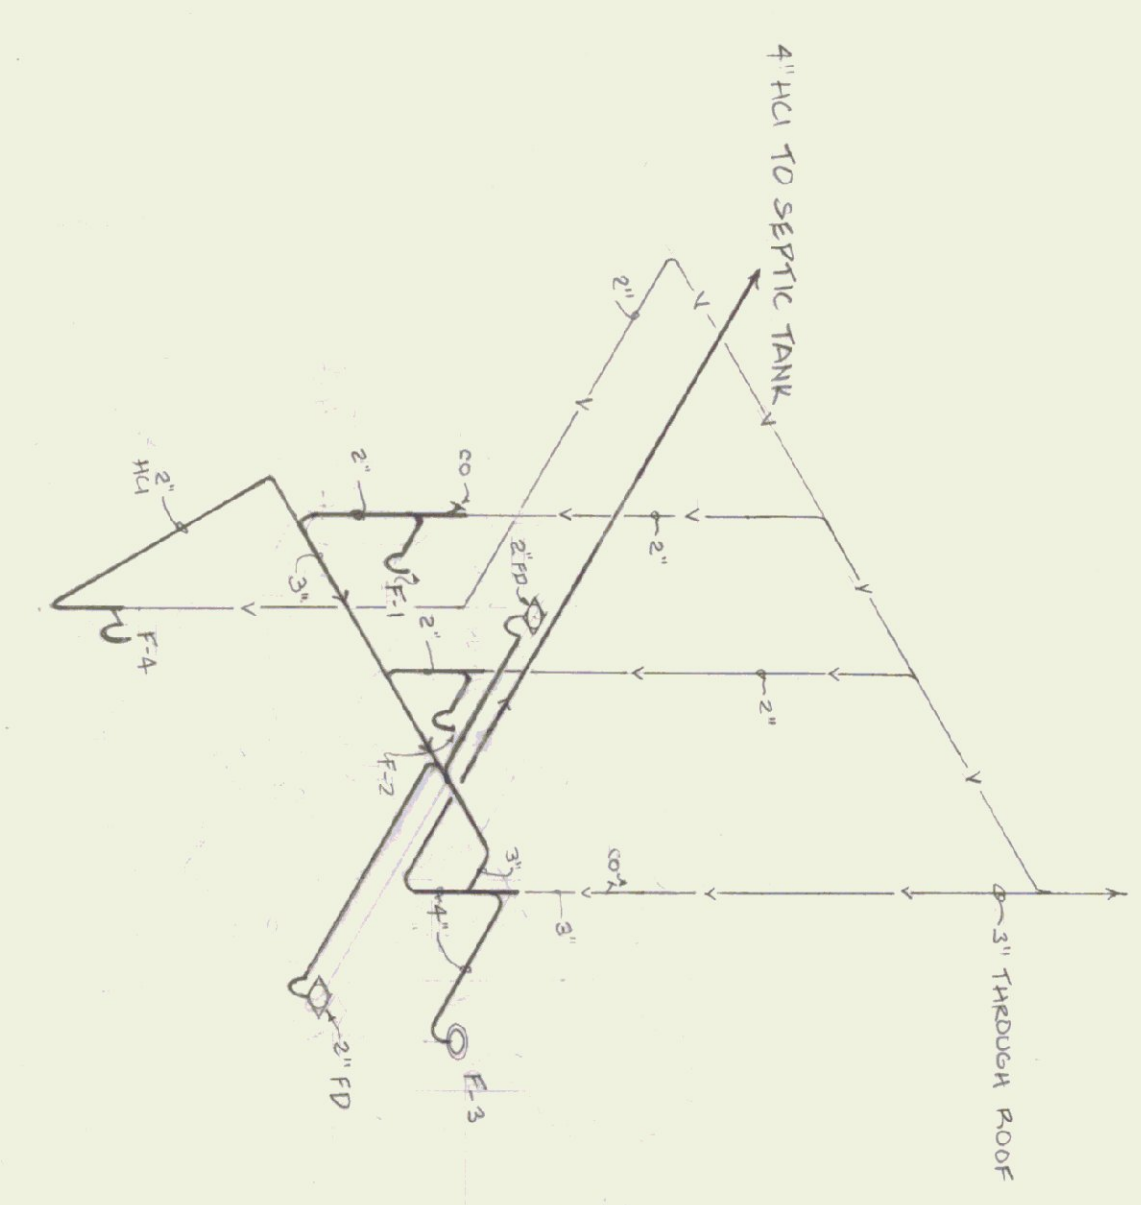

SANITARY WASTE & VENT PIPE RISER DIAGRAM
SCALE: 1/2" = 1'-0"
NOTE: H.C.I. PIPE CONVERTS TO TYPE L COPPER C-B ABOVE FINISHED FLOOR

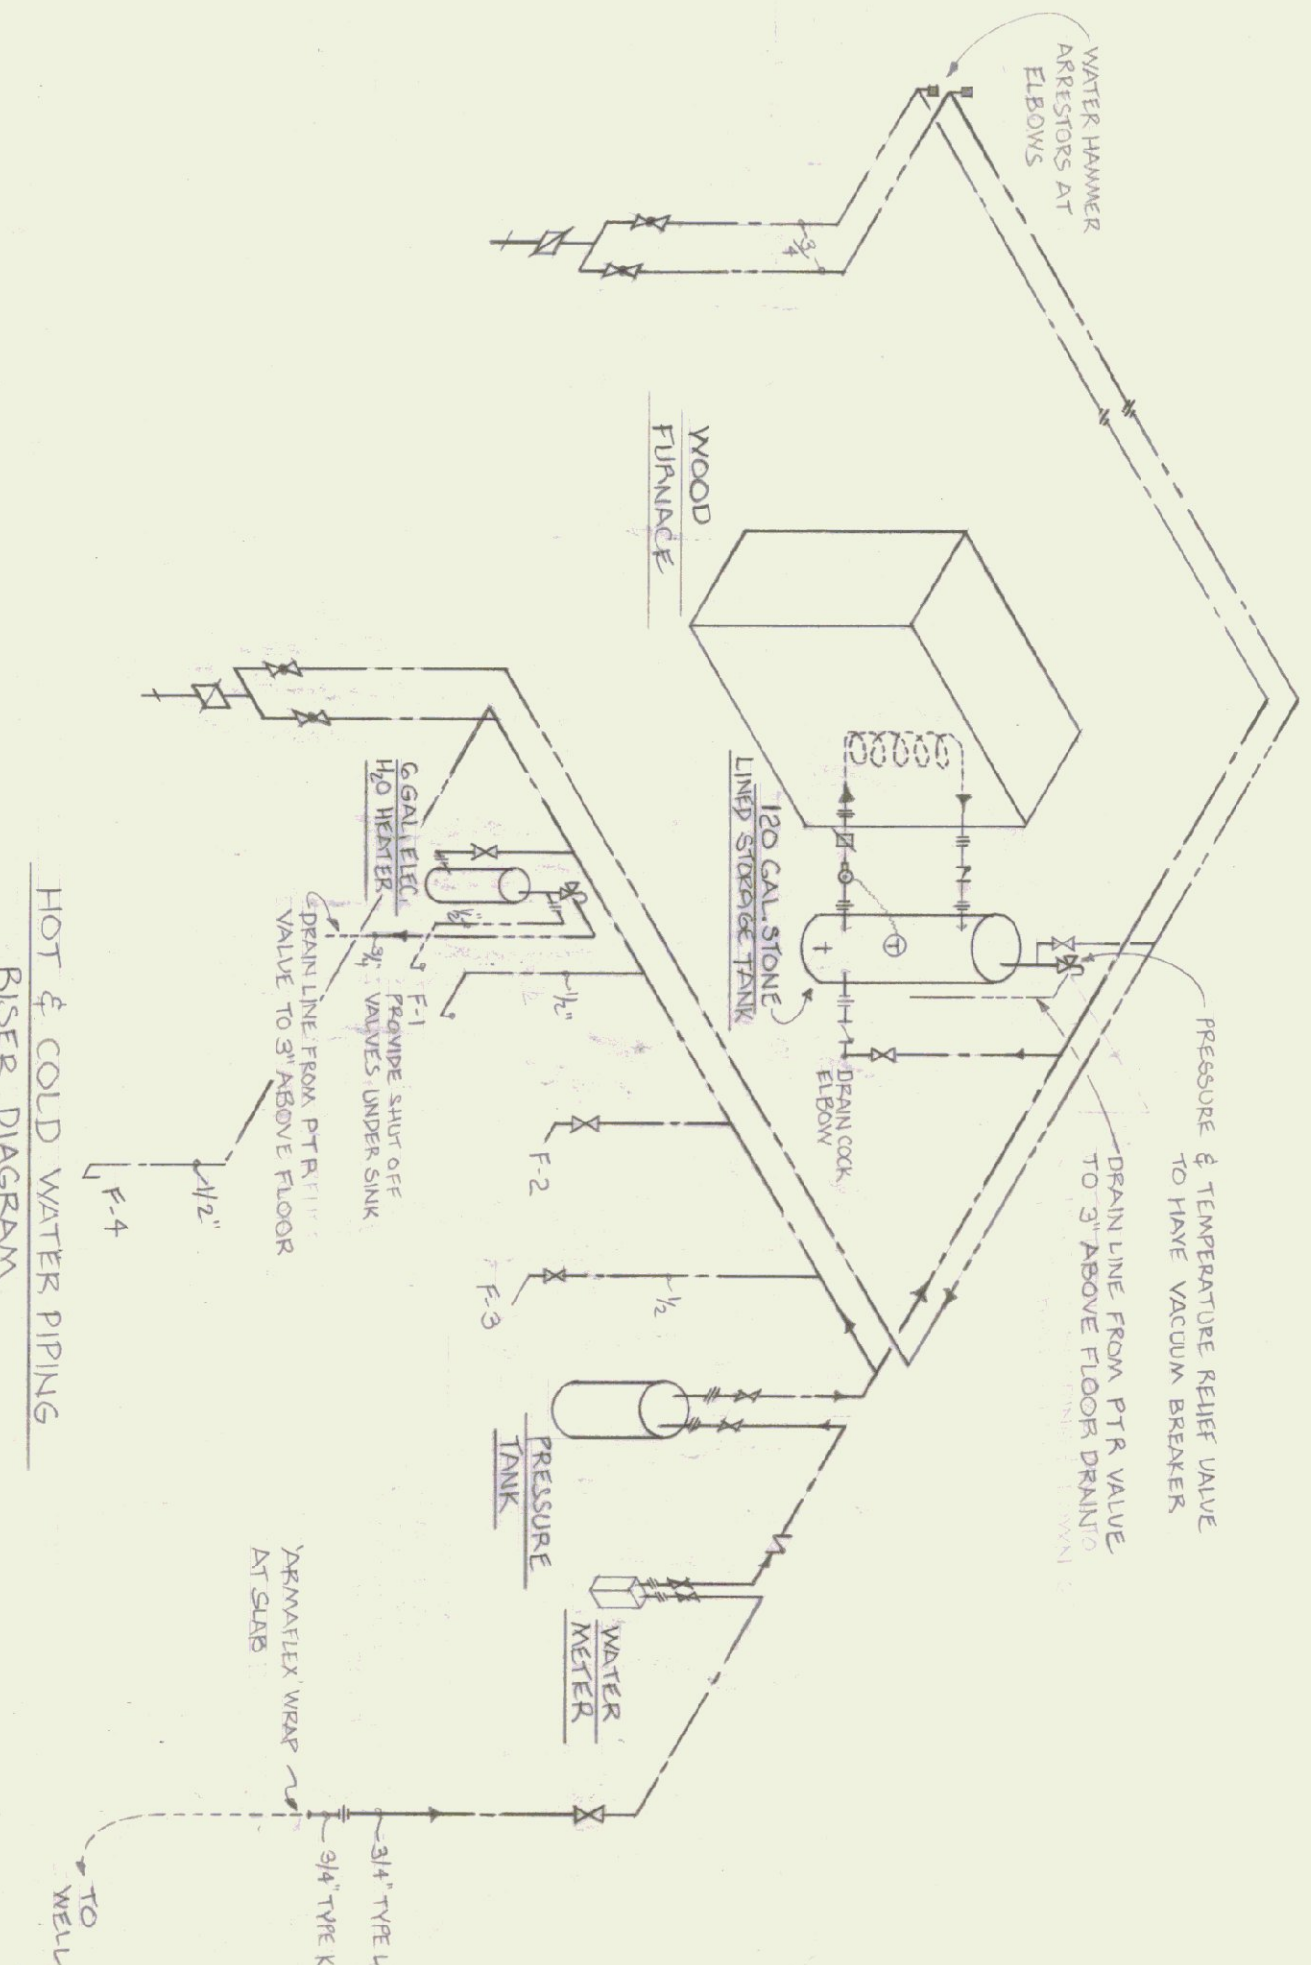

HOT & COLD WATER PIPING RISER DIAGRAM
NOTE TO SCALE: NOTES: 1) ALL WATER LINES ABOVE GRADE TO BE 3/4" TYPE L COPPER EXCEPT FOR 1/2" LINES TO SINK & TOILET 2) 120 GAL. STONE LINED STORAGE TANK TO BE EQUIPPED WITH A VACUUM BREAKER

PLUMBING SYMBOLS FOR PIPING, VALVES, & FITTINGS

—	COLD WATER	□	FLOOR DRAIN WITH "P" TRAP
—	HOT WATER	○	TOILET FLANGE
—	PTR VALVE WATER	—○—	PUMP
—	WASTE PIPING		
—	VENT PIPING		
—	FLOW DIRECTION		
—	GATE VALVE		
—	CHECK VALVE		
—	BACKFLOW PREVENTER		
—	PRESSURE & TEMP RELIEF VALVE		
—	WATER HAMMER ARRESTOR		
—	FLOOR CLEANOUT		
—	CLEANOUT		
—	UNION		
—	HOSE BIBB		
—	"P" TRAP		

STATE OF VERMONT
DIVISION OF STATE BUILDINGS
AGENCY OF ADMINISTRATION
MONTPELIER, VERMONT

AGENCY OF TRANSPORTATION
FIVE BAY GARAGE WITH OFFICE
CAMBRIDGE, VT. DISTRICT 8

PLUMBING SYSTEM PLAN

DATE: 11/7/83	SCALE: AS NOTED	REVISIONS:	DWG. NO. P-1
DRAWN BY: J. Richardson	APPROVED BY: J. Richardson		10 of 11