



ELECTRICAL SITE PLAN
NOT TO SCALE

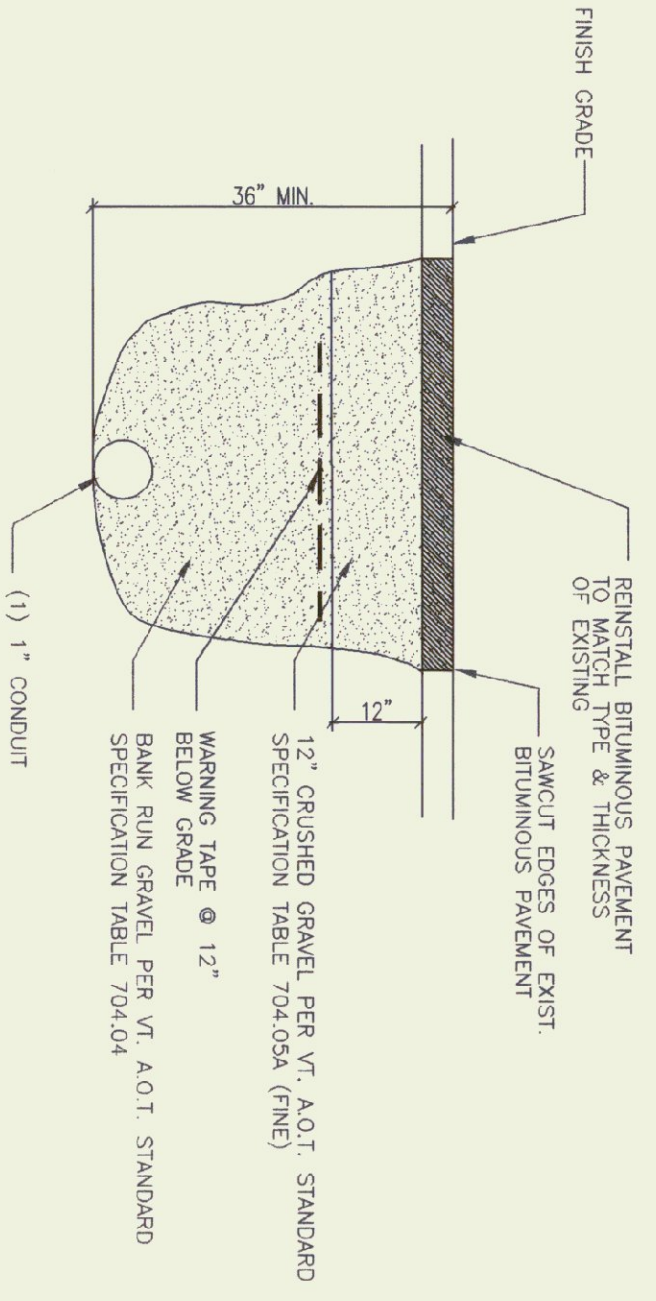

TRENCH DETAIL
NOT TO SCALE

PROPOSED LIGHTING PLAN
SCALE: 1/8" = 1'-0"

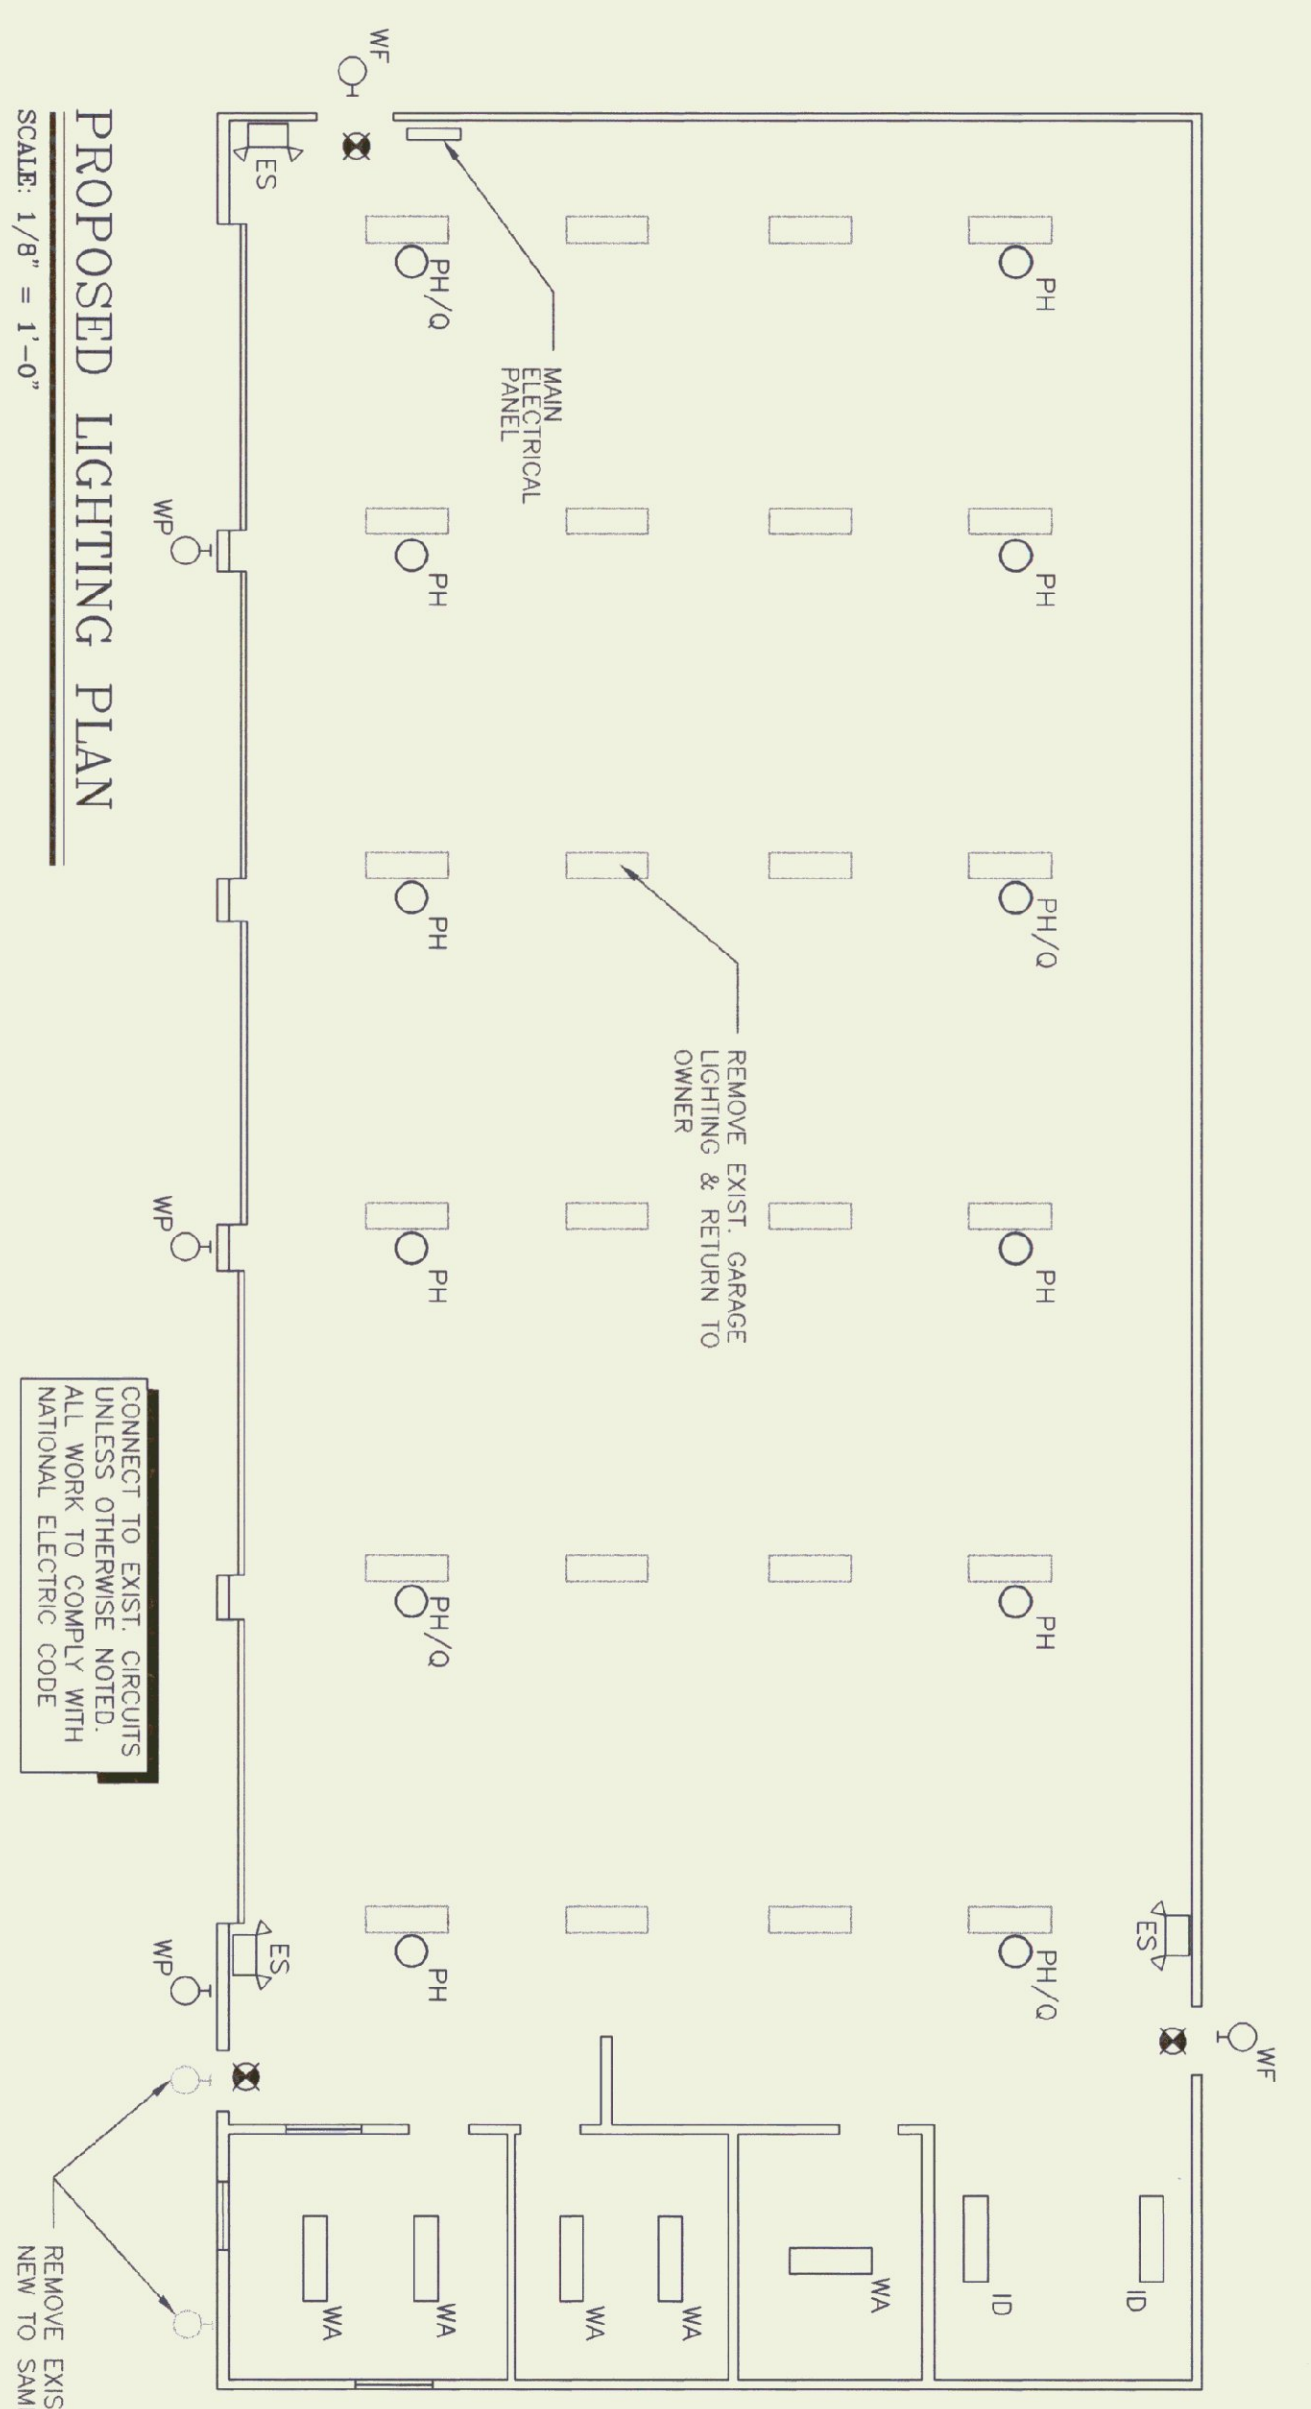


LIGHT FIXTURE SCHEDULE

- PH PENDANT HIGH BAY HID FIXTURE, 150W HPS, SAFETY CHAIN, 150W PAR38 FLOOD LAMP, BRACKET MOUNT ABOVE CEILING, HANGS BOTTOM ABOUT 14\"/>


LIGHT FIXTURE SCHEDULE

- NEW FLUORESCENT LIGHT FIXTURE
- EXIST. LIGHT TO BE REMOVED
- NEW GARAGE HIGH BAY FIXTURE
- EXIT LIGHT
- EMERGENCY LIGHT
- NEW SALT SHED MOTION SENSOR LIGHT

MEZZANINE LIGHTING PLAN
SCALE: 1/8" = 1'-0"

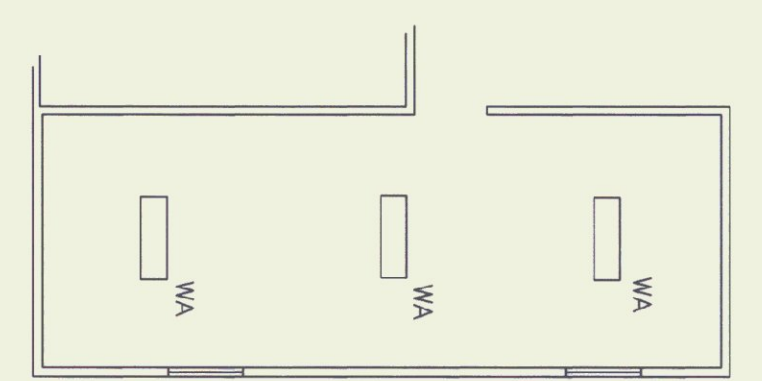

SALT SHED SIDE ELEVATION
SCALE: 1/8" = 1'-0"

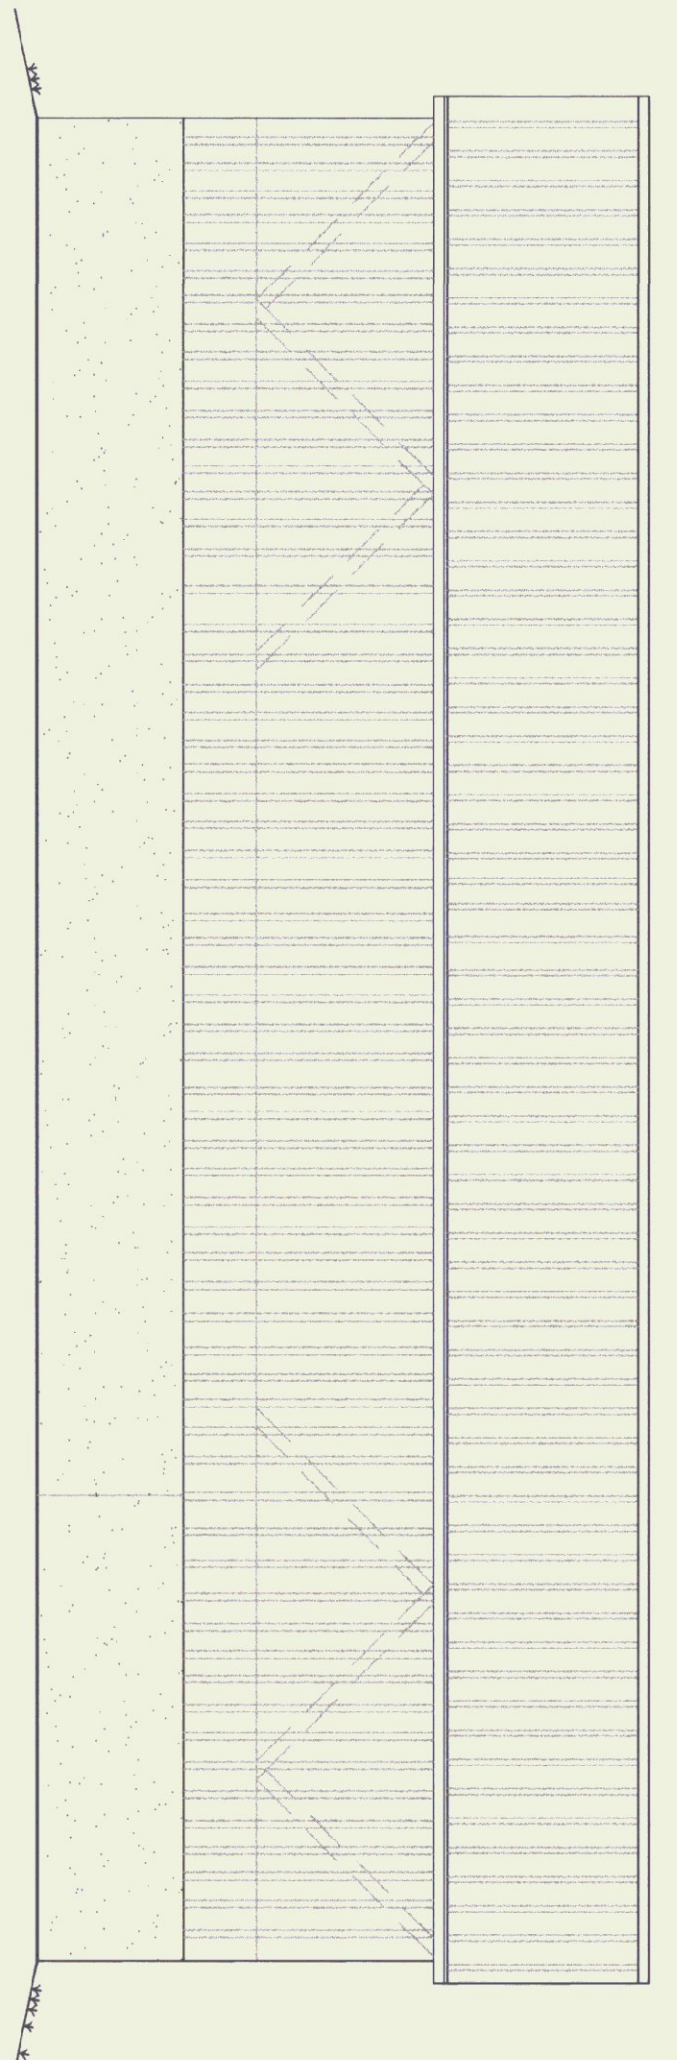

SALT SHED FRONT ELEVATION
SCALE: 1/8" = 1'-0"

