




**HOT & COLD WATER PIPING RISER DIAGRAM**  
NOT TO SCALE

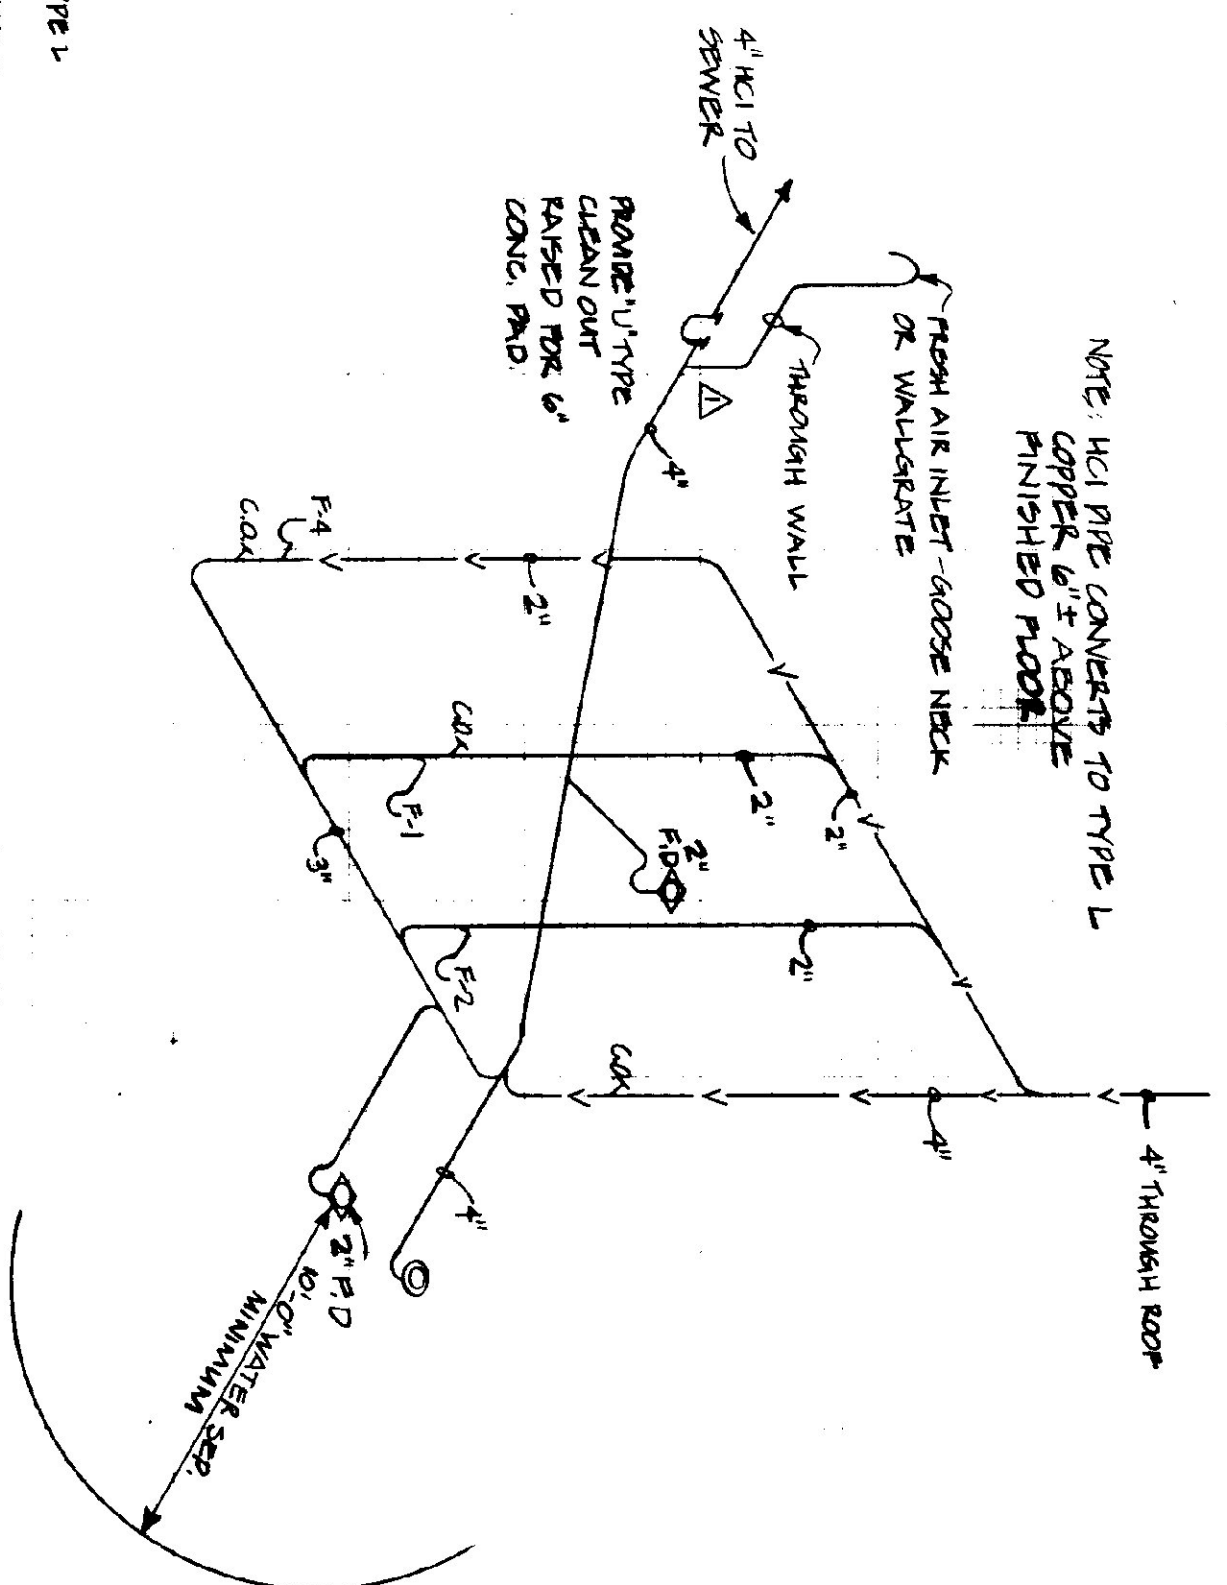

**SANITARY WASTE & VENT PIPE RISER DIAGRAM**  
NOT TO SCALE

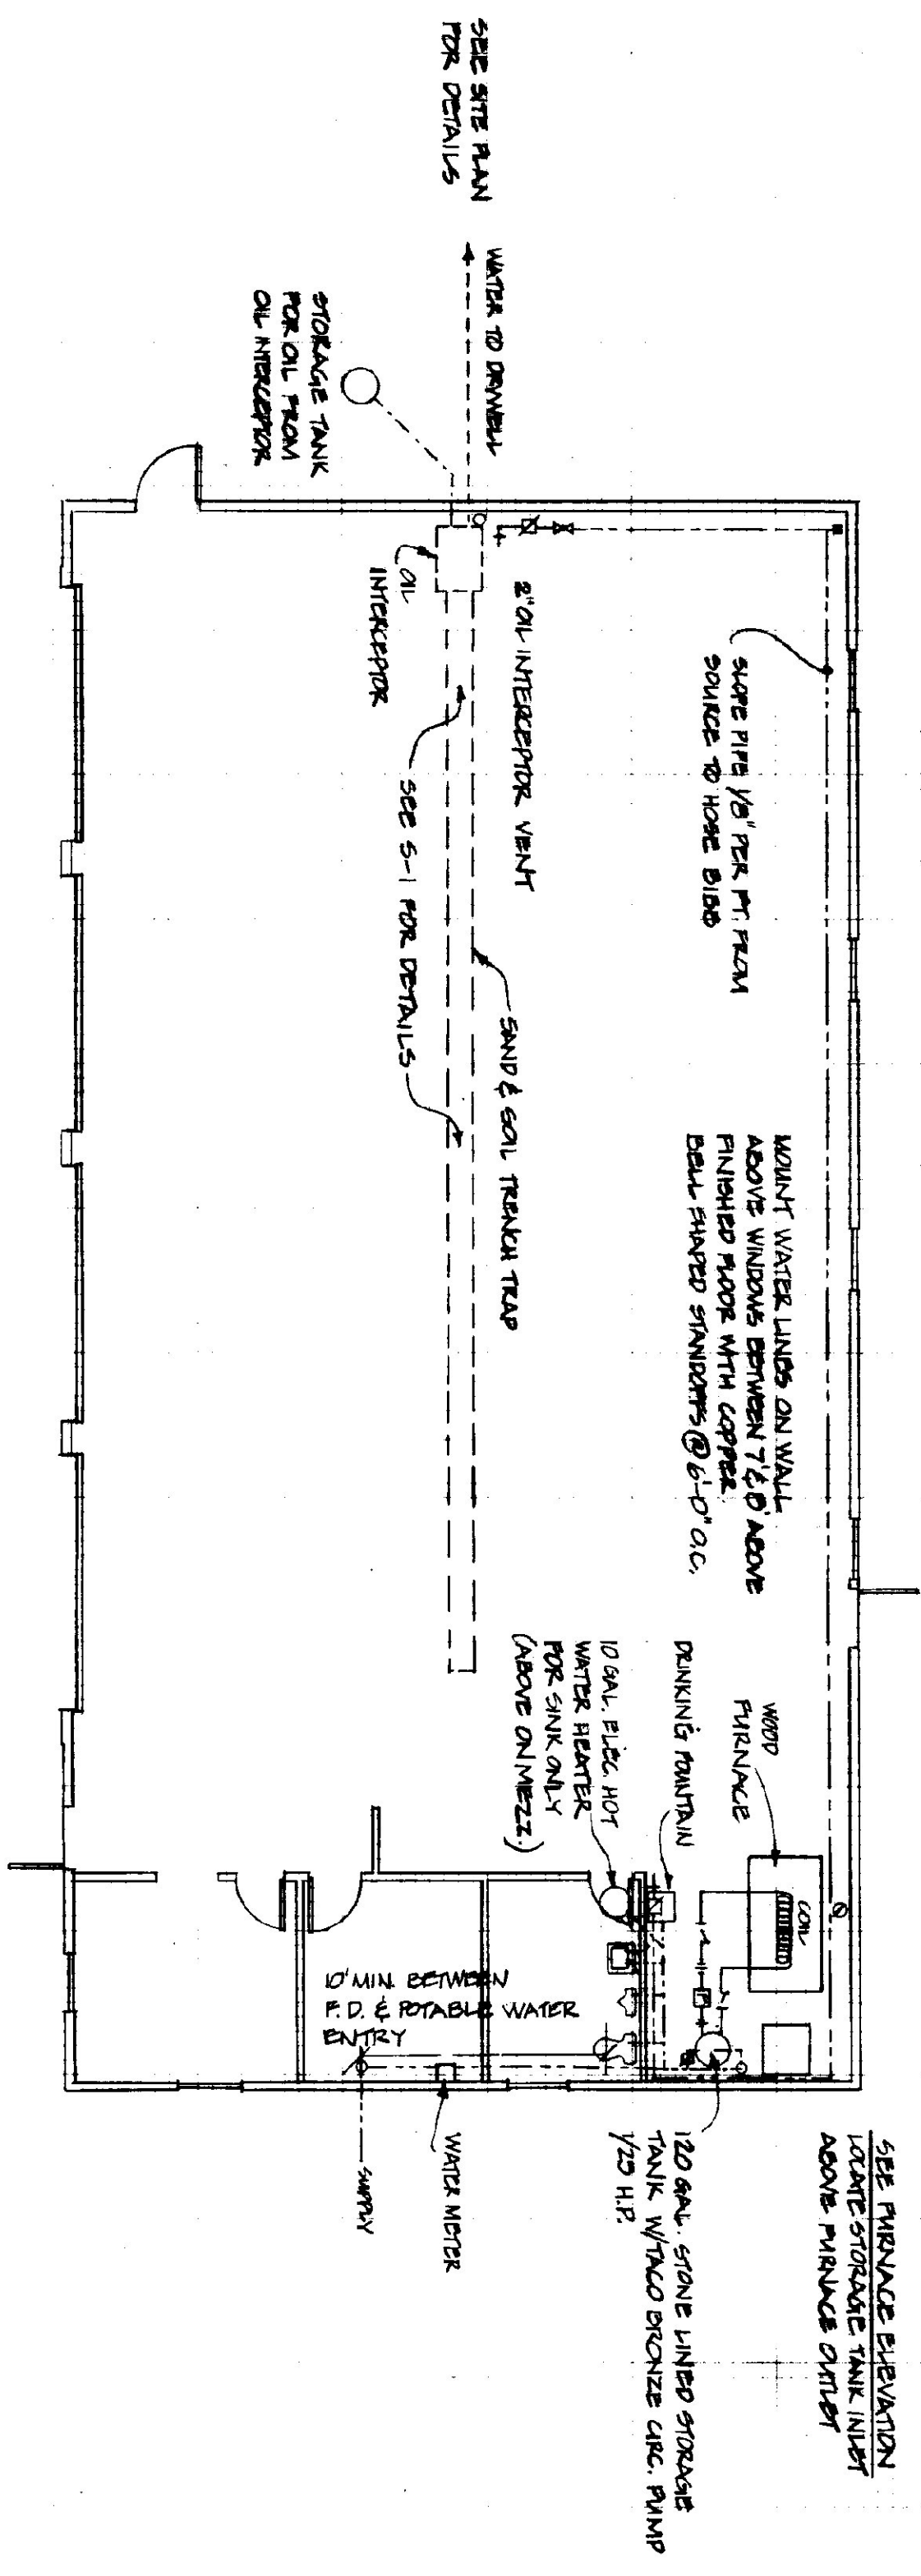

**HOT & COLD WATER PIPING PLAN**  
SCALE 1/8" = 1'-0"

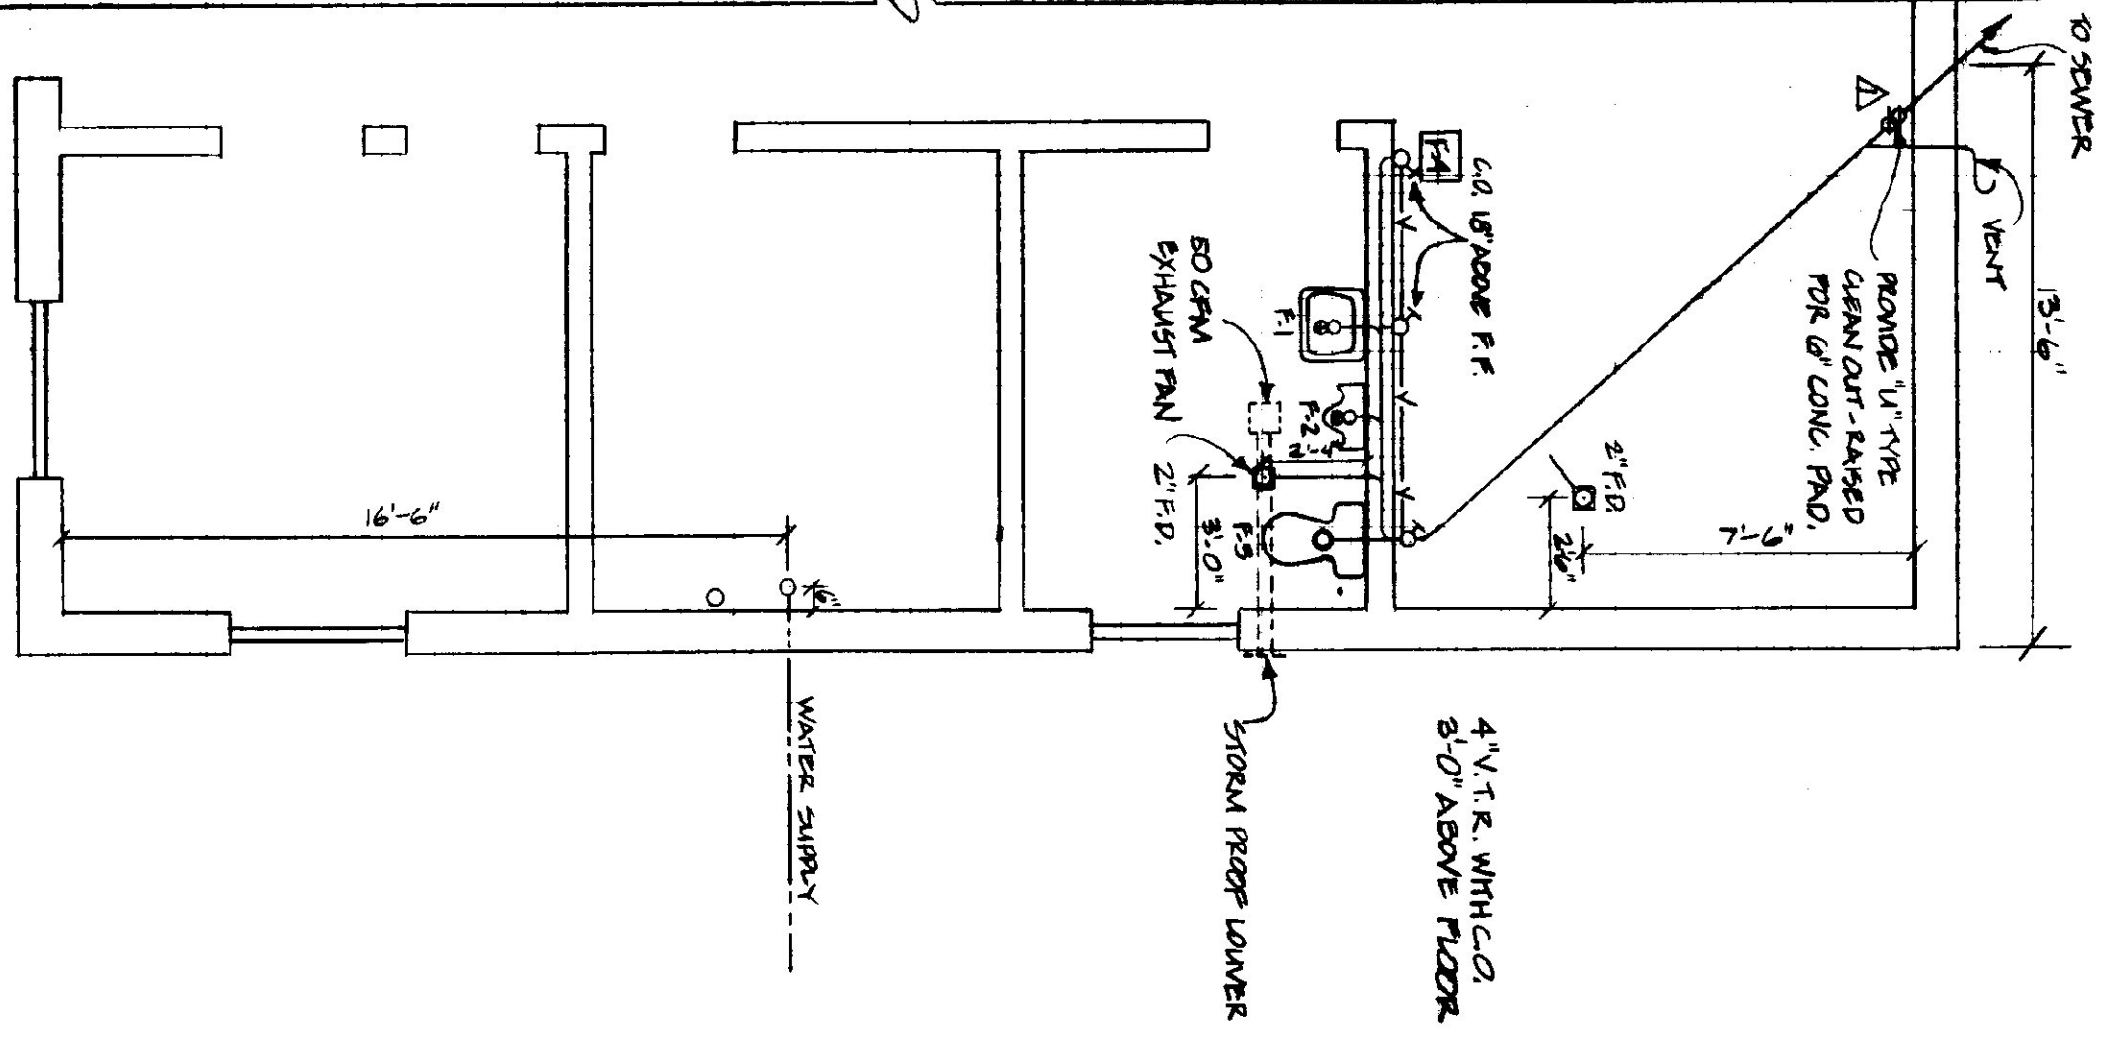


**SANITARY WASTE & VENT PLAN**  
SCALE: 1/4" = 1'-0"

PLUMBING SYMBOLS FOR PIPING, VALVES & FITTINGS	
	COLD WATER
	HOT WATER
	PTR VALVE WATER 100%/100
	WASTE PIPING
	VENT PIPING
	GATE VALVE
	CHECK VALVE
	BACKFLOW PREVENTER
	PRESSURE & TEMP. RELIEF VALVE
	WATER HAMMER ARRESTOR
	FLOOR CLEANOUT
	UNION
	HOSE BIBB
	P-TRAP
	FLOOR DRAIN WITH P-TRAP
	TOILET FLANGE
	BUILDING TRAP

**FIXTURE SCHEDULE**

- F-1 WALL MOUNTED CERAMIC LAVATORY.
- F-2 WALL MOUNTED URINAL WITH VACUUM BREAKER ON FLUSH VALVE.
- F-3 FLOOR MOUNTED CERAMIC TOILET FIXTURE WITH EXHHAUST FRONT (W/HIGH)
- F-4 WALL MOUNTED DRINKING FOUNTAIN

△ HOSE TRAP - REVISION 4/22/04 AVP

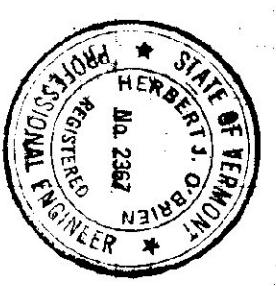

STATE OF VERMONT DIVISION OF STATE BUILDINGS AGENCY OF ADMINISTRATION MONTPELIER, VERMONT		AGENCY OF TRANSPORTATION MAINTENANCE GARAGE EPPEN, VERMONT	
<b>PLUMBING PLAN</b>			
DATE: JULY 25, 1984	SCALE: AS NOTED	REVISIONS:	DWG. NO. P-1
DRAWN BY: A. PALMIN	APPROVED BY: [Signature]		12 OF 13