

STATE OF VERMONT
 AGENCY OF TRANSPORTATION

FOUR BAY MAINTENANCE GARAGE

EDEN, VERMONT

JULY 1984

AGENCY OF ADMINISTRATION
 DEPARTMENT OF STATE BUILDINGS
 MONTPELIER, VERMONT
 IRVING A. BATES, COMMISSIONER

AGENCY OF TRANSPORTATION
 MONTPELIER, VERMONT
 PATRICK J. GARAHAN, SECRETARY








 







INDEX OF DRAWINGS


- SD-1 SITE PLAN
- A-1 GROUND FLOOR PLAN
- A-2 GARAGE ELEVATIONS
- A-3 INTERIOR ELEVATIONS AND SECTIONS
- A-4 WALL PLANS AND SECTIONS
- A-5 WALL DETAILS
- A-6 EXTERIOR DOORS, WINDOWS AND STAIR DETAILS
- S-1 FOOTINGS AND WALL PLAN SECTIONS AND DETAILS
- S-2 GRADE FLOOR SLAB AND FOUNDATION DETAILS
- S-3 ROOF FRAMING
- S-4 STRUCTURAL DETAILS - FOUNDATION AND ROOF FRAME
- P-1 PLUMBING PLAN
- M&E1 MECHANICAL AND ELECTRICAL

ABBREVIATIONS

F.F.	FINISHED FLOOR	V & H.	VERTICLE & HORIZONTAL
F.O.F.	FACE OF FOUNDATION	O.C.	ON CENTER
F.O.S.	FACE OF STUDS	A.B.	ANCHOR BOLT
T.O.F.	TOP OF FOOTING	N.I.C.	NOT IN CONTRACT
H.C.I.	HUBLESS CAST IRON	R.O.	ROUGH OPENING


KEY

	EARTH
	SAND
	CONCRETE
	GRAVEL
	METAL ROOF DECK INSULATION
	FIBERGLASS INSULATION
	CONTINUOUS STRUCTURAL WOOD
	DISCONTINUOUS WOOD BLOCKING
	WOOD FACE GRAIN
	WOOD END GRAIN
	OSB (ORIENTED STRAND BOARD) INTERIOR SHEATHING
	STEEL
	CONCRETE BLOCK IN PLAN
	CONCRETE BLOCK IN SECTION
	BITUMINOUS PAVING

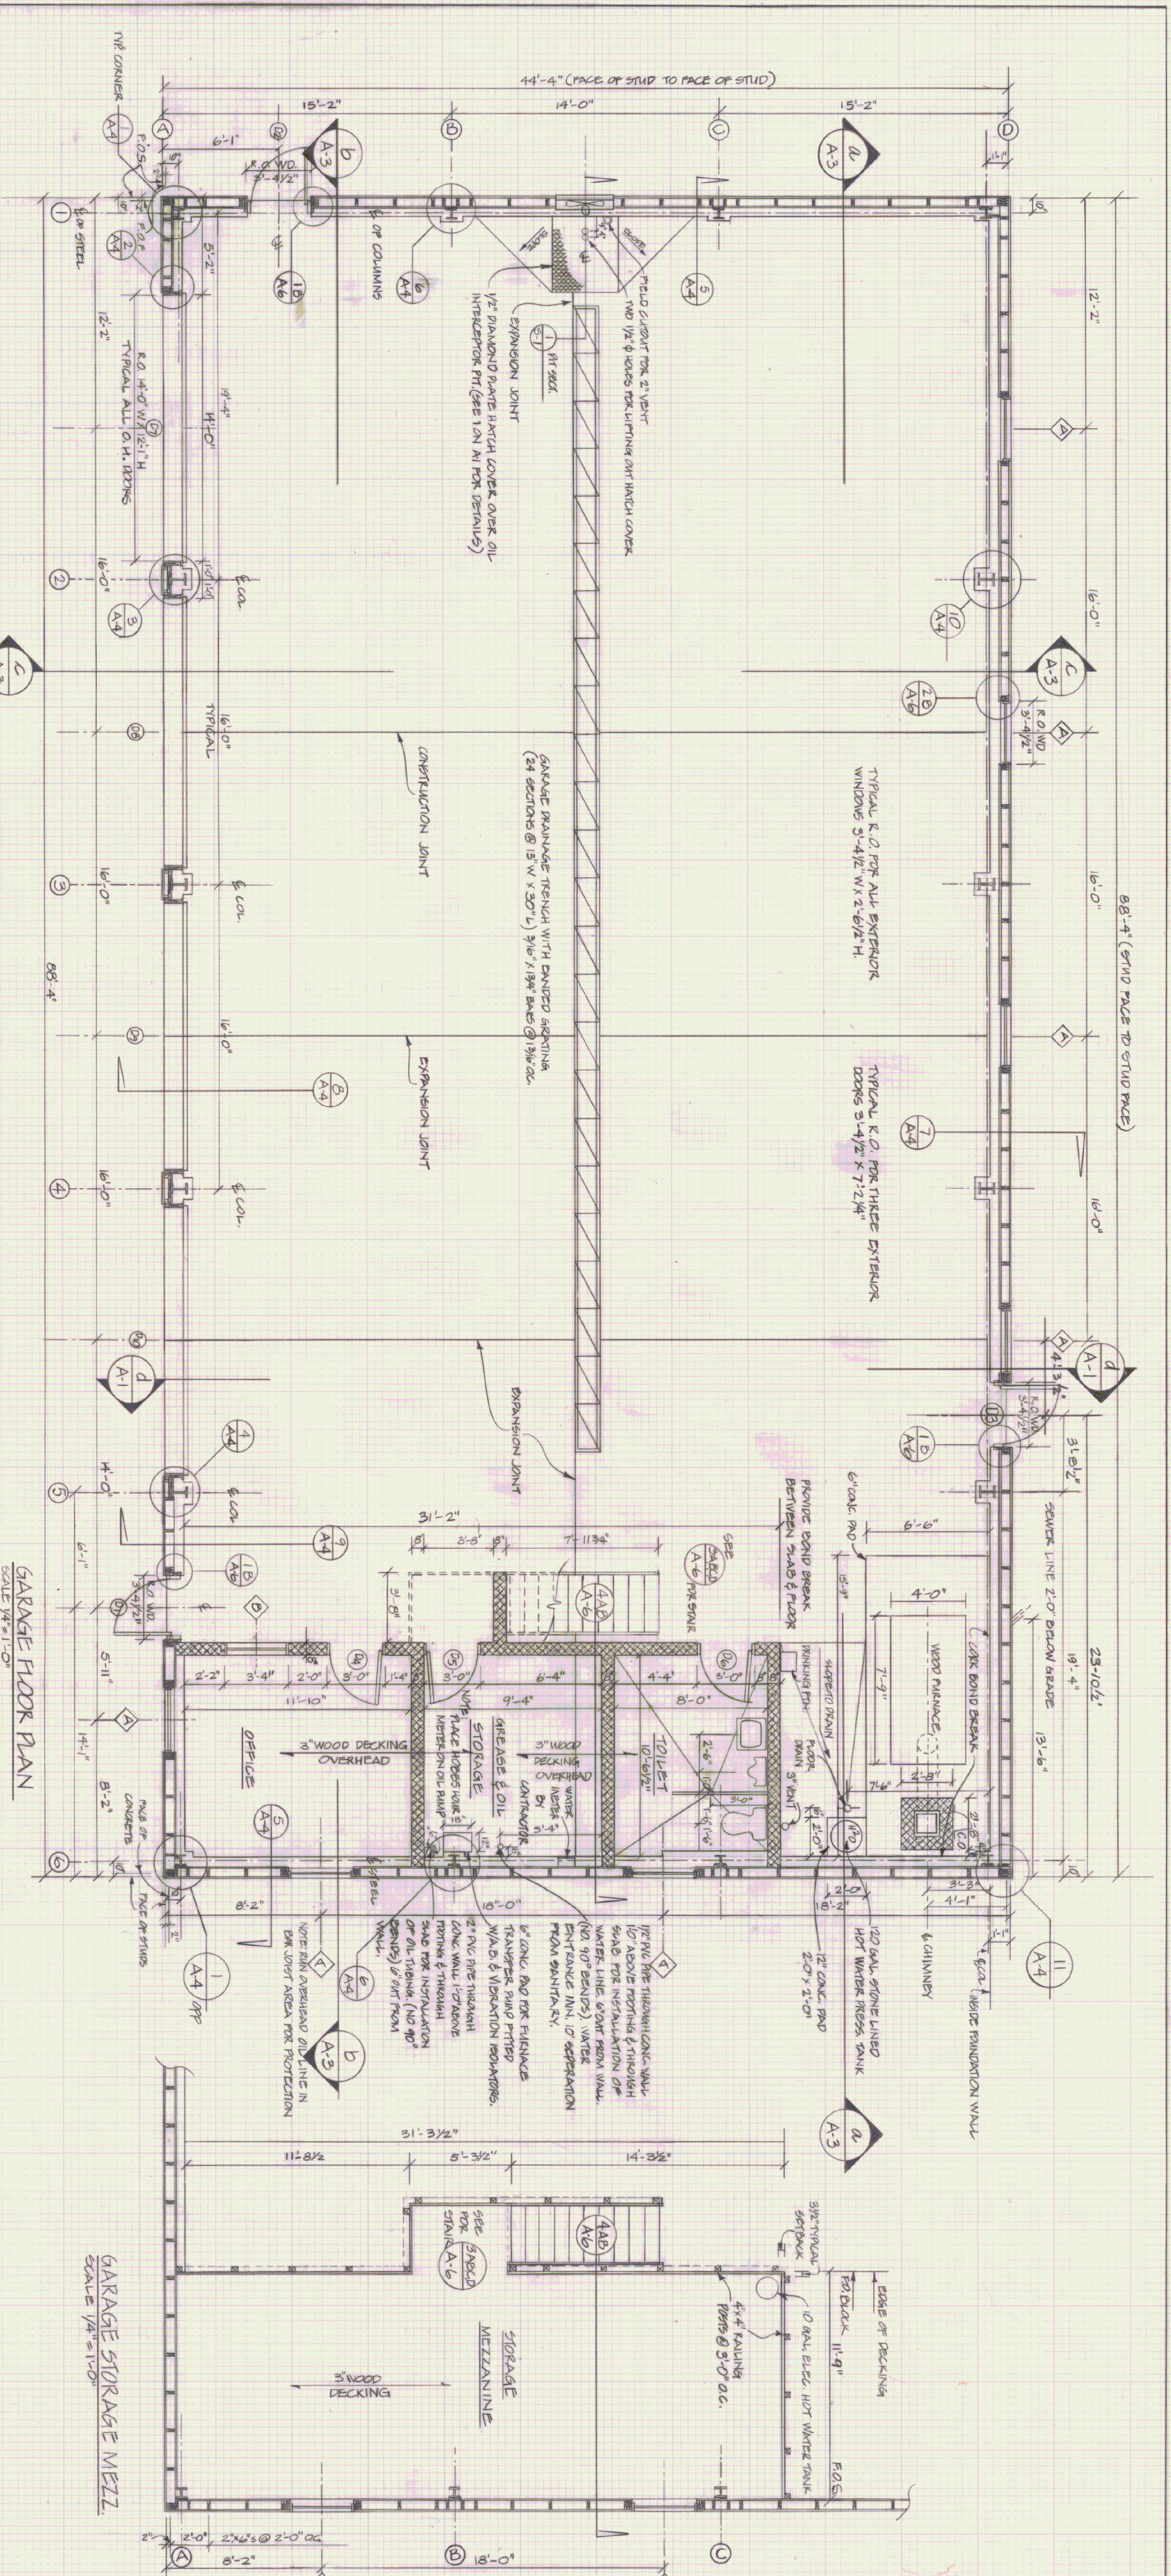

GARAGE FLOOR PLAN
SCALE 1/8" = 1'-0"


GARAGE STORAGE MEZZ.
SCALE 1/8" = 1'-0"

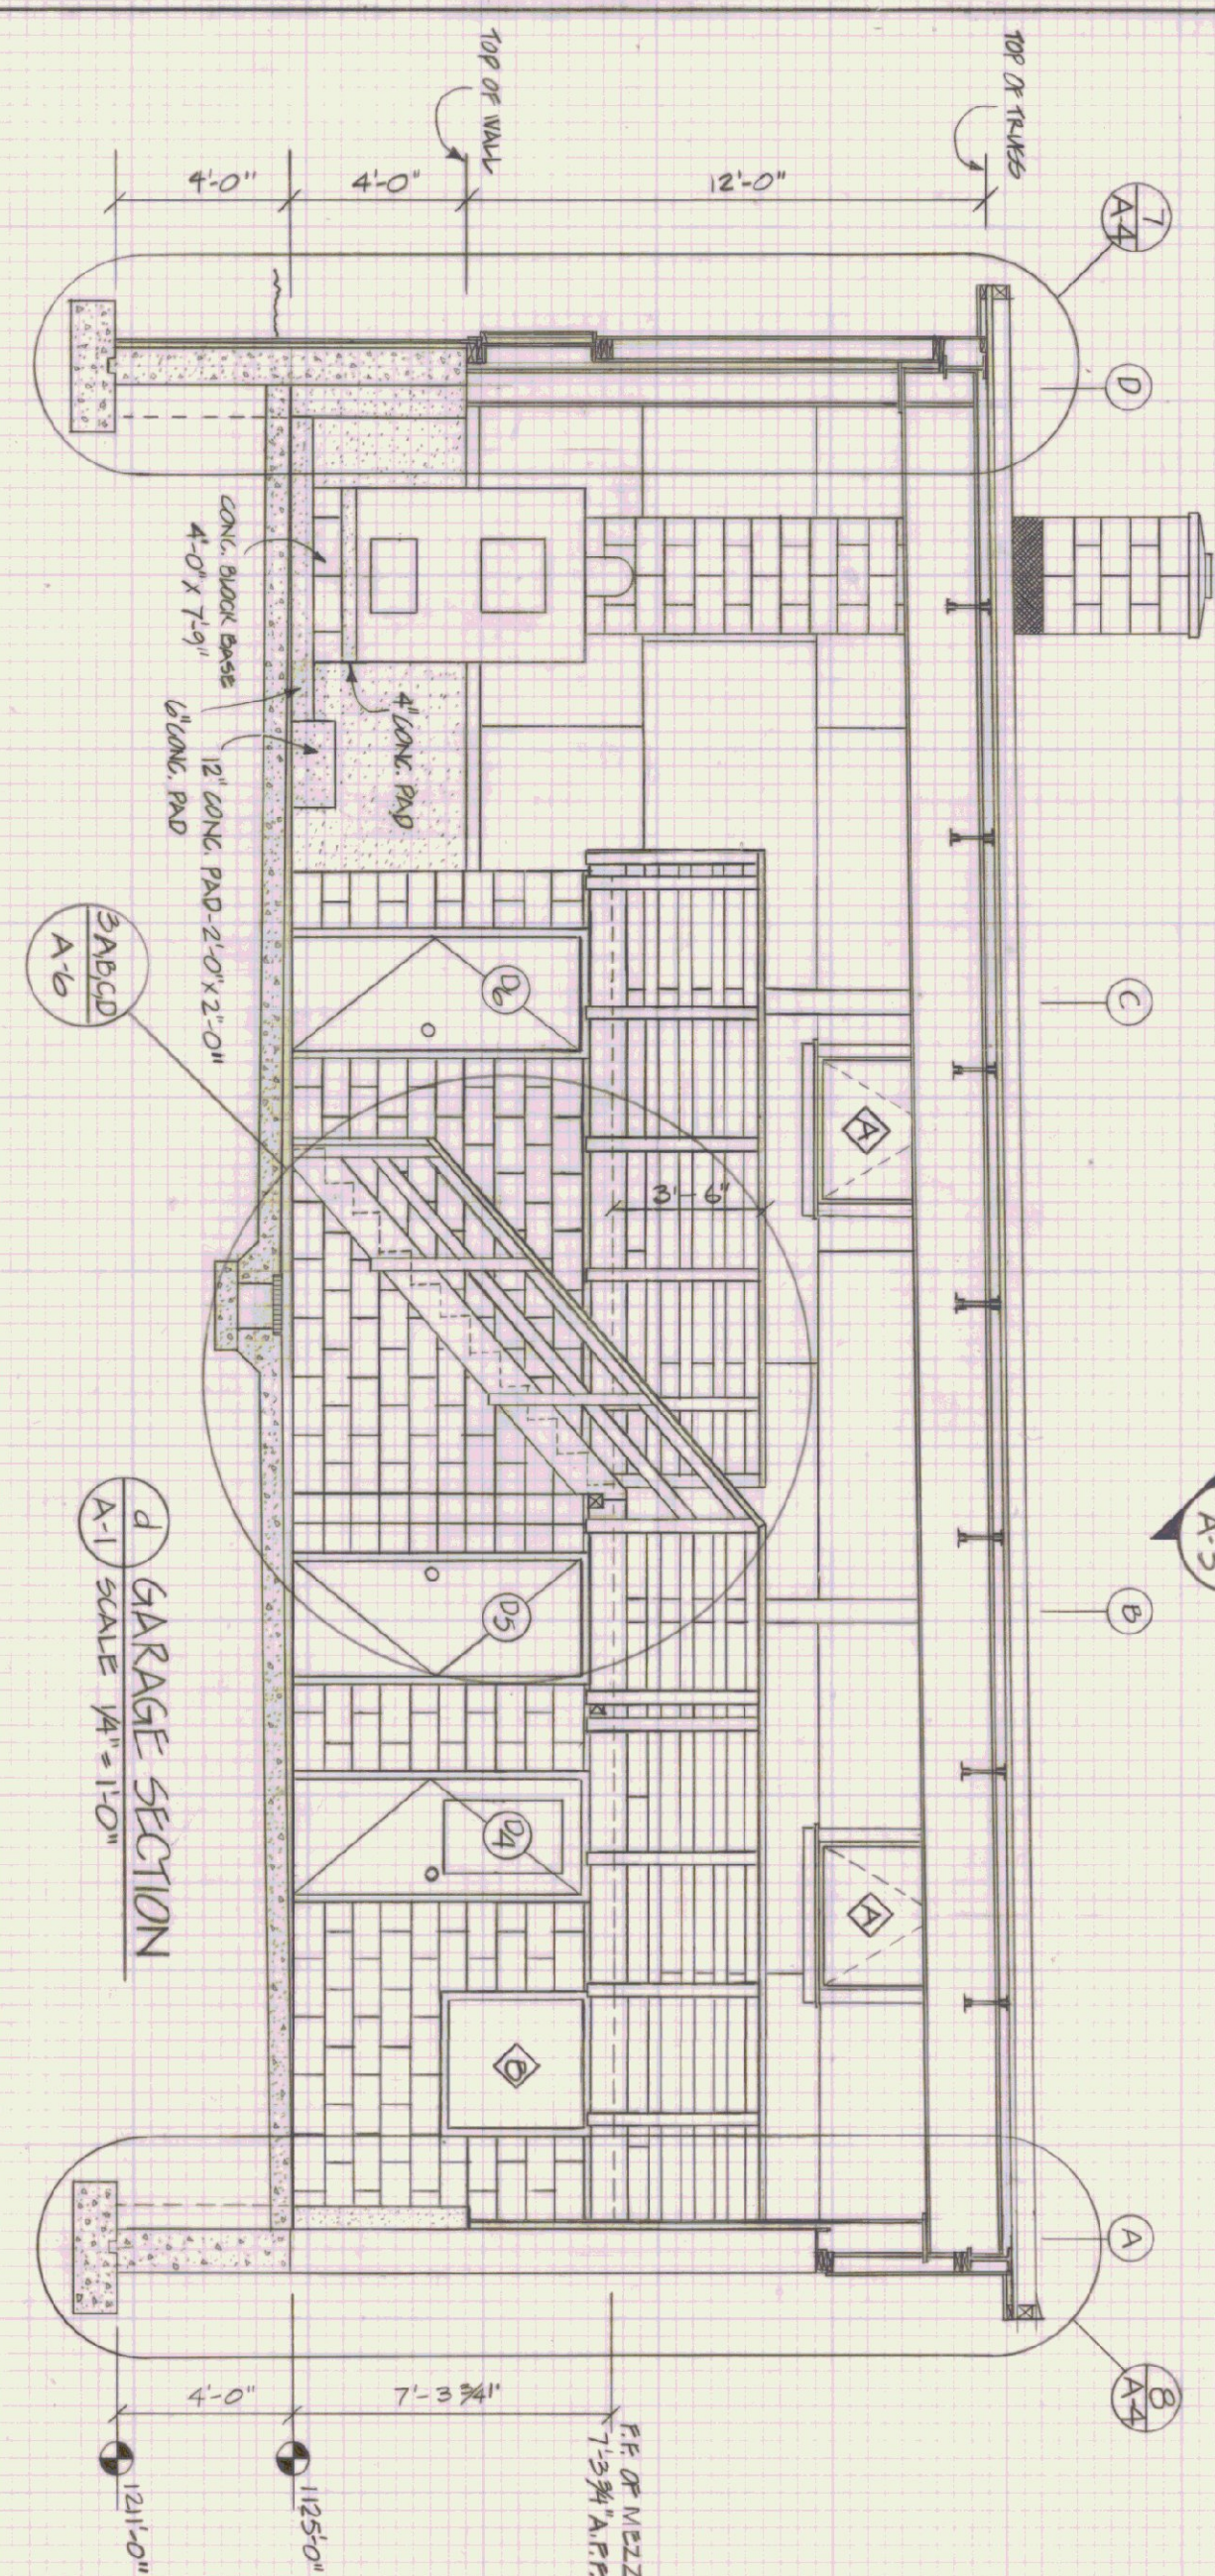

GARAGE SECTION
SCALE 1/4" = 1'-0"

WINDOW SCHEDULE										
NO.	QUANTITY	TYPE	FRAME MATERIAL	ROUGH OPENING	REMARKS	NO.	QUANTITY	TYPE	FRAME MATERIAL	REMARKS
D1	1	3'-0" x 7'-0"	C	1	ALUMINUM	D1-D10	4	4'-0" W x 12'-0" H	C	WOOD CHANNEL
D2	1	3'-0" x 7'-0"	C	1	ALUMINUM					
D3	1	3'-0" x 7'-0"	C	1	ALUMINUM					
D4	1	2'-8" x 6'-8"	C	2	ALUMINUM					
D5	1	3'-0" x 7'-0"	C	1	ALUMINUM					
D6	1	3'-0" x 7'-0"	C	1	ALUMINUM					
D7	1	3'-0" x 7'-0"	C	1	ALUMINUM					
D8	1	3'-0" x 7'-0"	C	1	ALUMINUM					
D9	1	3'-0" x 7'-0"	C	1	ALUMINUM					
D10	1	3'-0" x 7'-0"	C	1	ALUMINUM					

WINDOW SCHEDULE				
NO.	QUANTITY	TYPE	FRAME MATERIAL	REMARKS
1	9	FIXED METAL	3'-4 1/2" W x 2'-6 1/2" H	ALUMINUM BUILT COMPONENTS 4000 SERIES - #2024 C
2	1	FIXED METAL	3'-4" W x 3'-4" H	HOLLOW METAL SPEC 08100

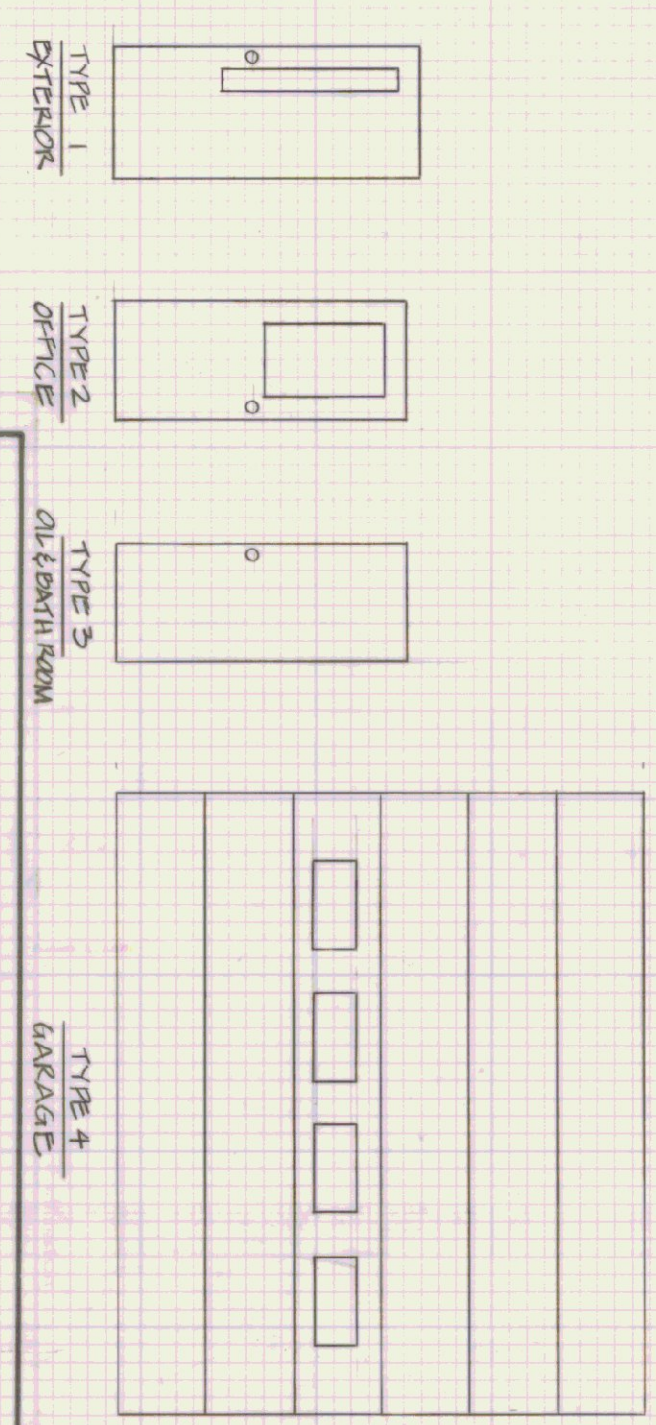

STATE OF VERMONT
DIVISION OF STATE BUILDINGS
AGENCY OF ADMINISTRATION
MONTPELIER, VERMONT



AGENCY OF TRANSPORTATION
MAINTENANCE GARAGE
EDEN, VERMONT

GROUND FLOOR PLAN

DATE: JULY 21, 1984
DRAWN BY: A. PAULIN
APPROVED BY: R. F. OSB

SCALE: AS NOTED
REVISIONS:

DWG. NO. A-1
2 OF 13

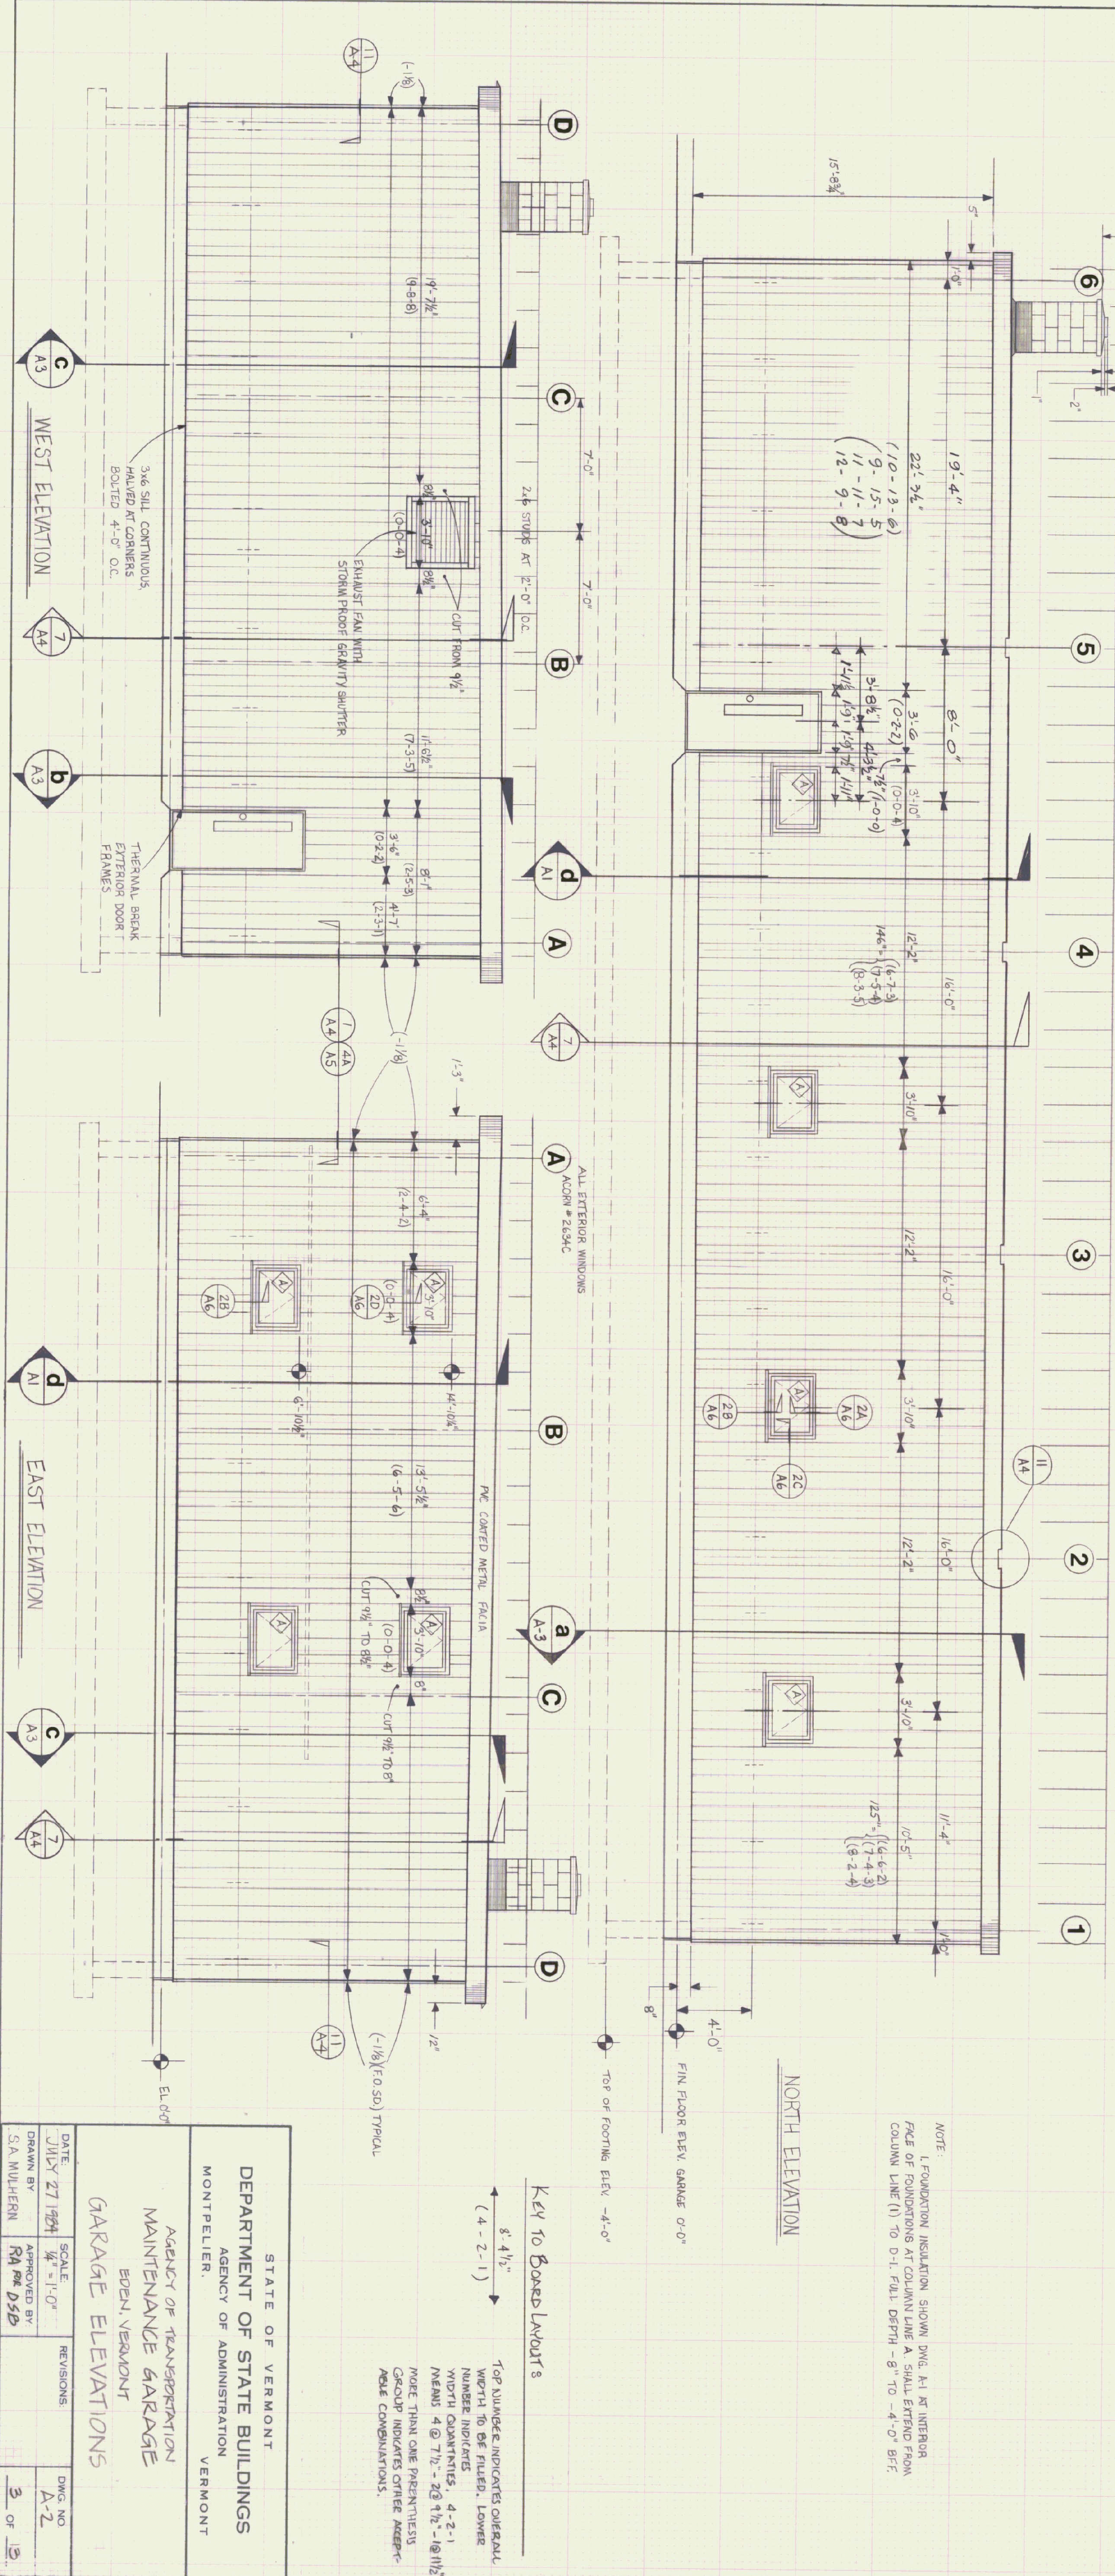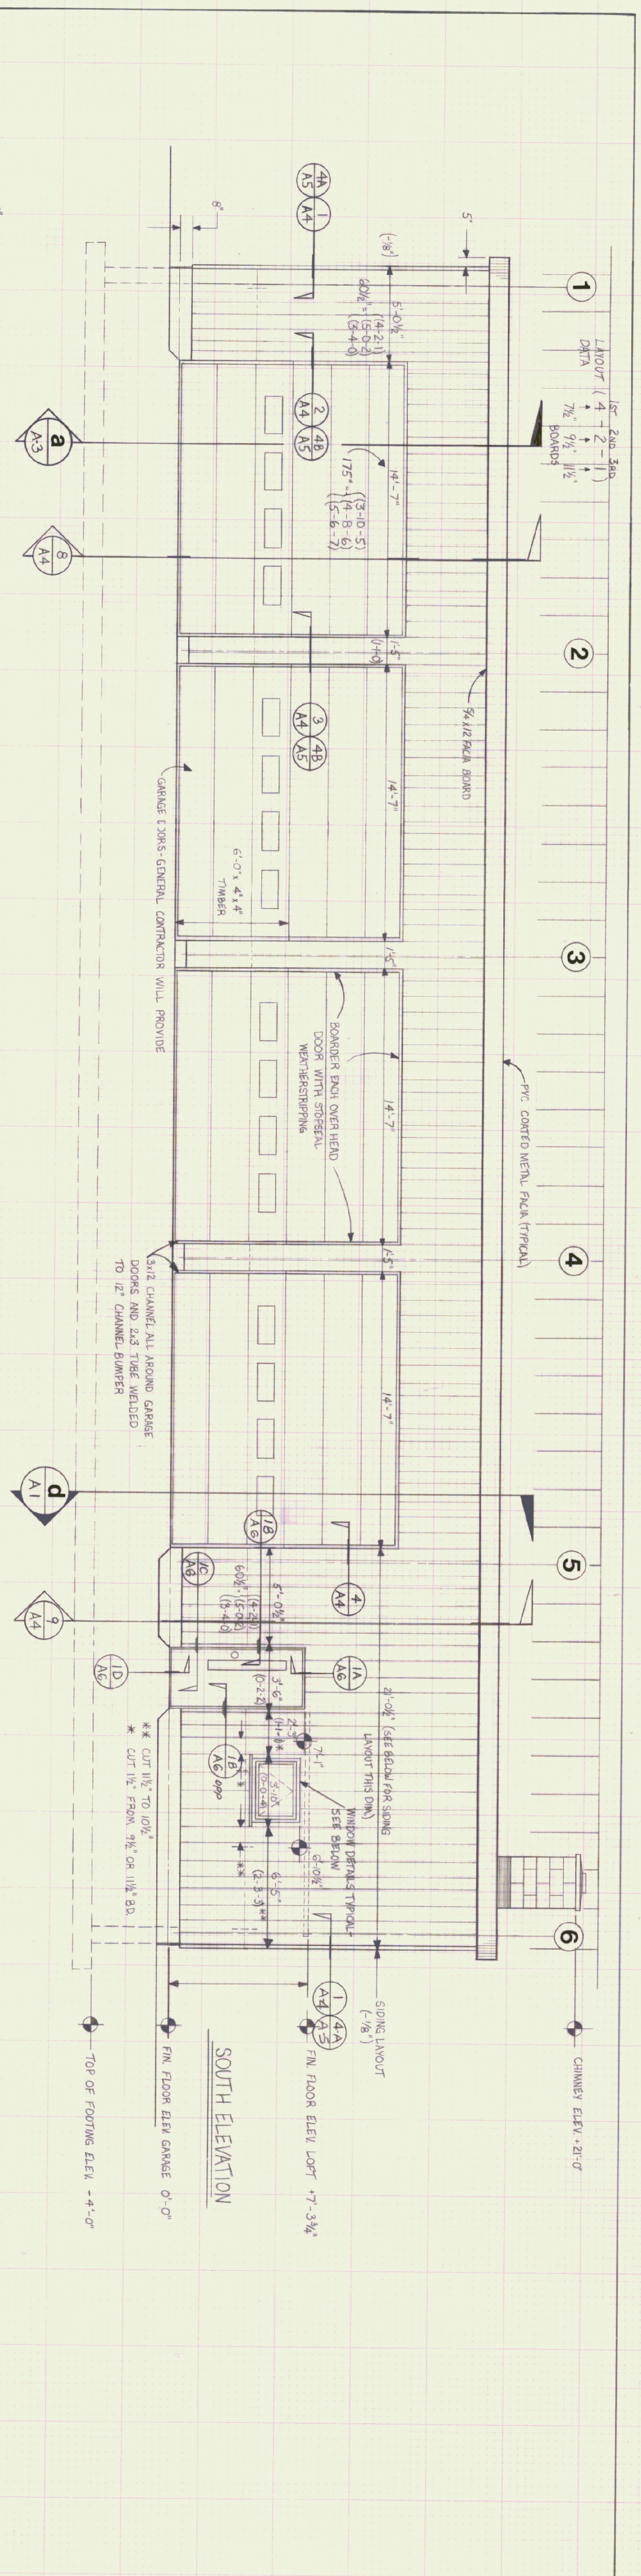


NOTE:
 1. FOUNDATION INSULATION SHOWN DIM. IS AT INTERIOR
 FACE OF FOUNDATIONS AT COLUMN LINE A SHALL EXTEND FROM
 COLUMN LINE (1) TO D-1. FULL DEPTH - 8" TO -4'-0" B.F.


Key to Bored Layouts
 (4 - 2 - 1)

TOP NUMBER INDICATES OVERALL
 WIDTH TO BE FILLED. LOWER
 NUMBER INDICATES
 WIDTH COARCTURES. 4-2-1
 MEANS 4 @ 7 1/2" - 2 @ 1 1/2" - 1 @ 1 1/2"
 MORE THAN ONE PARENTHESIS
 GROUP INDICATES OTHER AREAS
 ARE COMPARATIVES.


STATE OF VERMONT		DWG. NO.	
DEPARTMENT OF STATE BUILDINGS		A-2	
AGENCY OF ADMINISTRATION		3 OF 13	
MONTPELIER, VERMONT			
AGENCY OF TRANSPORTATION			
MAINTENANCE GARAGE			
OPEN VERMONT			
GARAGE ELEVATIONS			
DATE	SCALE	REVISIONS	DWG. NO.
JUL 27 1994	1/4" = 1'-0"		A-2
DRAWN BY	APPROVED BY		
S.A. MULHERN	RA P. DSB		

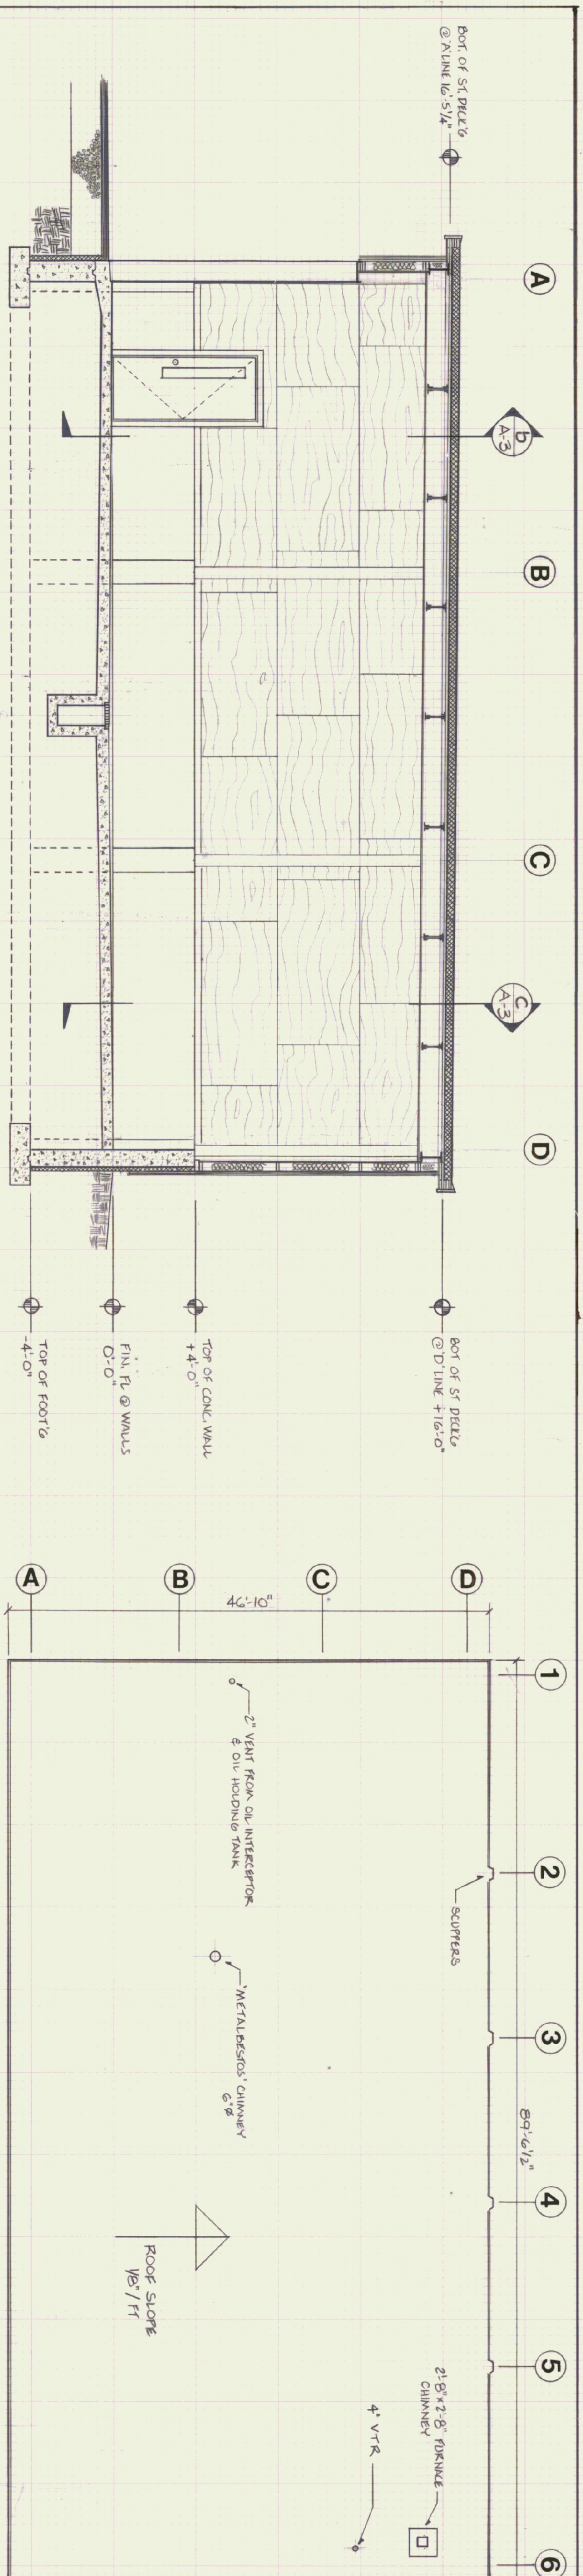


INTERIOR ELEVATION / SECTION (LOOKING TOWARDS #1 COL. LINE)
SCALE 1/4" = 1'-0"

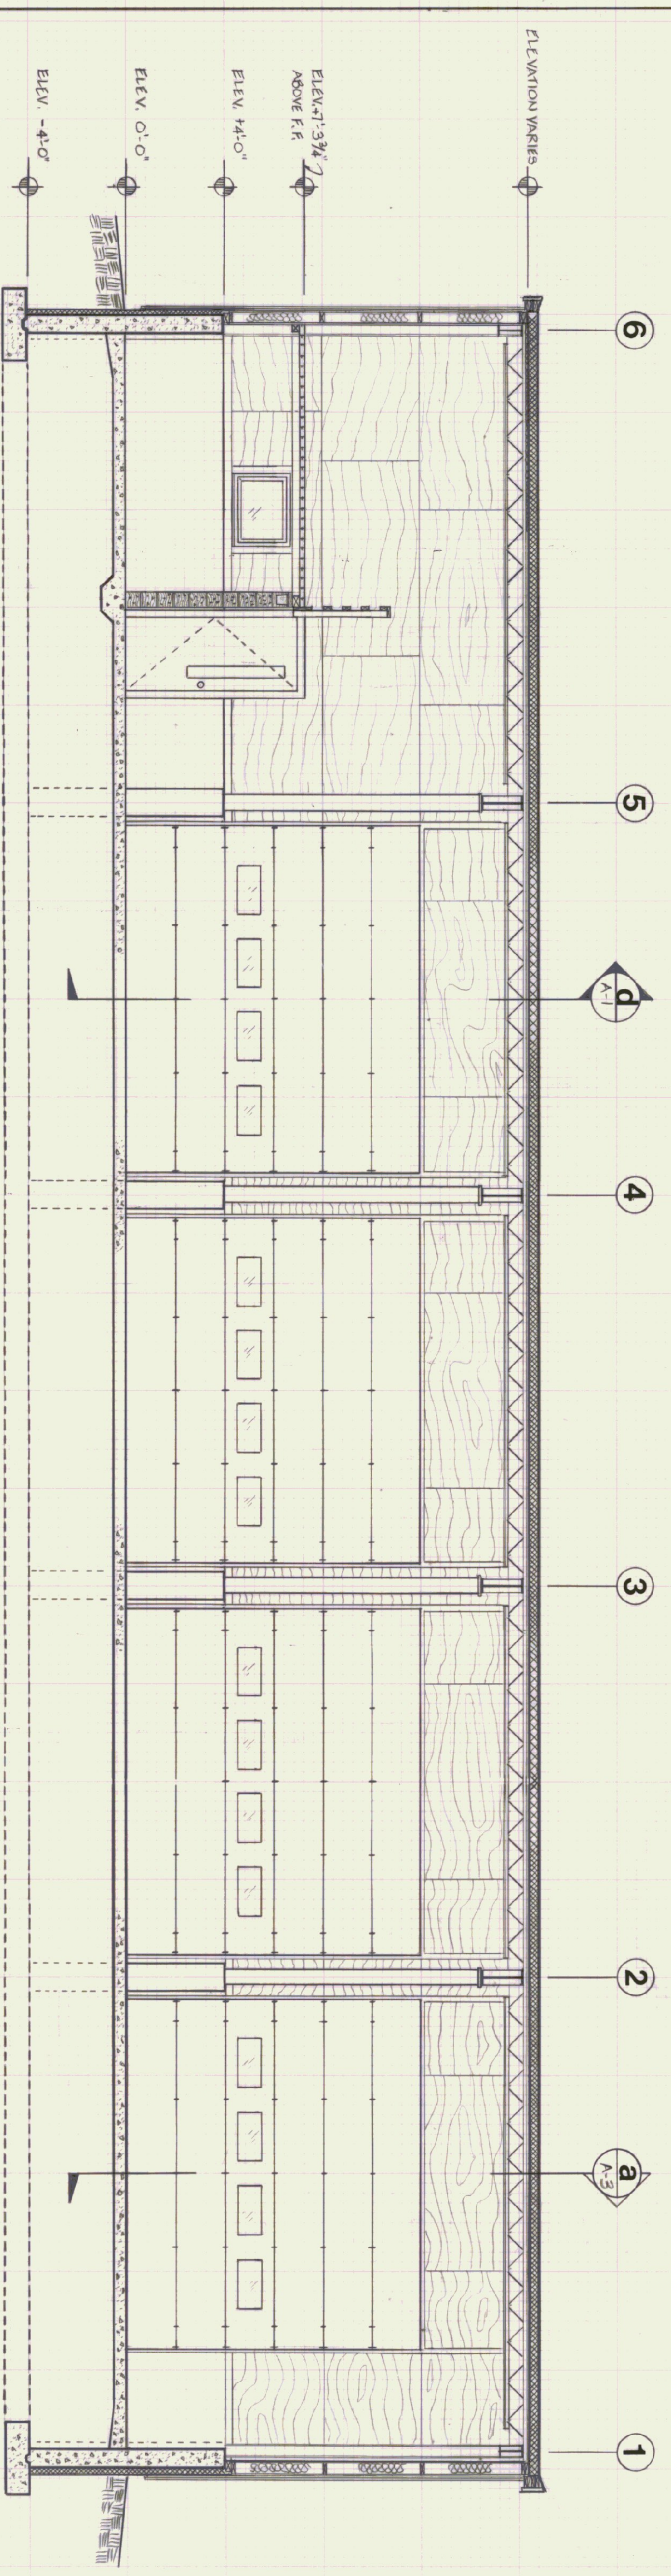



INTERIOR ELEVATION / SECTION (LOOKING TOWARDS 'A' LINE)
SCALE 1/4" = 1'-0"

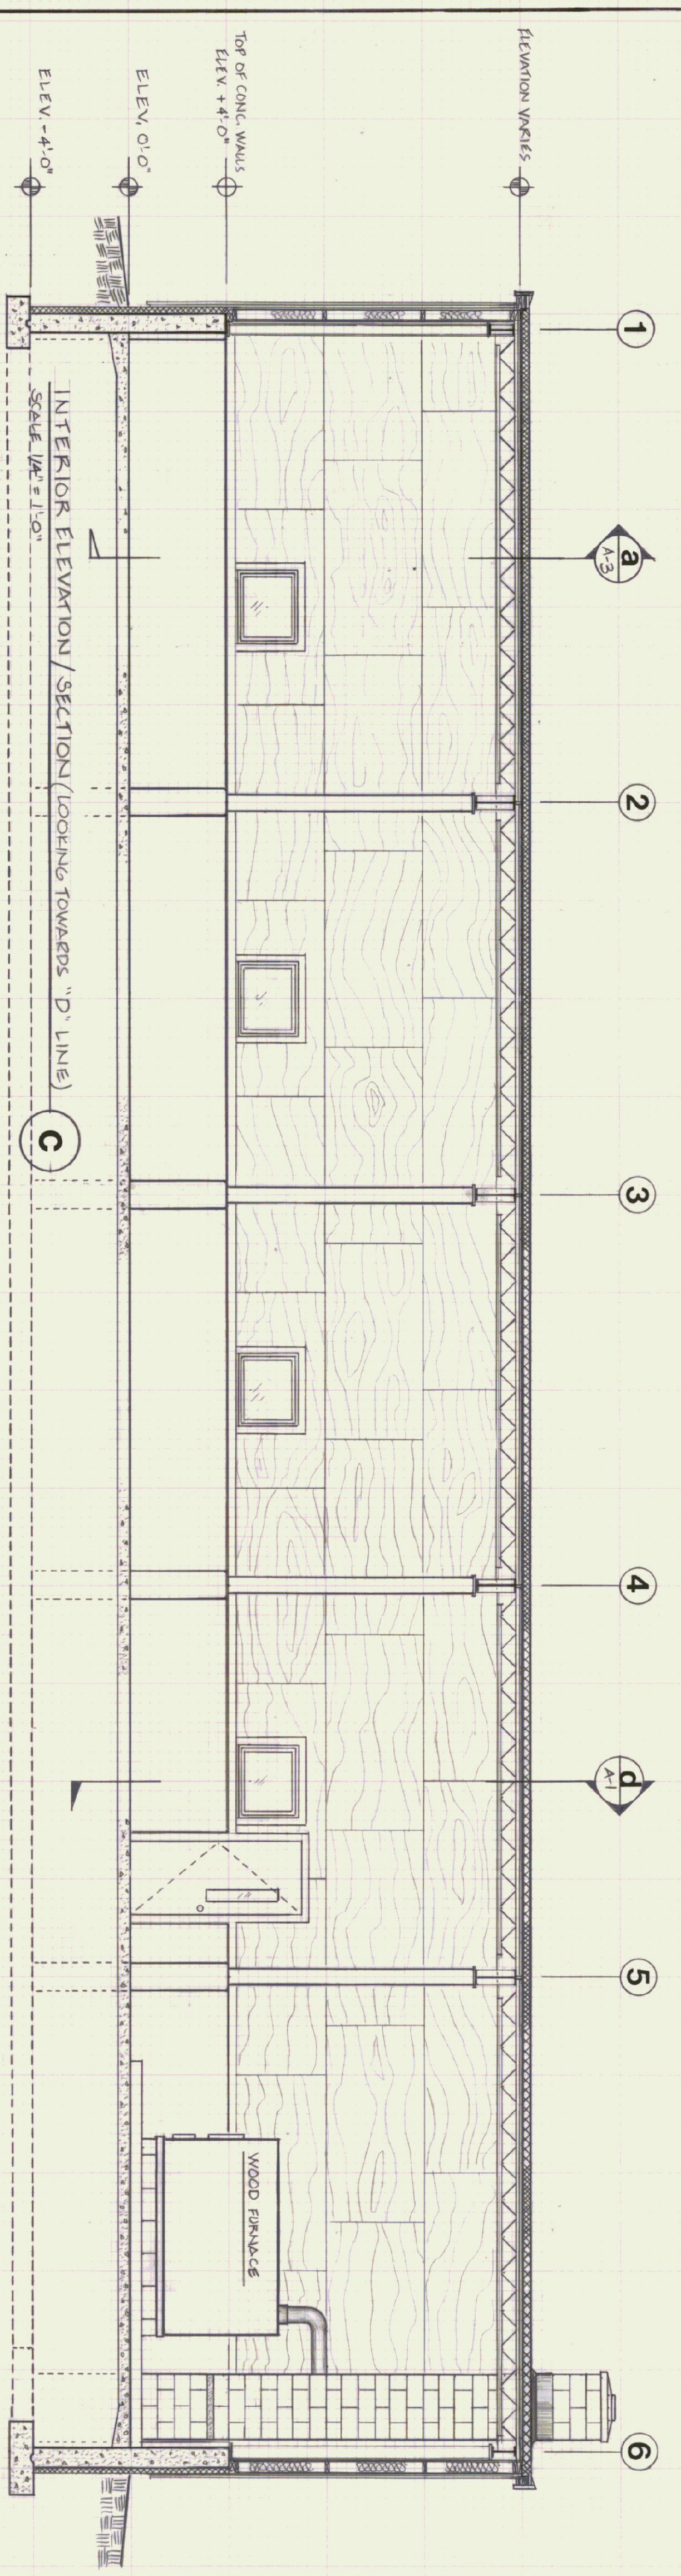












STATE OF VERMONT		DEPARTMENT OF STATE BUILDINGS	
MONTPELIER.		AGENCY OF ADMINISTRATION	
VERMONT		VERMONT	
AGENCY OF TRANSPORTATION MAINTENANCE GARAGE EDEN VERMONT			
INTERIOR ELEVATIONS AND SECTIONS			
DATE:	JULY 27, 1984	SCALE:	AS NOTED
DRAWN BY:	JOSTRUM	APPROVED BY:	RA FOR USB
REVISIONS:		DWG. NO.:	A-3
			4 OF 13

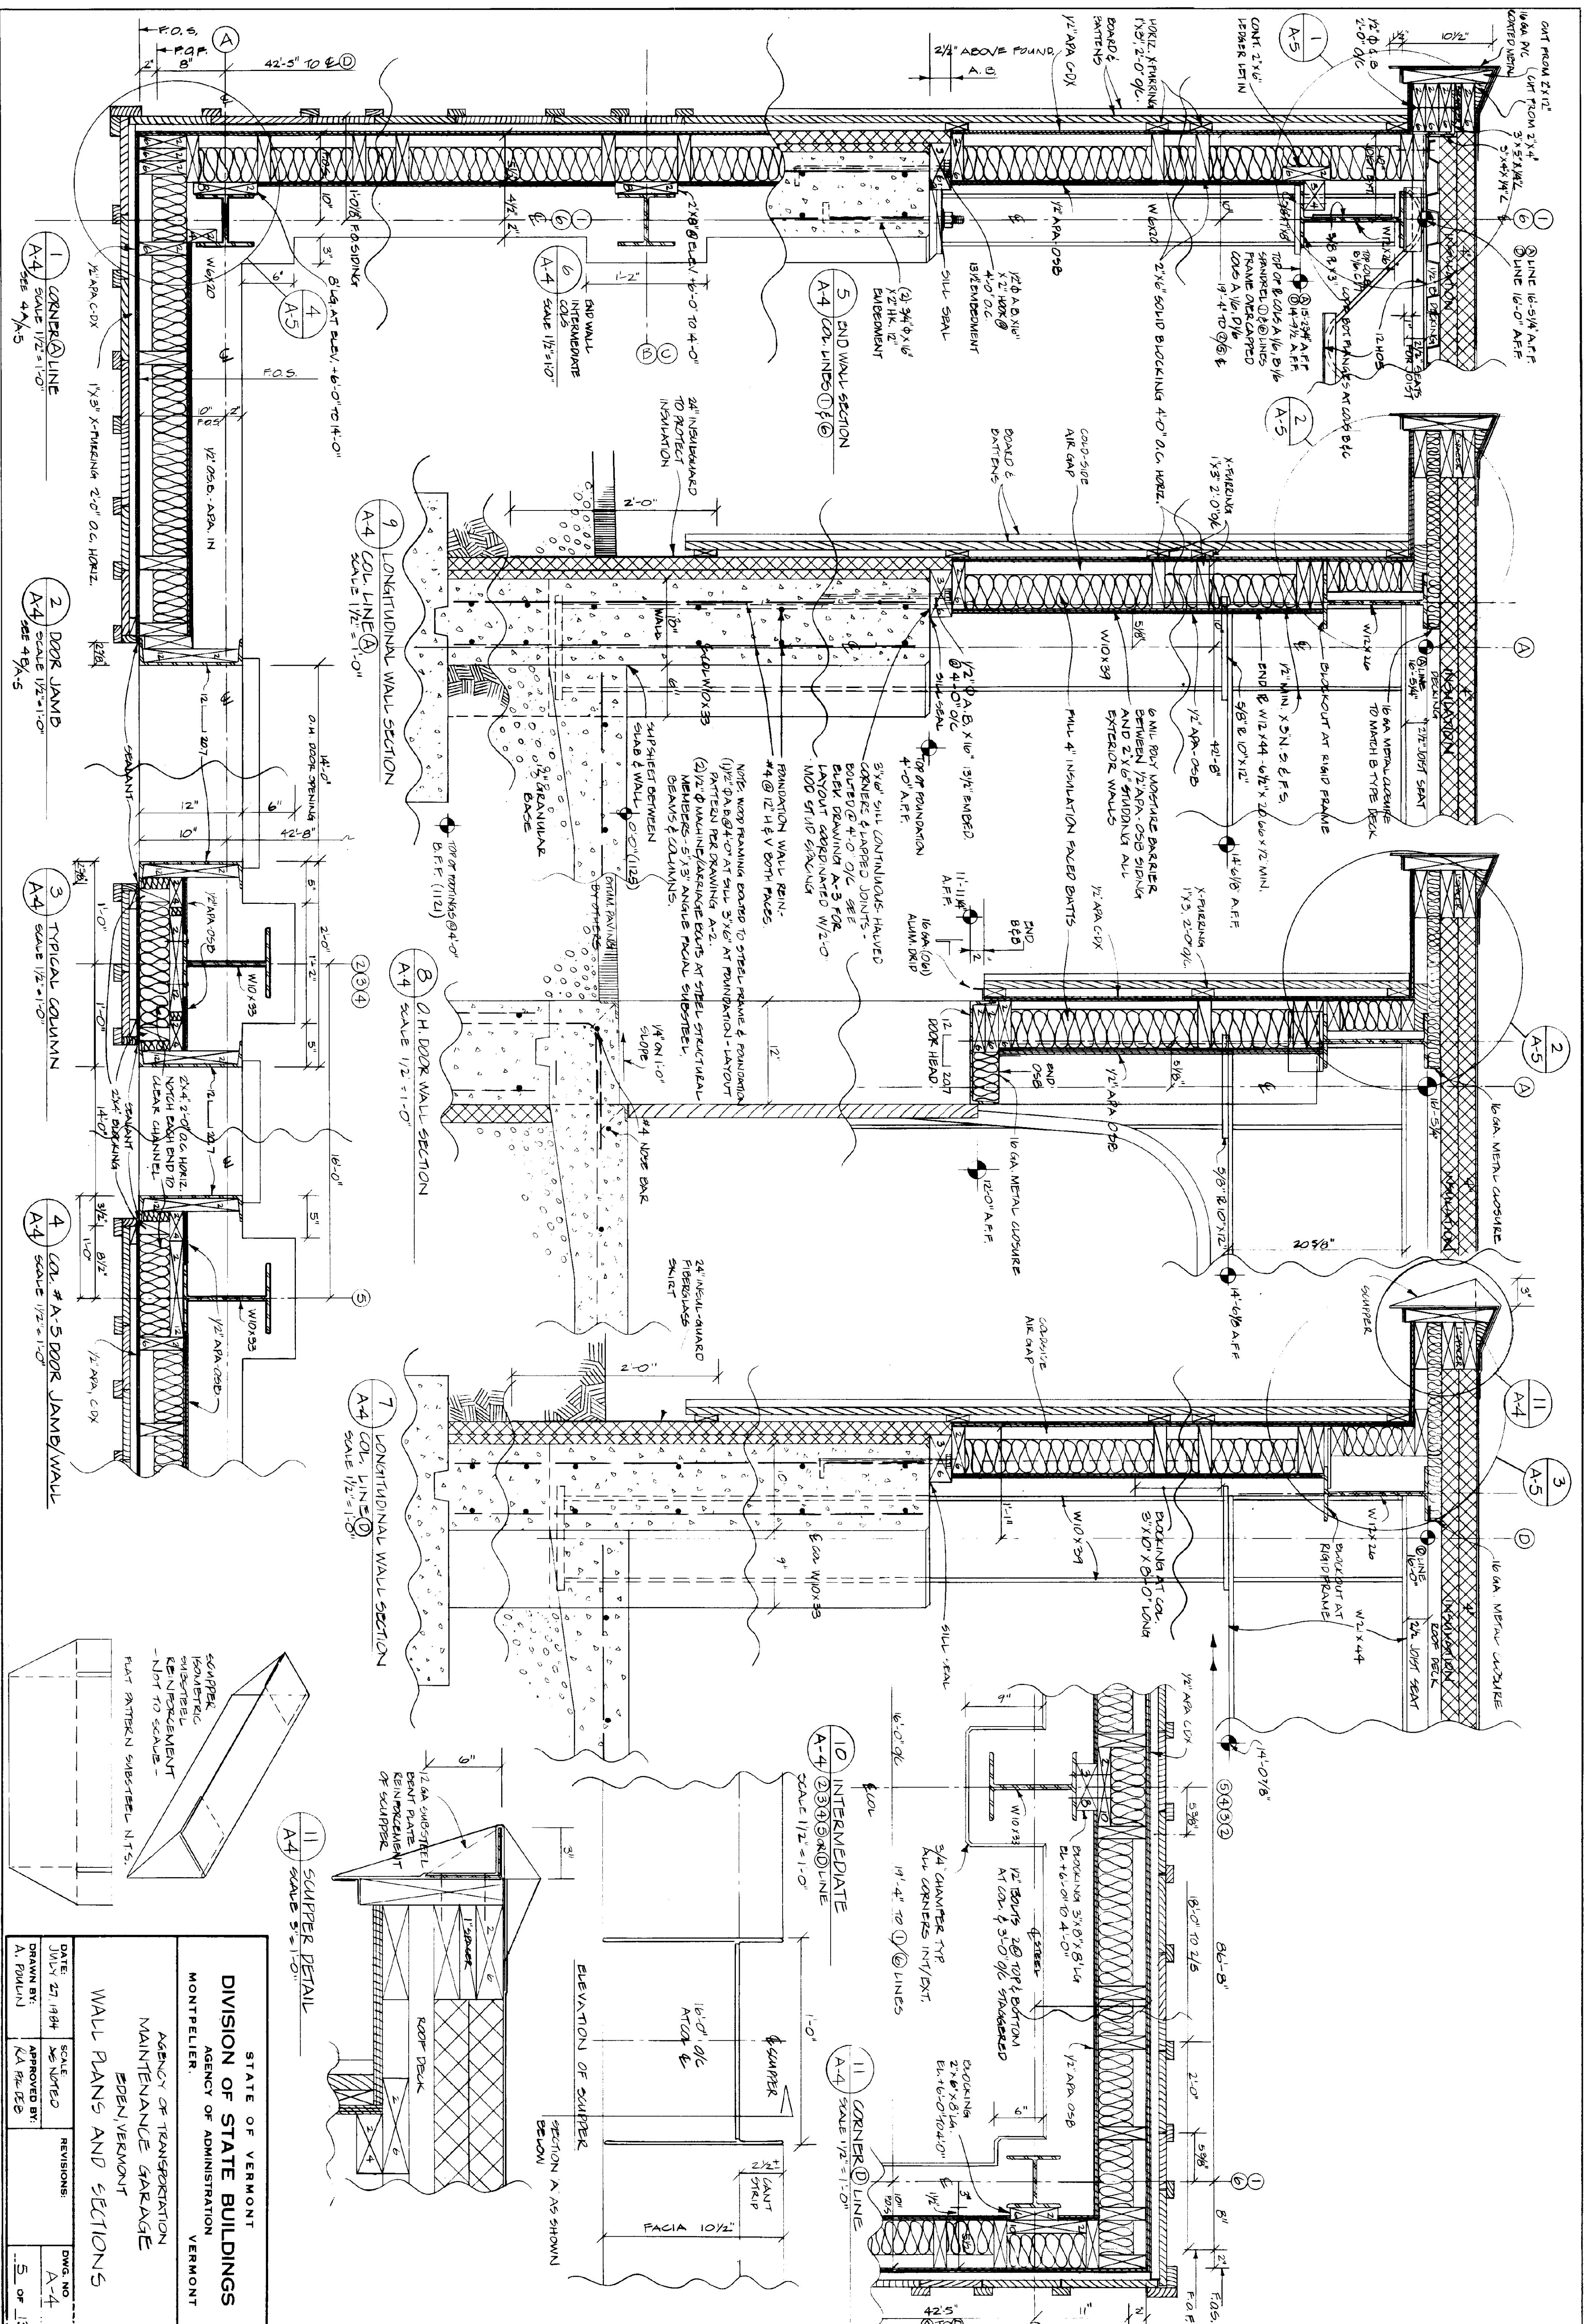


STATE OF VERMONT		DIVISION OF STATE BUILDINGS	
AGENCY OF ADMINISTRATION		MONTPELLIER	
AGENCY OF TRANSPORTATION		MAINTENANCE GARAGE	
EDEN, VERMONT		WALL PLANS AND SECTIONS	
DATE: JULY 27, 1984	SCALE: AS NOTED	REVISIONS:	DWG. NO. A-4
DRAWN BY: A. P. BULLI	APPROVED BY: K. P. B. B.		5 OF 13

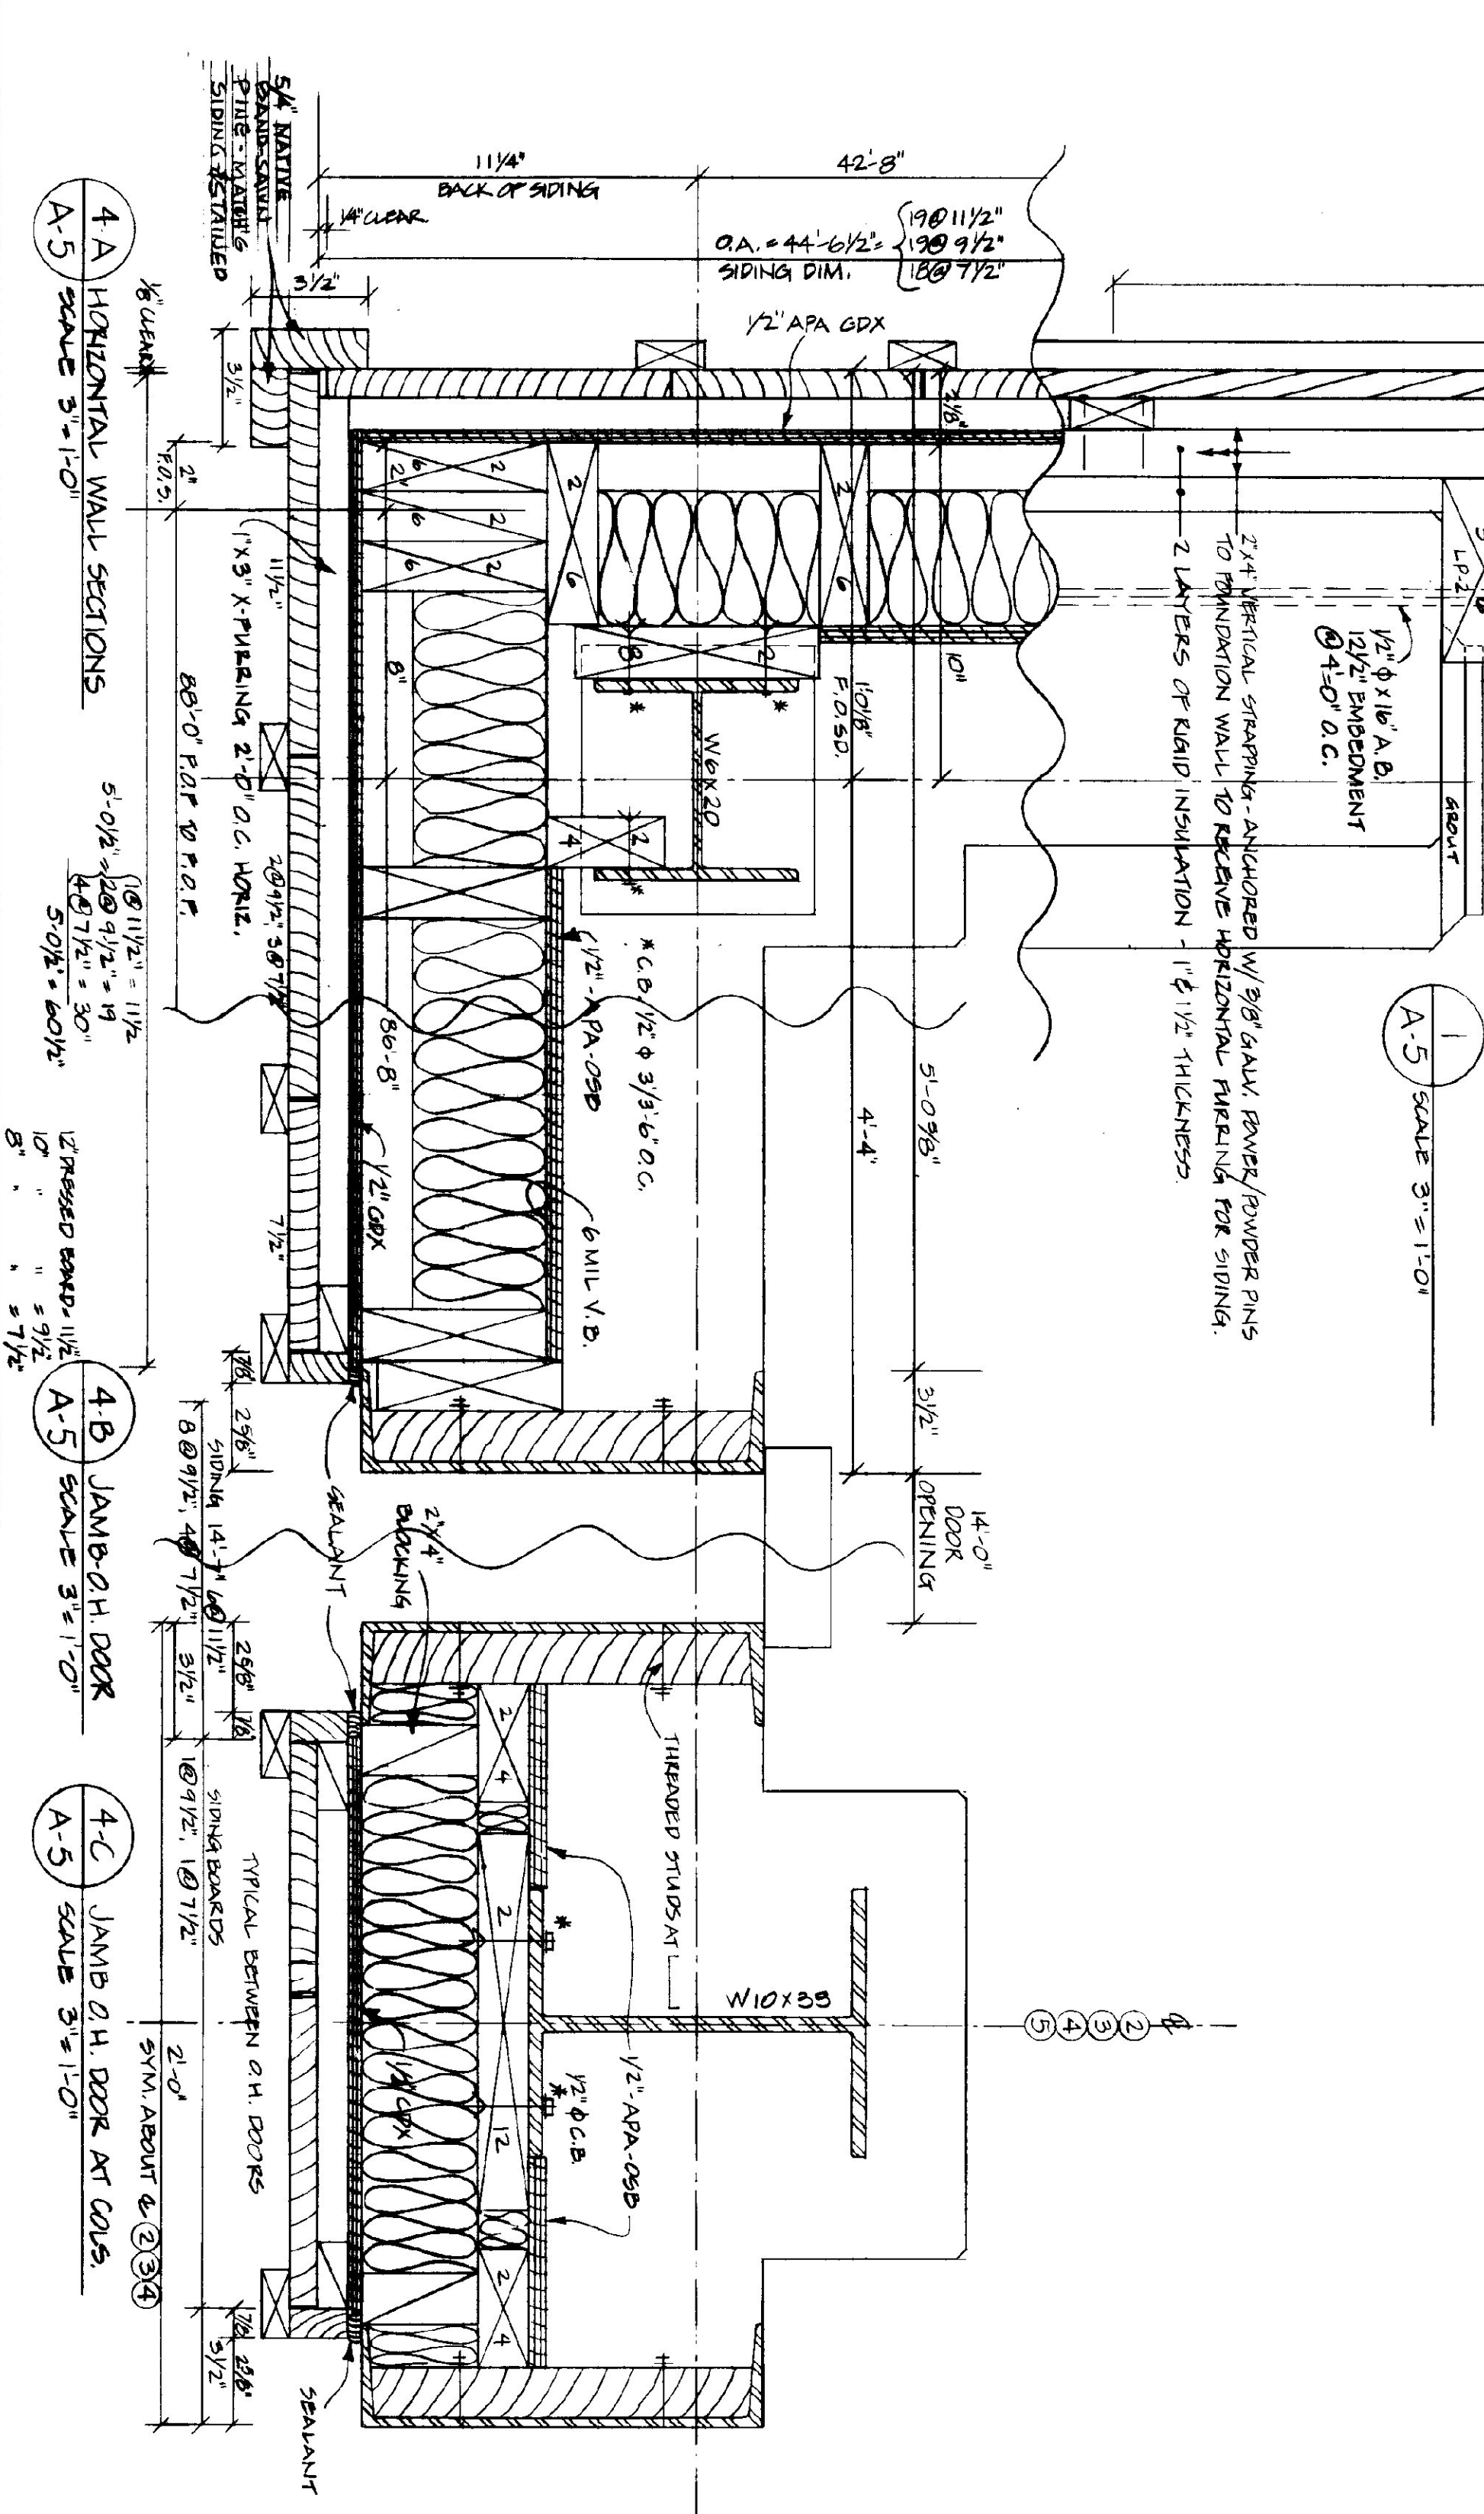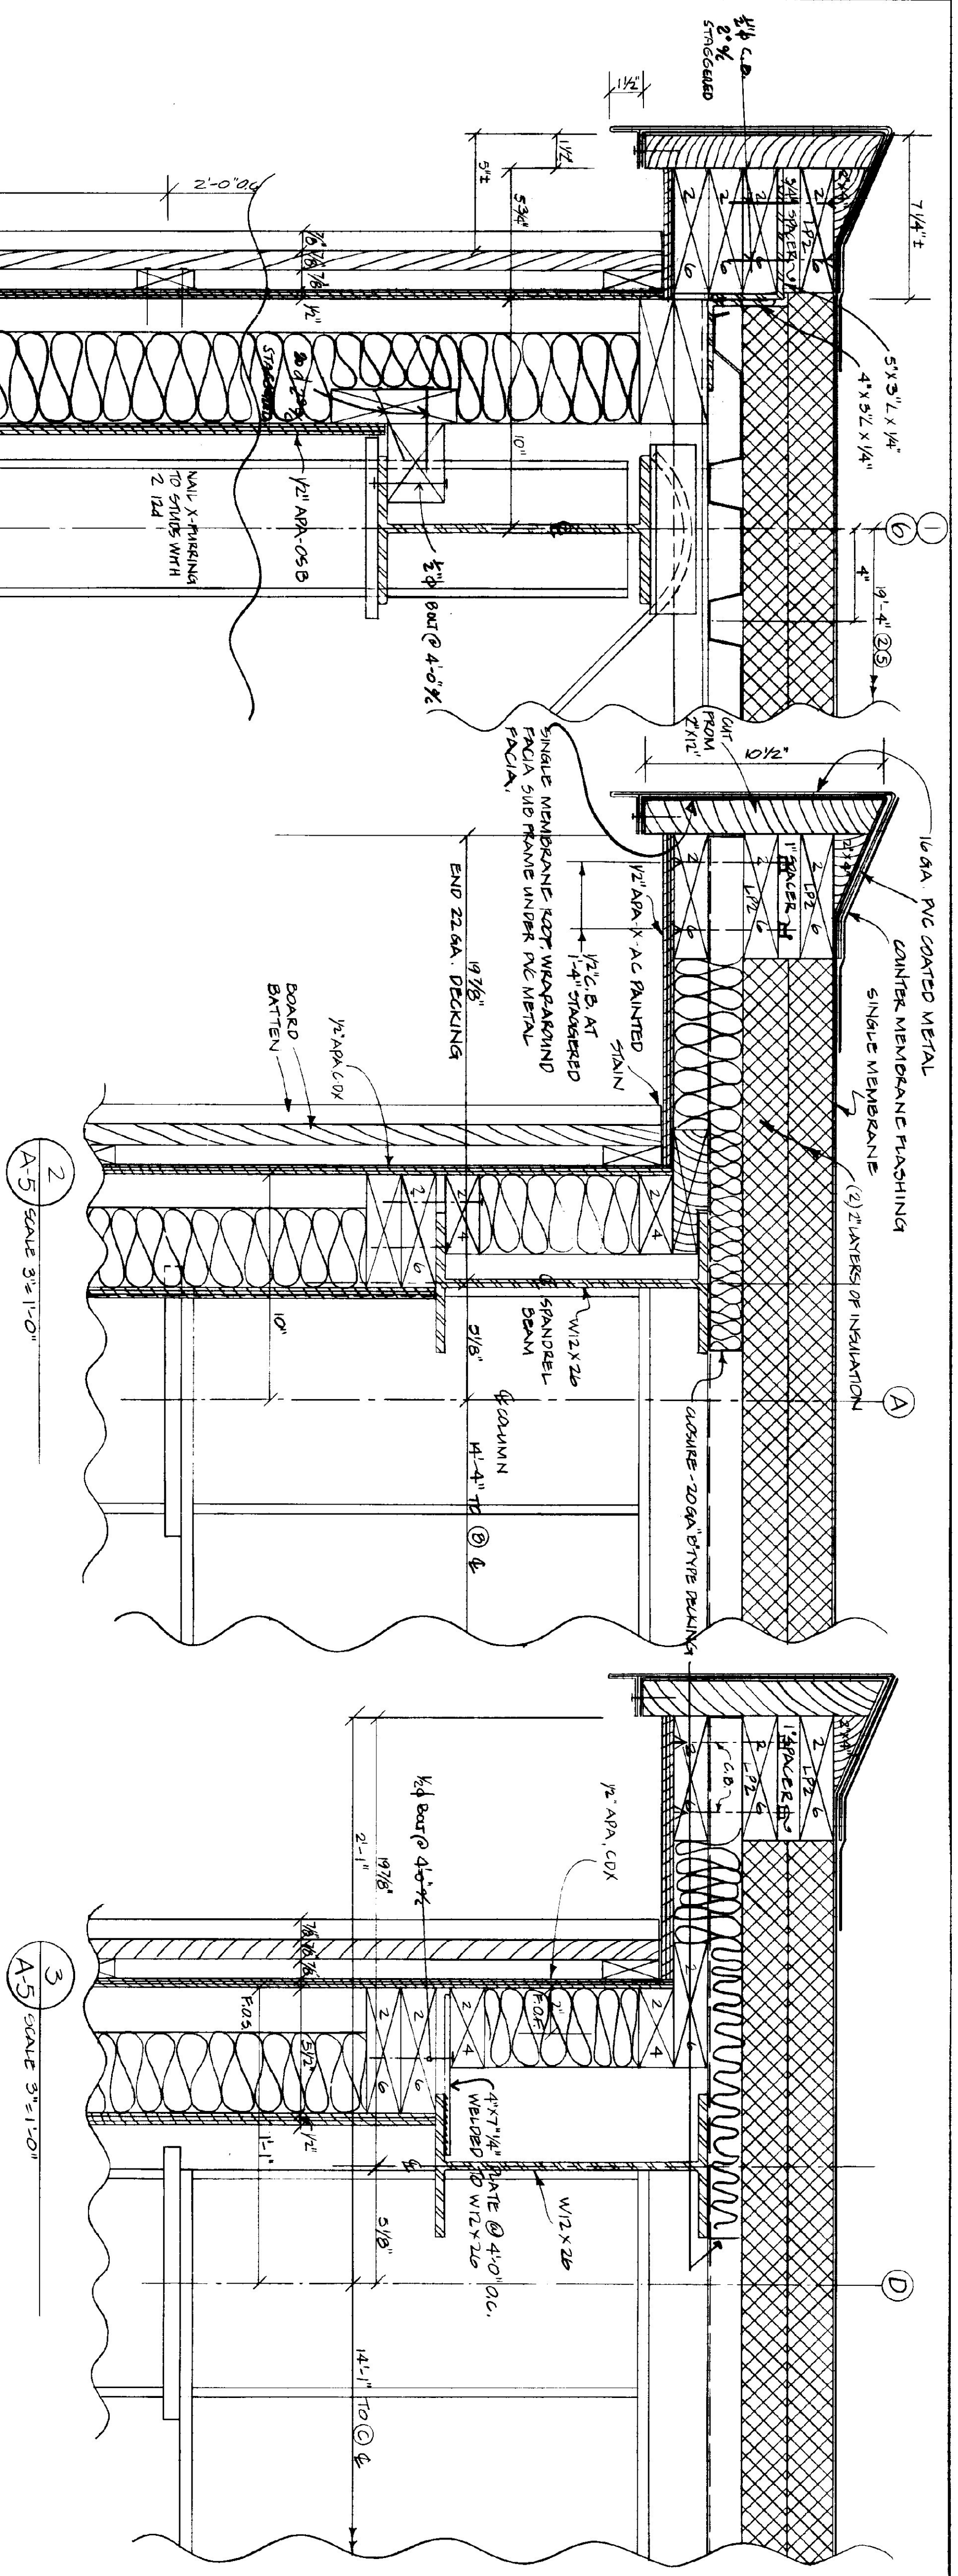

STATE OF VERMONT		DIVISION OF STATE BUILDINGS	
AGENCY OF ADMINISTRATION		MONTPELIER, VERMONT	
AGENCY OF TRANSPORTATION		MAINTENANCE GARAGE	
EDEN, VERMONT		WALL DETAILS	
DATE: JUL 27 1984	SCALE: 3/4" = 1'-0"	REVISIONS:	DWG. NO. A-5
DRAWN BY: A. PHELIN	APPROVED BY: RA FOR DEB		6 OF 13

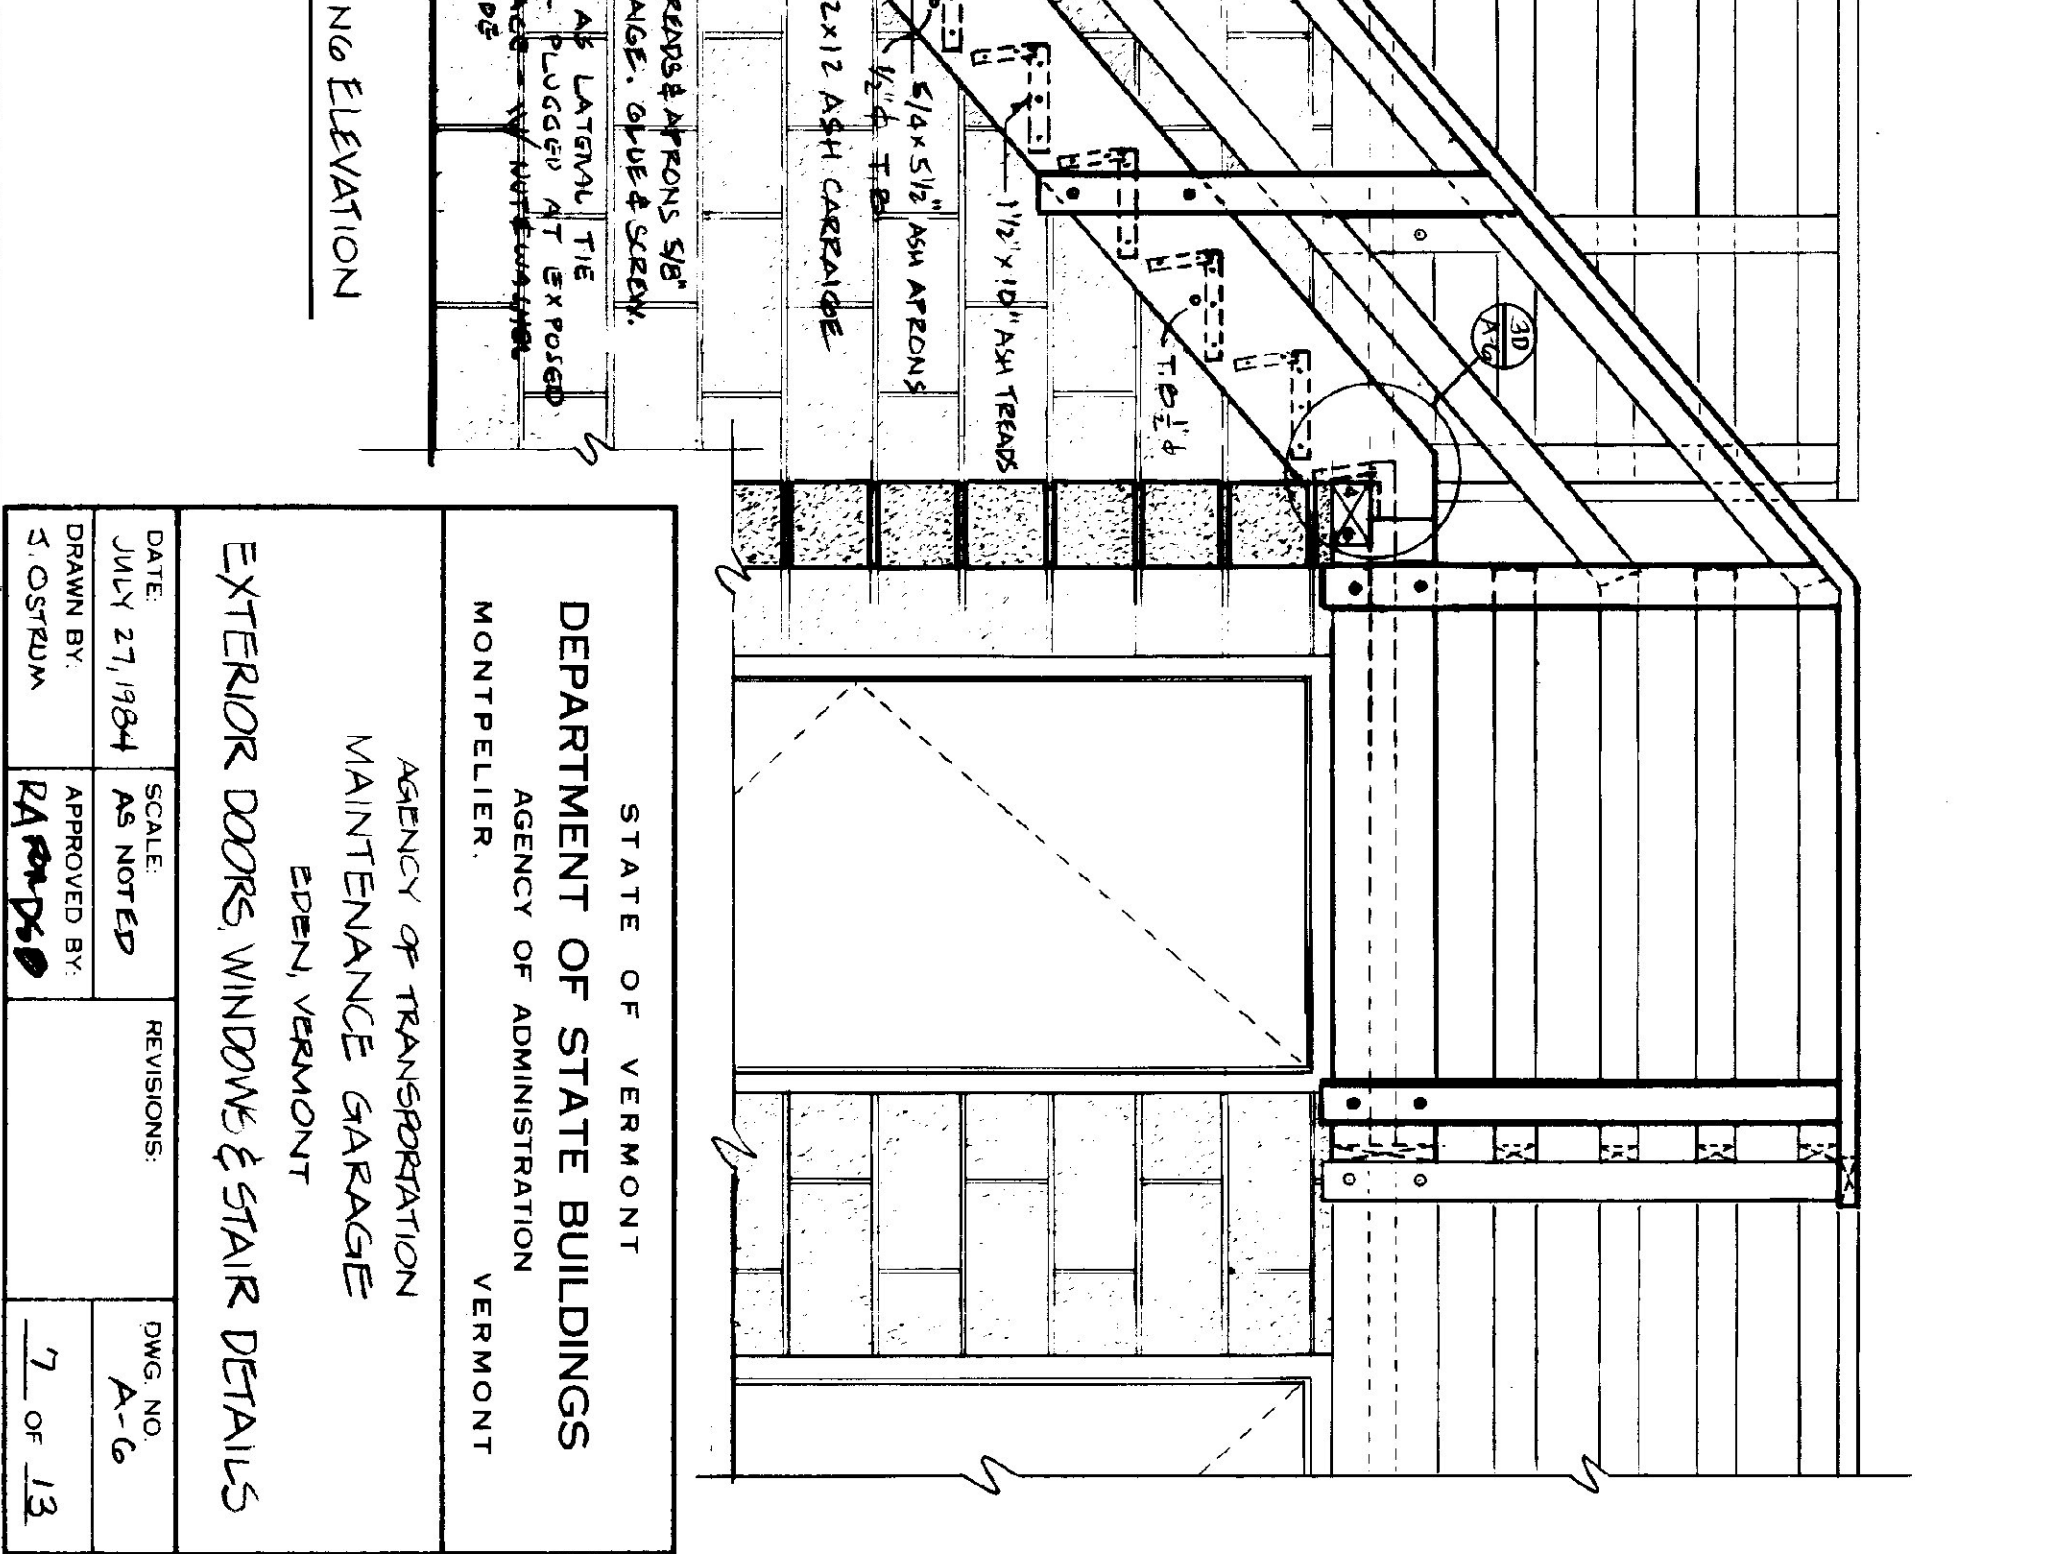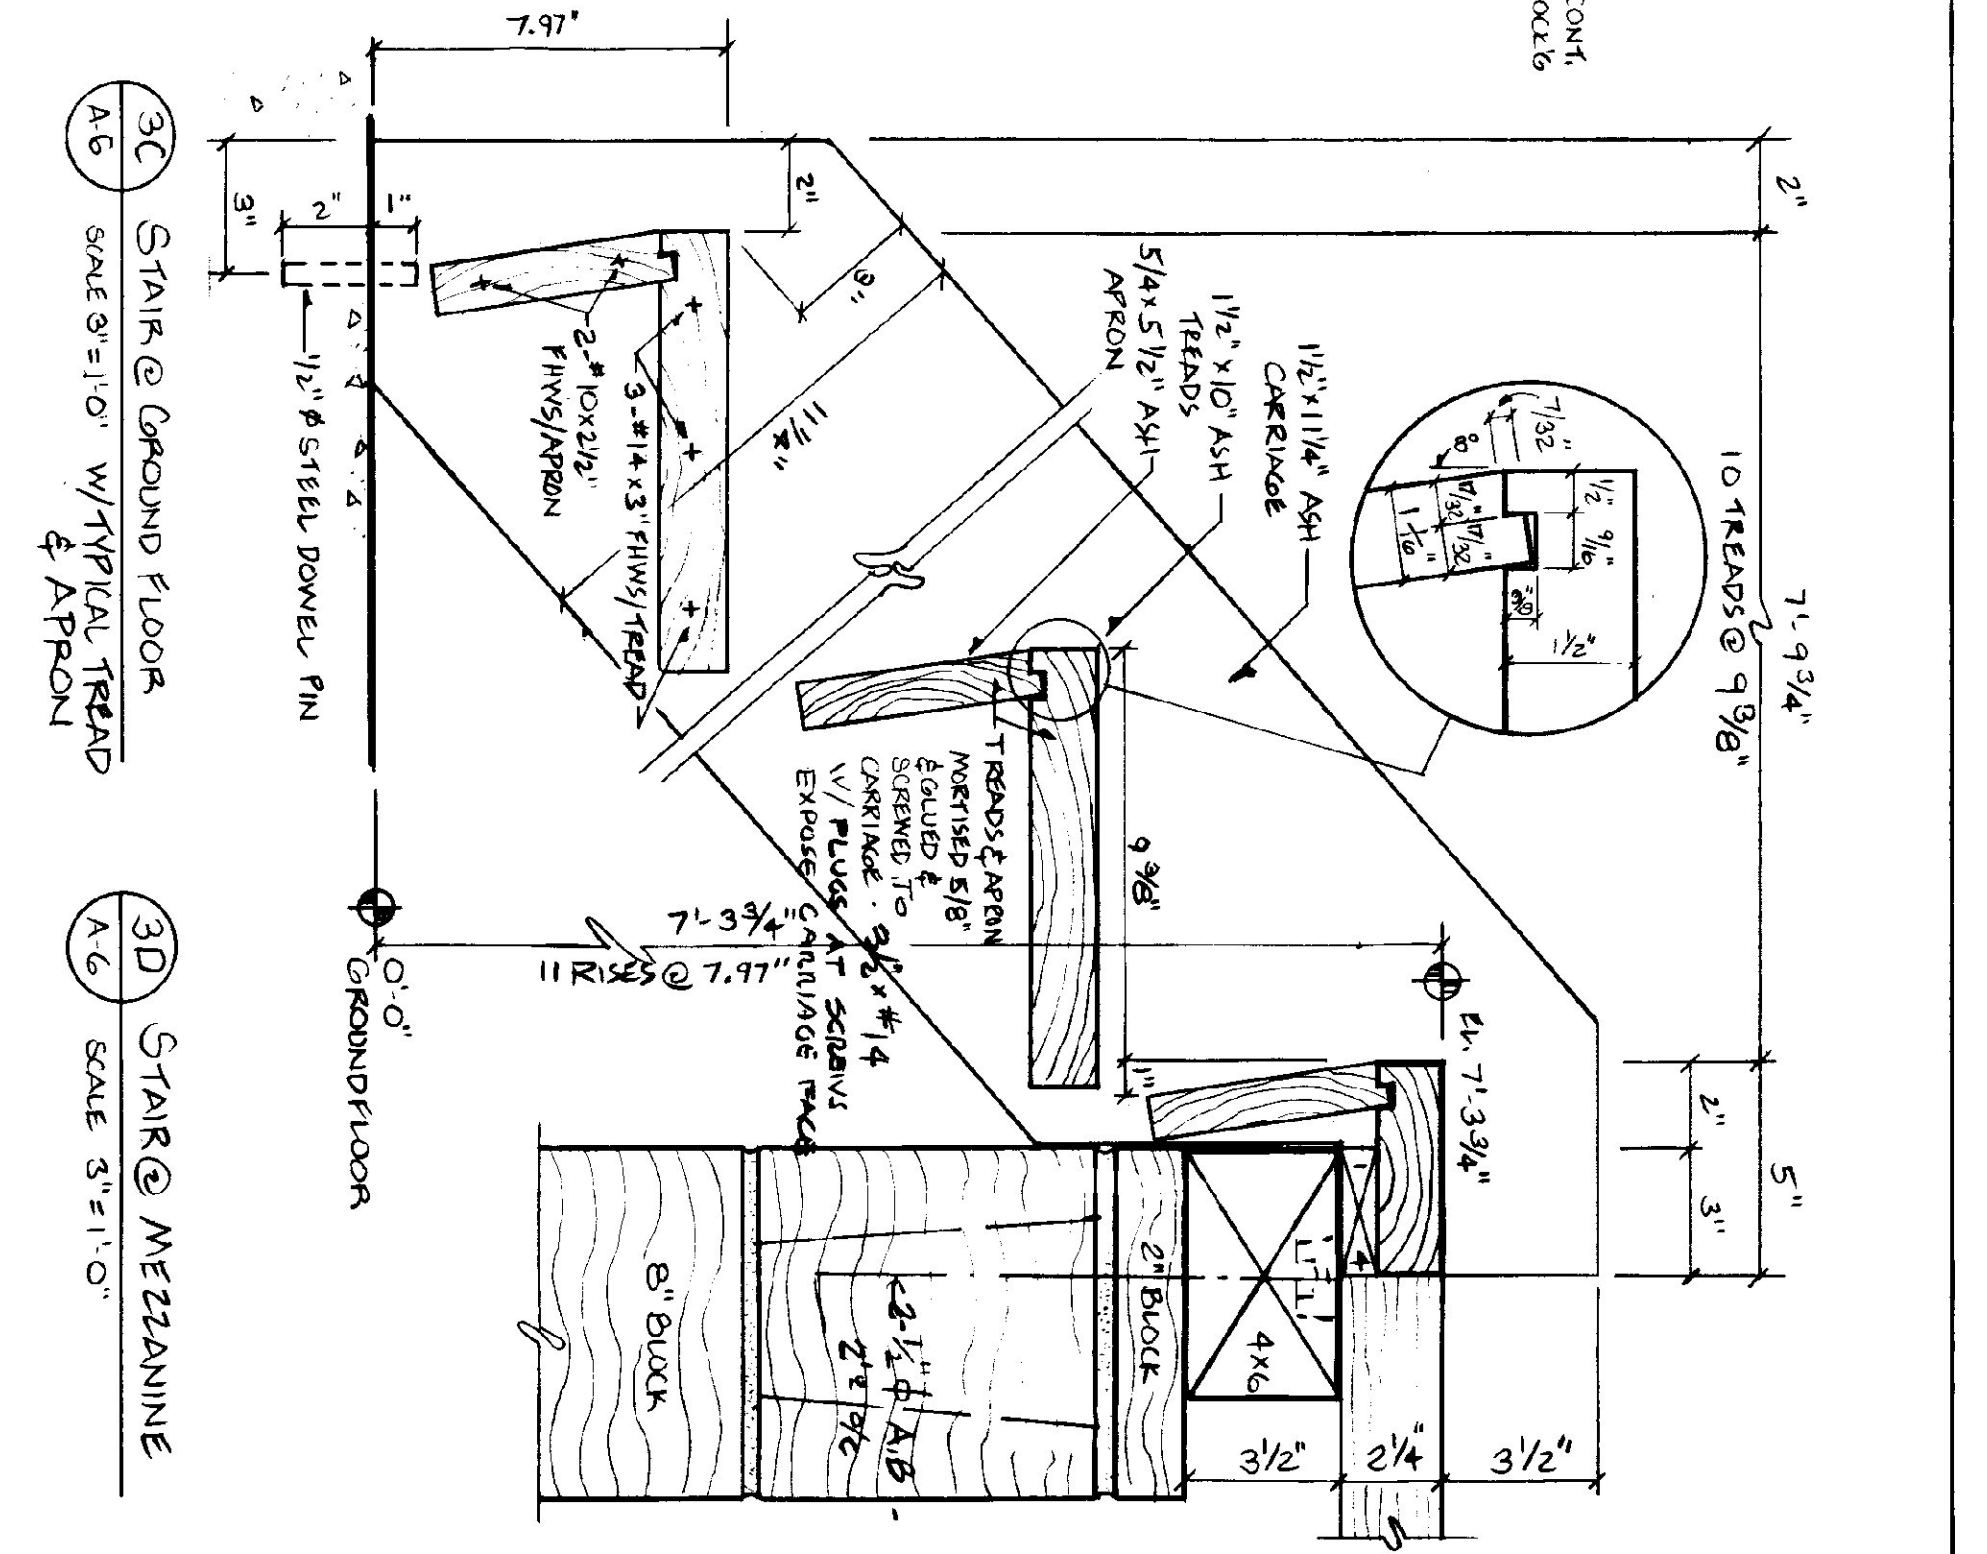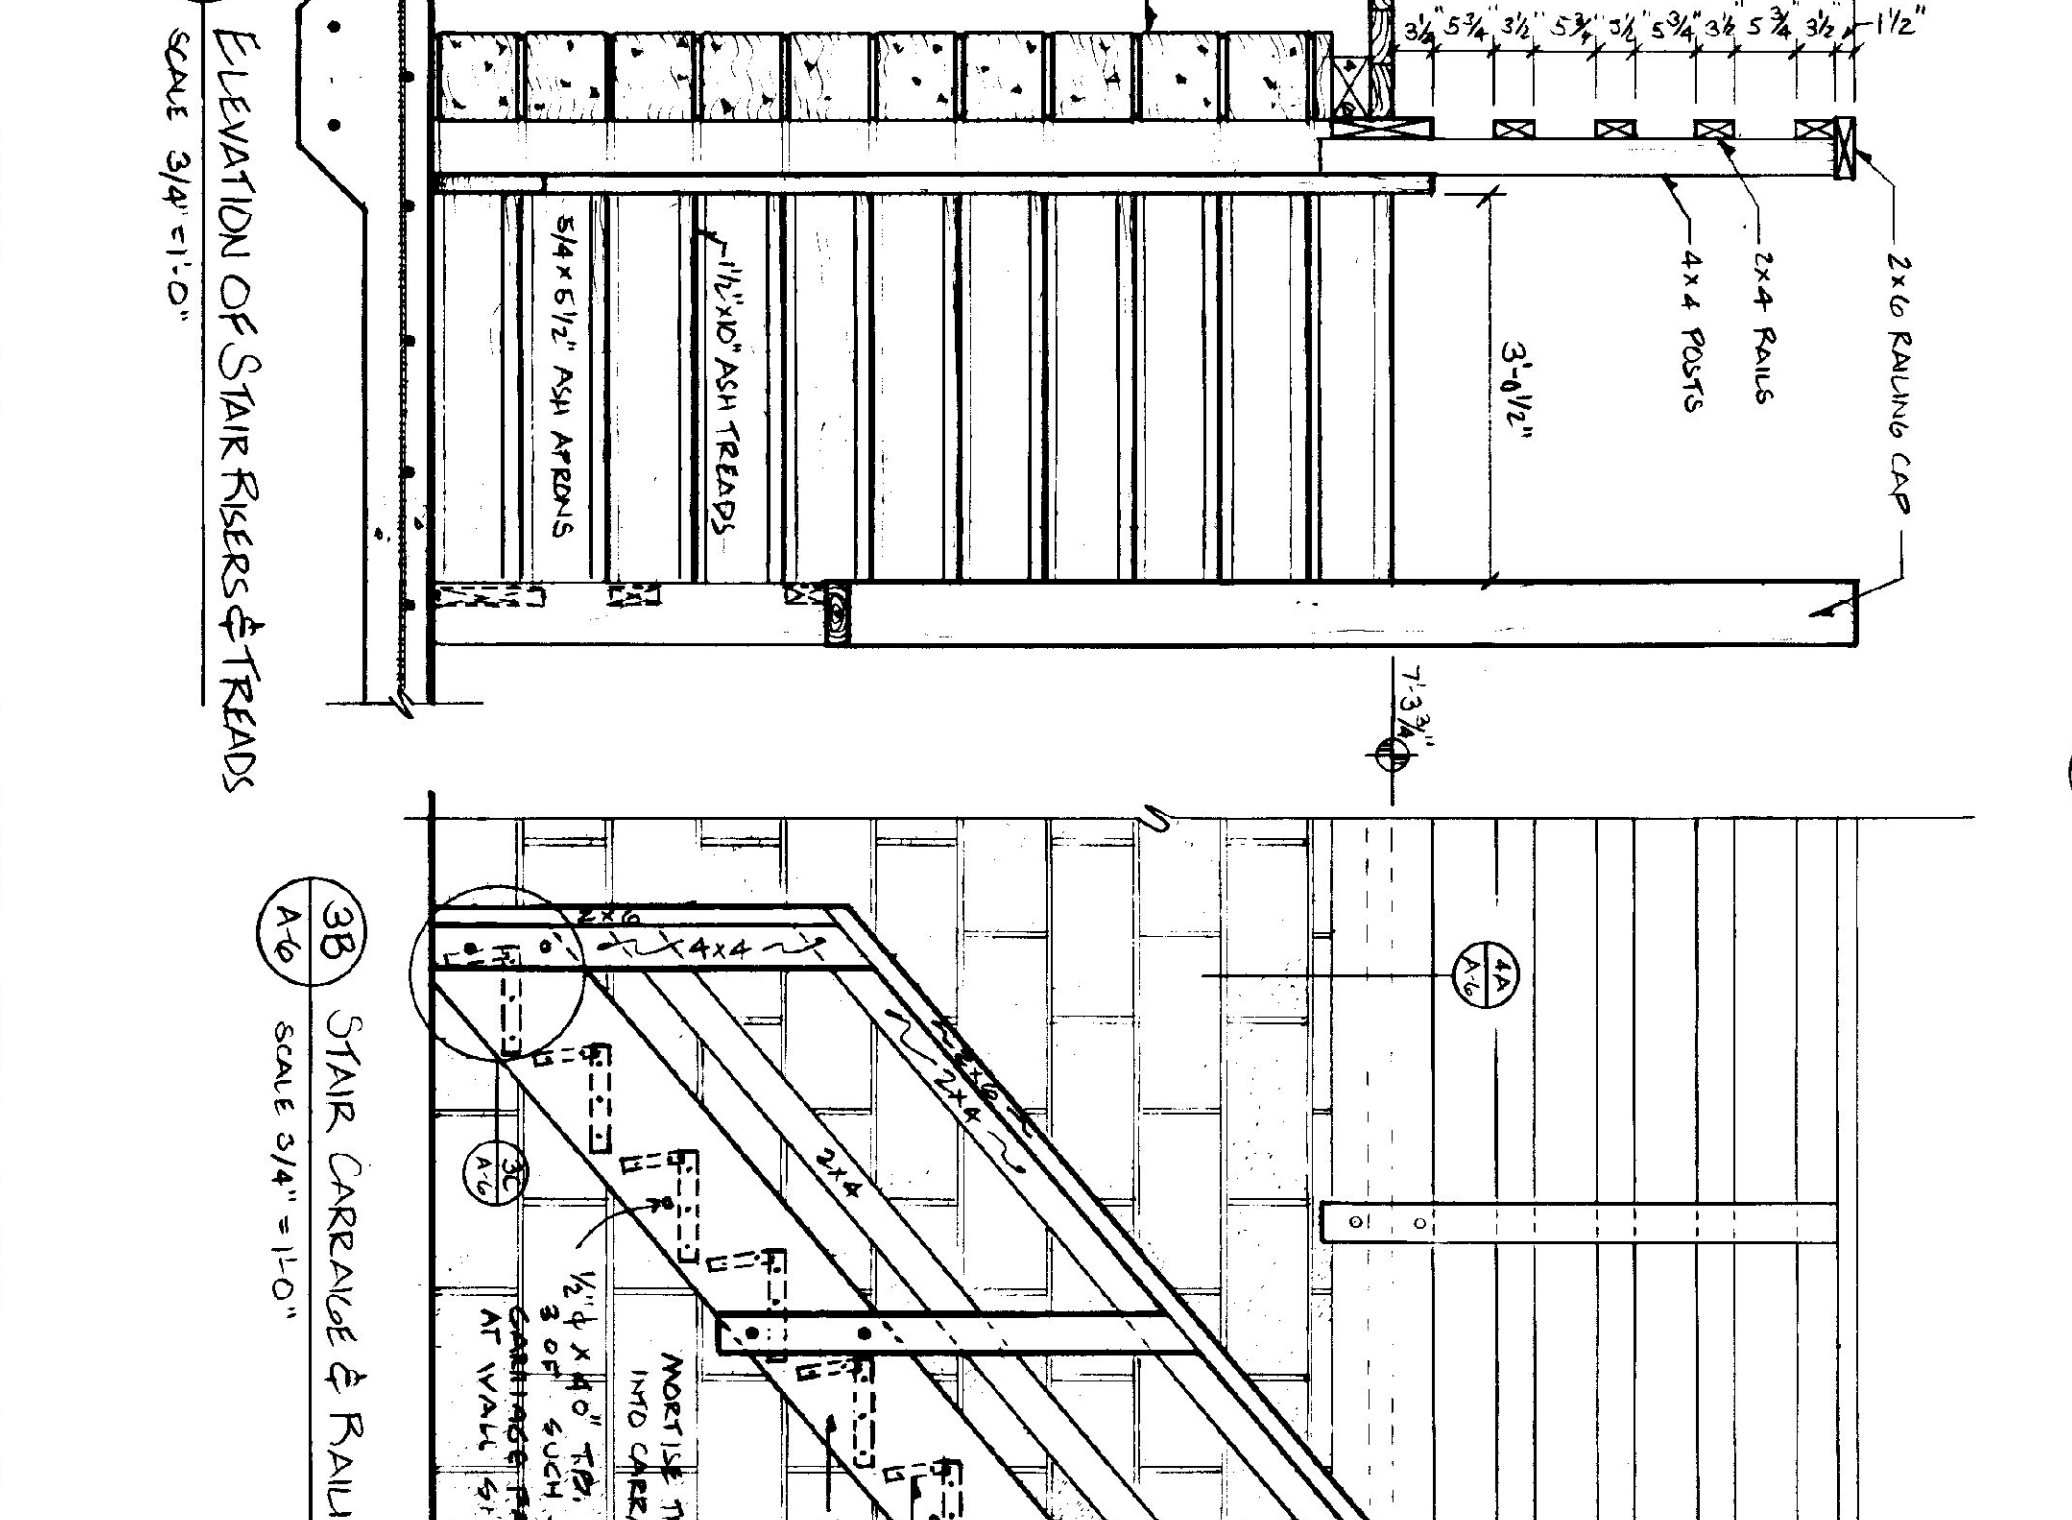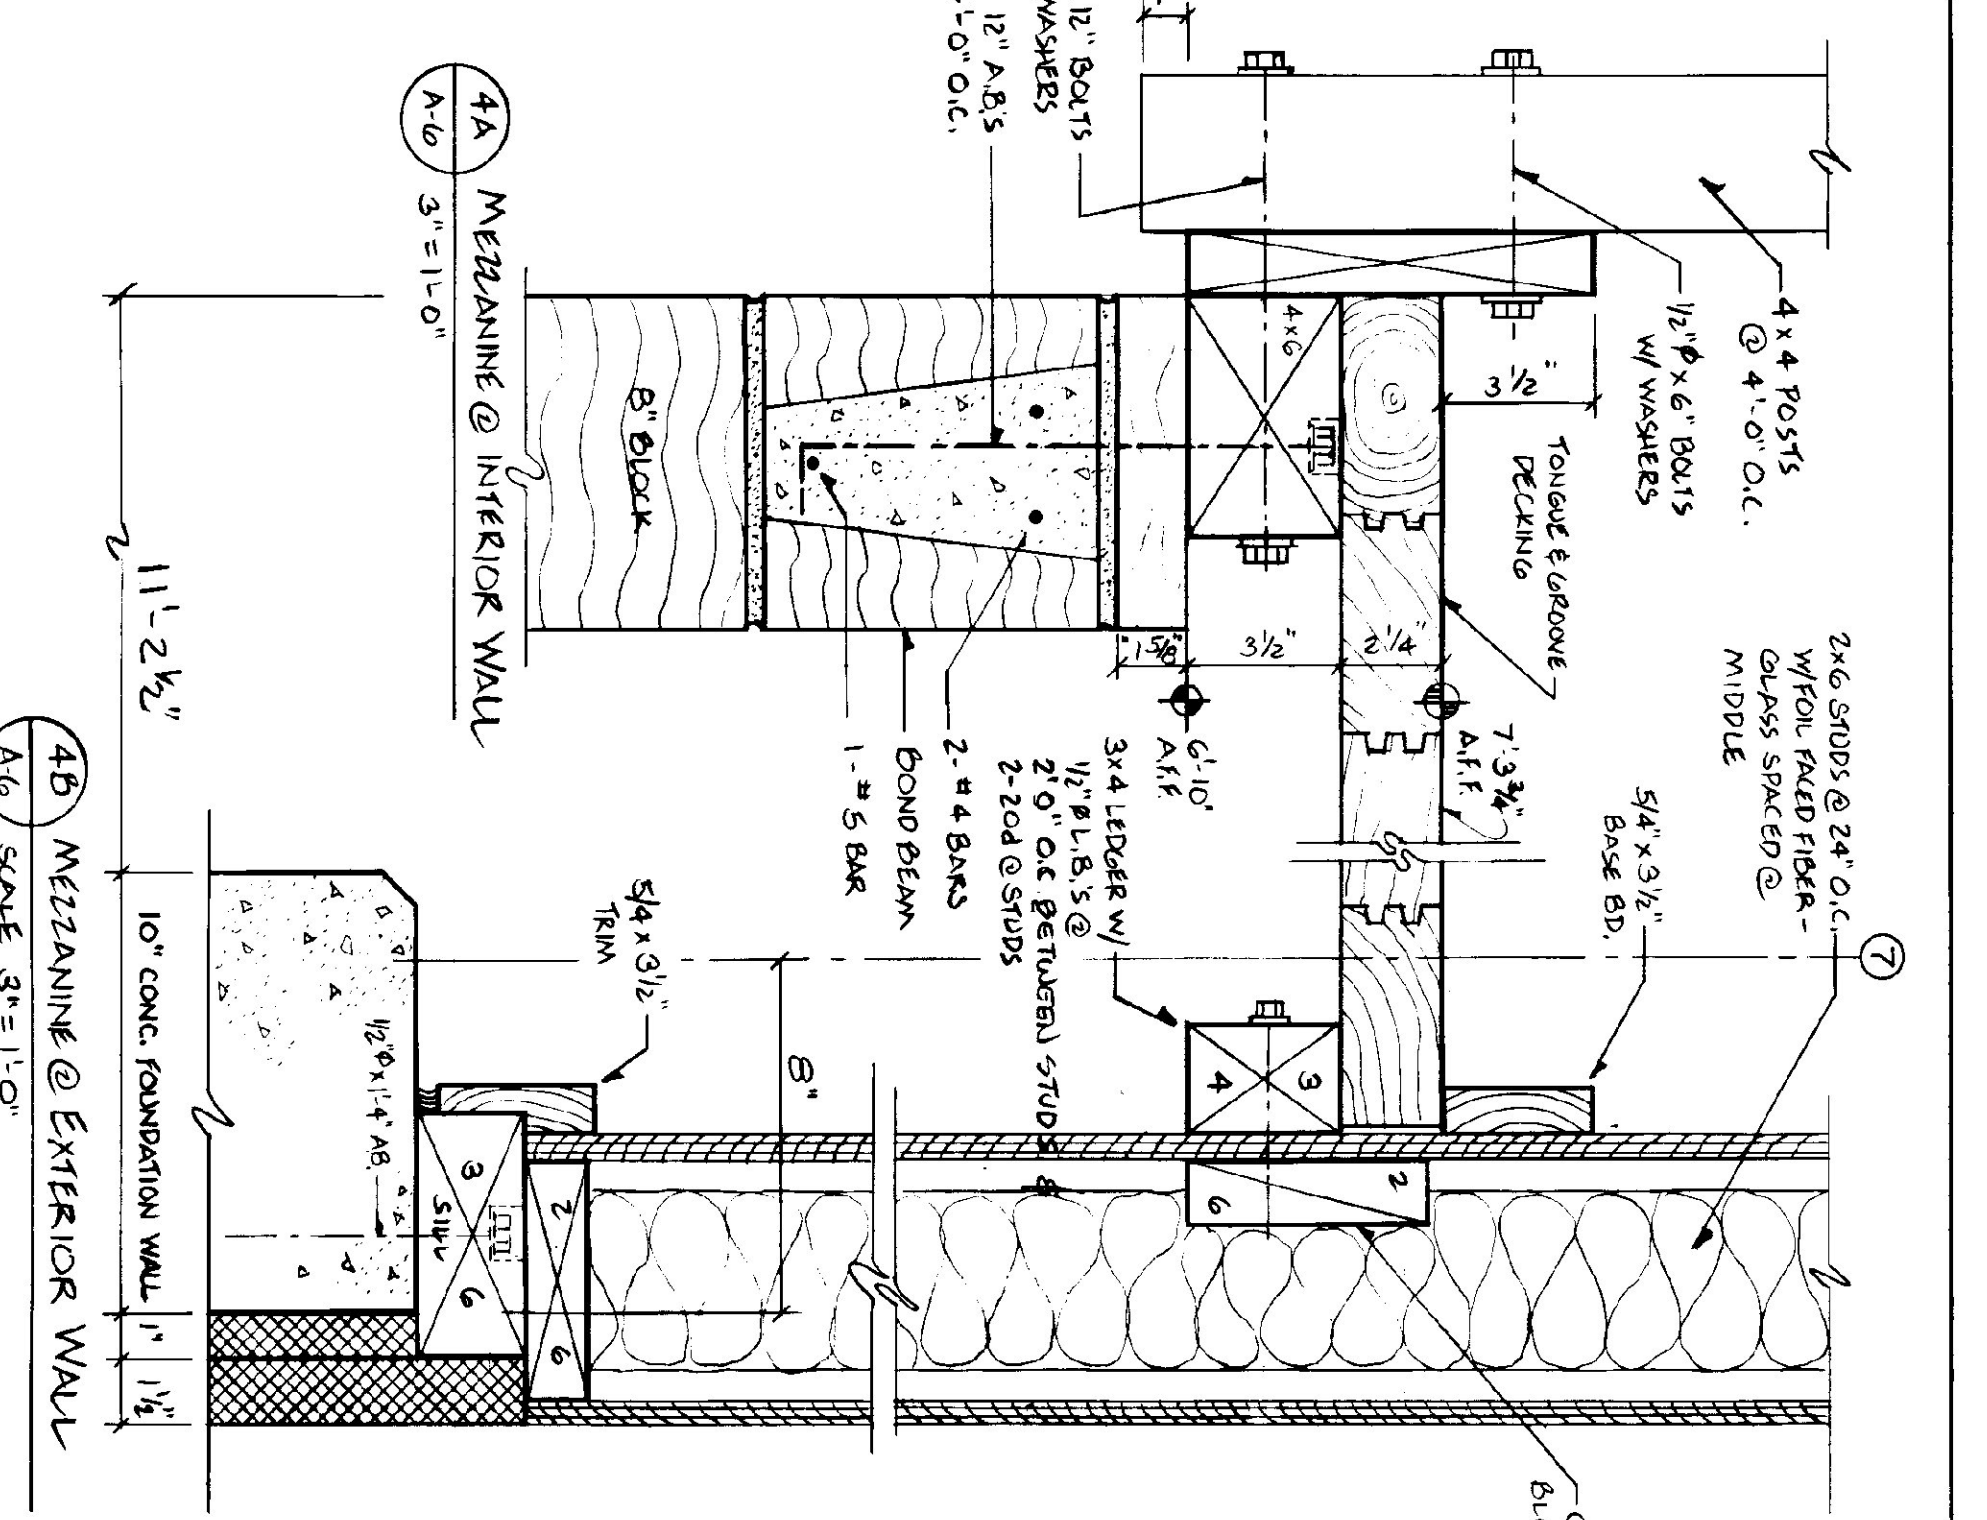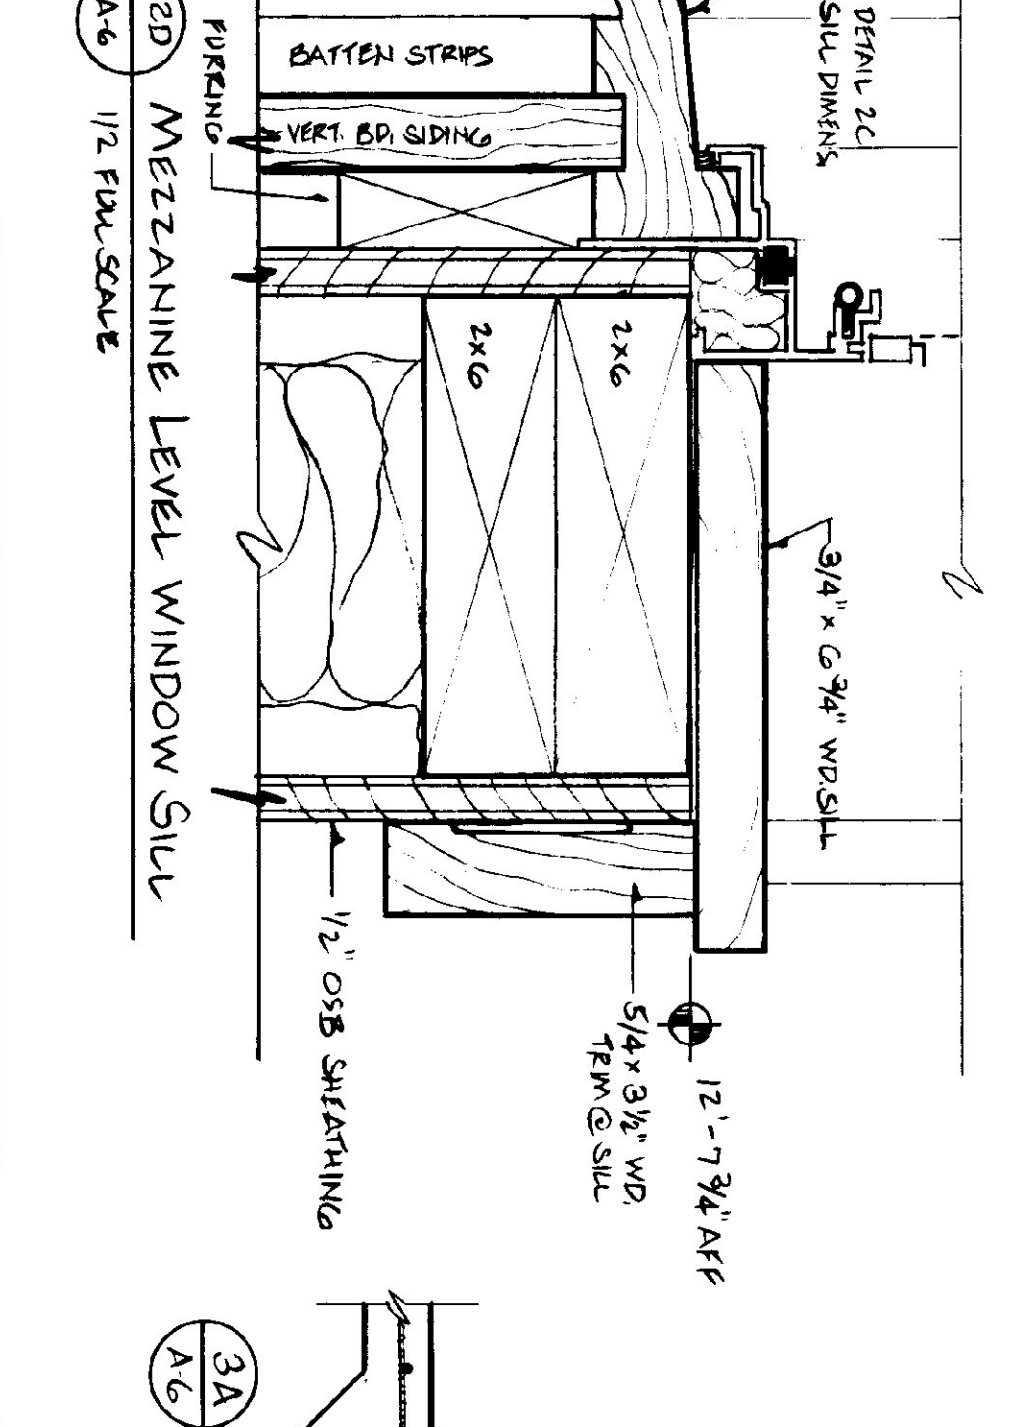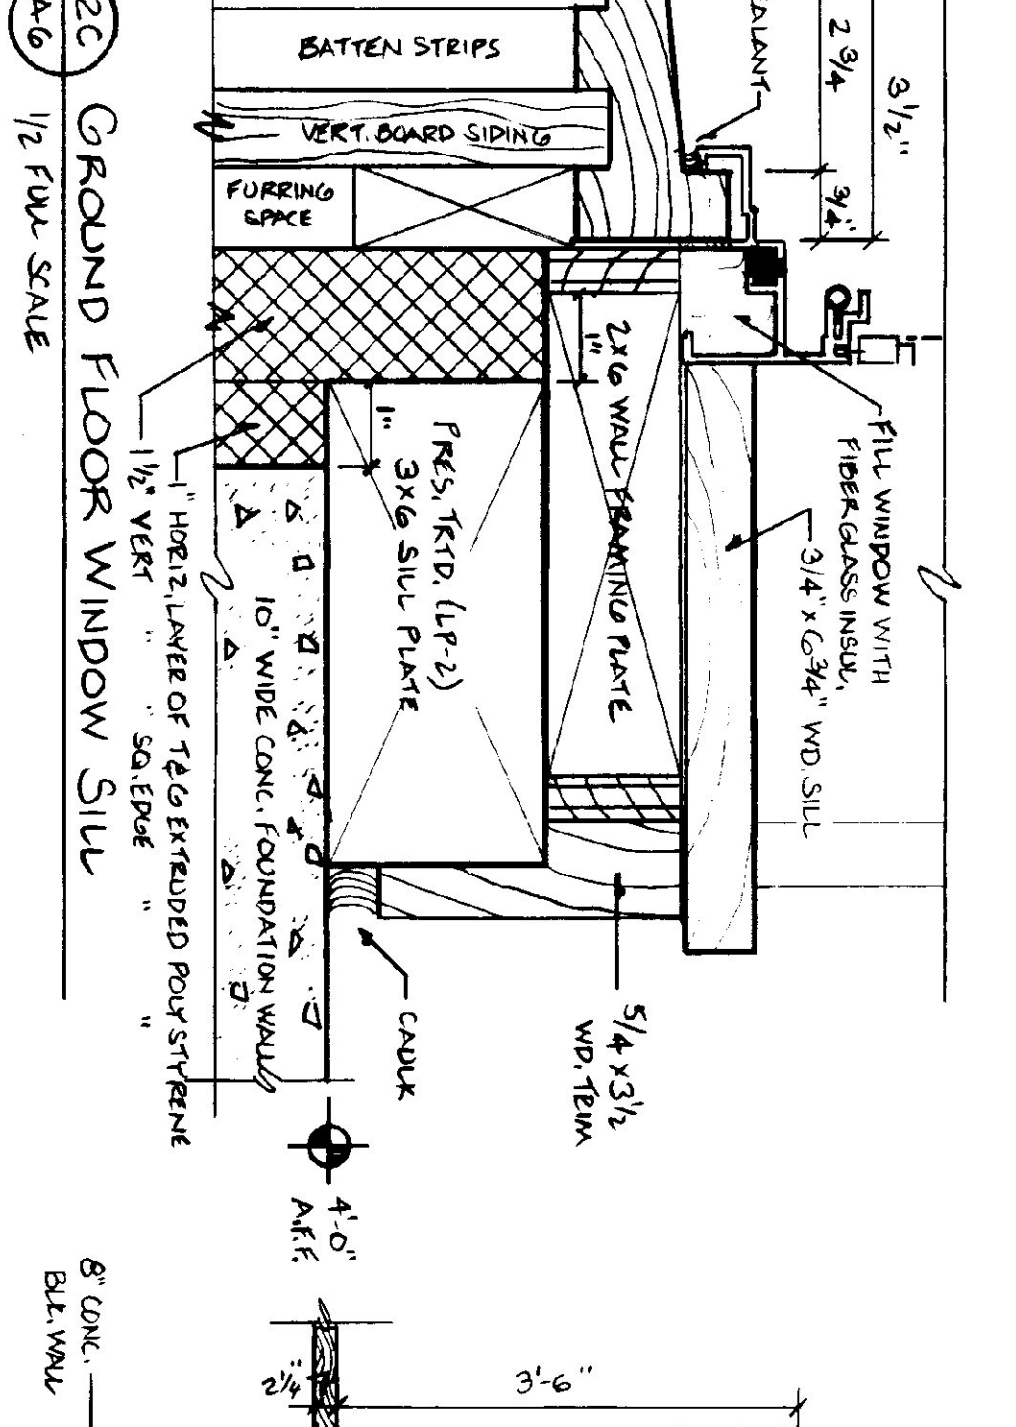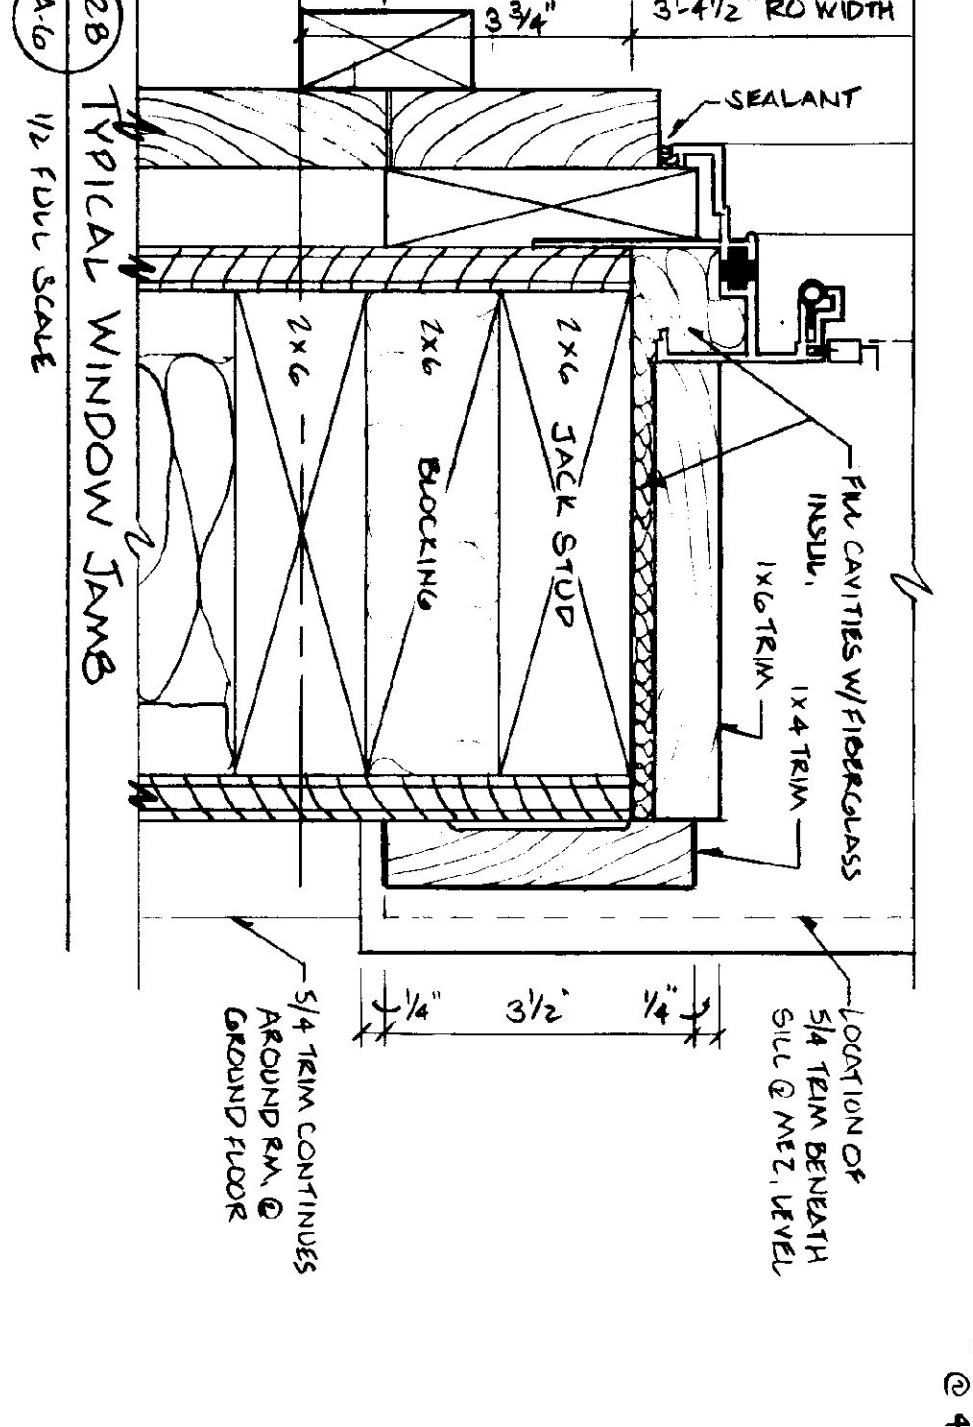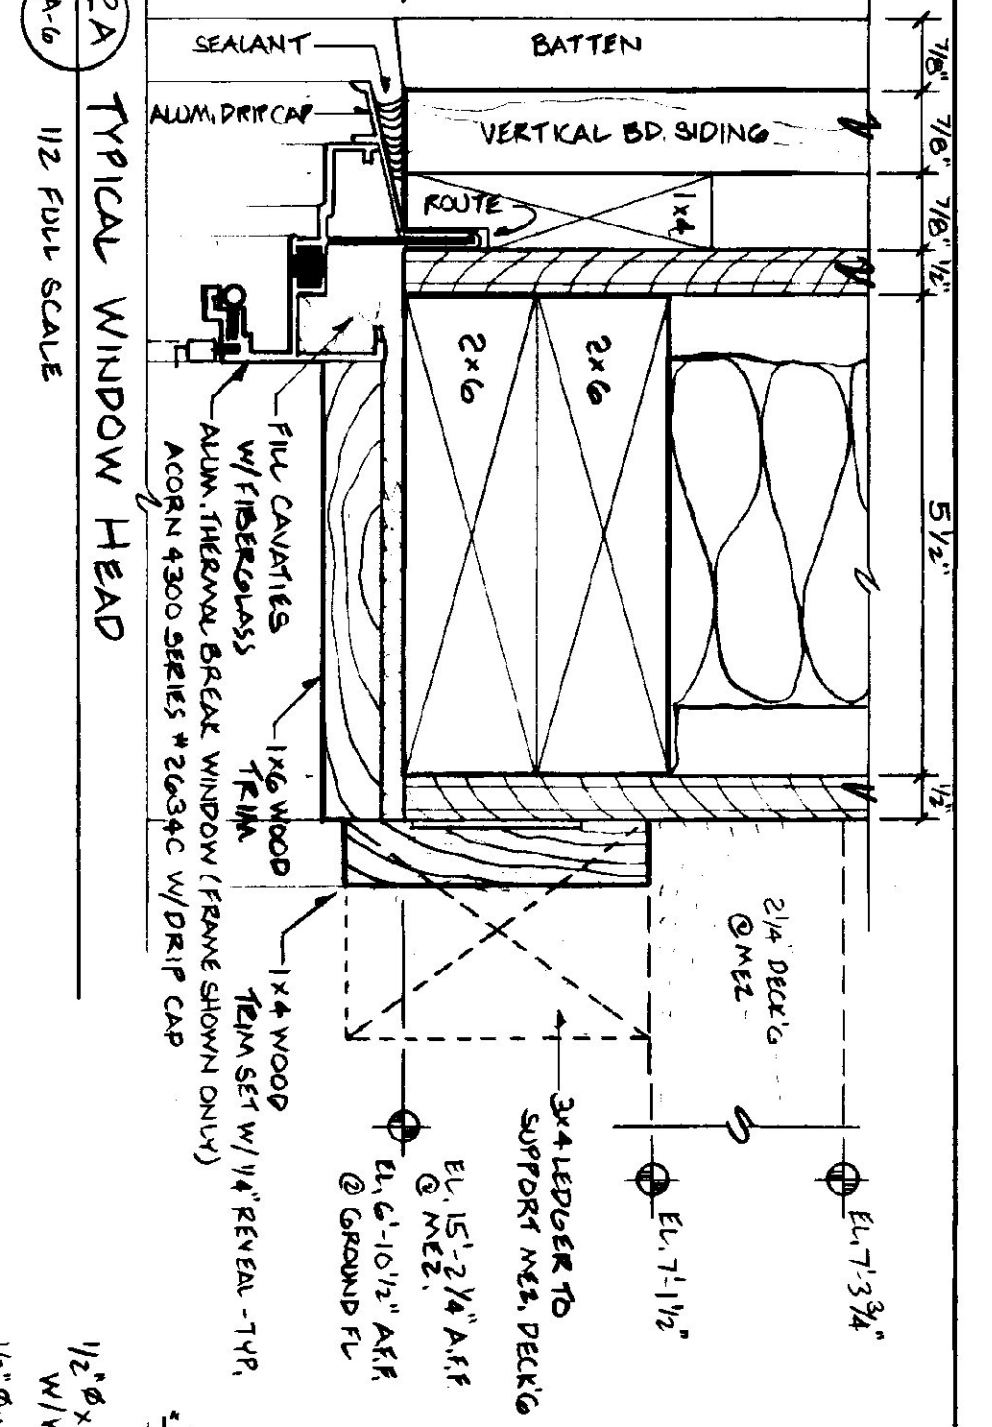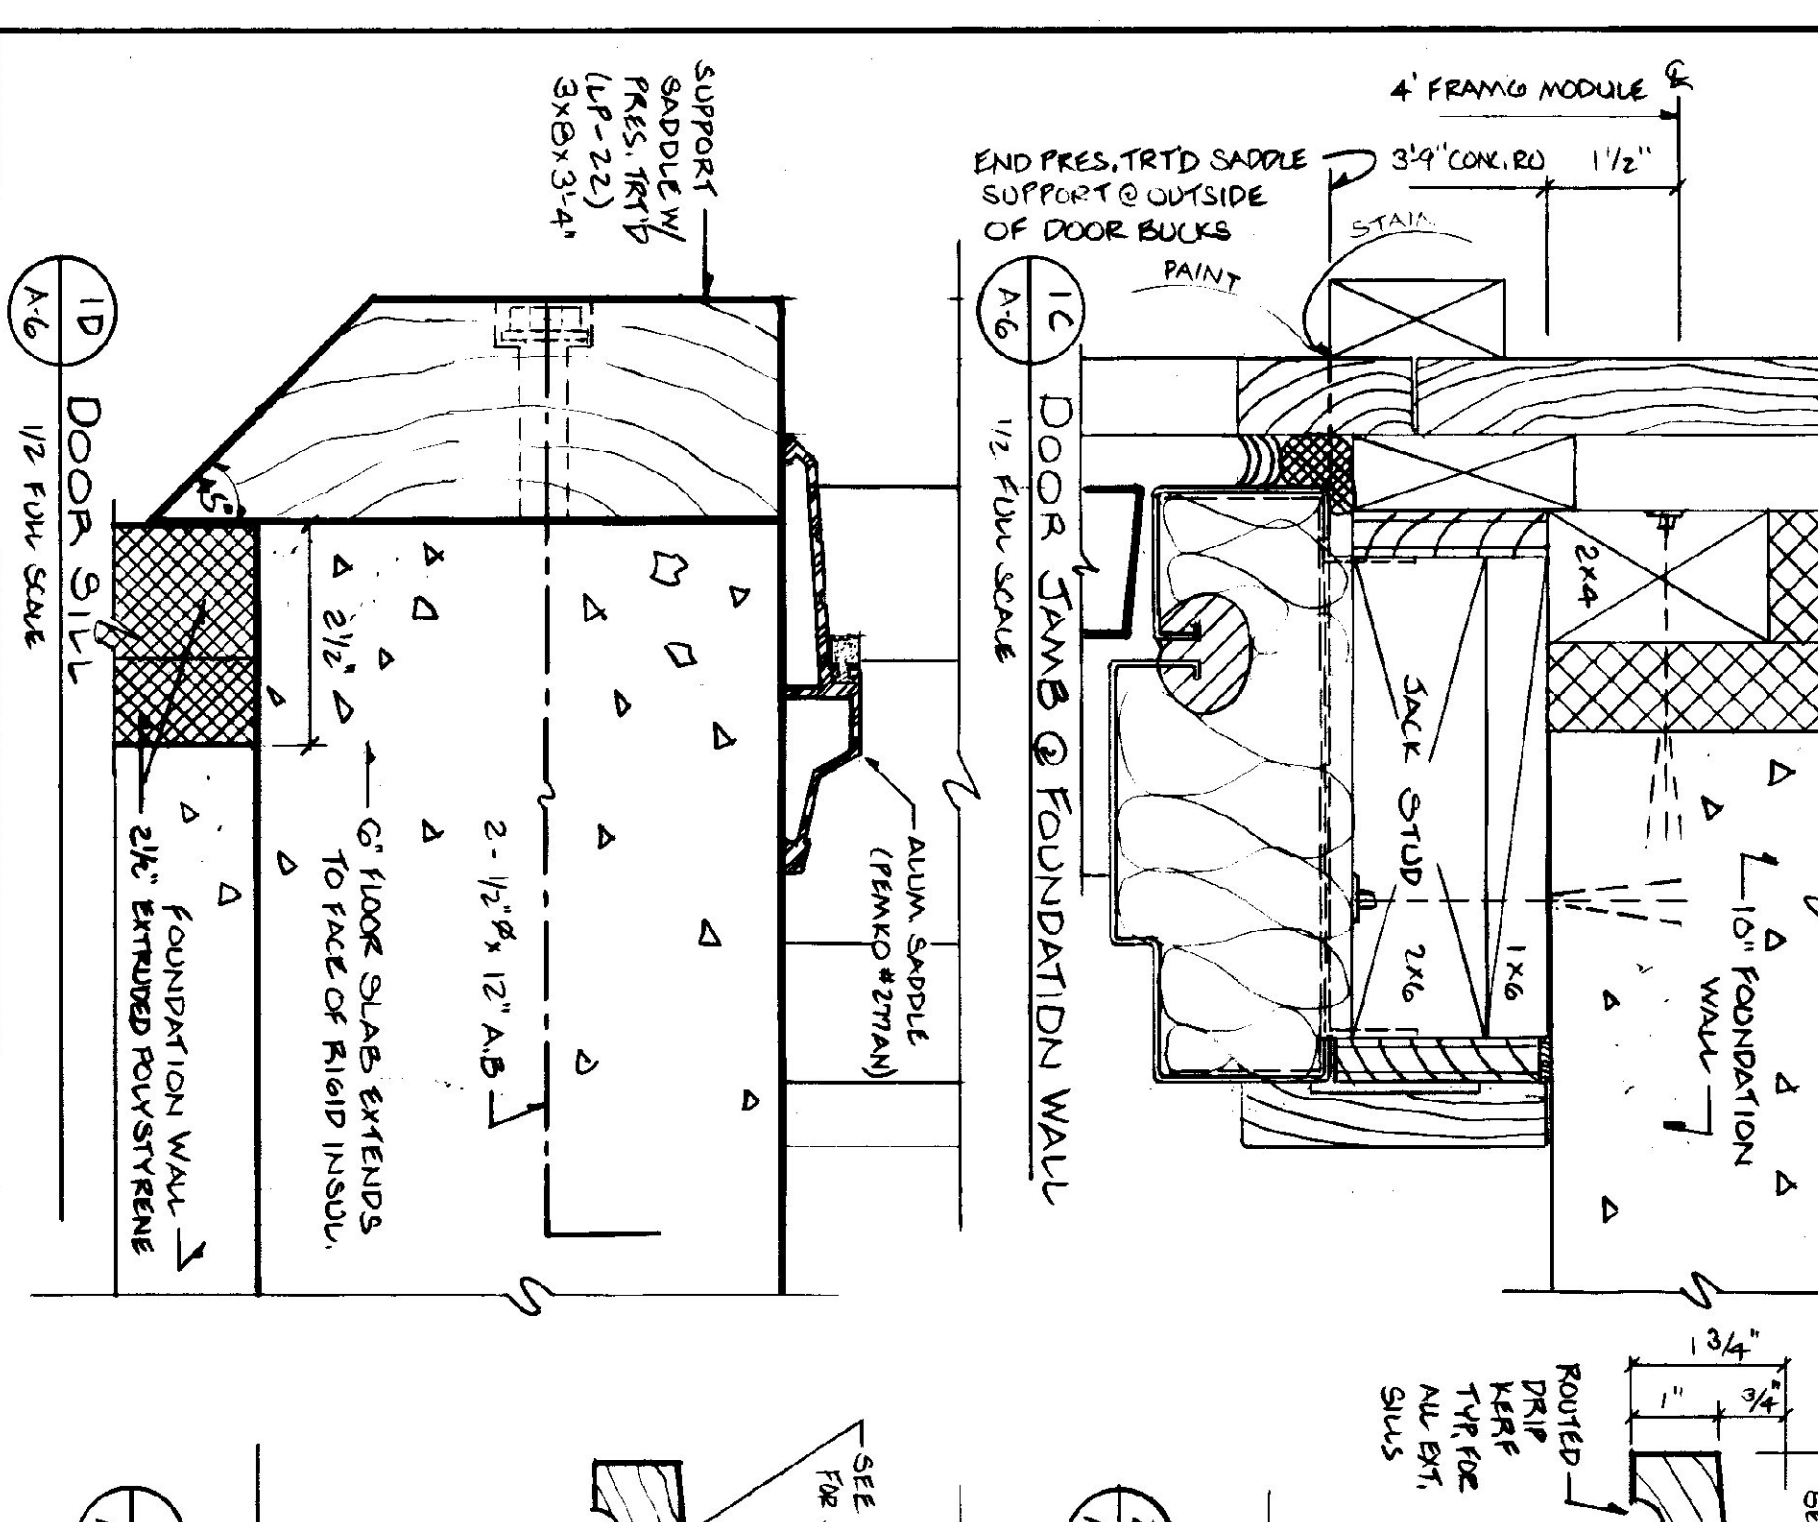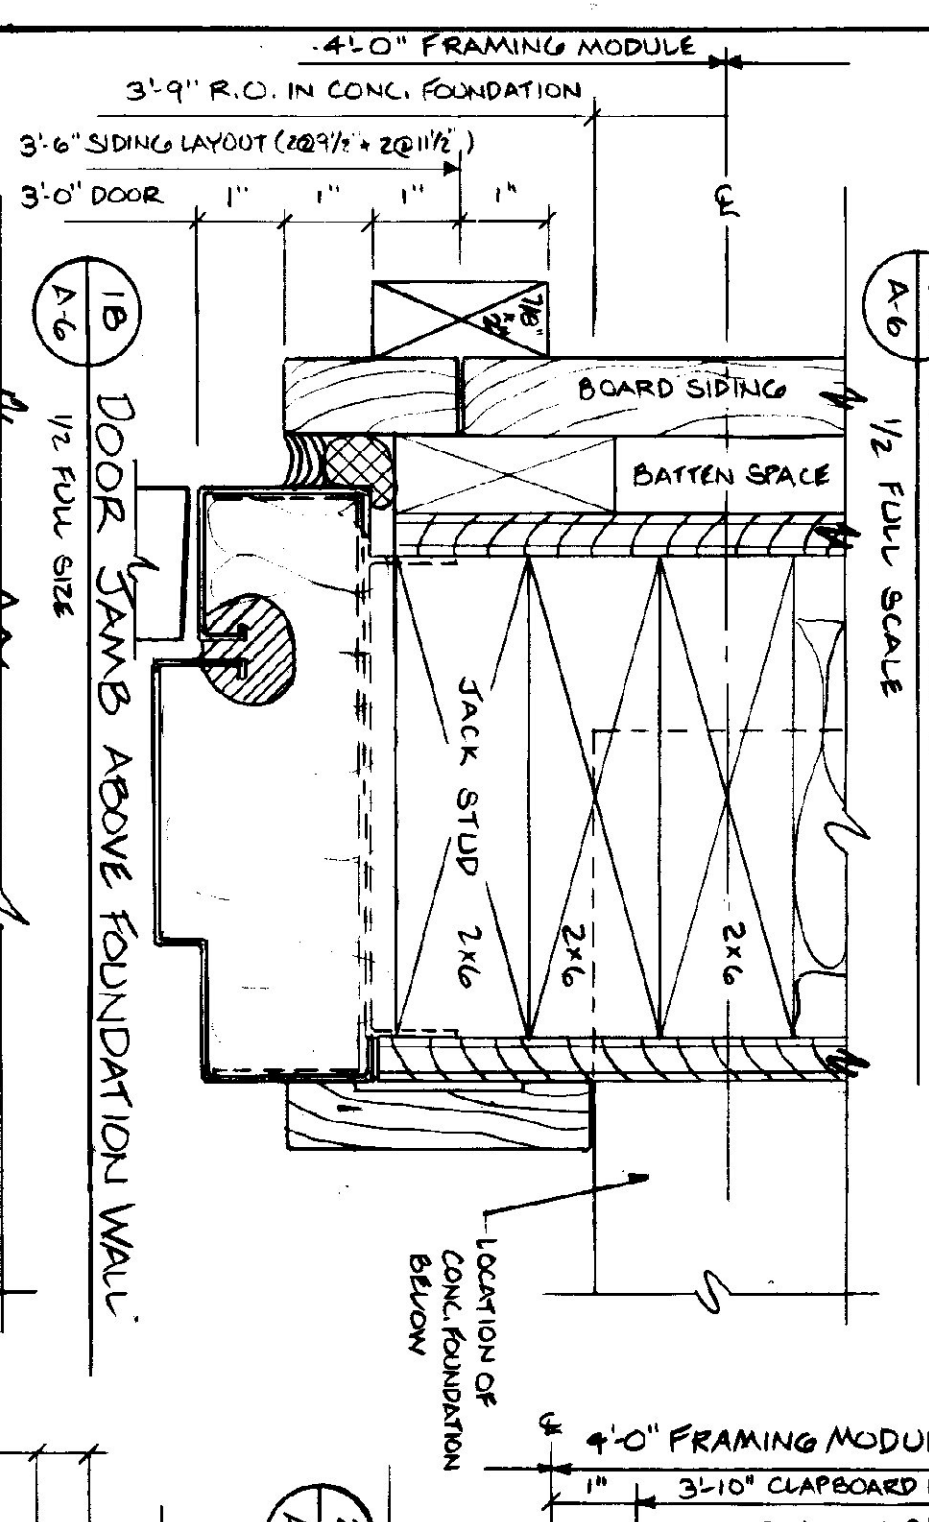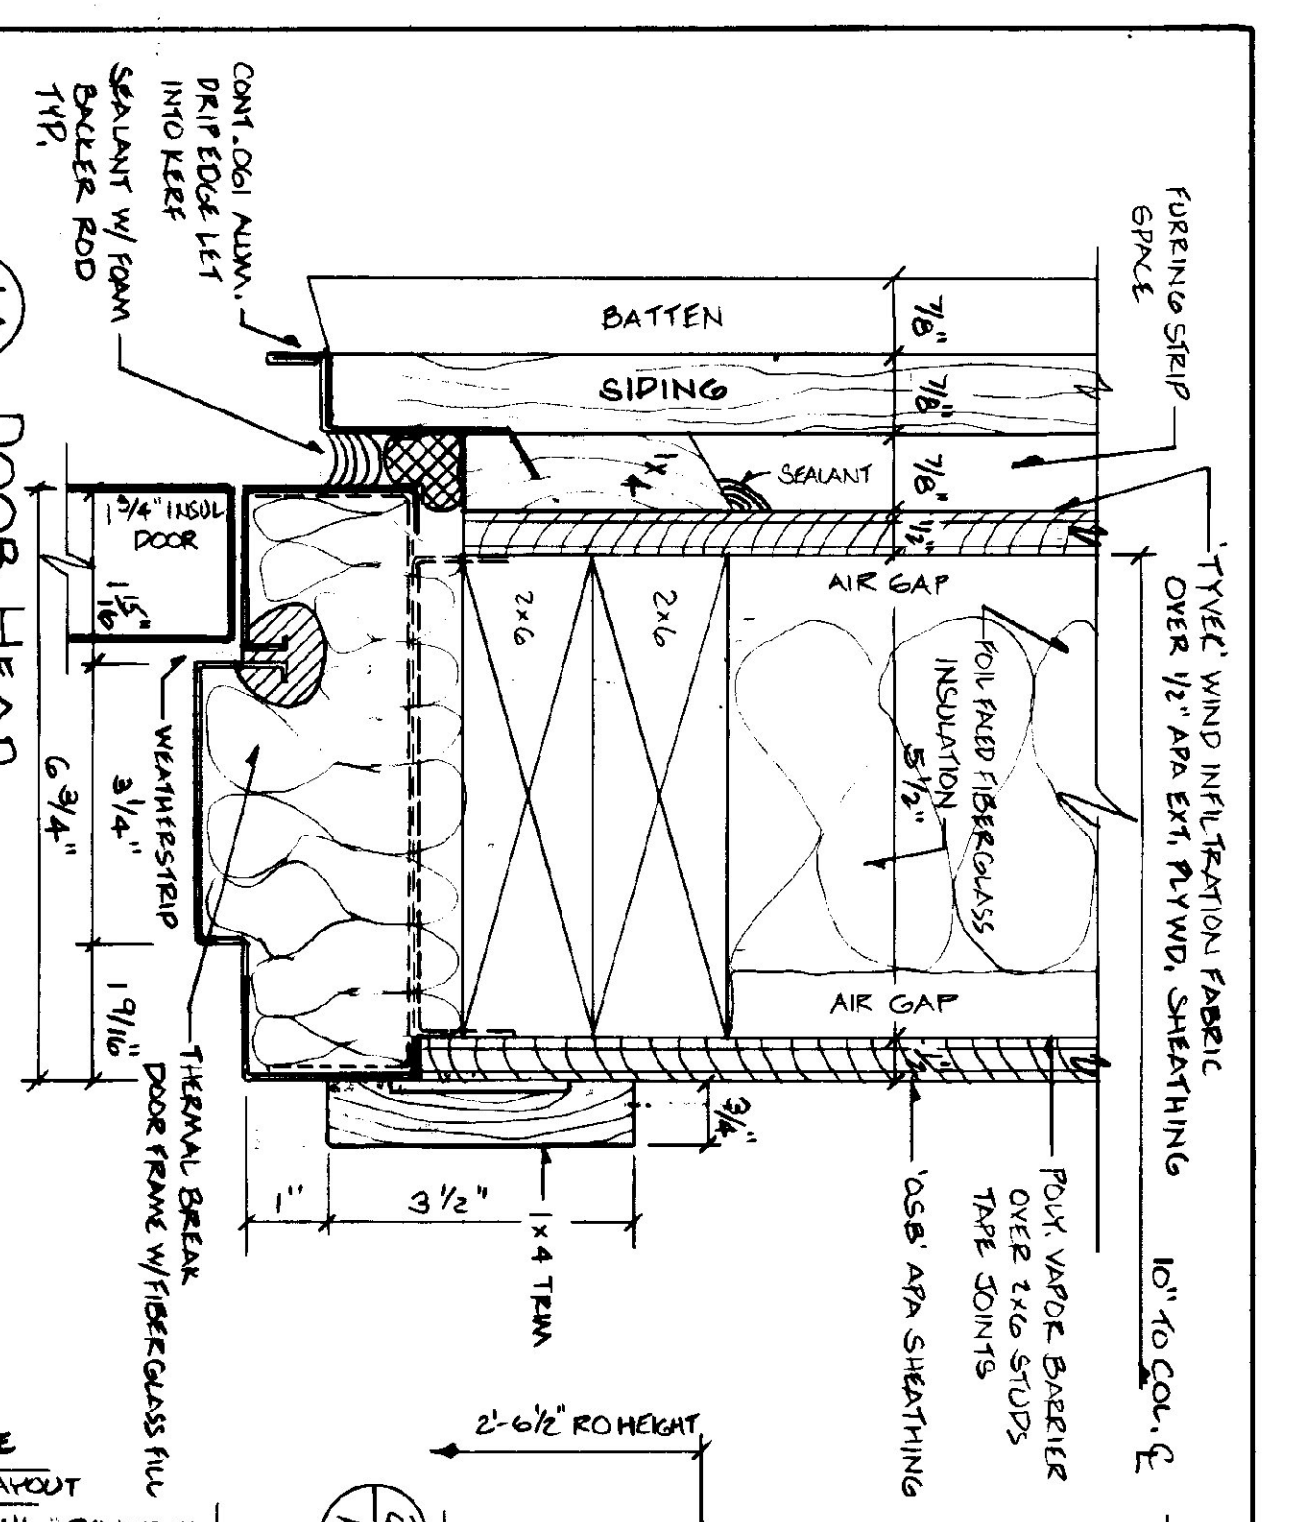

STATE OF VERMONT		DEPARTMENT OF STATE BUILDINGS	
AGENCY OF ADMINISTRATION		AGENCY OF ADMINISTRATION	
MONTPELIER, VERMONT		VERMONT	
AGENCY OF TRANSPORTATION			
MAINTENANCE GARAGE			
EDEN, VERMONT			
EXTERIOR DOORS, WINDOWS & STAIR DETAILS			
DATE	SCALE	APPROVED BY	DRNG NO.
JULY 27, 1994	AS NOTED	PA [Signature]	A-6
DRAWN BY	SCALE	APPROVED BY	DRNG NO.
S. OSTROM	AS NOTED	PA [Signature]	A-6
REVISIONS:		7 OF 13	

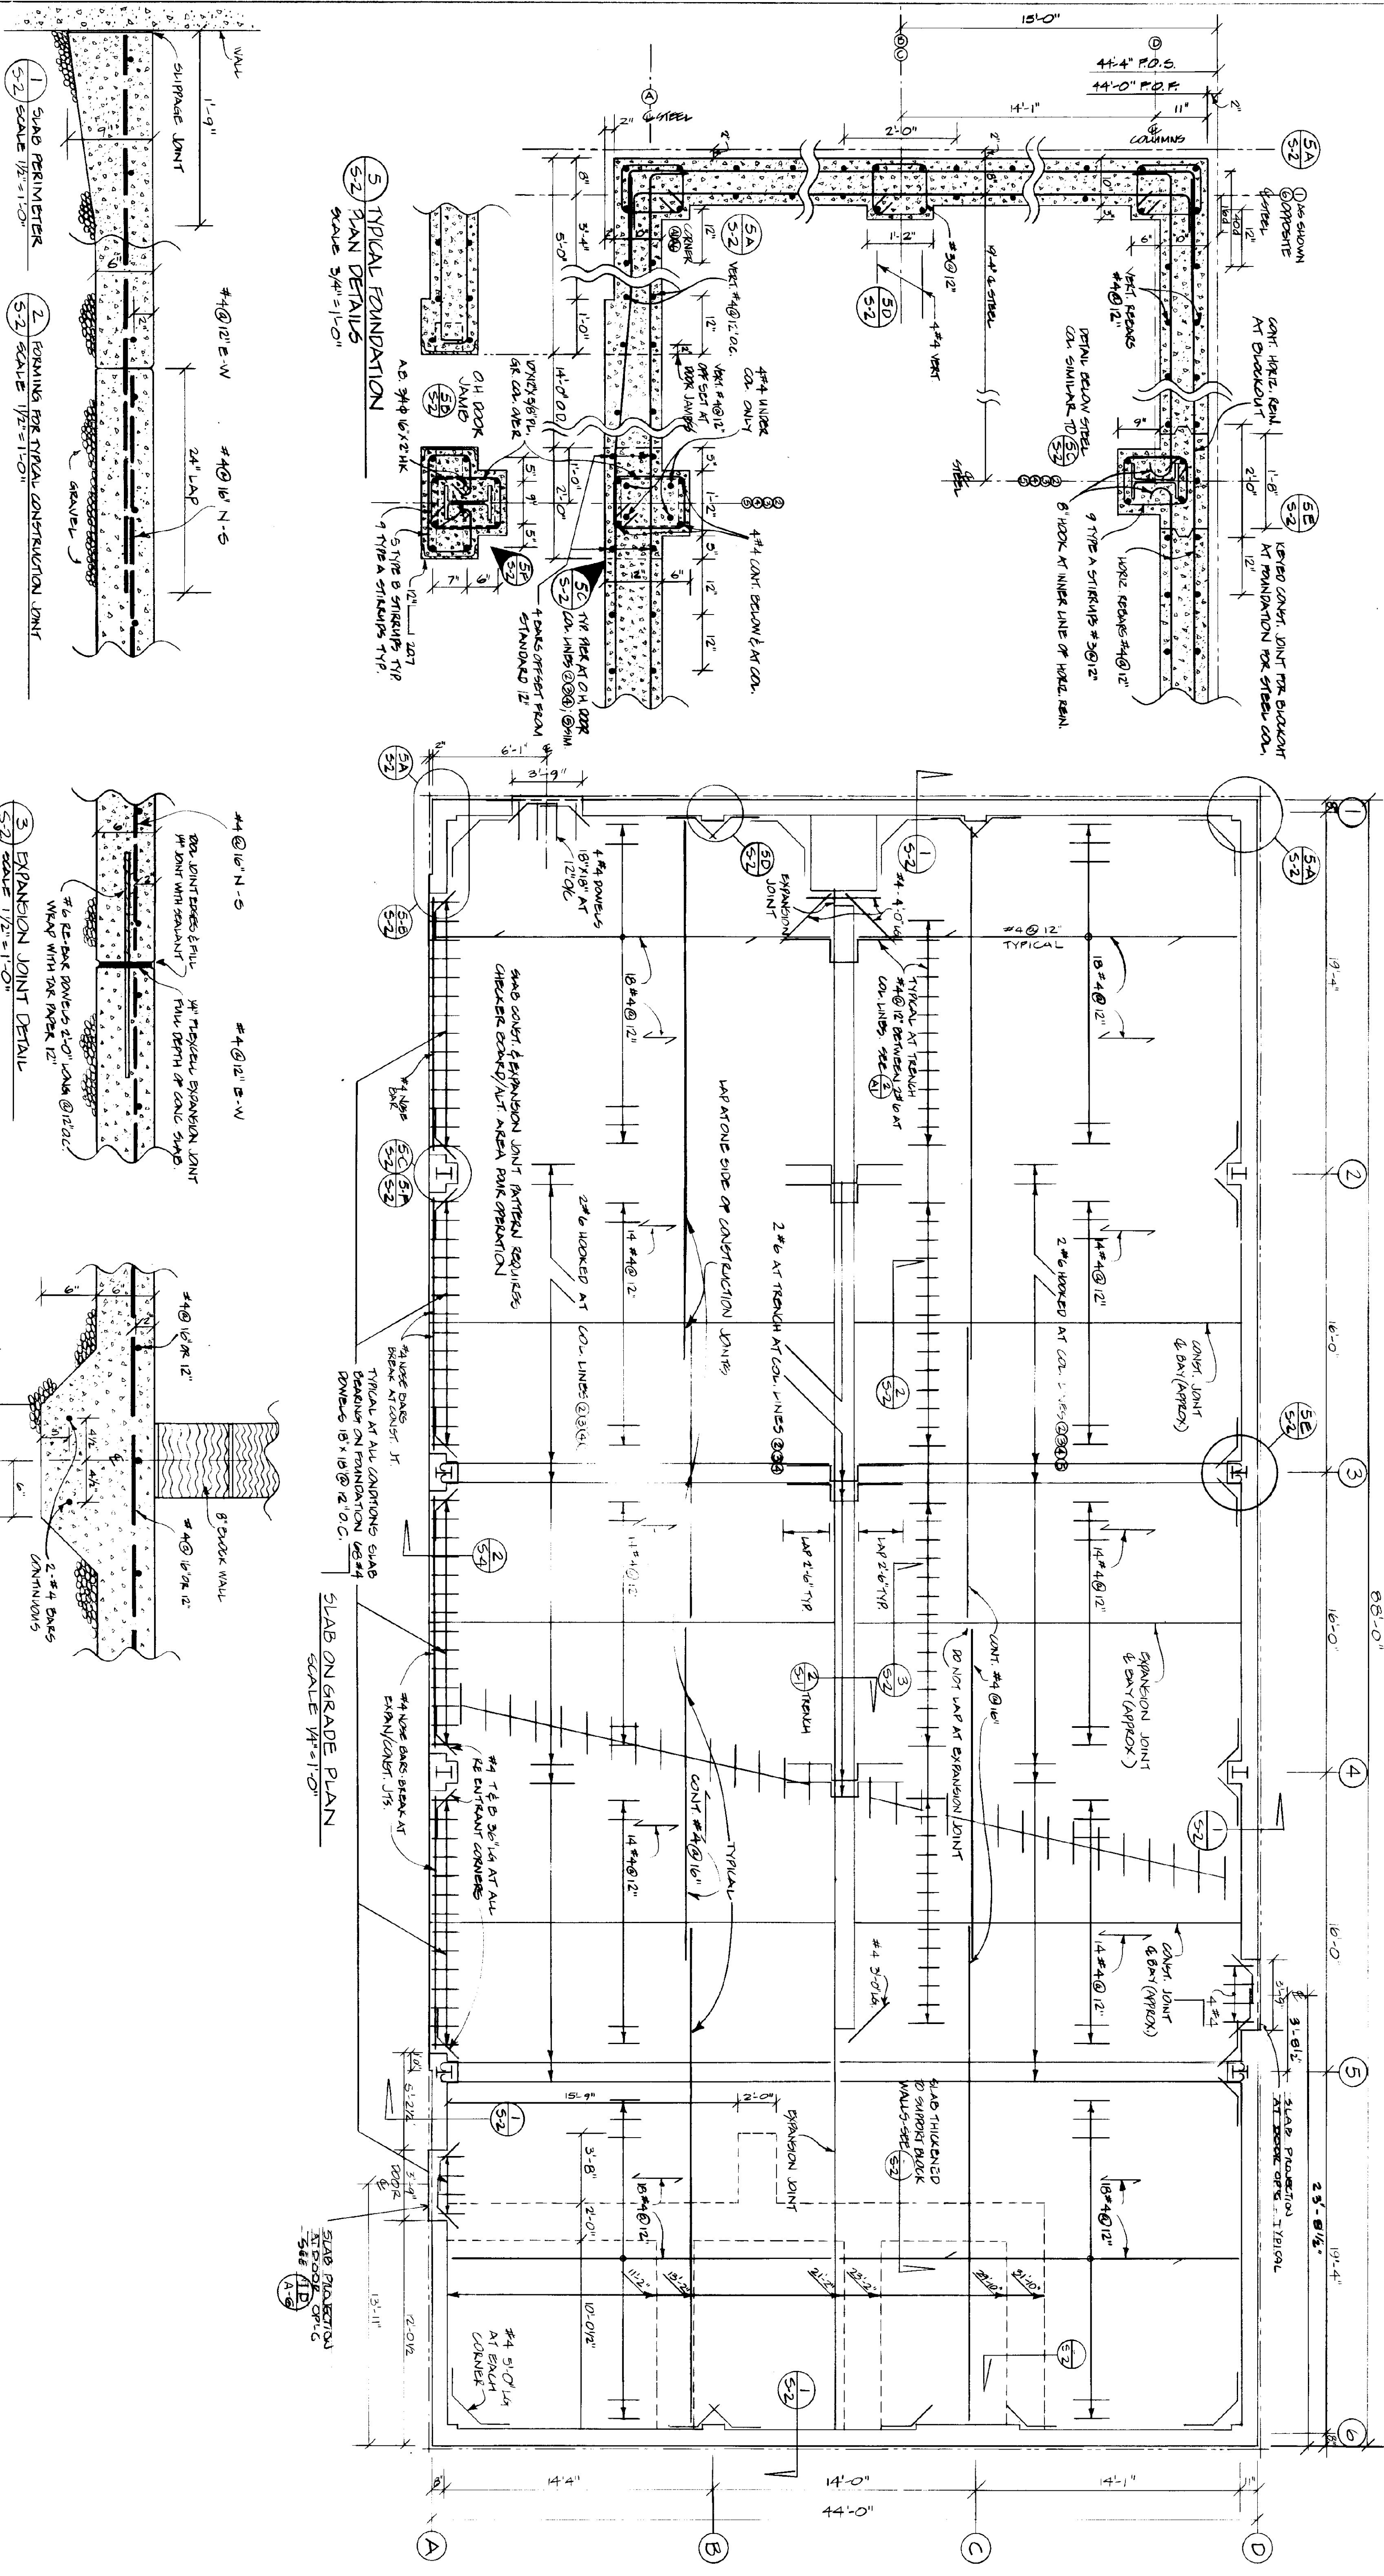


STATE OF VERMONT
 DIVISION OF STATE BUILDINGS
 AGENCY OF ADMINISTRATION
 MONTPELIER, VERMONT

AGENCY OF TRANSPORTATION
 MAINTENANCE GARAGE
 EDEN, VERMONT

GRADE FLOOR SLAB & FOUNDATION DETAILS

DATE	SCALE	REVISIONS	DWG. NO.
JULY 27, 1994	AS SHOWN		S-2
DRAWN BY: A. DOLAN			
APPROVED BY: RA FOR DSB			
			9 OF 13

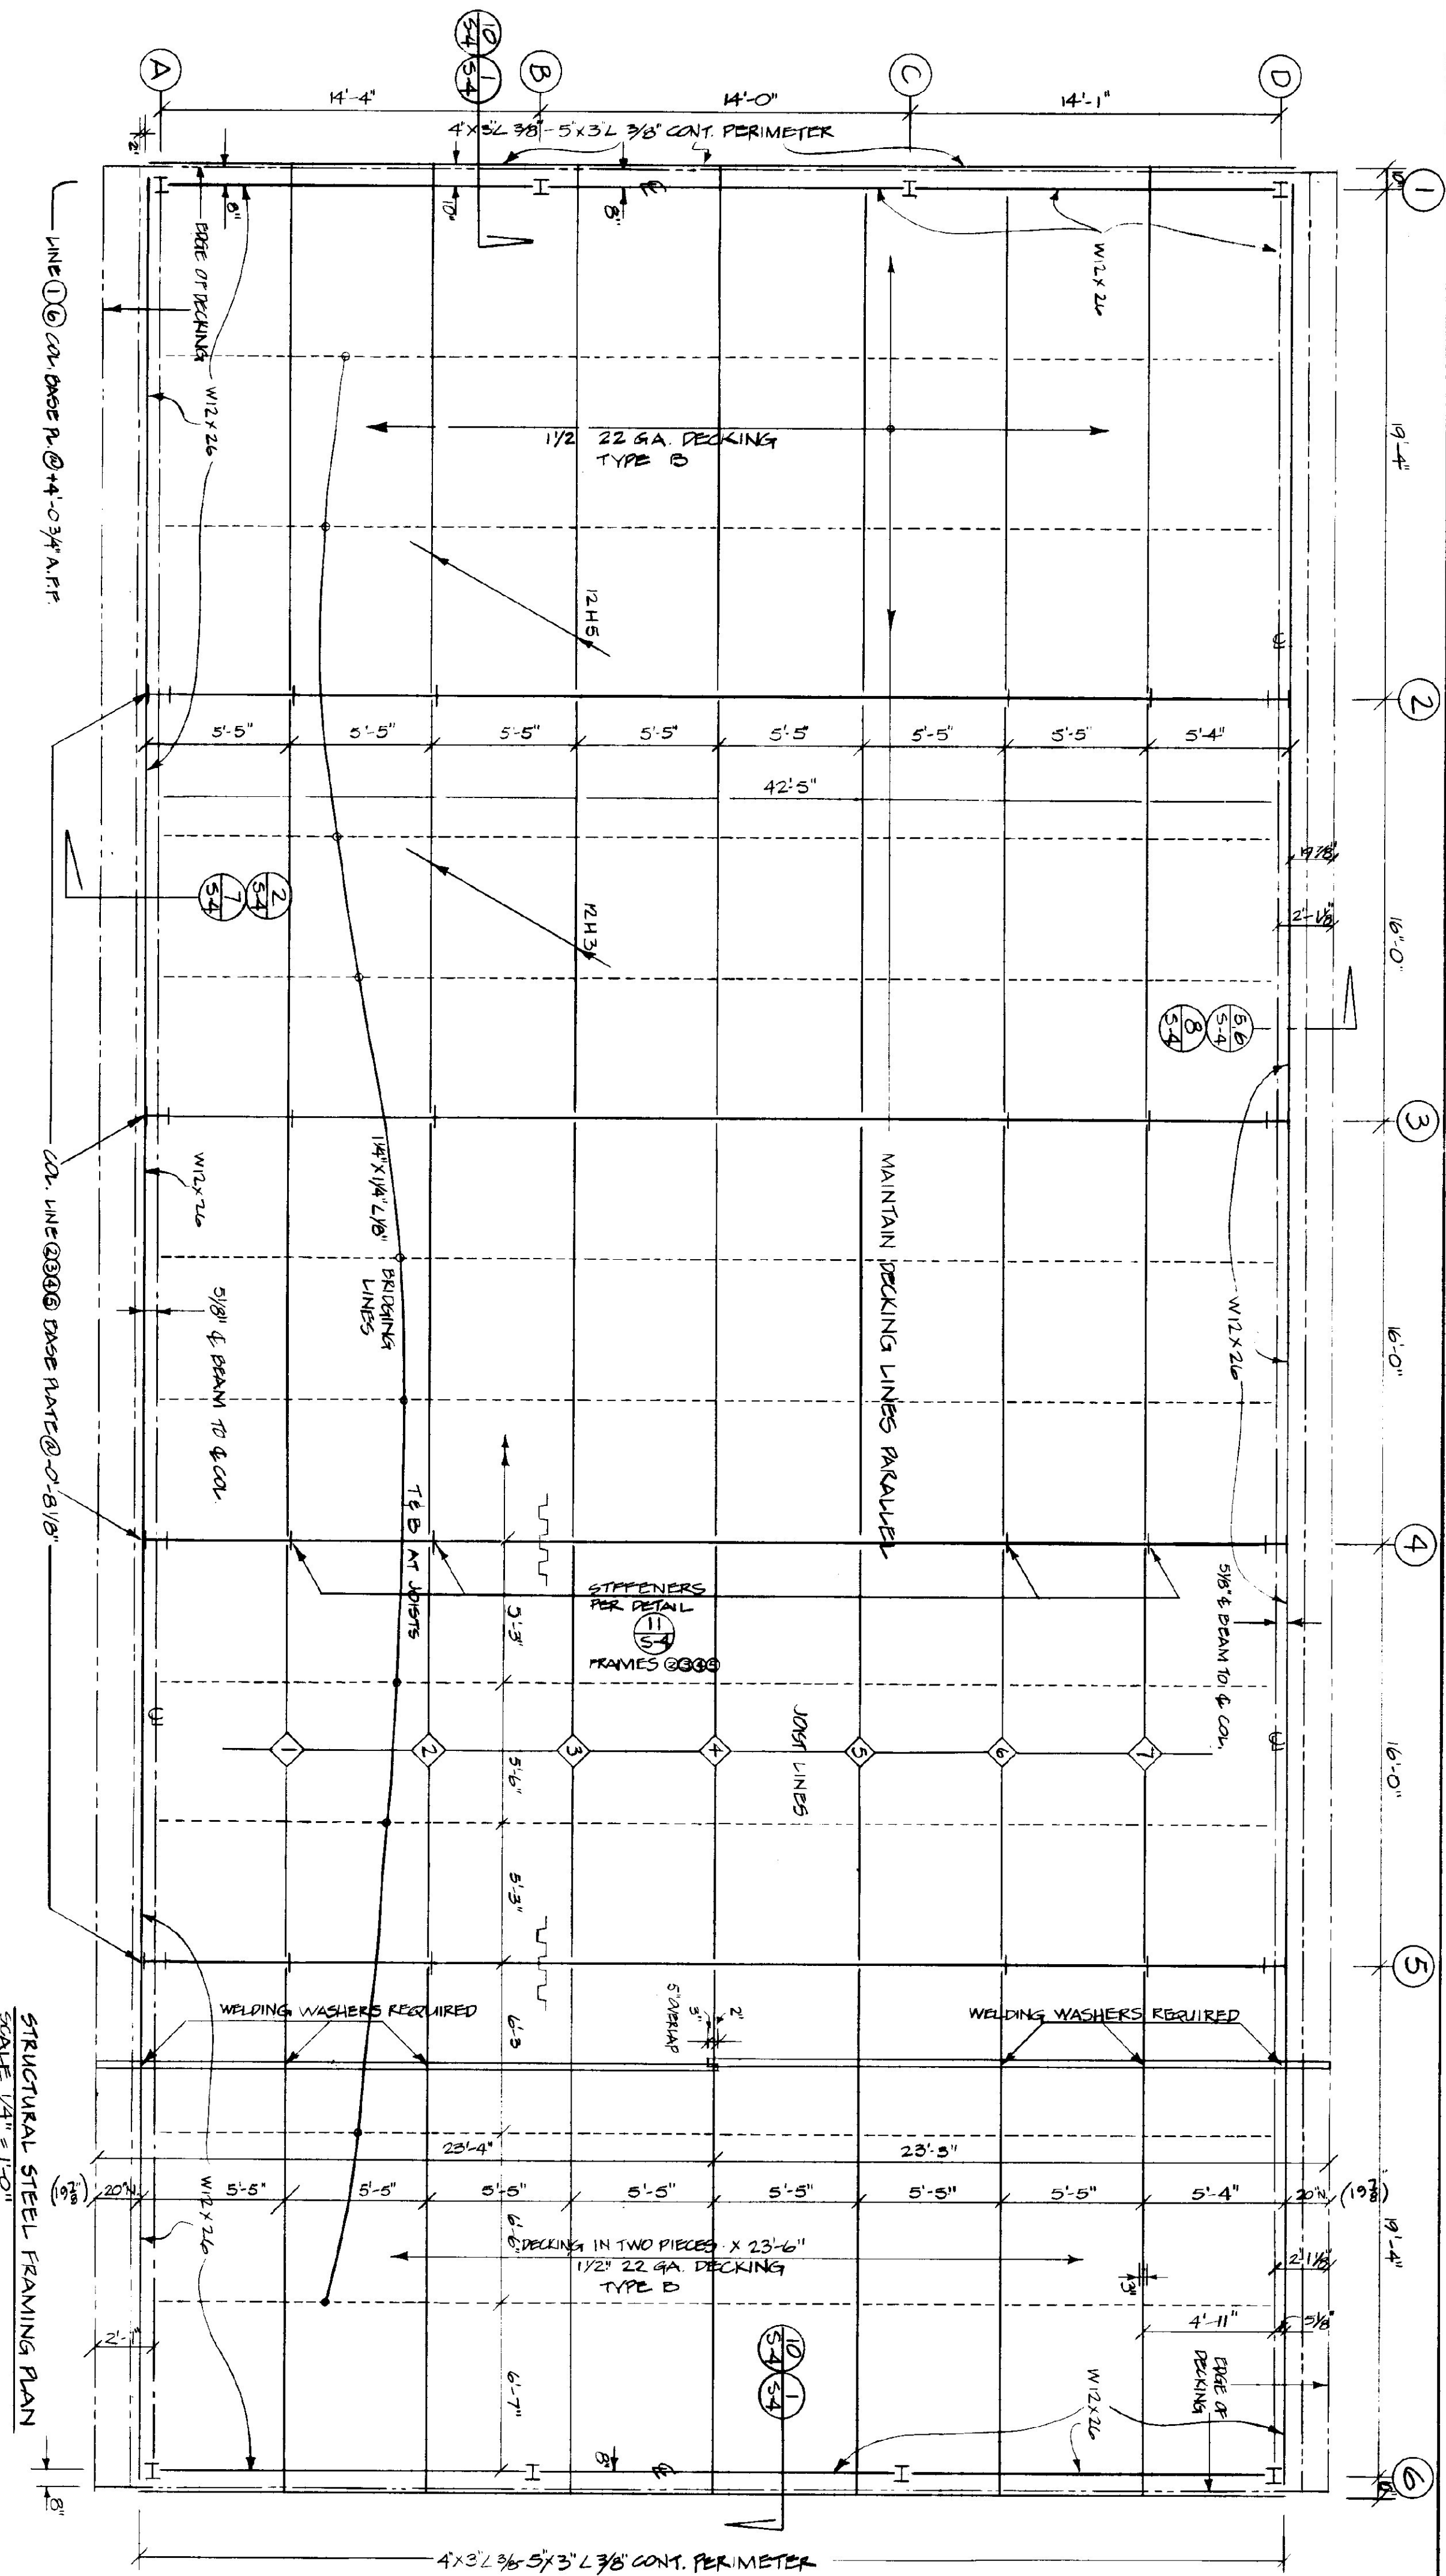

STATE OF VERMONT
 DIVISION OF STATE BUILDINGS
 AGENCY OF ADMINISTRATION
 MONTPELIER, VERMONT

AGENCY OF TRANSPORTATION
 MAINTENANCE GARAGE
 EPHEN VERMONT
 ROOF FRAMING

DATE:	JULY 27, 1984	SCALE:	AS NOTED	REVISIONS:	DWG. NO.
DRAWN BY:	A. PAULIN	APPROVED BY:	PAULIN		5-3
					10 OF 13

