


MECHANICAL PLAN
SCALE: 1/4" = 1'-0"

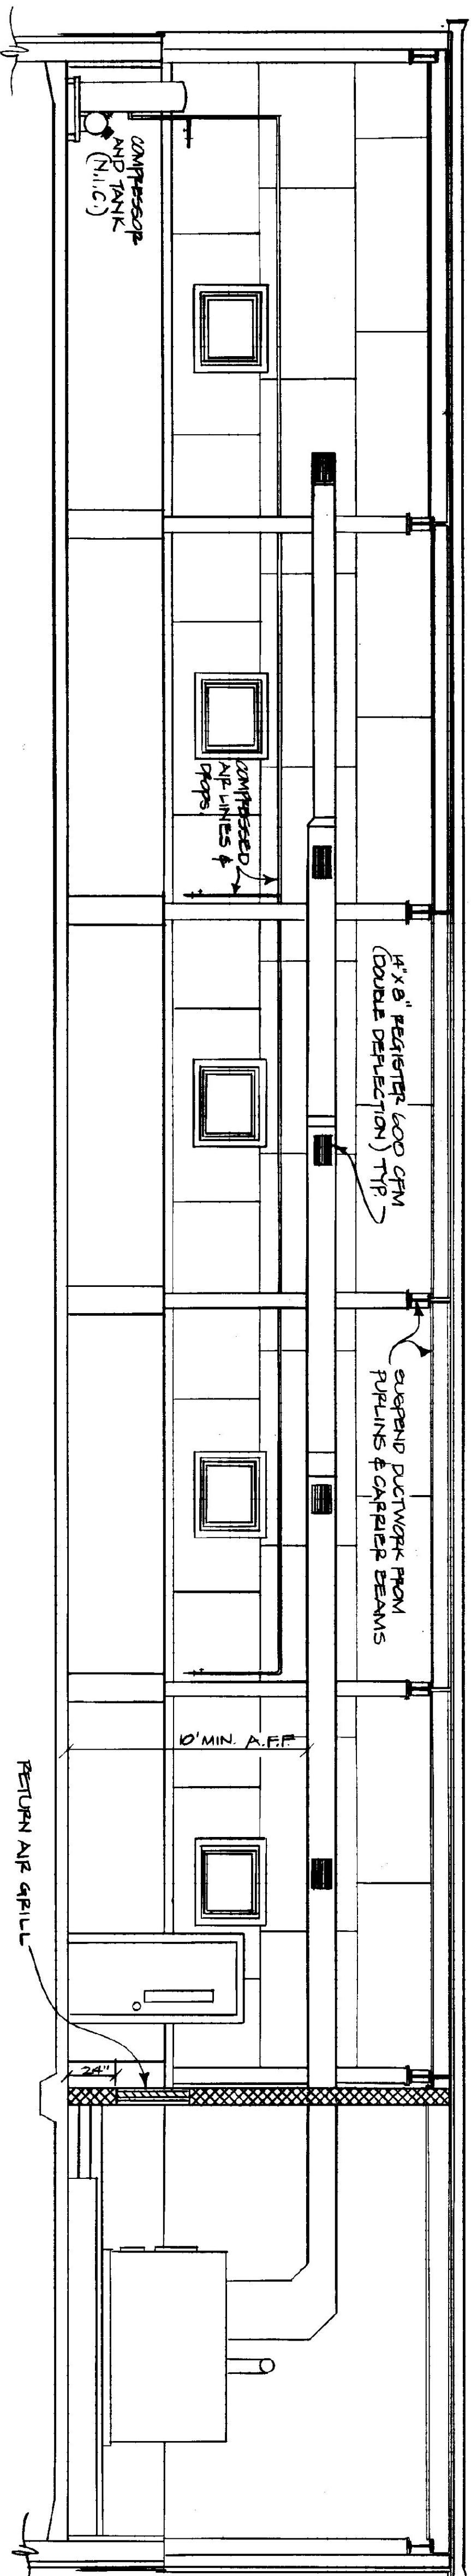

FURNACE & DUCTWORK ELEVATION
SCALE: 1/4" = 1'-0"

- NOTES:
- (1) FURNACE BLOWER MOTOR 1.0 HP 115/230V.
 - (2) STORAGE TANK FOR HOT WATER FROM FURNACE SHALL HAVE BRONZE CIRCULATING PUMP W/ONE LOOP FROM TANK TO FURNACE.
 - (3) ALL JOINTS IN FUEL OIL LINE TO BE FLANGED, ALL SOLDERED JOINTS TO BE SWEATED WITH SILVER SOLDER.

STATE OF VERMONT
DEPARTMENT OF STATE BUILDINGS
AGENCY OF ADMINISTRATION
MONTPELIER, VERMONT

HEATING PLAN
VERMONT AGENCY OF TRANSPORTATION
\$ BAY MAINTENANCE GARAGE
VERMONT
ENOSBURG FALLS,

DATE:	SCALE:	REVISIONS:	DWG. NO.
MAY 20, 1991	1/4" = 1'-0"	7/9/91 FANS AVP	H-1
DRAWN BY:	APPROVED BY:		
A. FOULIN			21 OF 24