




DEMOLITION PLAN  
SCALE: 3/16"=1'-0"

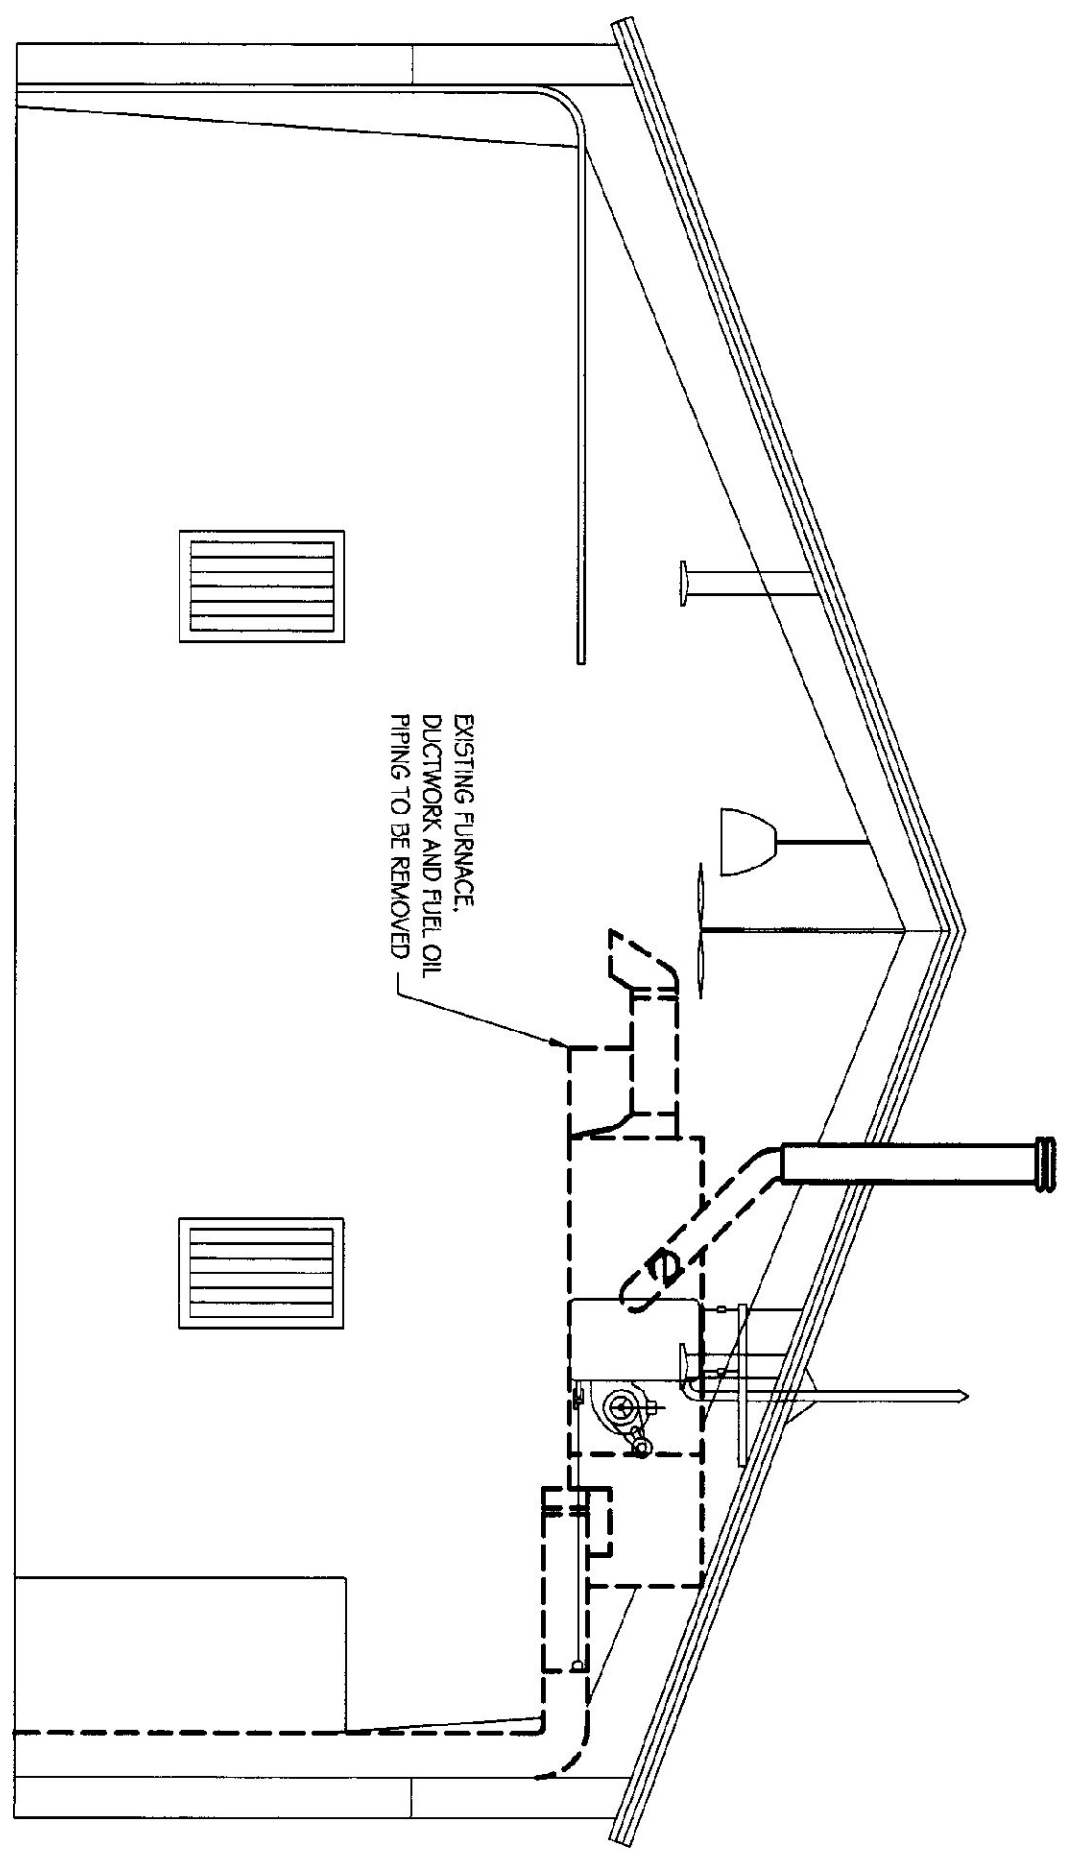

SECTION A-A DEMOLITION  
SCALE: 1/4"=1'-0"

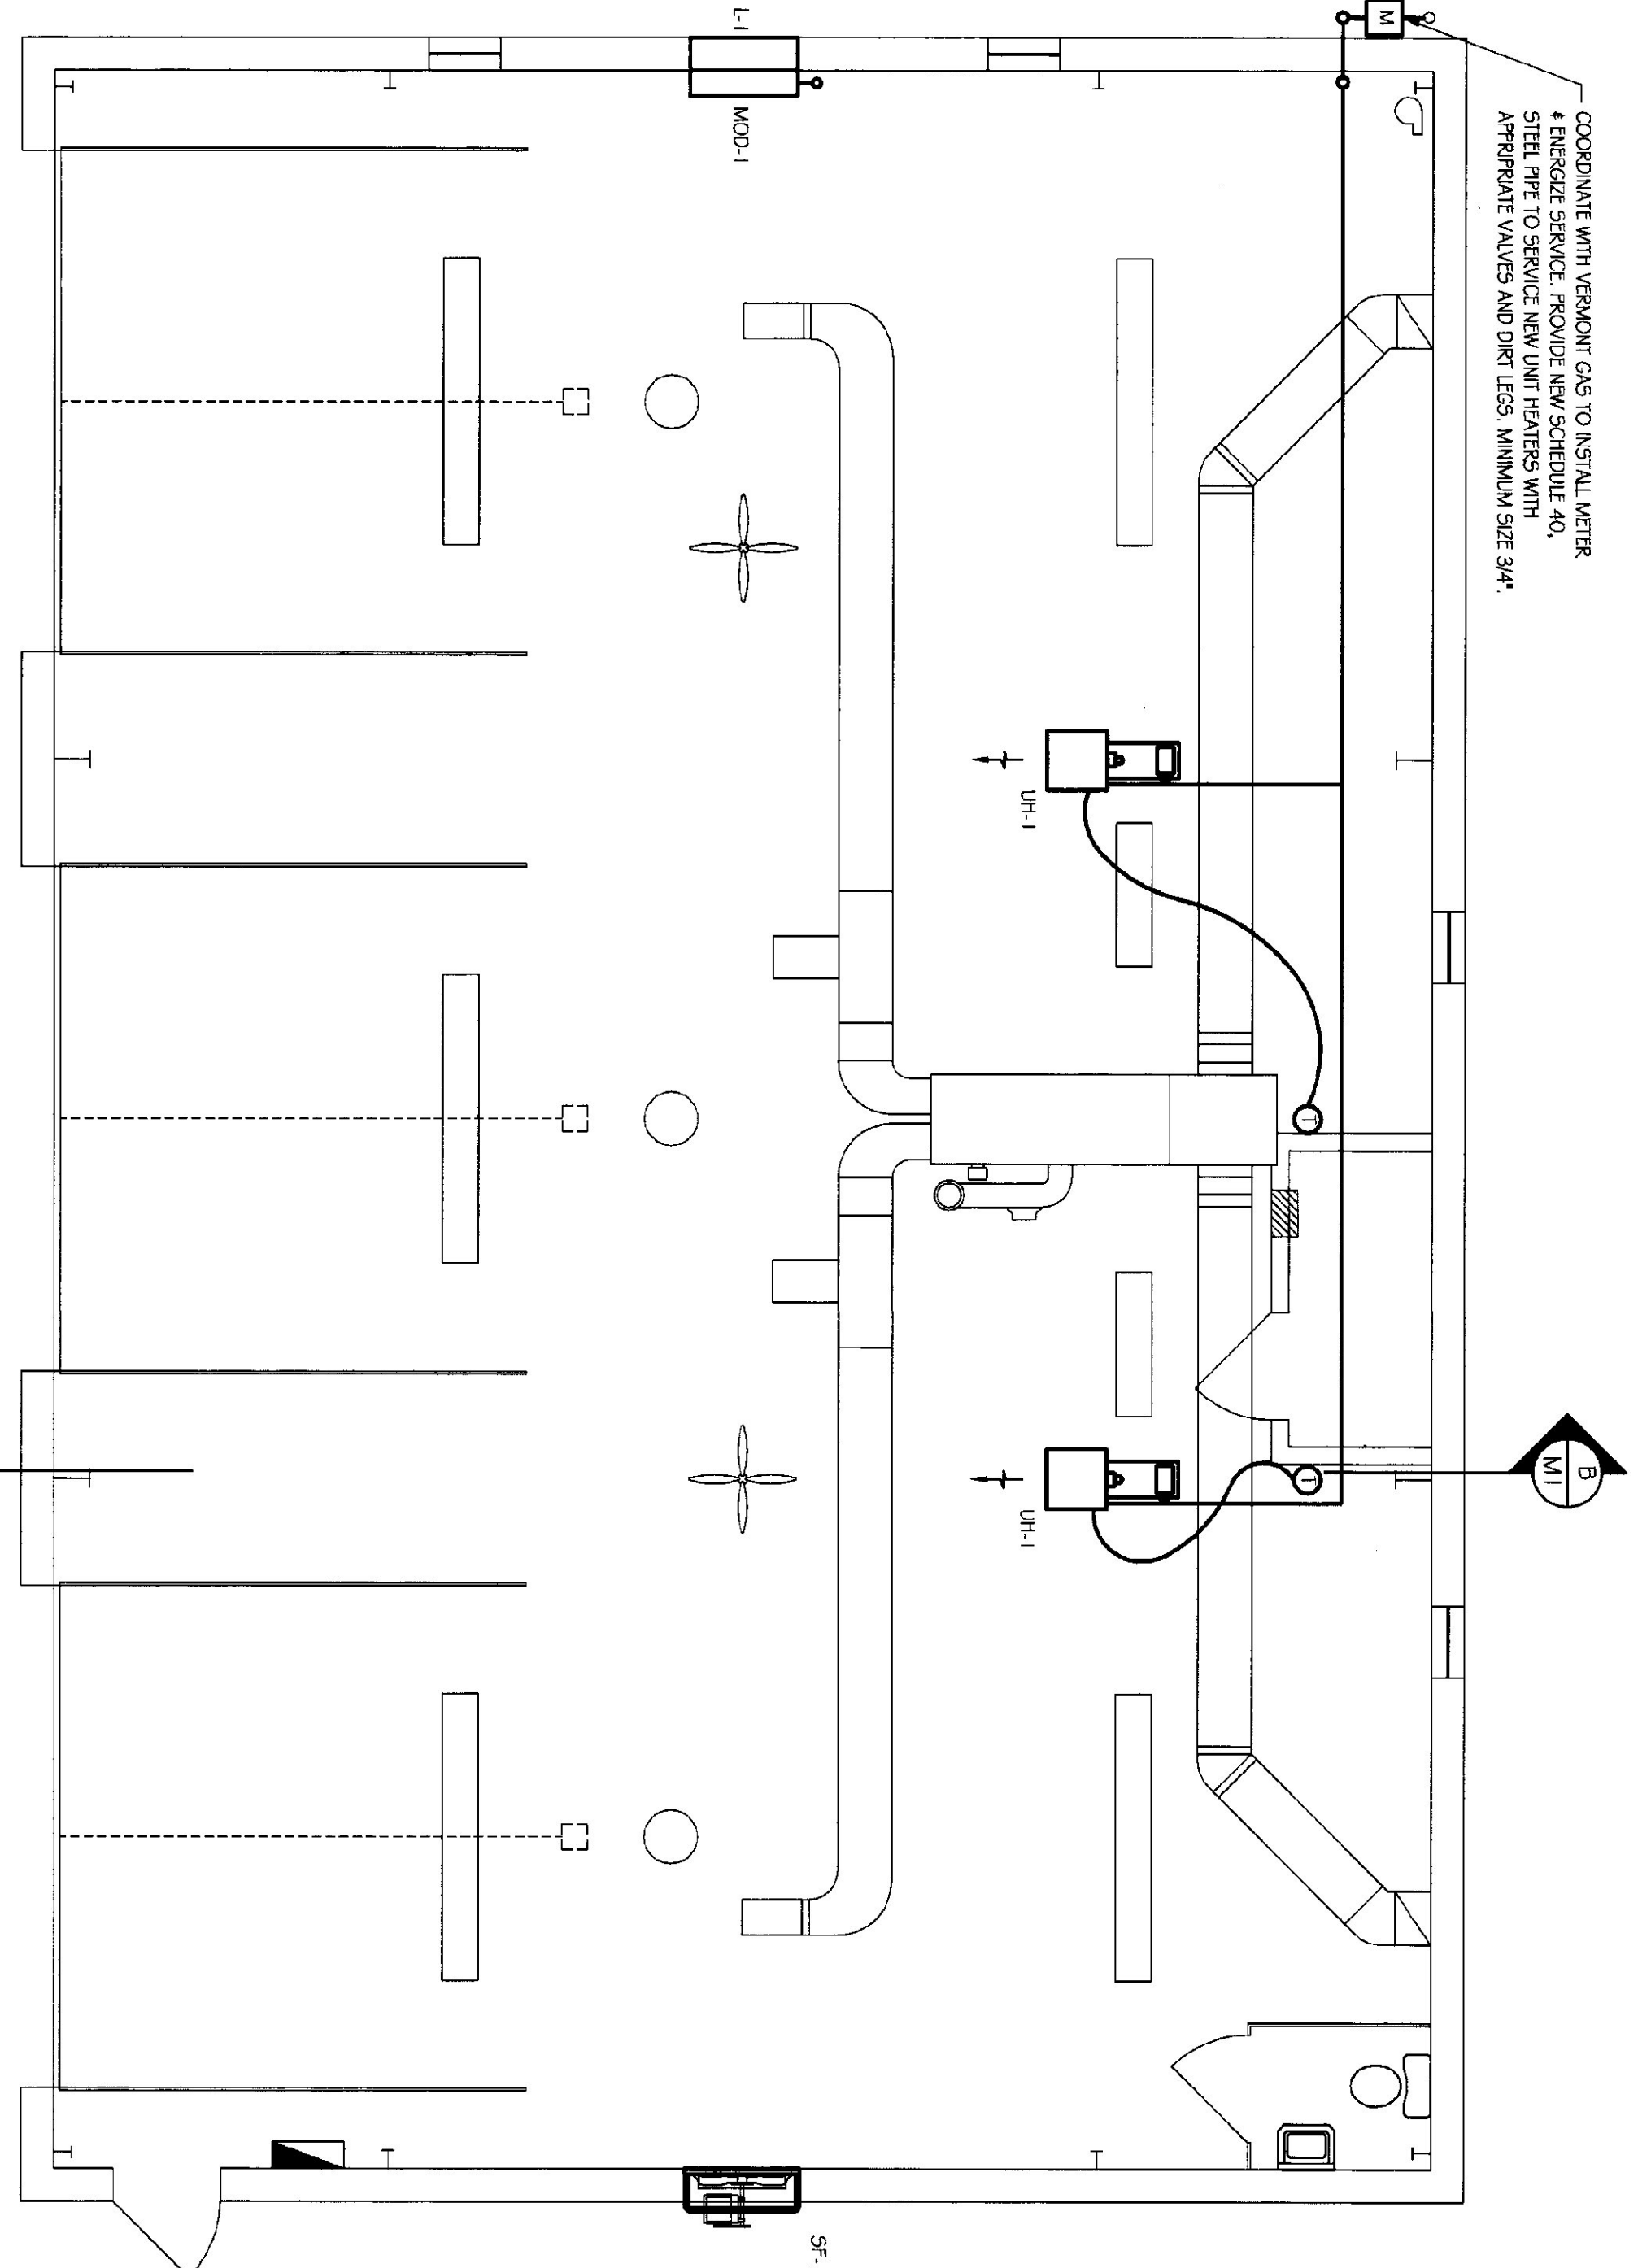

NEW HEATING PLAN  
SCALE: 1/4"=1'-0"

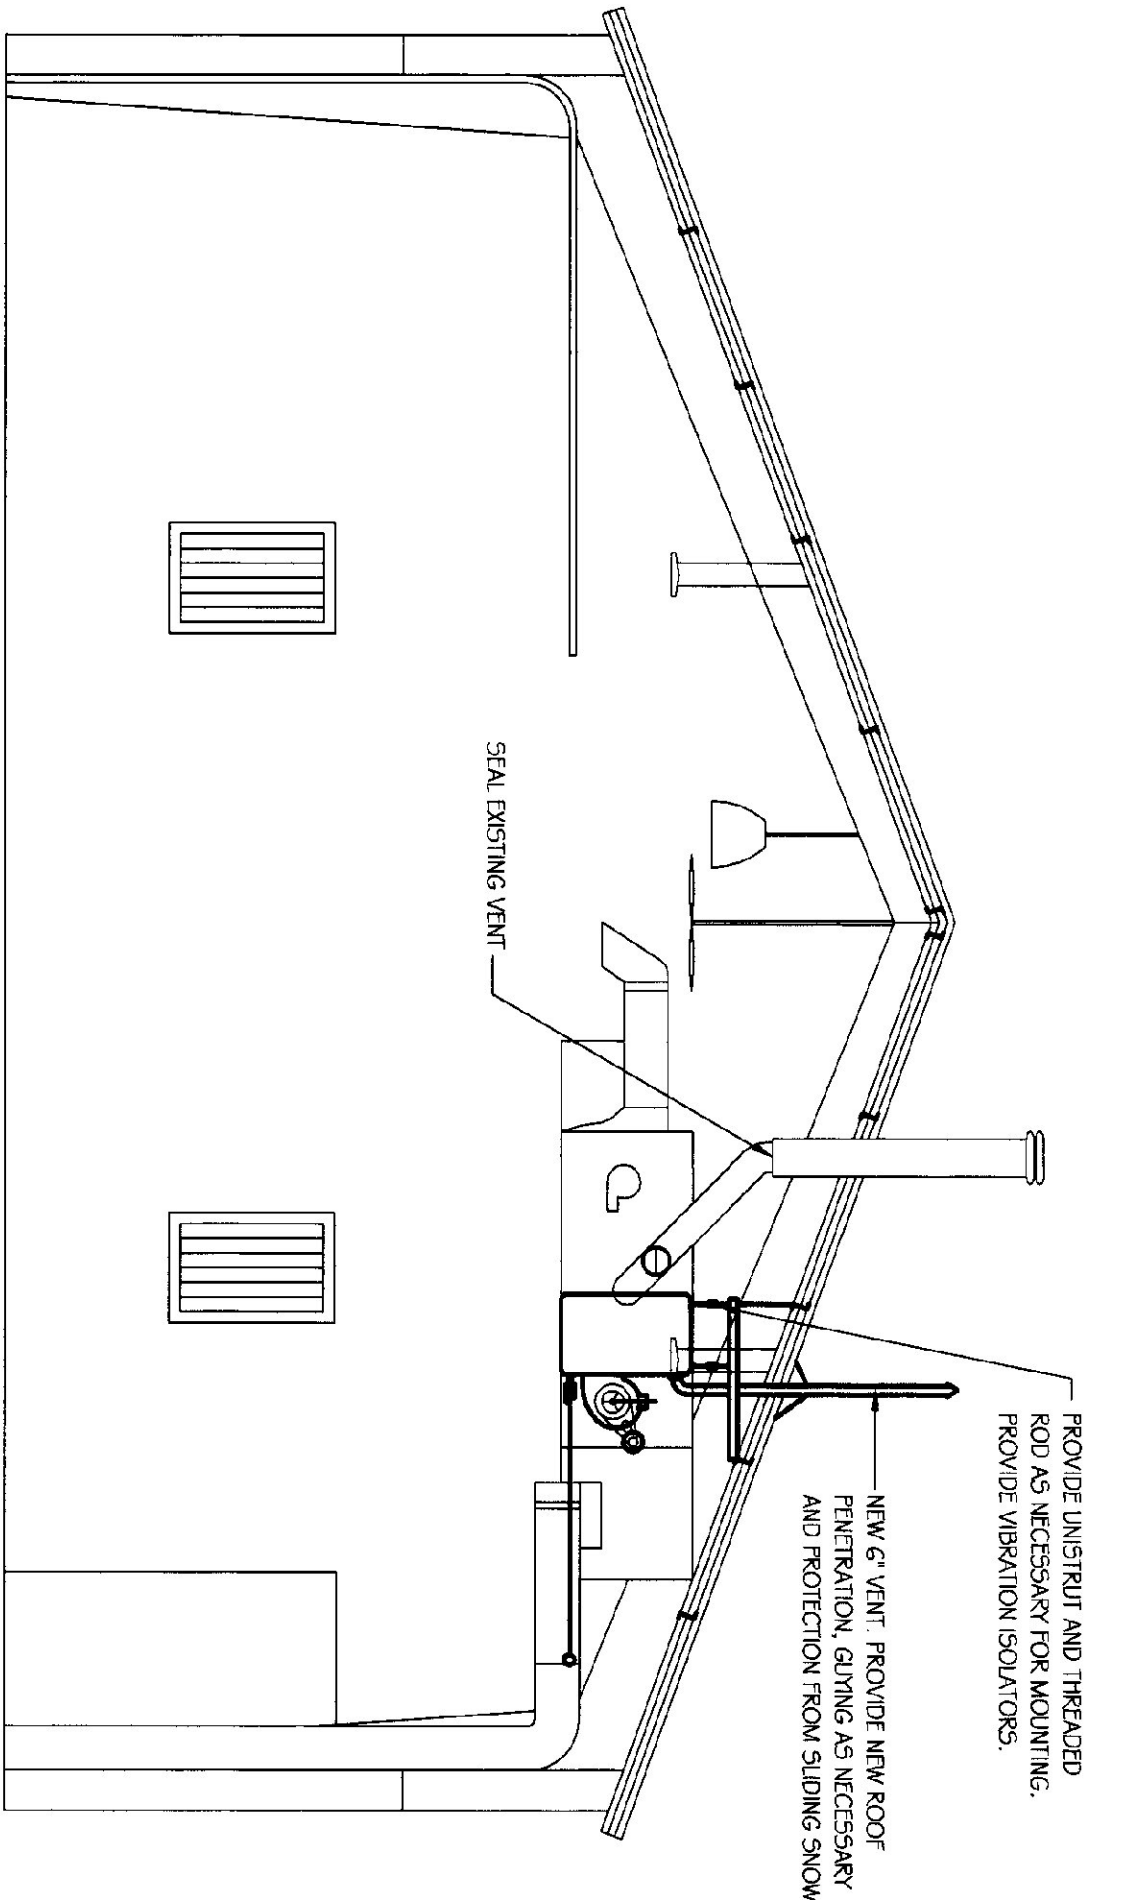

SECTION B-B NEW HEATING SYSTEM  
SCALE: 1/4"=1'-0"

ITEM SYMBOL	DESCRIPTION	MANUFACTURER/MAKE	CHARACTERISTICS	ELECTRICAL	NOTES
UH-1	GAS UNIT HEATER	MORNING STAR	MANUFACTURE NUMBER: KMDRNE 30125	1/4 HP, 120 V, 1Ø	INSTALL IN ACCORDANCE WITH MANUFACTURER'S INSTRUCTIONS AND VDMA 54
SE-1	GREENHICK GARAGE VENTILATOR	GREENHICK	585-1120-4	3360 CFM, 0.125 IN. L31 SCREENS, 21.6 IN. W.	W/IT WEATHERWOOD SCREEN MOD
L-1	RELIEF LOUVER	VENTRODUCTS	2750	36x36	
MOD-1	RELIEF DAMPER	VENTRODUCTS	5703	36x36	DELTA DIRECT COUPLED ACTUATOR SPRING WOUND N.C.

EQUIPMENT SCHEDULE

COORDINATE WITH VERMONT GAS TO INSTALL WATER METER SERVICE. PROVIDE NEW SCHEDULE 40 STEEL PIPE TO SERVICE NEW UNIT HEATERS WITH APPROPRIATE VALVES AND DIRT LENS. MINIMUM SIZE 3/4".

AOT MAINTENANCE GARAGE - DISTRICT 8  
HVAC RENOVATION  
PLANS AND SECTIONS



STATE OF VERMONT  
Department of Buildings  
and General Services  
Agency of Administration  
Montpelier, Vermont



<p>1 OF 1</p> <p style="font-size: 2em; font-weight: bold;">M1</p>	SCALE:	AS NOTED	REVISIONS   
	DATE:	11/2002	
	DRAWN BY:	T. DREW	
	APPR. BY:	T. SOUTHWORTH	

AOT MAINTENANCE GARAGE - DISTRICT 8 HVAC RENOVATION PLANS AND SECTIONS	GEORGIA VERMONT
---	--------------------