


State of Vermont  
Department of State Buildings  
**HVAC RENOVATION**  
MAINTENANCE GARAGE  
AGENCY OF TRANSPORTATION – DISTRICT 8  
GEORGIA, VERMONT

AGENCY OF ADMINISTRATION  
DEPARTMENT OF STATE BUILDINGS  
2 GOVERNOR AIKEN AVENUE  
MONTPELIER, VERMONT 05633-5801  
THOMAS W. TORTI, COMMISSIONER

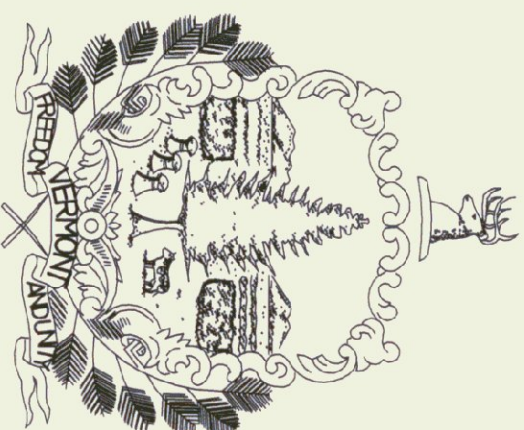


James H. Douglas  
Governor


November, 2002

INDEX OF SHEETS  
M1 PLAN AND SECTIONS


AGENCY OF TRANSPORTATION  
1 NATIONAL LIFE DRIVE  
DRAWER 33  
MONTPELIER, VT 05633  
PATRICIA A. McDONALD, SECRETARY

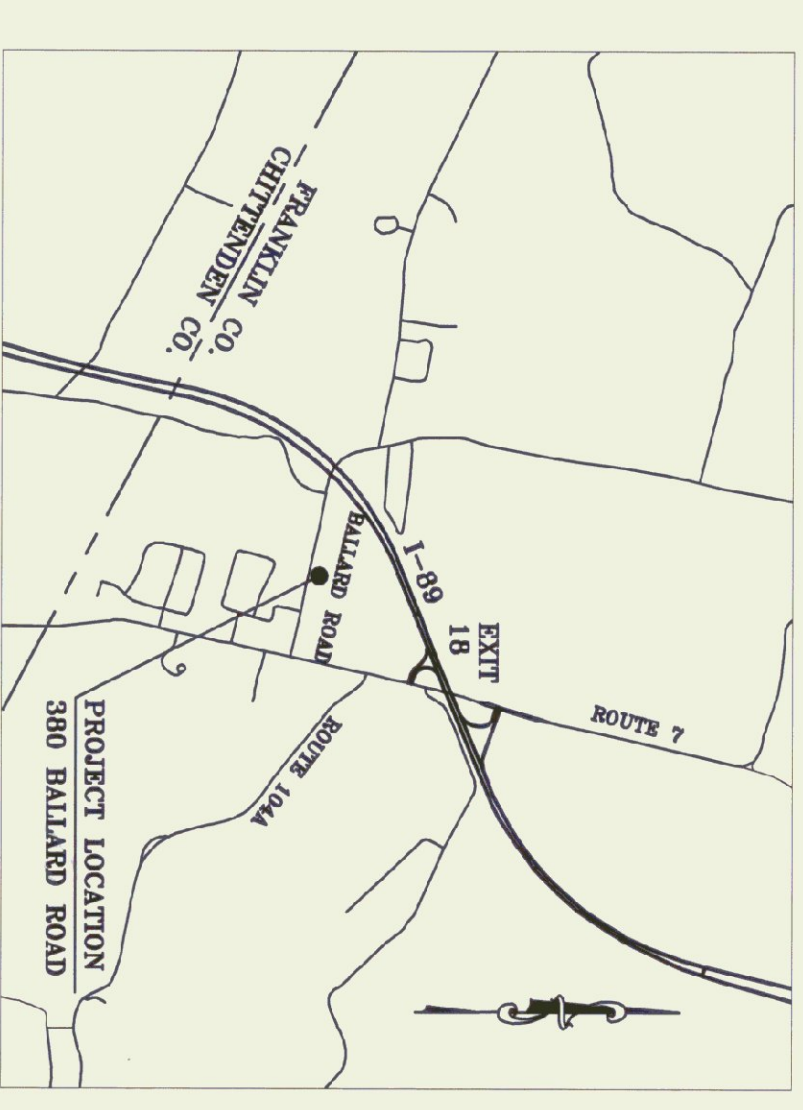


LOCATION PLAN

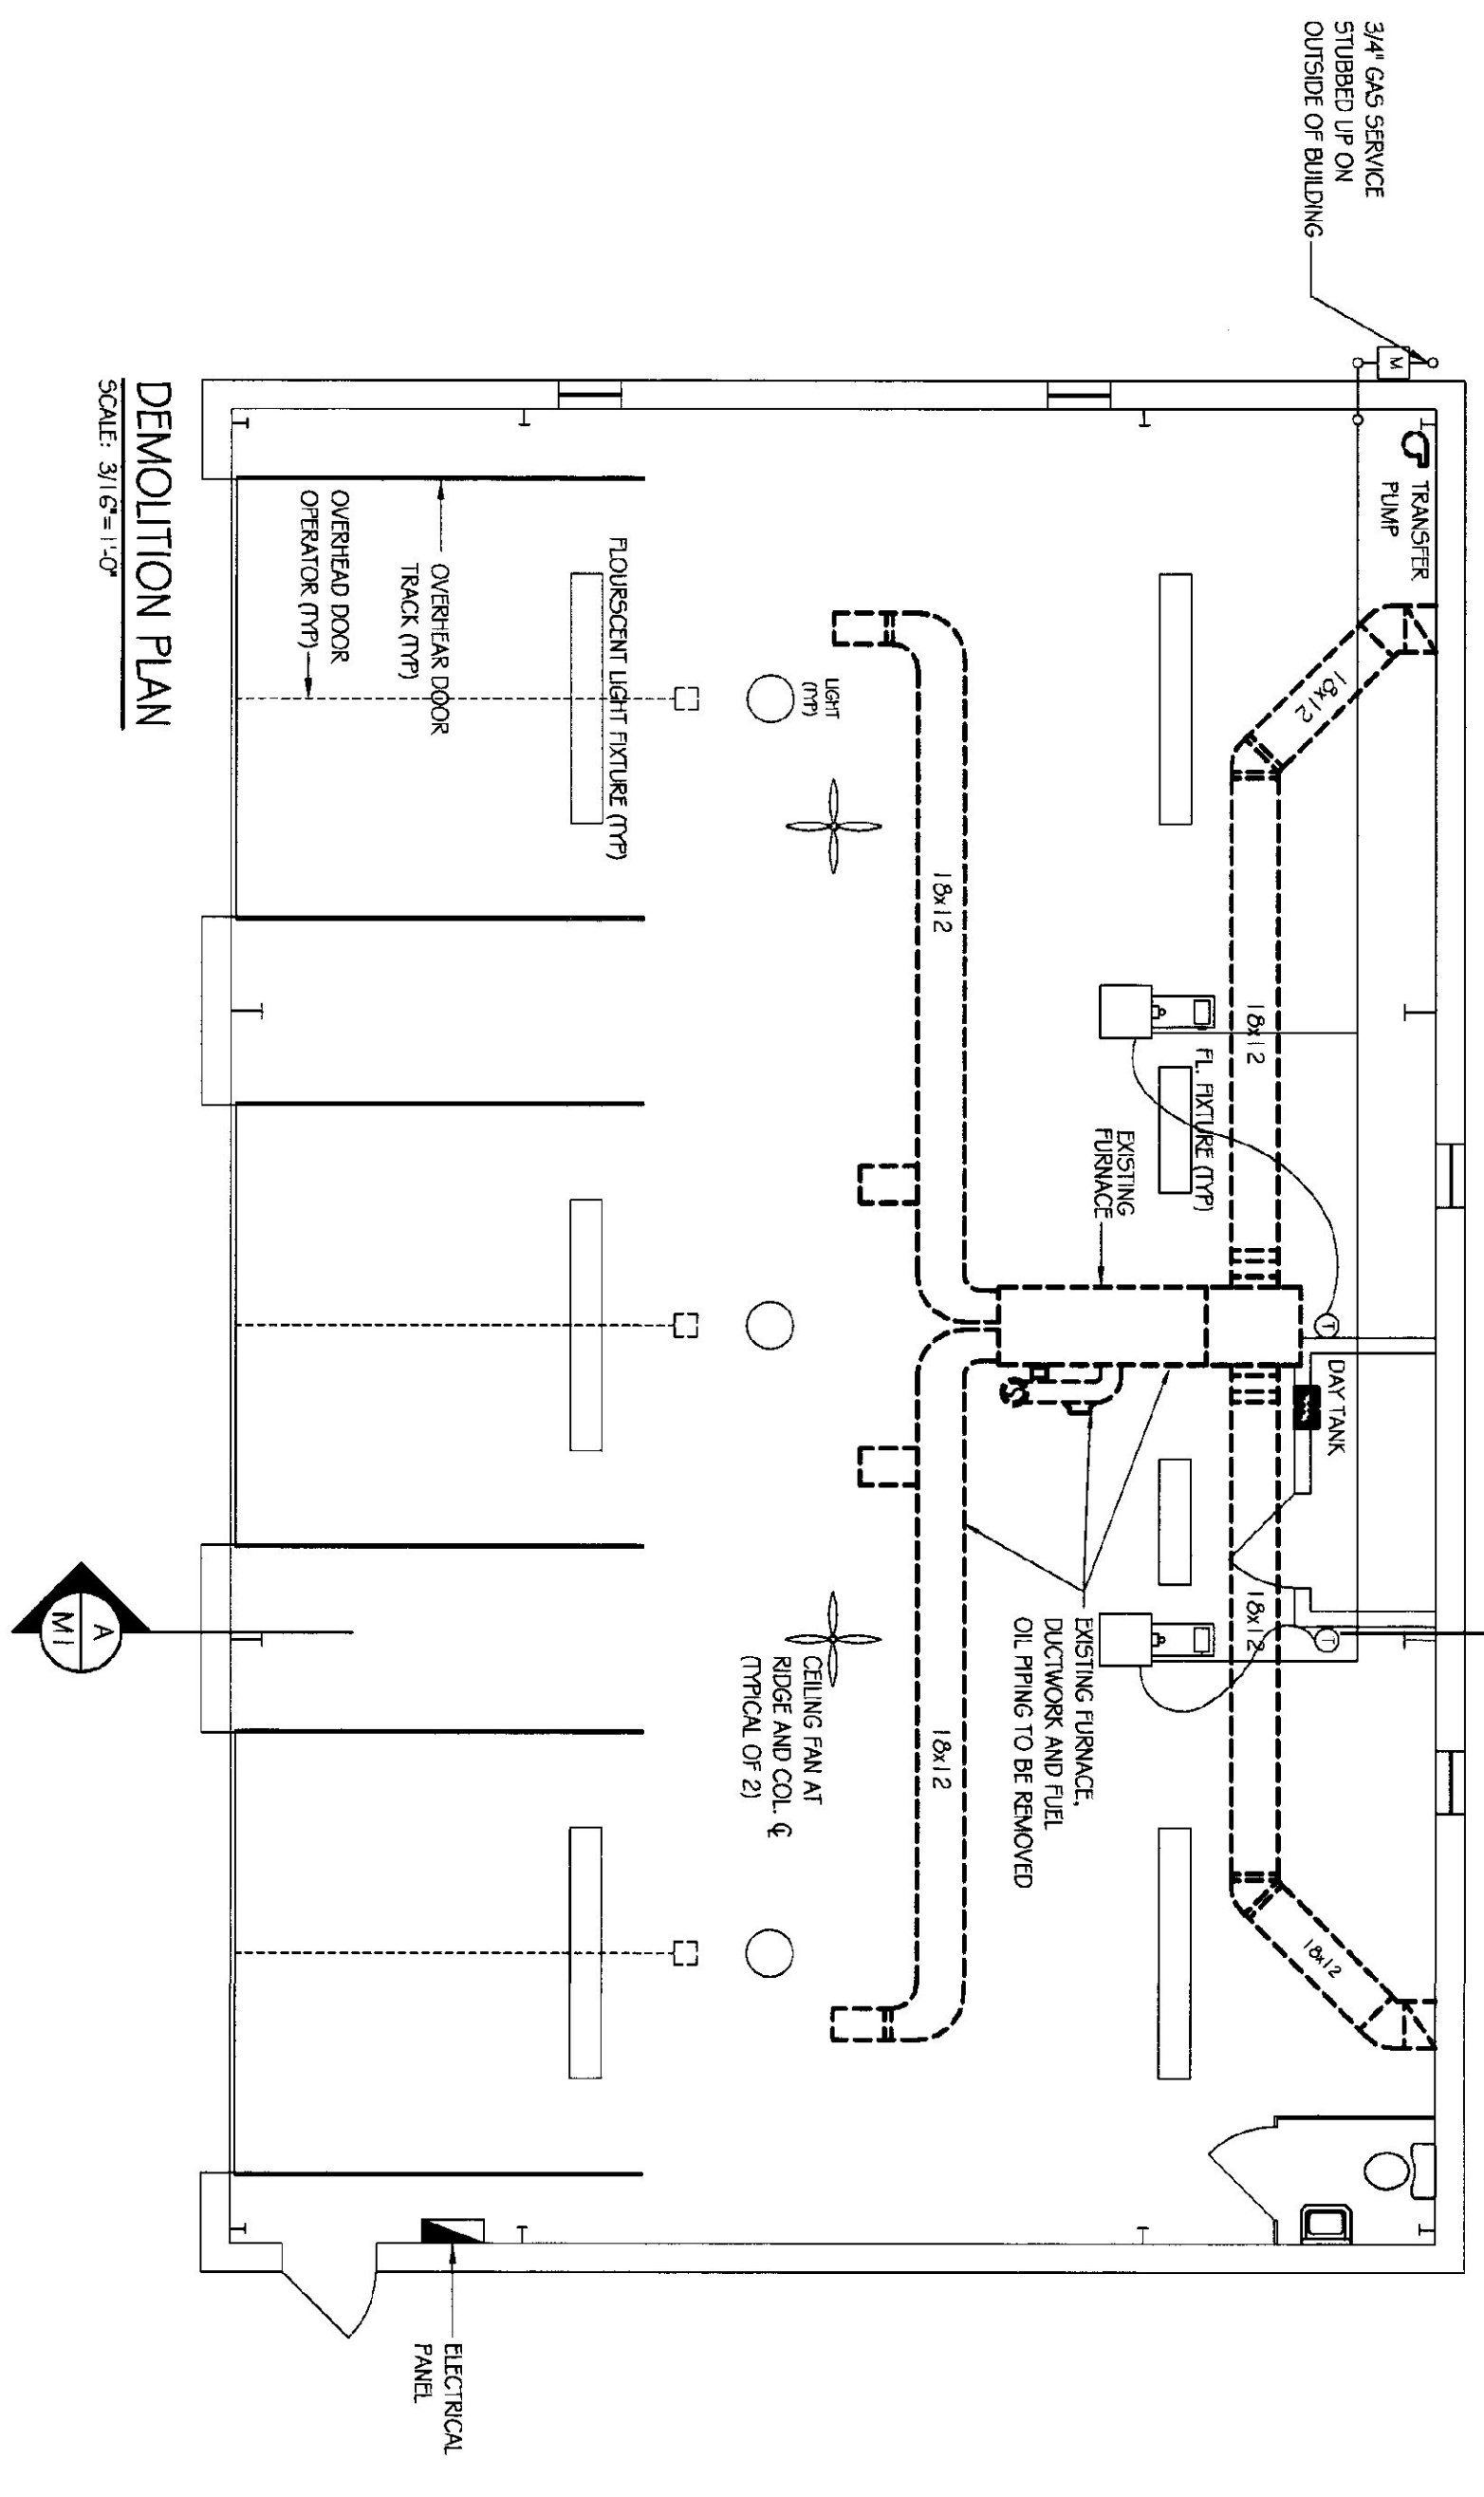


DEMOLITION PLAN  
SCALE: 3/16"=1'-0"

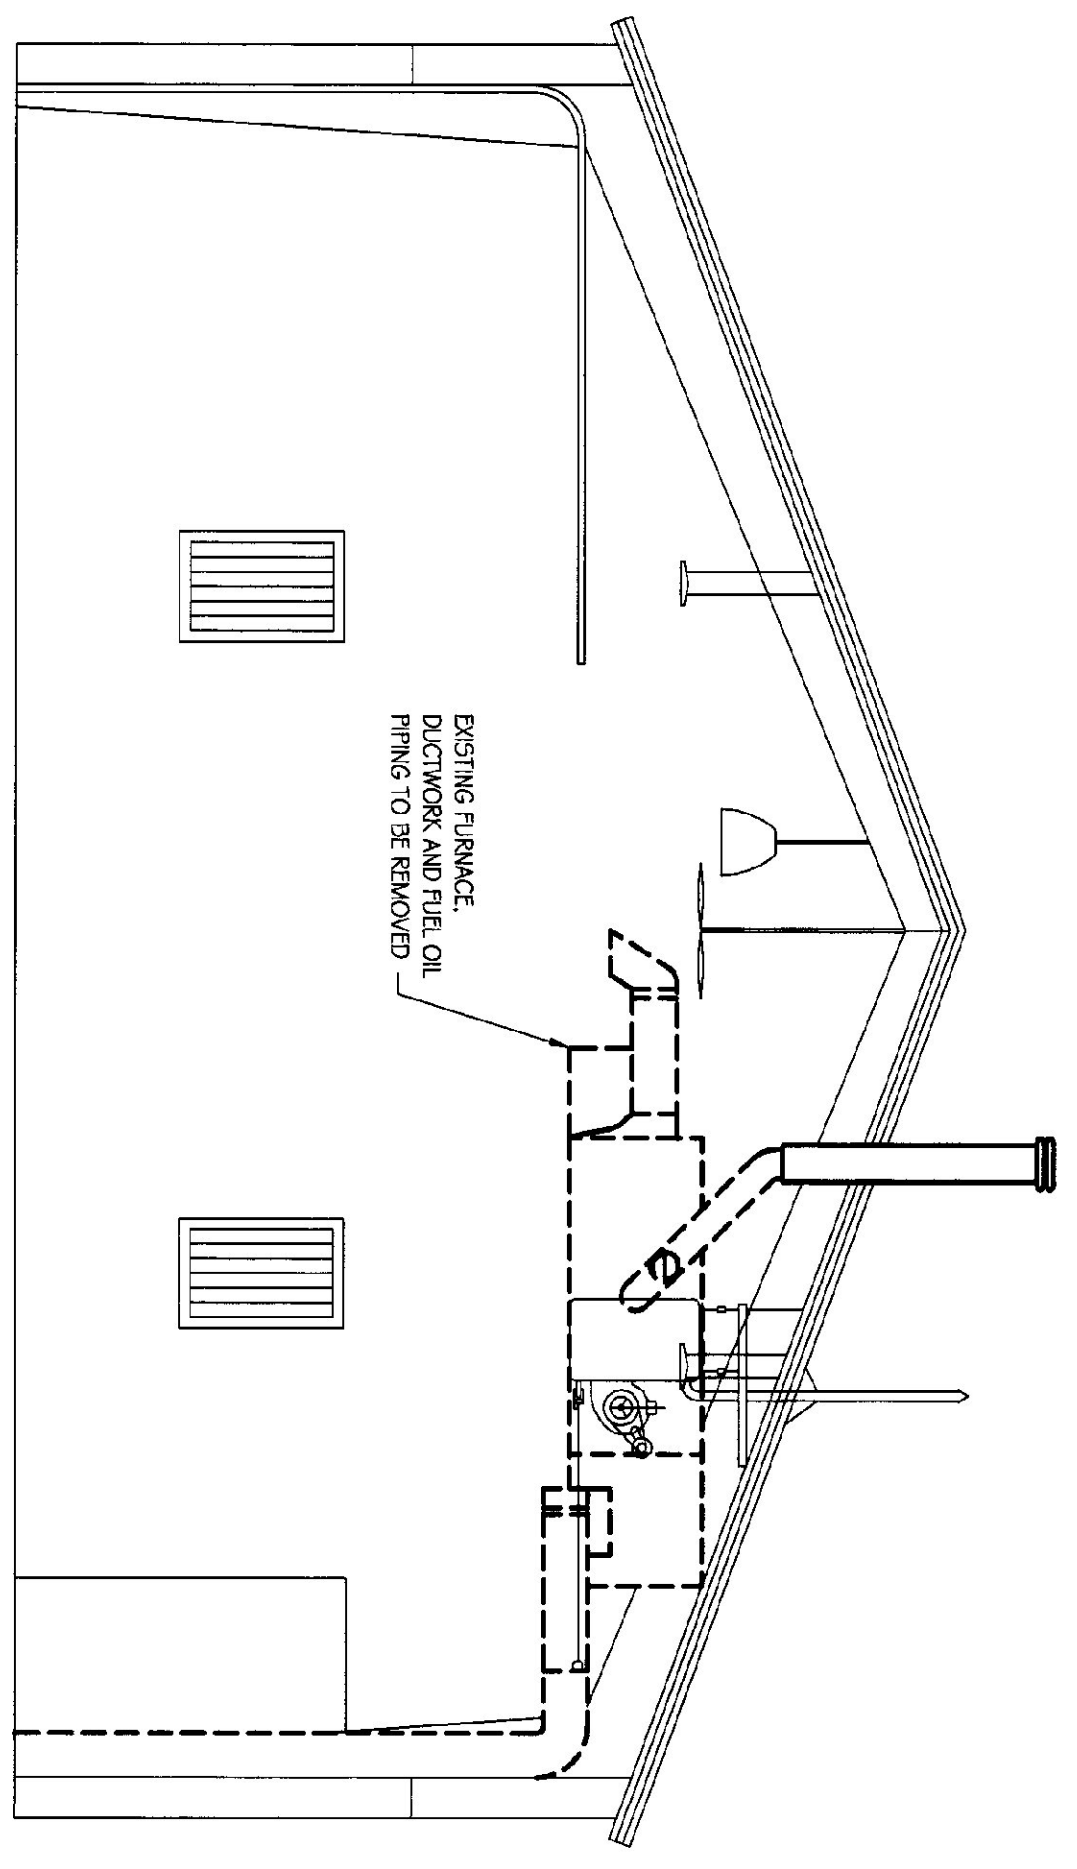

SECTION A-A DEMOLITION  
SCALE: 1/4"=1'-0"

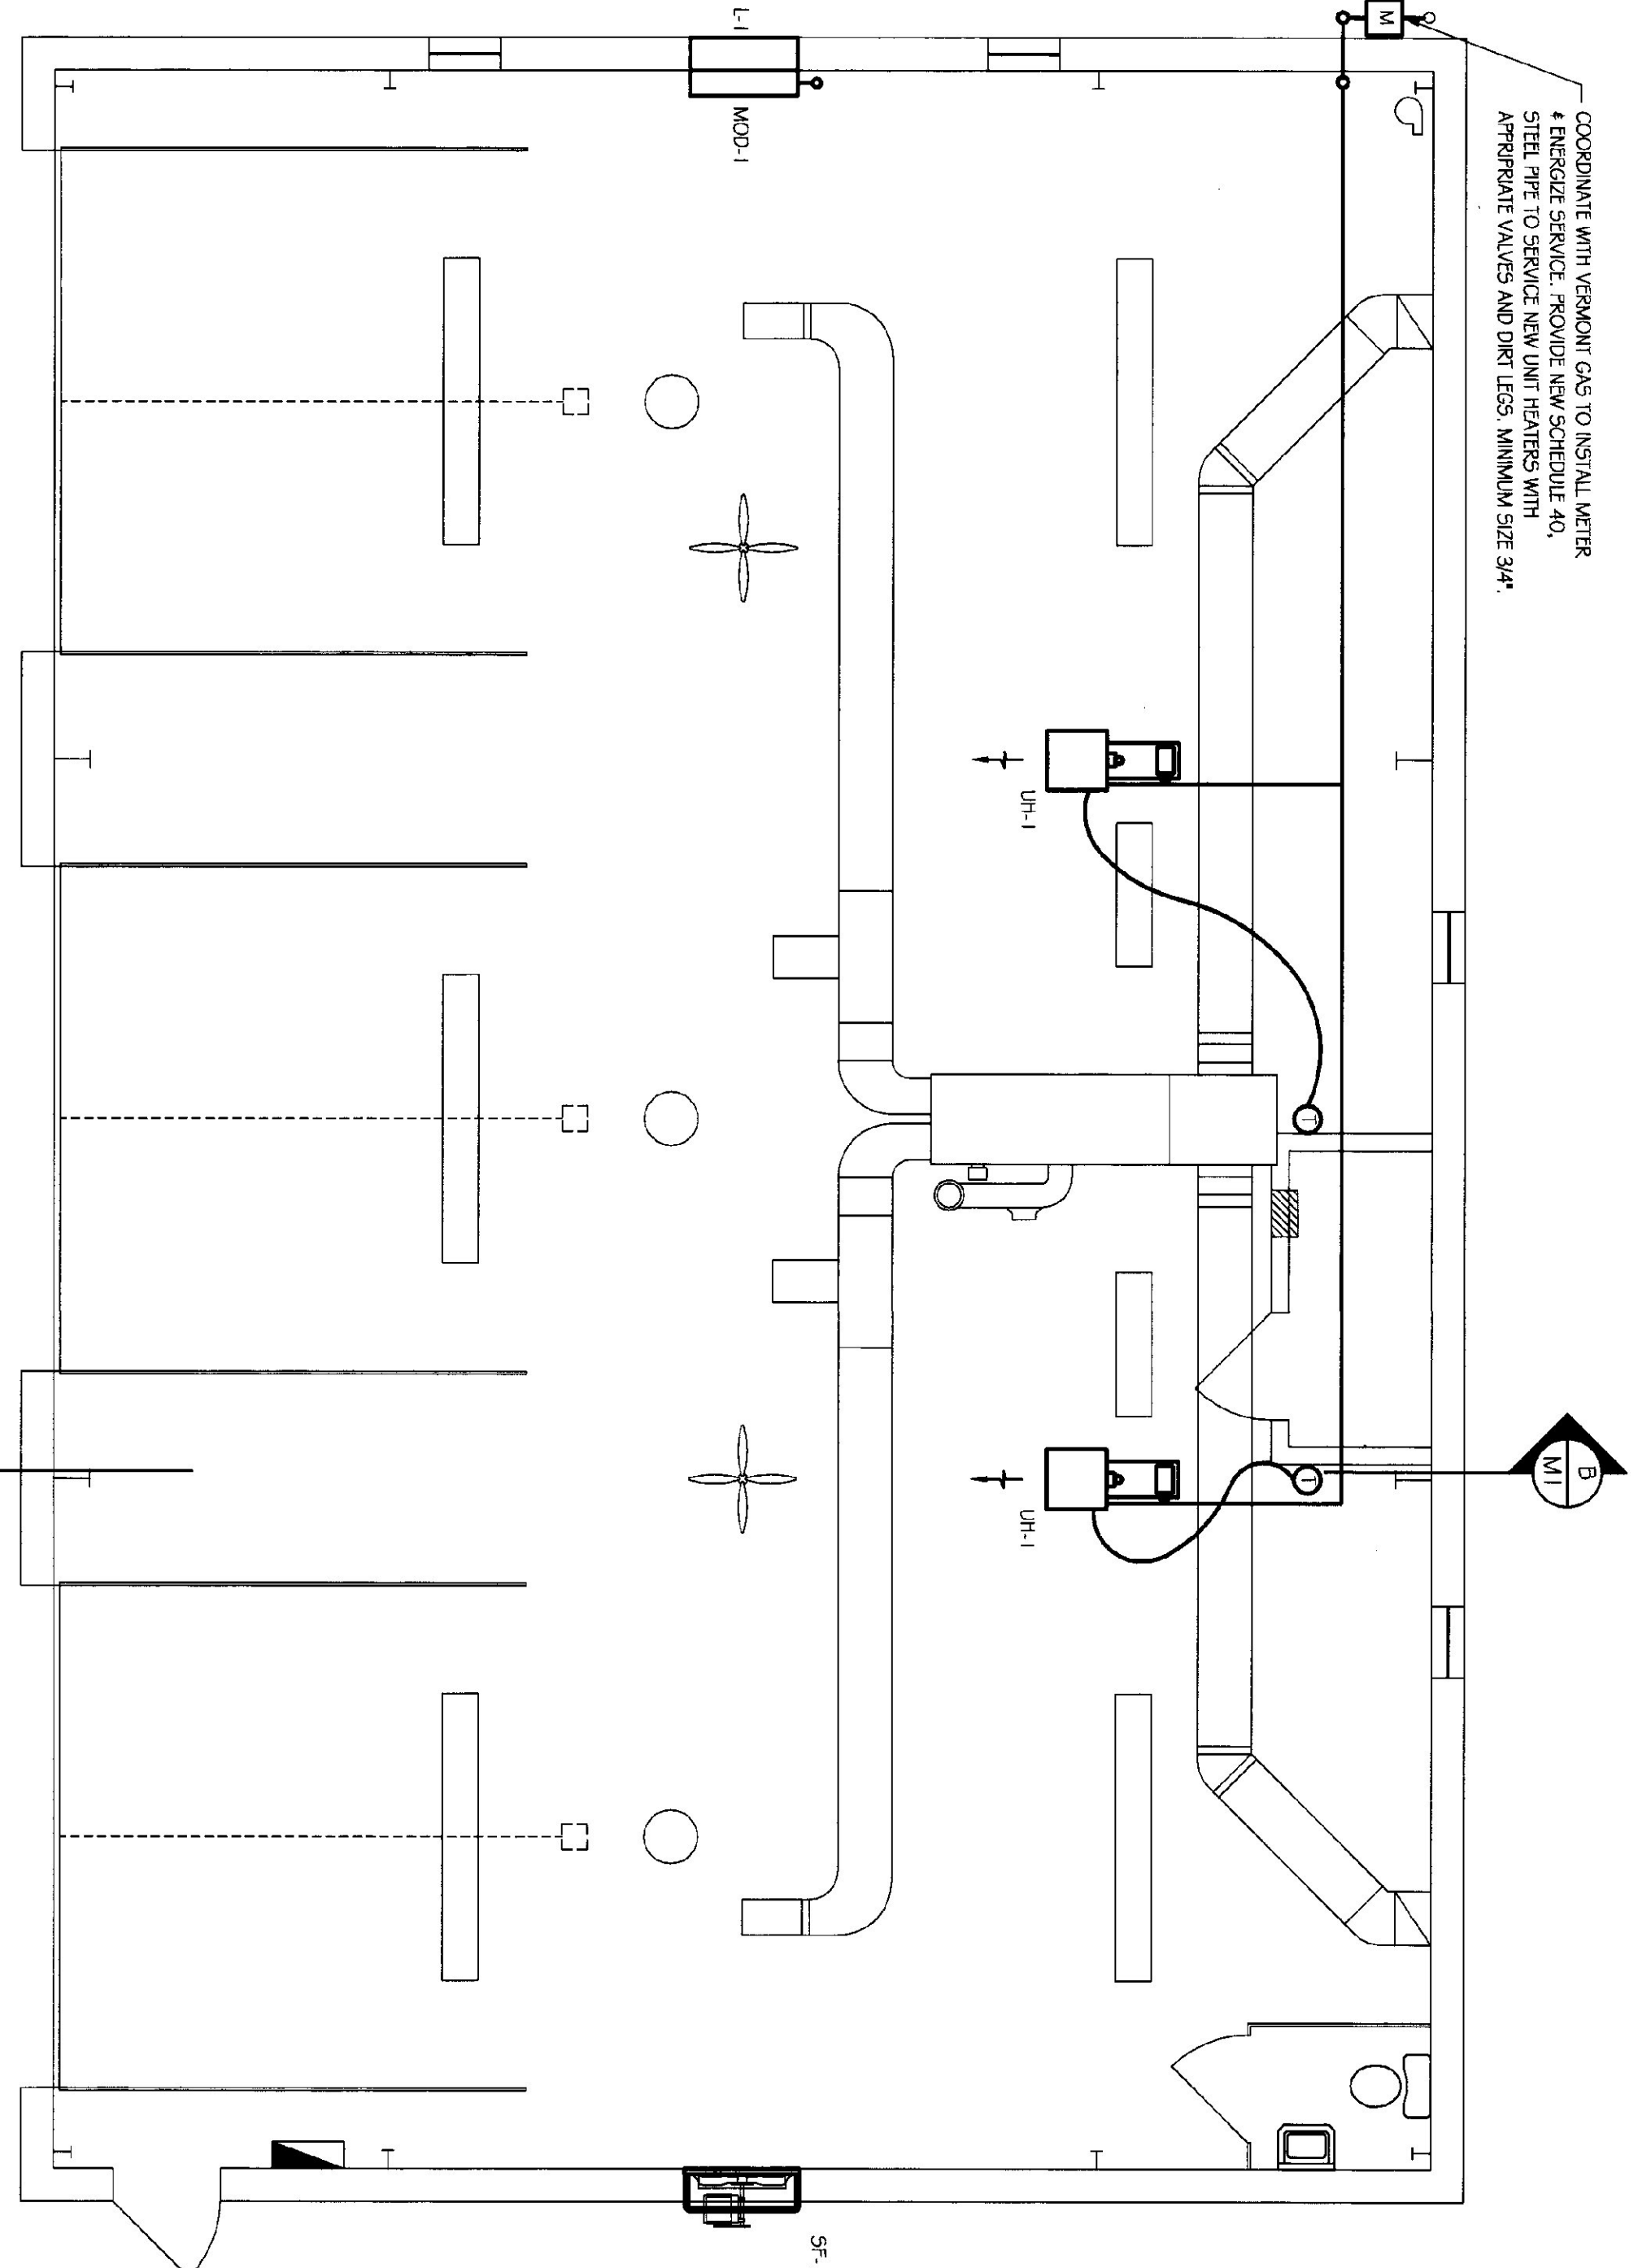

NEW HEATING PLAN  
SCALE: 1/4"=1'-0"

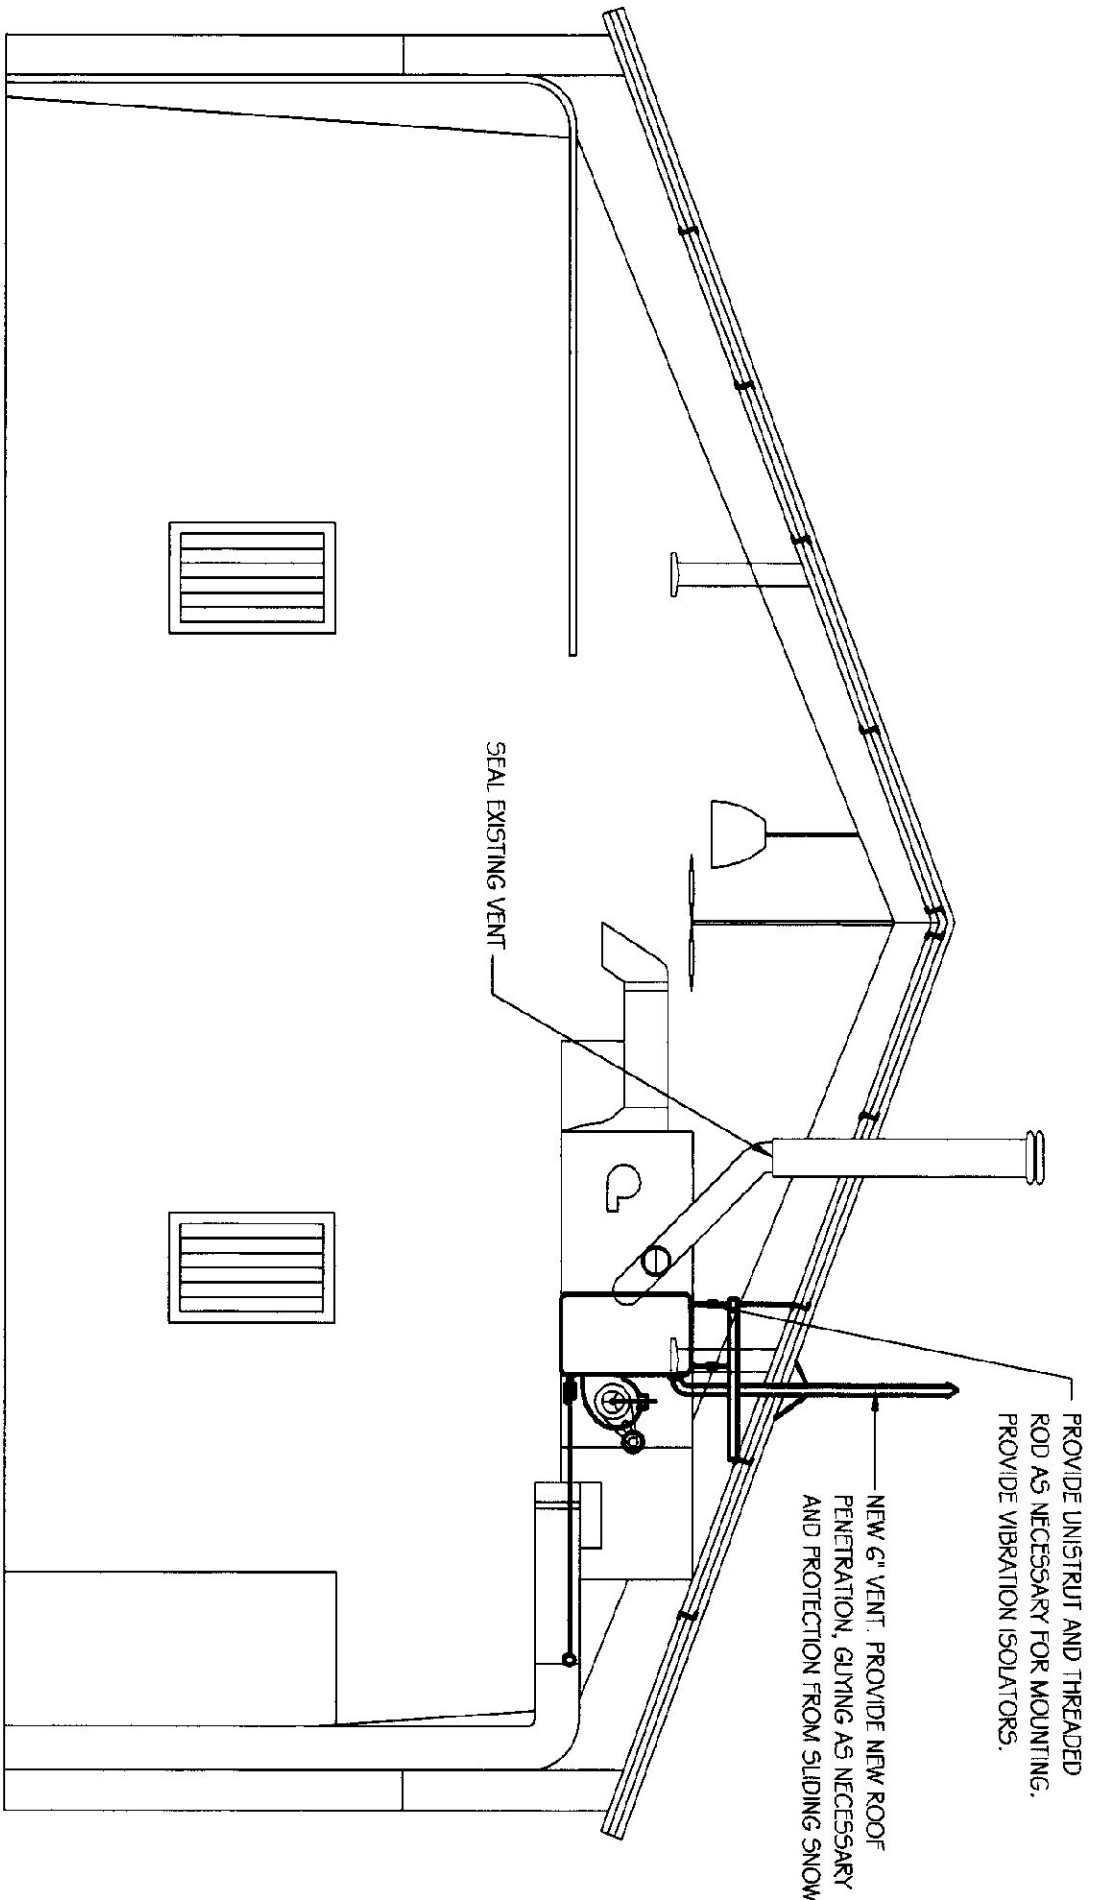

SECTION B-B NEW HEATING SYSTEM  
SCALE: 1/4"=1'-0"

ITEM SYMBOL	DESCRIPTION	MANUFACTURER/MAKE	CHARACTERISTICS	ELECTRICAL	NOTES
UH-1	GAS UNIT HEATER	KOCHLINE, 301 25	NATURAL GAS, 125,000 BTU/H, 100,000 BTU OUT, 1543 CFM, 550 RPM, 42" RISE	1/4 HP, 120 V, 1Ø	INSTALL IN ACCORDANCE WITH MANUFACTURER'S INSTRUCTIONS AND VERA 54
SE-1	GREENHICK GARAGE VENTILATOR	GREENHICK, 555-1120-4	3360 CFM, 0.125" ESP, 1.31 SCFM, 21.6 RPM	1/4 HP, 120 V, 1Ø	W/WT WEATHEROOD, SCREEN MOD
L-1	RELIEF LOUVER	VENTRODUCTS 2750	36x36		
MOD-1	RELIEF DAMPER	VENTRODUCTS 5703	36x36	120V Ø	DELIMO DIRECT COUPLED ACTUATOR SPRING WOUND N.C.

EQUIPMENT SCHEDULE

AOT MAINTENANCE GARAGE - DISTRICT 8 HVAC RENOVATION PLANS AND SECTIONS	SCALE:	AS NOTED
	DATE:	11/2002
	DRAWN BY:	T. DREW
	APPR. BY:	T. SOUTHWORTH

REVISIONS

AOT MAINTENANCE GARAGE - DISTRICT 8  
HVAC RENOVATION  
PLANS AND SECTIONS

GEORGIA VERMONT



STATE OF VERMONT  
Department of Buildings  
and General Services  
Agency of Administration  
Montpelier, Vermont

