


PAUL GUAY


N 19° 40' E  
580.5'

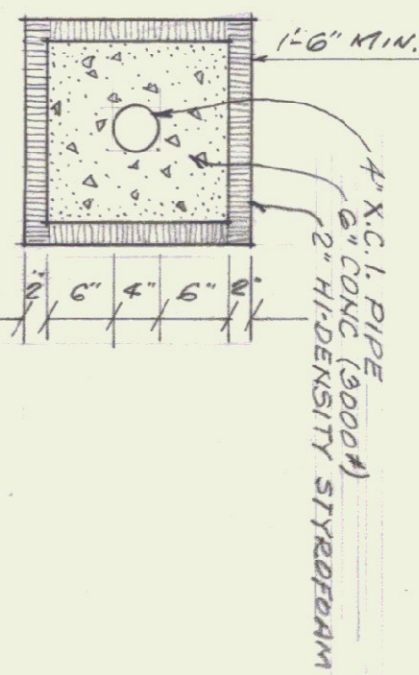

SECTION THRU SOIL PIPE UNDER DRIVEWAY  
SCALE: 3/4" = 1'-0"

D.0065  
M. 67 N

BOILING TYPICAL IN CONSTRUCTION AREA

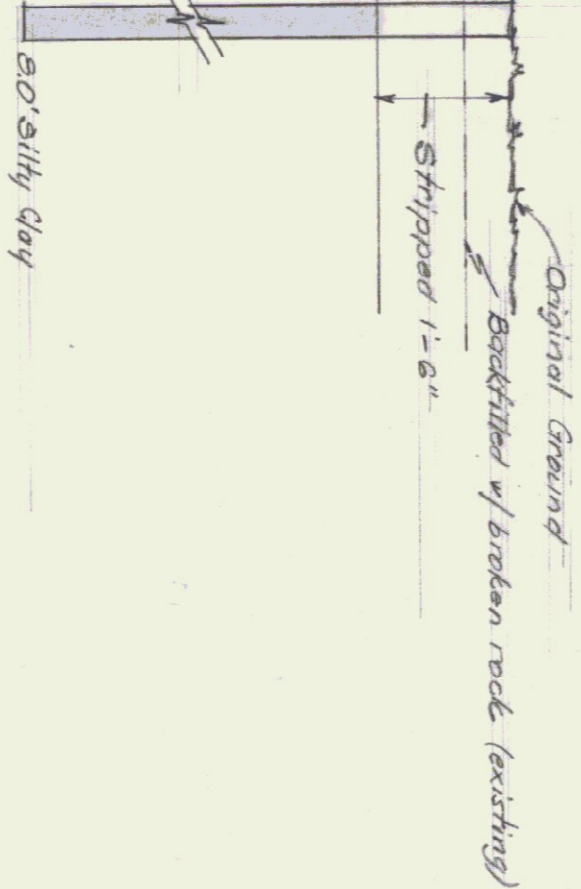

**SITE PLAN**  
STATE OF VERMONT  
DEPARTMENT OF HIGHWAYS,  
NORTH HERO GARAGE FACILITY

SCALE: 1" = 50'

N 17° 2' E  
950.0'

9.9 Acres

NOTE: Proposed roadway to buildings by State Highway Dept.



STATE OF VERMONT
DIVISION OF STATE BUILDINGS
AGENCY OF ADMINISTRATION
SURVEYED BY: J. BUSHLEY RLS# 830 673
DRAWN BY: C.E.H. 8/78
APPRO. T.S.
DRAWING # S-1 6/22/78