



FLOOR PLAN
SCALE 1/8" = 1'-0"

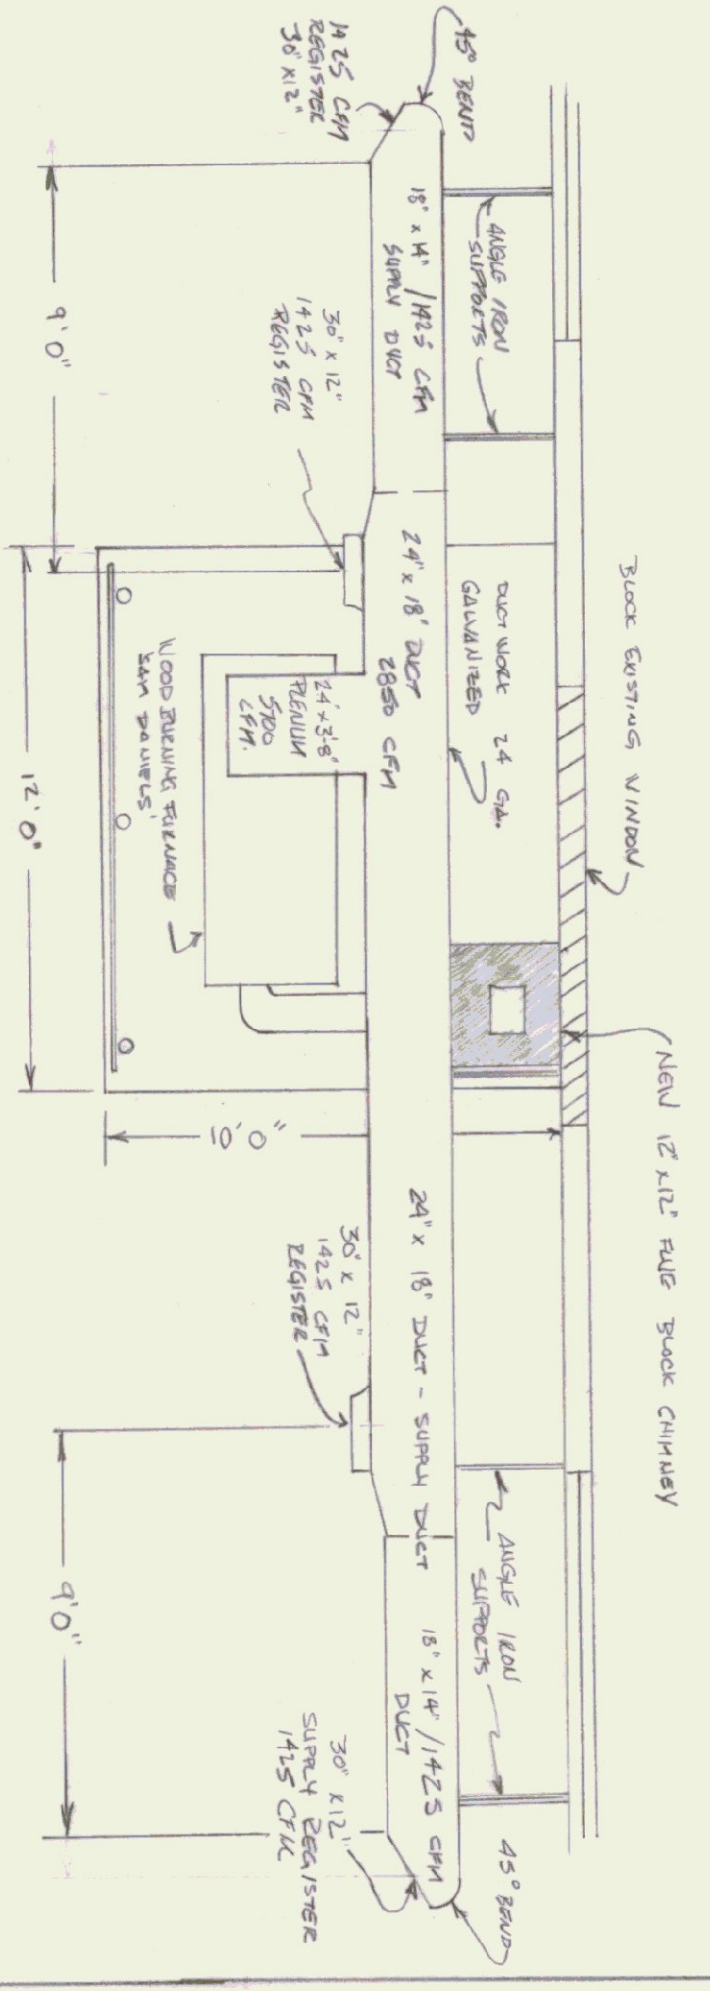

REAR OF FURNACE & SLAB
SCALE 1/4" = 1'-0"

Notes:
1 SUPPLY REGISTERS ARE ADJUSTABLE DOUBLE DEFLECTOR
WITHINING JAMES, ALUMINUM - CEILING MODEL 6821 OR
EQUIV. PROVIDE ALUMINUM OPERED BLADE VALVE-TANKER BEHIND EACH REGISTER.
2 PROVIDE SMOKESTOP BEHIND IN ALL DUCT TAKE.
3 PROVIDE TRICETS IN ALL EXHAUST AIR DUCTS.

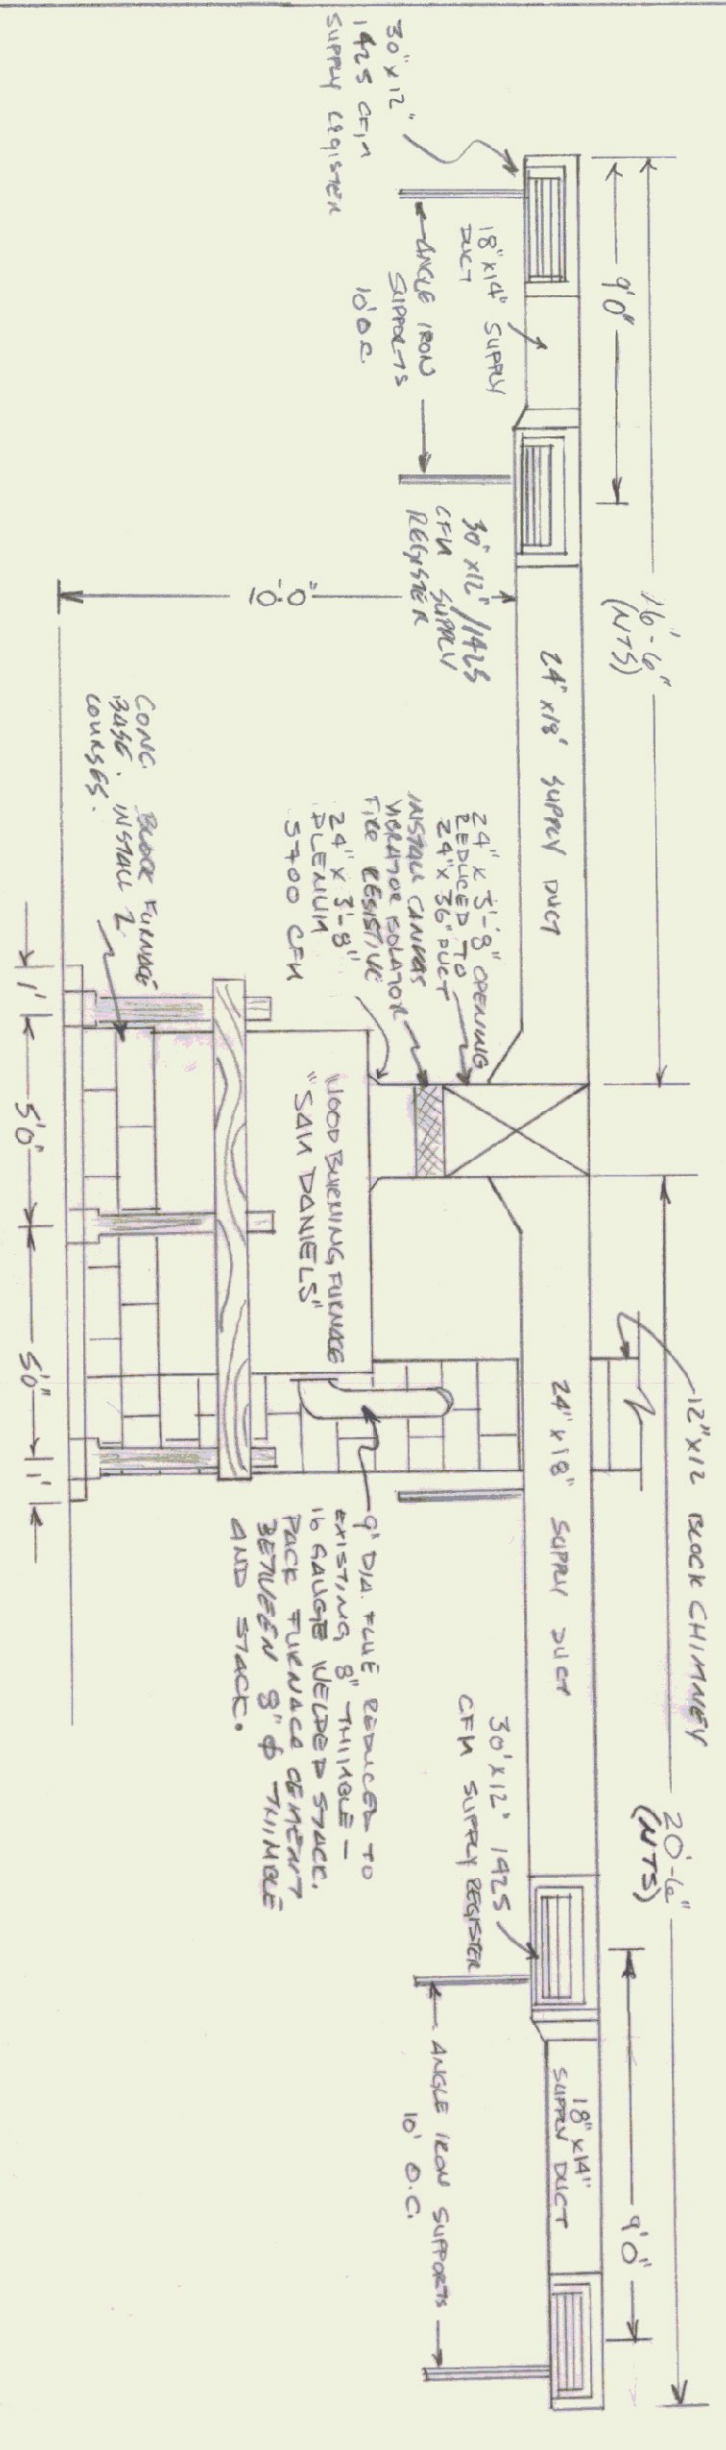

ELEVATION C FRONT OF FURNACE
SCALE 1/4" = 1'-0"

1425 CFM REGISTER 30" x 12"
45° REG. STEEL DEFLECTOR

STATE OF VERMONT			
DIVISION OF STATE BUILDINGS			
AGENCY OF ADMINISTRATION			
VERMONT			
MONTPELIER.			
WOOD BURNING FURNACE INSTALLATION			
GARAGE AT NORTH HERO, VERMONT			
AGENCY OF TRANSPORTATION			
DATE:	SCALE:	REVISIONS:	DWG. NO.
10/5/81	AS NOTED	SHUB SI M.S.G.	
DRAWN BY:	APPROVED BY:		OF
SC			