



MAIN LEVEL MECHANICAL DUCTWORK PLAN
SCALE: 1/8" = 1'-0"



UPPER LEVEL MECHANICAL DUCTWORK PLAN
SCALE: 1/8" = 1'-0"

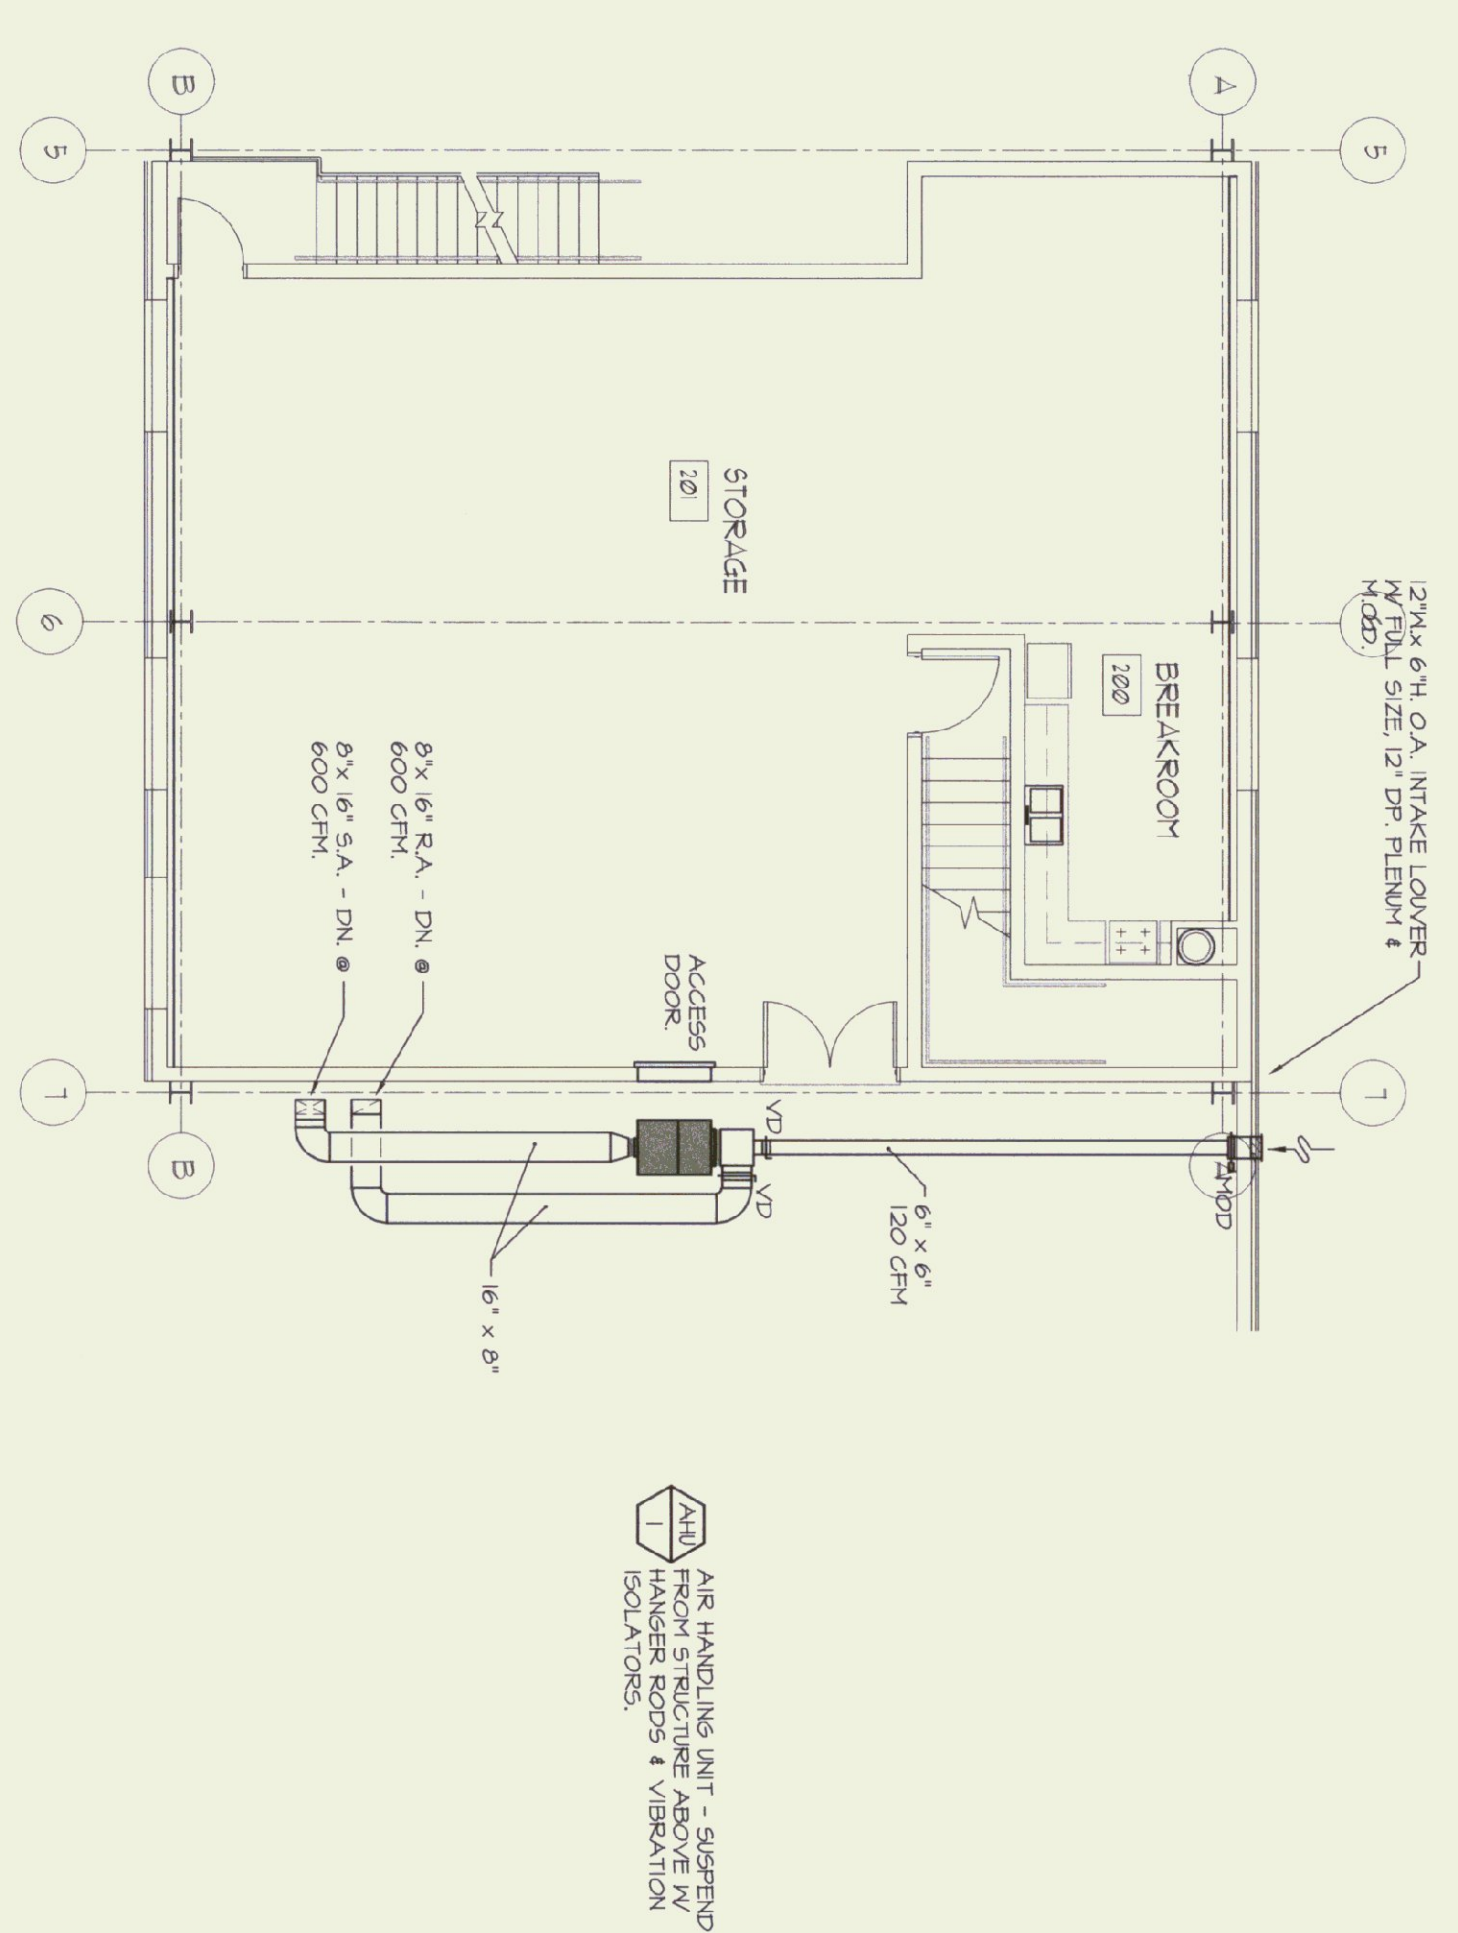

nv engineering associates
pa
00369
mechanical electrical consulting engineers
po box 764 keene, new hampshire 03431
603 352-1001 fax 352-10025
www.nvengineering.com

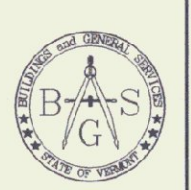

D&W
DORE AND WHITTIER, INC.
Architects • Project Managers
1795 WILLISTON RD, STE 5
S. BURLINGTON, VT 05403
Phone: (802) 865-1428
Fax: (802) 865-6955
1400 HANCOCK STREET
QUINCY, MA 02169
Phone: (617) 471-2897
Fax: (617) 471-2516



STATE OF VERMONT
DEPARTMENT OF BUILDINGS
AND GENERAL SERVICES
AGENCY OF ADMINISTRATION
MONTPELIER, VERMONT

AGENCY OF TRANSPORTATION
HIGHGATE MAINTENANCE FACILITY
HIGHGATE
AIRPORT ROAD HIGHGATE, VERMONT

REVISIONS	DATE	BY	APPR.
SCALE: AS SHOWN	10/24/90	MAM	MDV
HIGHGATE MAINTENANCE GARAGE MECHANICAL FLOOR PLAN			

M-2
30 OF 37