
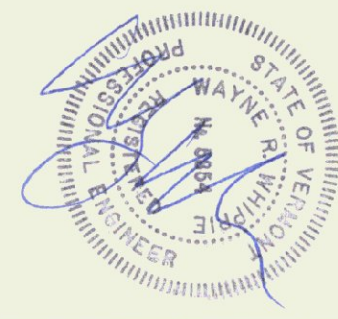
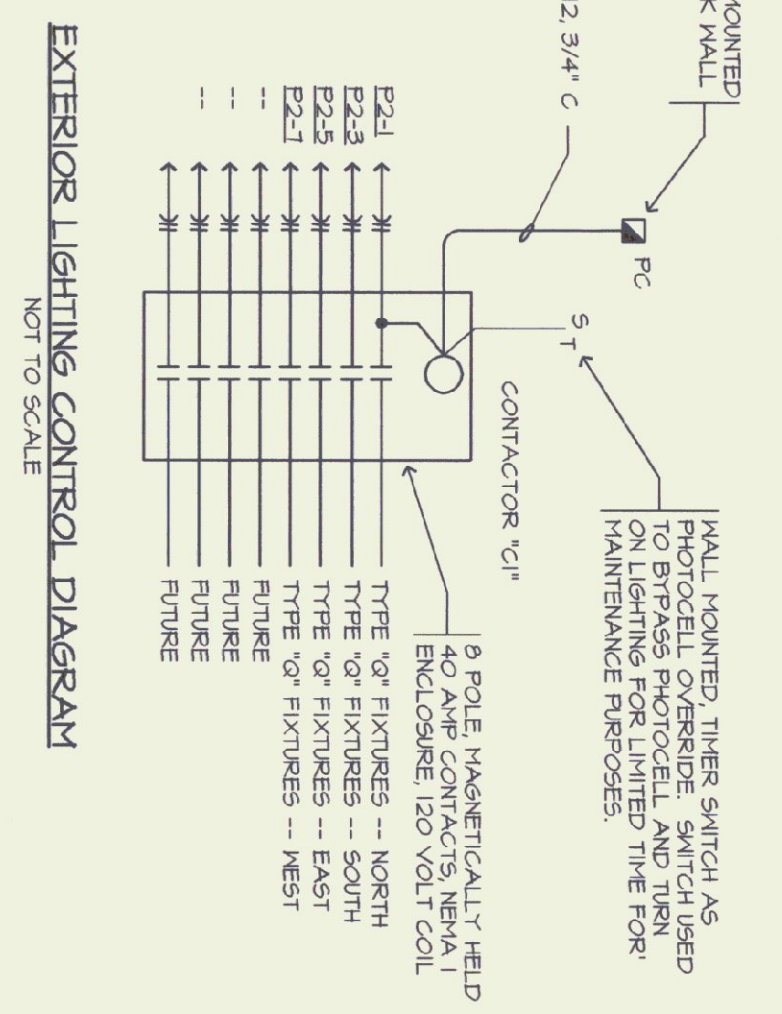
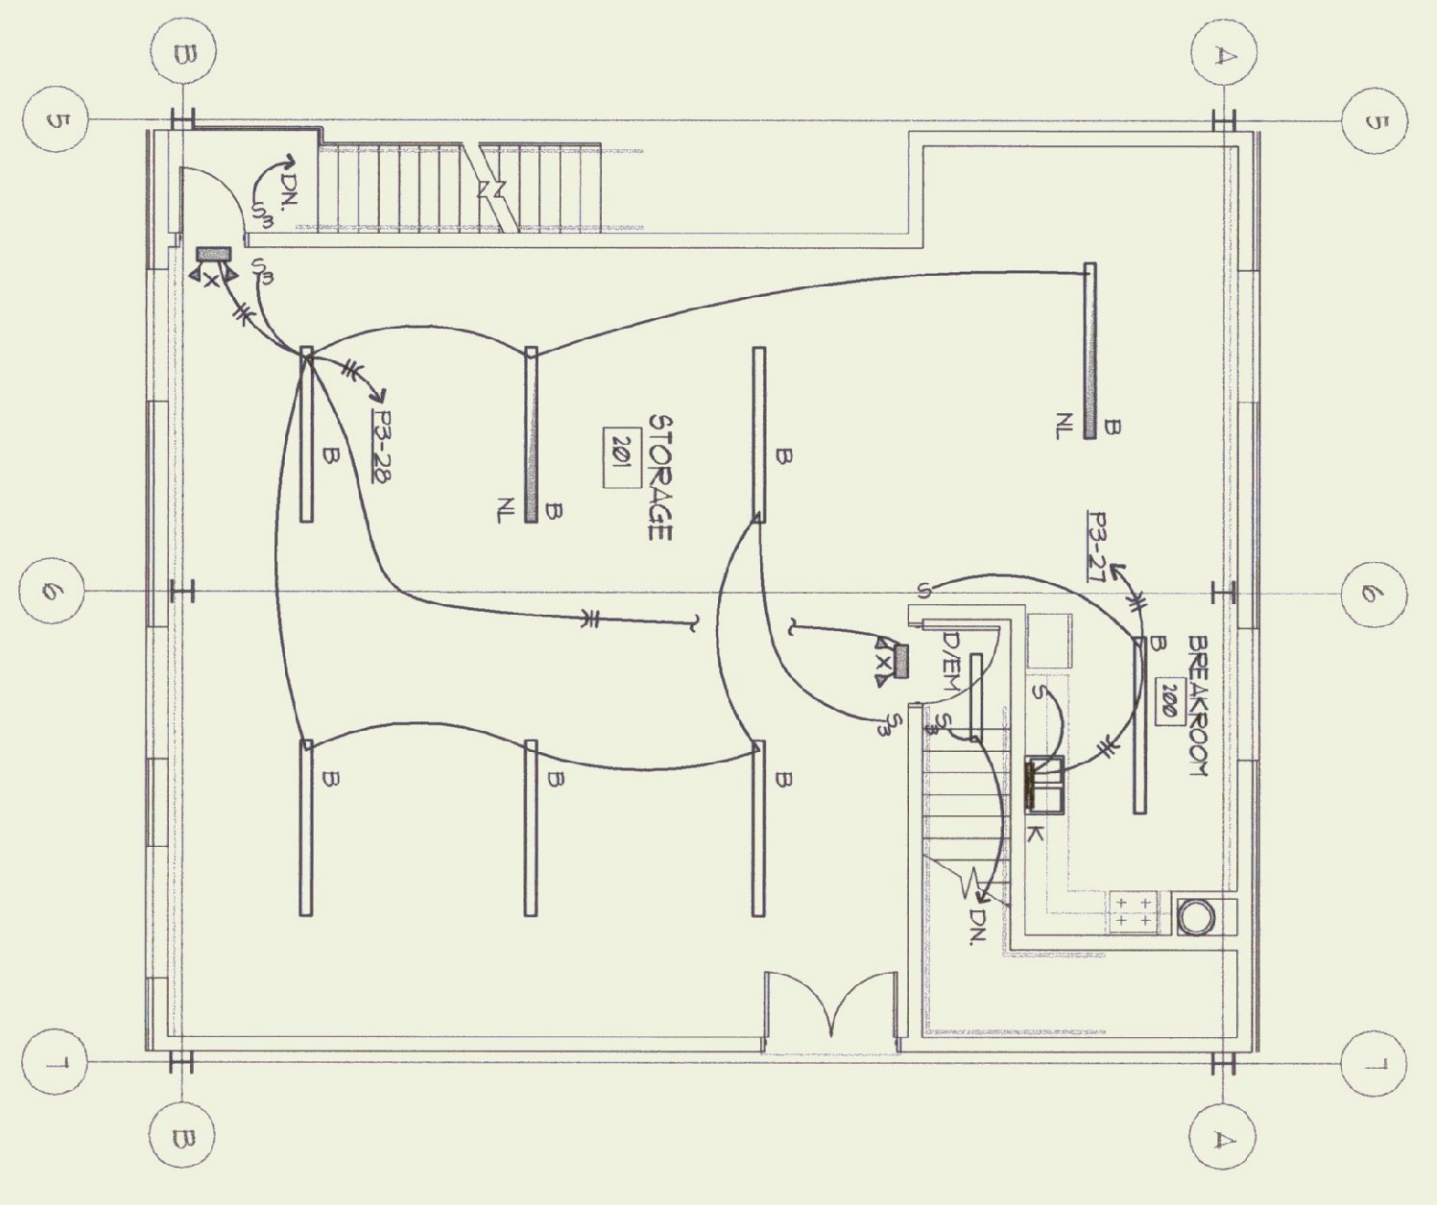
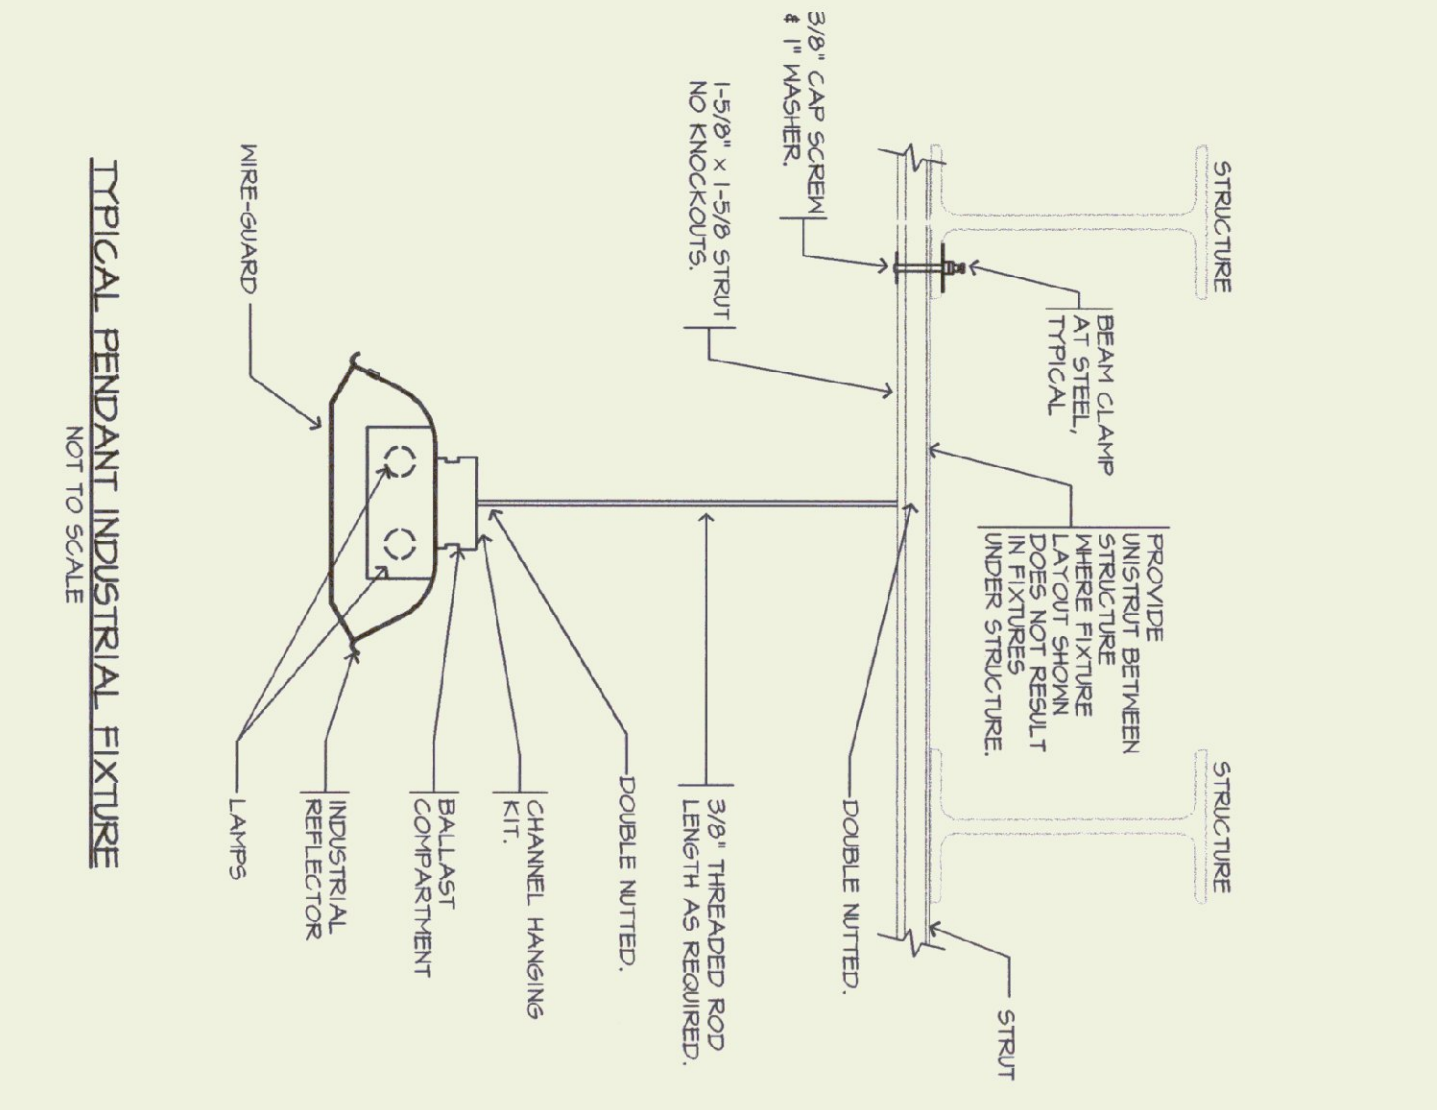


MAIN LEVEL LIGHTING PLAN
SCALE: 1/8"=1'-0"

WIRE CONNECTIONS FOR EXIT SIGNS/ BATTERY UNITS TO LOCAL LIGHTING CIRCUITS AHEAD OF LOCAL OR CENTRAL SWITCHING.
WIRE BATTERY UNITS TO LOCAL LIGHTING CIRCUITS AHEAD OF LOCAL AND CENTRAL SWITCHING.

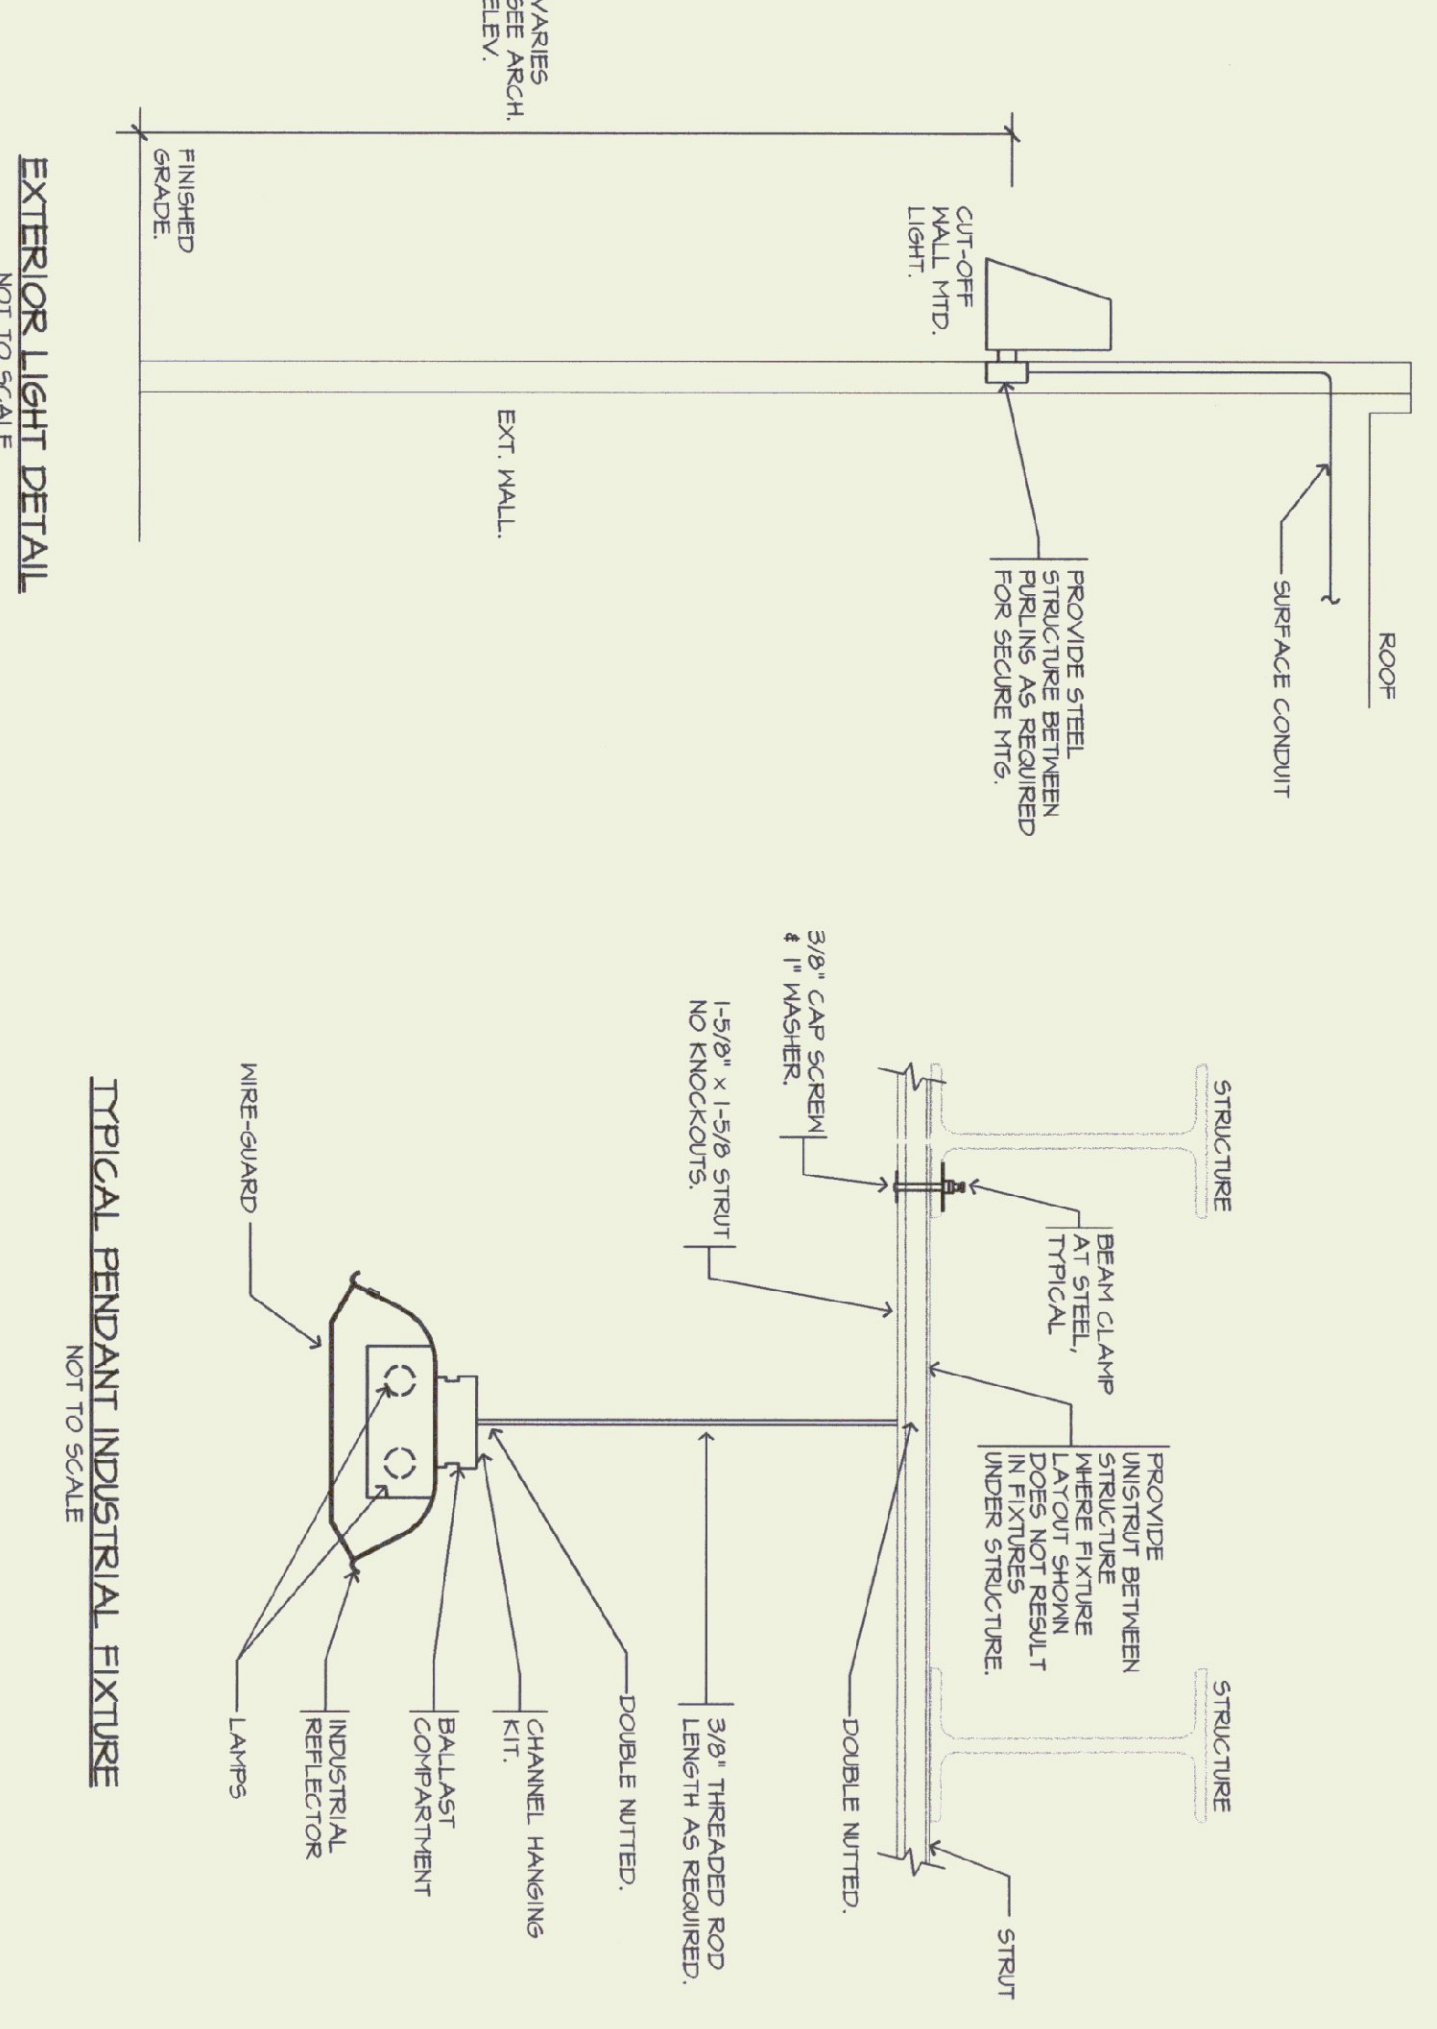

nv engineering associates
pa
00369
mechanical electrical consulting engineers
po box 764 keene, new hampshire 03431
603 352 1007 fax 352 1005
www.nvengineering.com

STATE OF VERMONT
DEPARTMENT OF BUILDINGS
AND GENERAL SERVICES
AGENCY OF ADMINISTRATION
MONTPELIER, VERMONT

D&W
DORE AND WHITTIER, INC.
Architects • Project Managers
1795 WILLETTON RD, STE 5
S. BURLINGTON, VT 05403
Phone: (802) 863-1428
Fax: (802) 863-0955
1400 HANCOCK STREET
QUINCY, MA 02169
Phone: (617) 471-2897
Fax: (617) 471-2516

AGENCY OF TRANSPORTATION
HIGHGATE MAINTENANCE FACILITY
HIGHGATE VERMONT

REVISIONS	SCALE: AS SHOWN
DATE: 09/24/01	
DRAWN BY: CTS	
APPR. BY: WRW	

HIGHGATE
MAINTENANCE
GARAGE
ELECTRICAL
LIGHTING PLAN