


List of Drawings:
 S-1 Site Plan
 P-1 Plumbing Plan

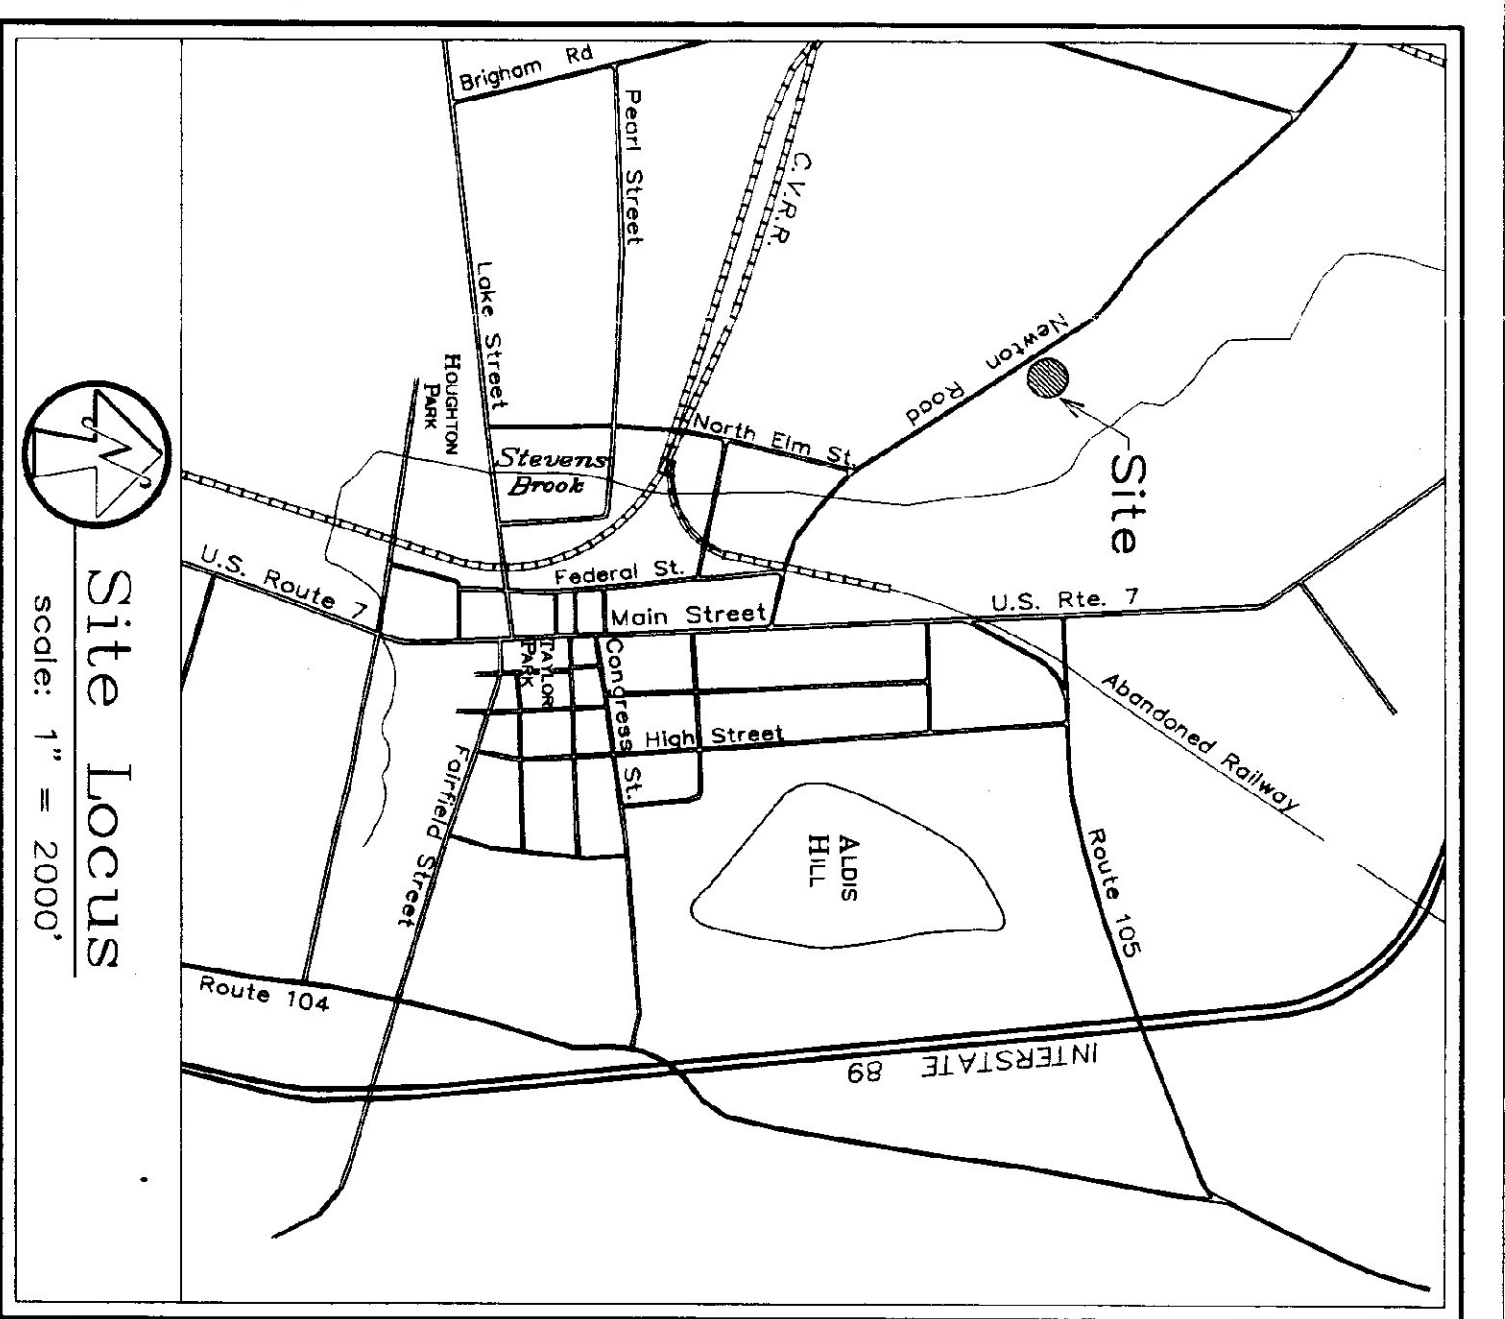

Site Locust
 Scale: 1" = 200'

LEGEND

- ⊙ EXISTING IRON PIN
- ⊕ EXISTING GAS VALVE
- ⊖ EXISTING SIGN
- ⊙ EXISTING UTILITY POLE
- ⊙ EXISTING CATCH BASIN
- ⊙ EXIST. PUMP STATION & VALVE COMPARTMENT
- ⊙ EXISTING SEWER WARE (SM) - AS NOTED
- ⊙ EXISTING WOODEN FENCE
- ⊙ EXISTING STORM DRAIN
- ⊙ EXISTING CHAIN LINK FENCE
- ⊙ EXISTING CONTOUR
- ⊙ APPROXIMATE RIGHT-OF-WAY (R.O.W.) LIMIT
- ⊙ PROPOSED PRESSURE SEWER
- ⊙ EXISTING GRAVITY SEWER
- ⊙ EXISTING ELEC. POWER
- ⊙ EXISTING UNDERGROUND CONDUIT
- ⊙ EXISTING NATURAL GAS LINE
- ⊙ EXISTING WATER LINE
- ⊙ PROPOSED FLOOR DRAIN LINE
- ⊙ EXISTING FLOOR DRAIN LINE

Notes

- The contractor shall be responsible for verifying and determining the location of all existing utilities shown or not shown on this plan prior to the start of construction. Proposed construction and appropriate remedial action shall be taken before proceeding with the work. The contractor shall verify all dimensions and elevations in the field before commencing construction and notify the engineer, in writing, of any discrepancies found.
- The contractor shall be responsible for contacting Dig Safe (1-888-344-7233) prior to excavation.
- Permitted to the State access to public records statute V.S.A. 1, Chapter 5, Subchapter 3, 1. (a) hereby authorizes any person to inspect or copy this document or record as may be necessary to comply with the laws and regulations of the State of Vermont.

