




1. FURNACE CONTRACT LIMITED TO FURNISHING AND INSTALLING FURNACE AND NECESSARY DUCTWORK AND ELECTRICAL WORK. PAD AND FURNACE FOUNDATION TO BE SUPPLIED BY A.O.T. FORCES.
2. ALL WIRING TO BE INSTALLED IN EMT.

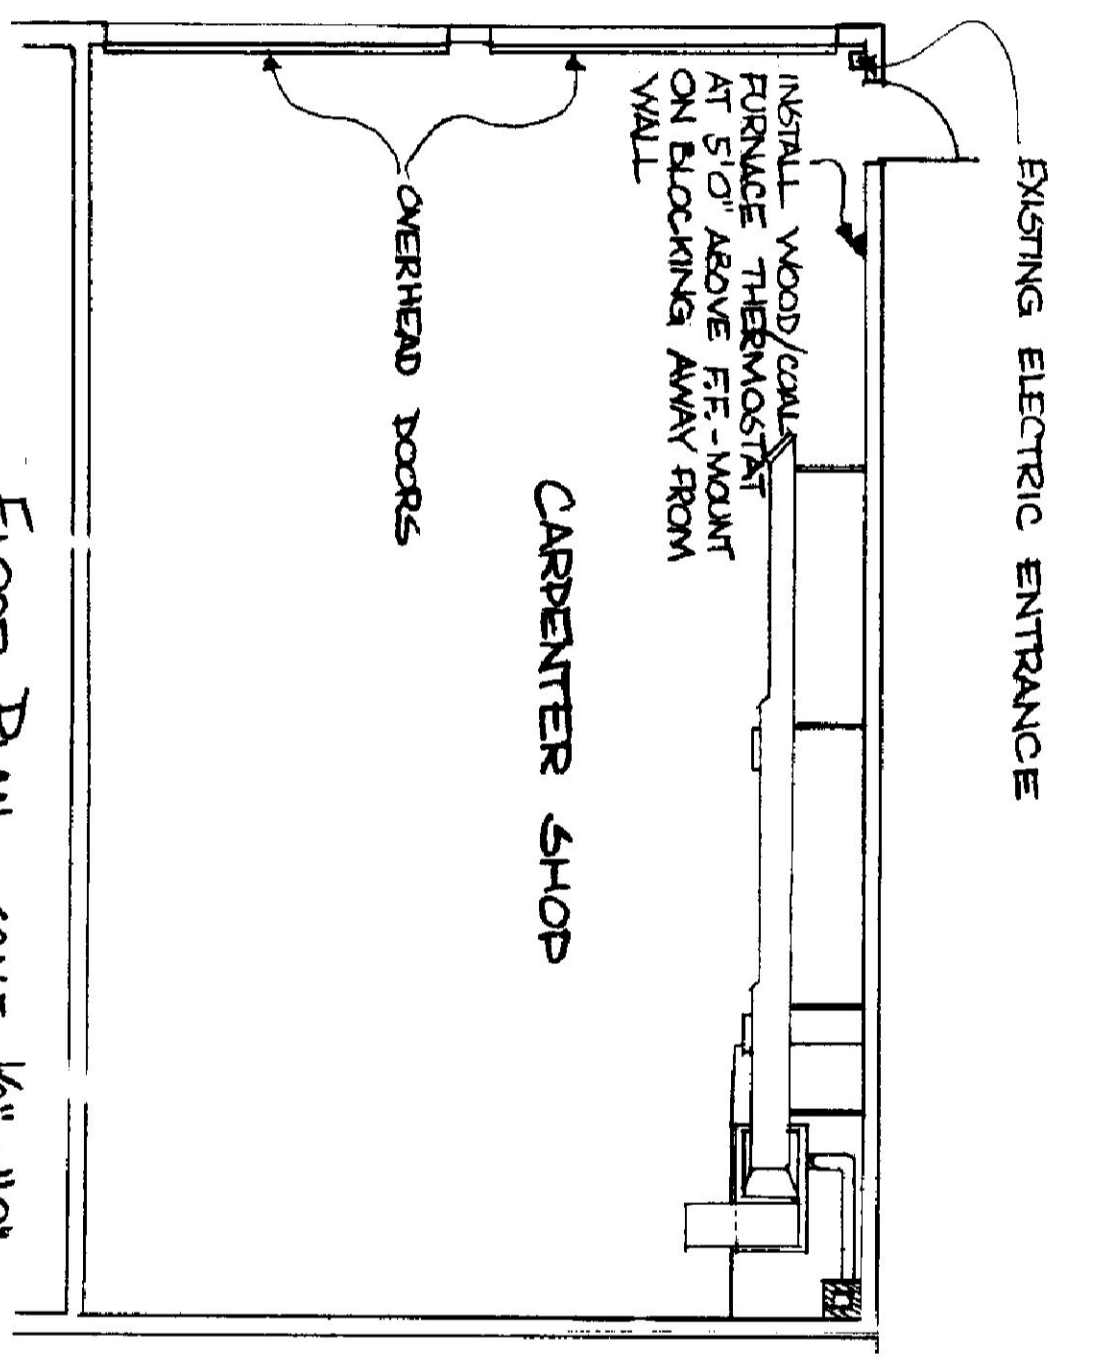

FLOOR PLAN SCALE 1/8" = 1'-0"

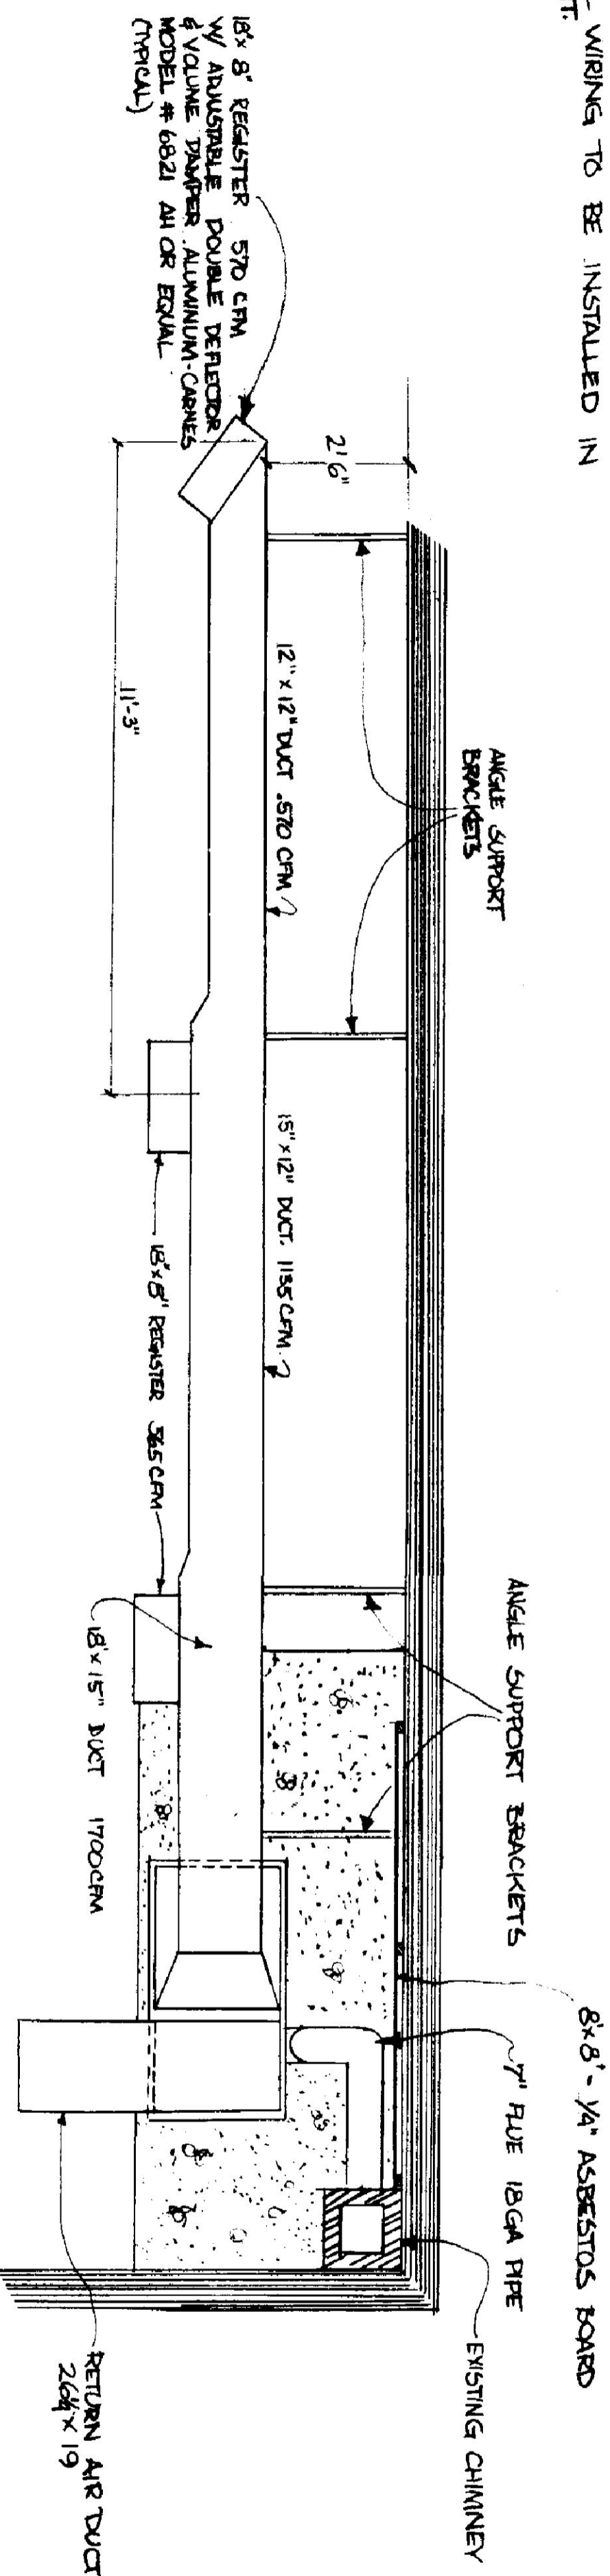

WOOD/COAL FURNACE PLAN SCALE: 3/8" = 1'-0"

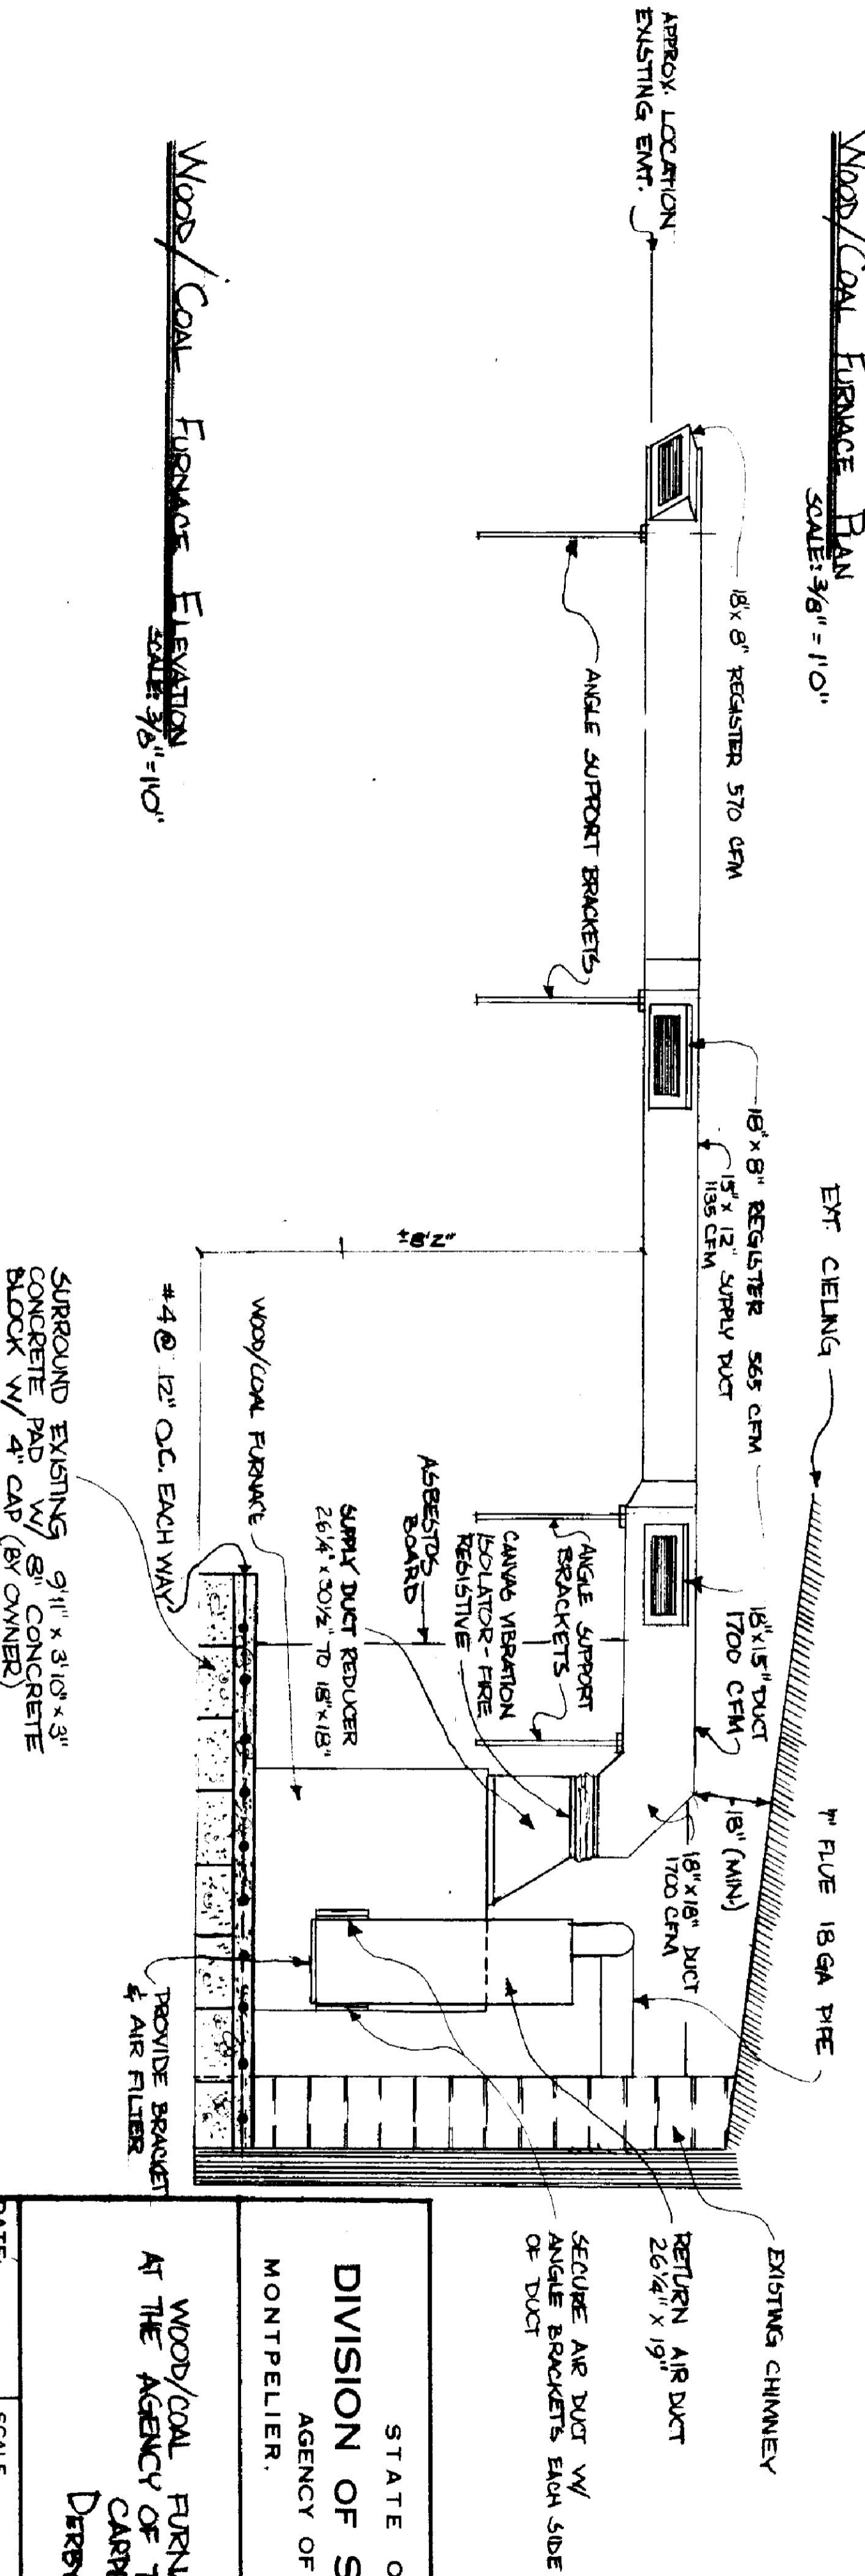

WOOD/COAL FURNACE ELEVATION SCALE: 3/8" = 1'-0"

STATE OF VERMONT			
DIVISION OF STATE BUILDINGS			
AGENCY OF ADMINISTRATION			
MONTPELIER, VERMONT			
WOOD/COAL FURNACE INSTALLATION			
AT THE AGENCY OF TRANSPORTATION GARAGE			
CARPENTER SHOP			
DERBY, VERMONT			
DATE:	SCALE:	REVISIONS:	DWG. NO.
25 JULY, 1981	AS NOTED		
DRAWN BY:	APPROVED BY:		
RJG1	F. TRATT		
			1 OF 1