



FLOOR PLAN

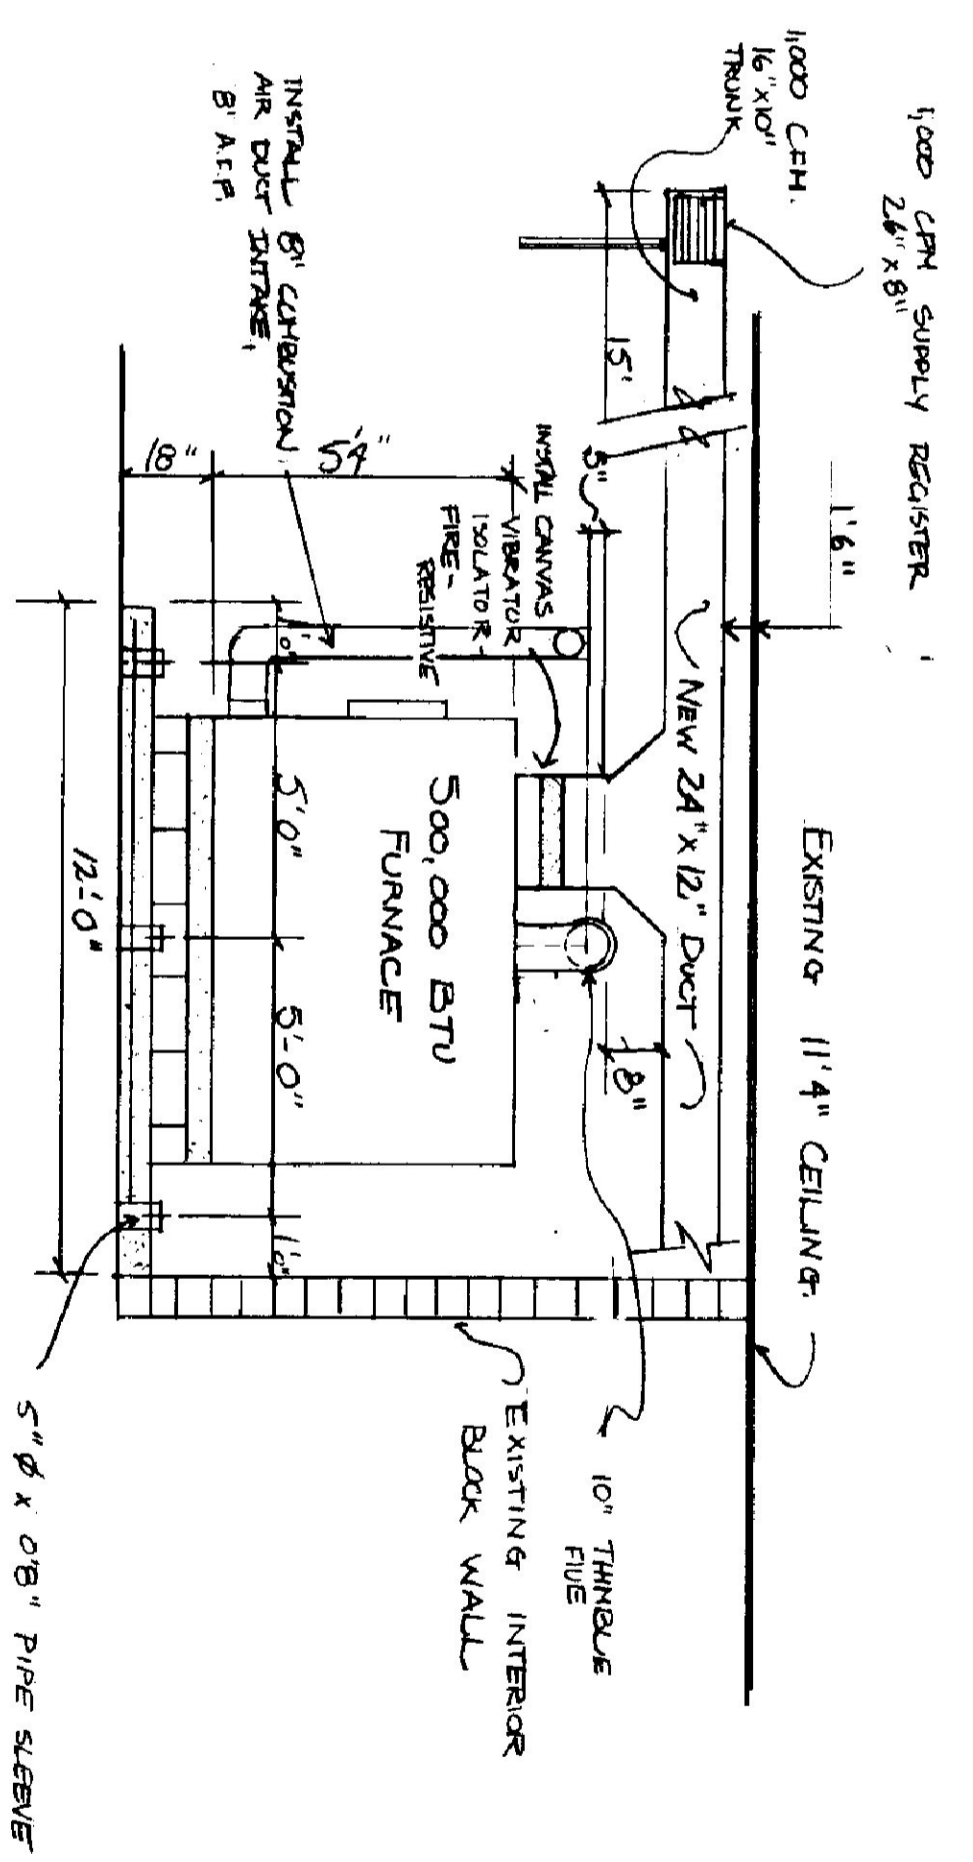


FRONT VIEW

1/4" = 1'0"

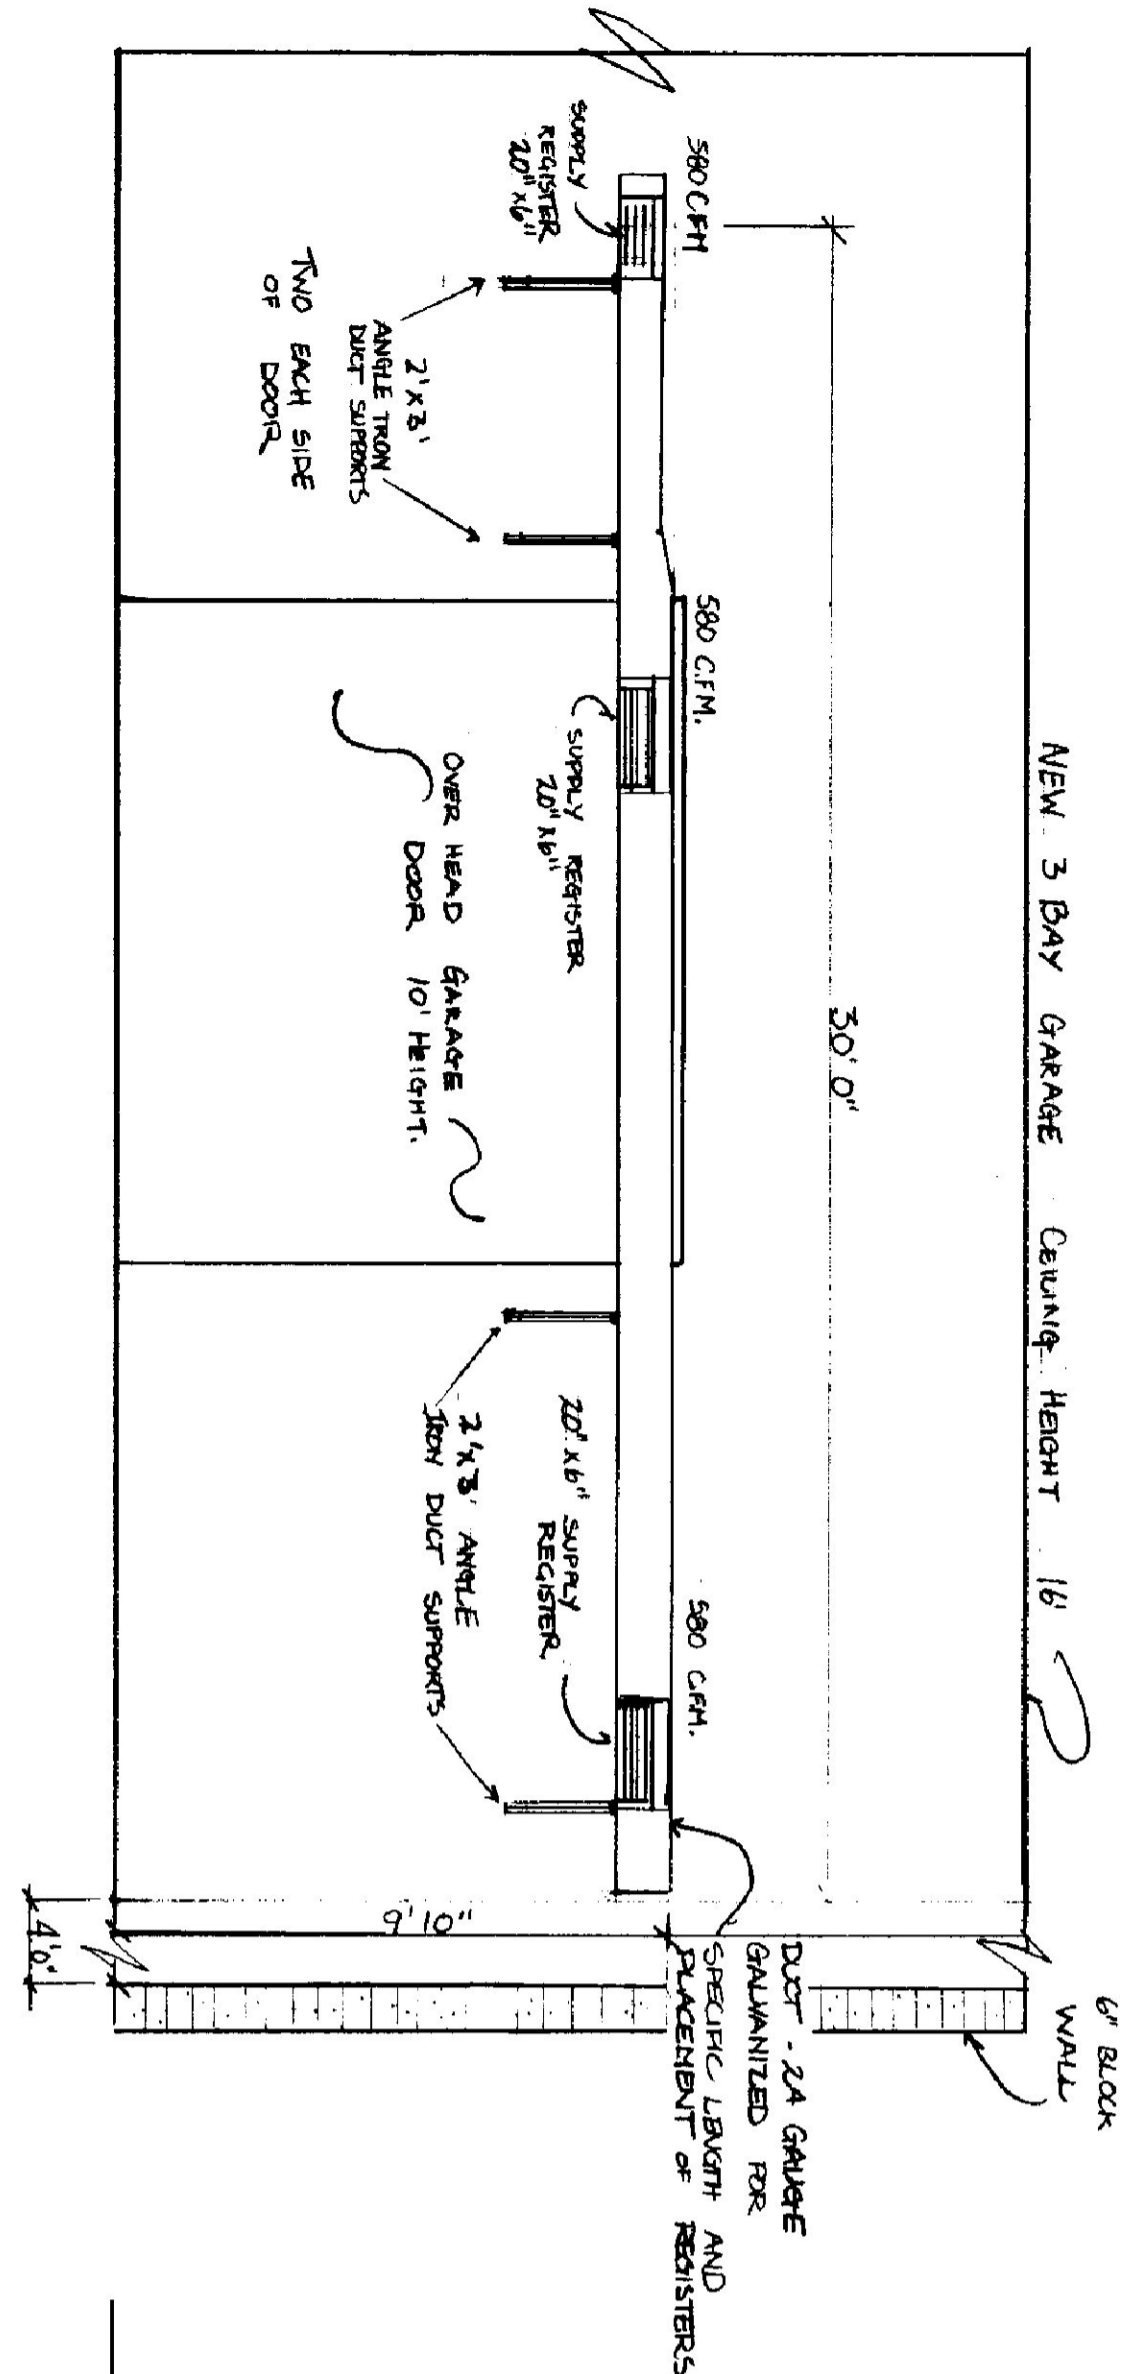

DUCT WORK ELEVATION @ NEW 3 BAY GARAGE AREA

1/4" = 1'0"

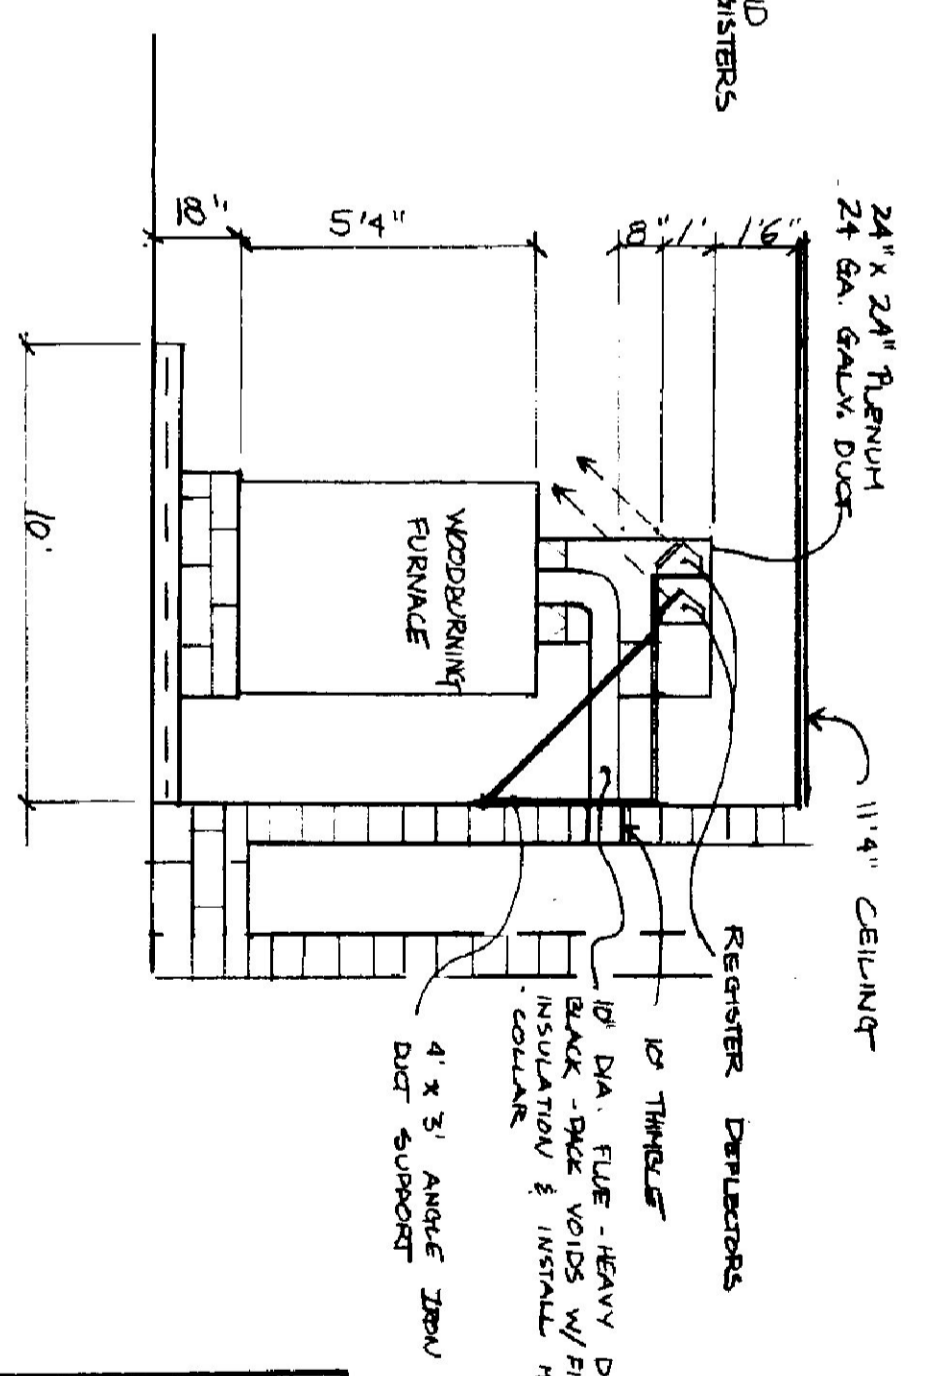

SIDE ELEVATION

1/4" = 1'0"

NOTES:  
 1. TYPICAL: SUPPLY REGISTER ADJUSTABLE DUCT DEFLECTOR W/VOLUME DAMPER-ALUMINUM CARBON MODEL 6821 OR EQUAL  
 2. PROVIDE A PROVED GRADE VOLUME DAMPER (ALUMINUM) BEHIND EACH REGISTER.

STATE OF VERMONT			
DIVISION OF STATE BUILDINGS			
AGENCY OF ADMINISTRATION			
MONTPELIER, VERMONT			
Wood Burning Furnace			
INSTALLATION AGENCY OF TRANSPORTATION			
DERBY GARAGE VERMONT			
DATE:	SCALE:	REVISIONS:	DWG. NO.
9/20/81	AS NOTED		
DRAWN BY:	APPROVED BY:		
L. J. J. J.			
			OF

