





FLOOR PLAN - SANITARY & VENT
SCALE: 1/8" = 1'-0"

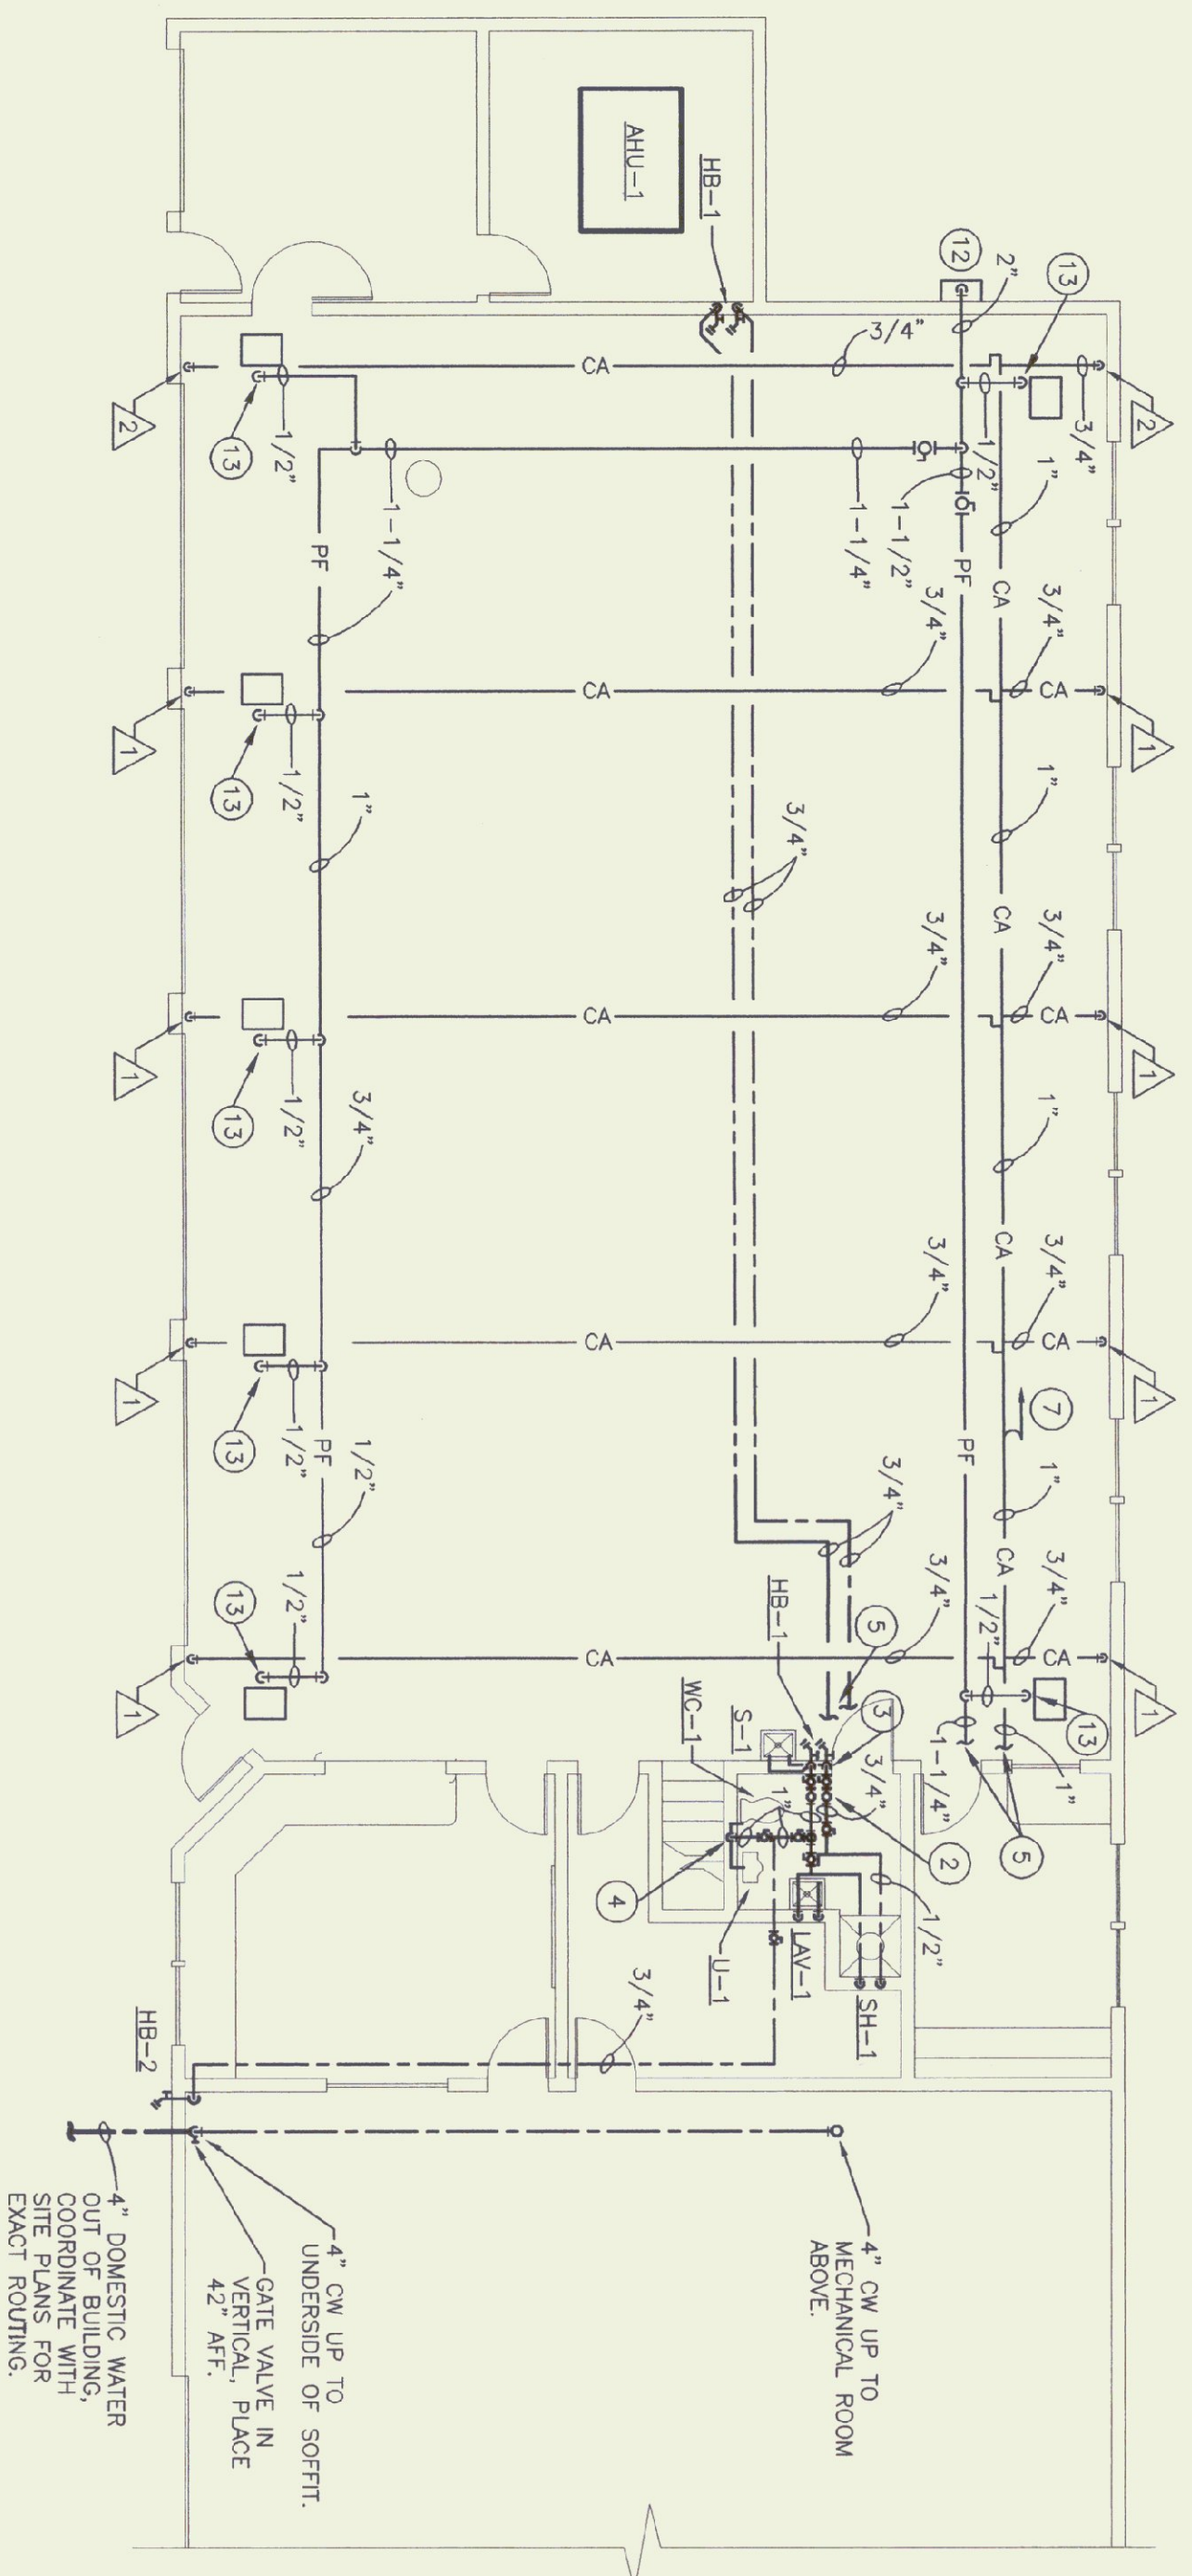

FLOOR PLAN - DOMESTIC & OTHER PIPING
SCALE: 1/8" = 1'-0"

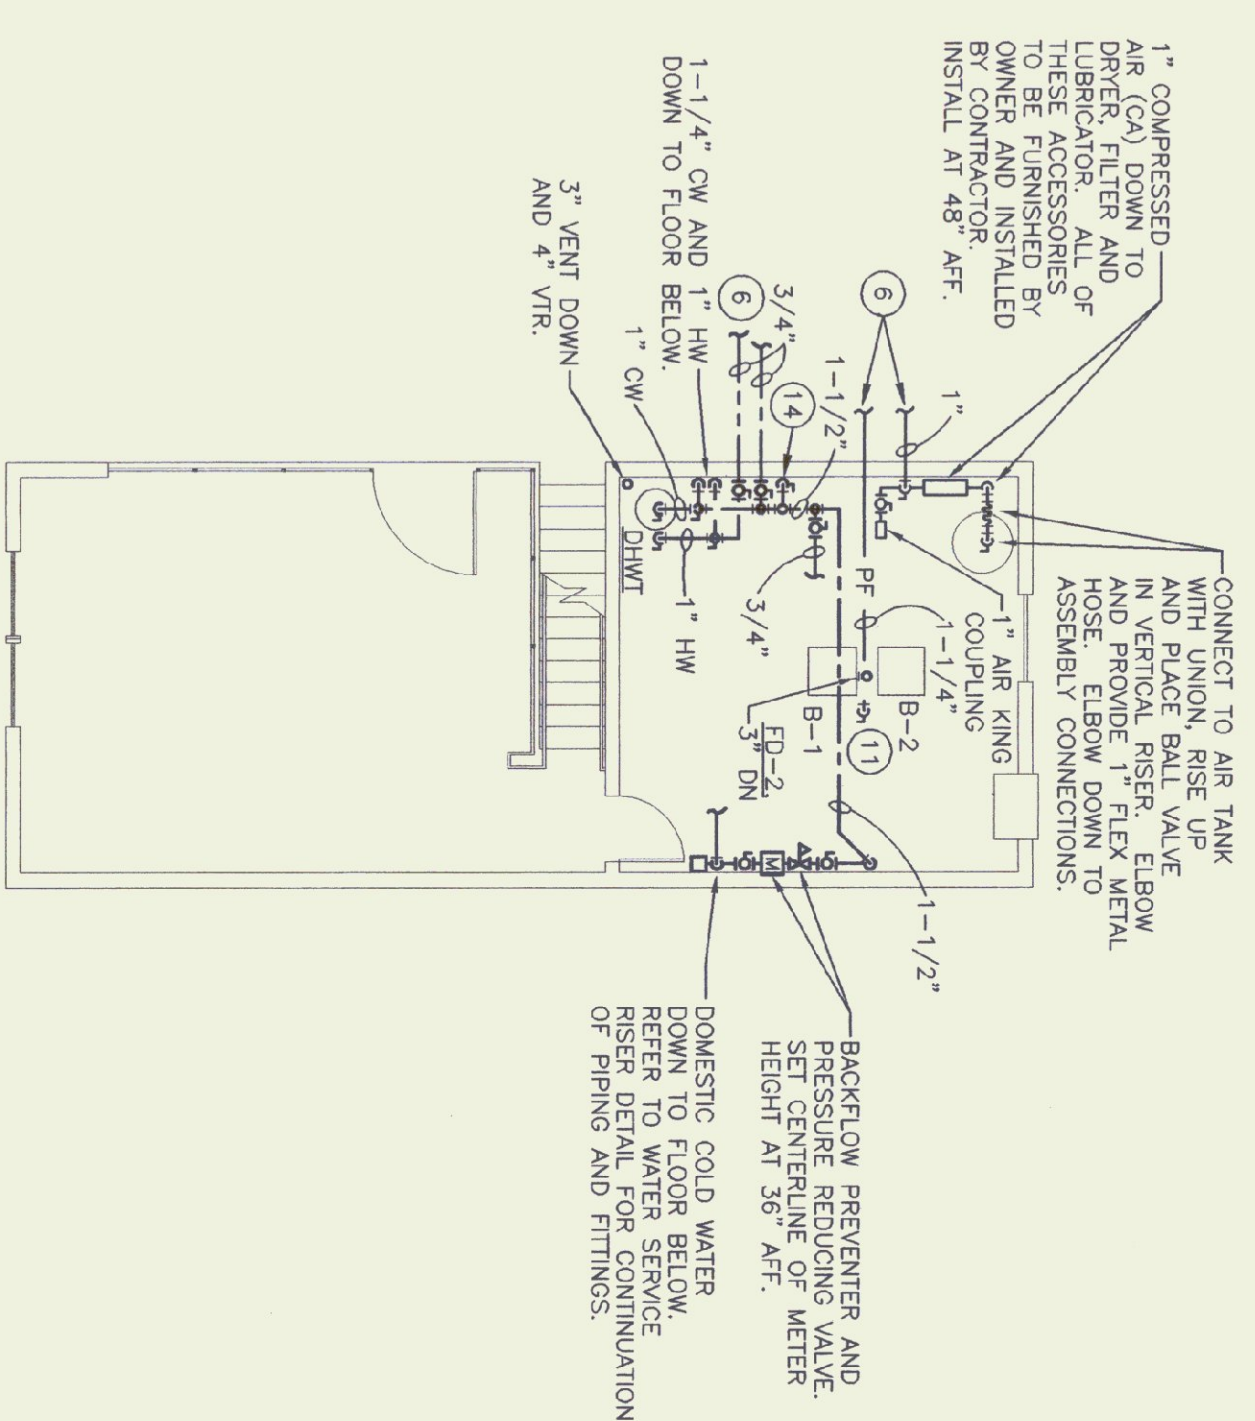


SECOND FLOOR PLAN
SCALE: 1/8" = 1'-0"

GENERAL NOTES:
A. FOR THE TRIANGLE NOTES ON THIS SHEET, REFER TO DRAWING P2 FOR CLARIFICATION.

KEYED NOTES:

- 1 TRANSITION IN VERTICAL, GOING THROUGH THE FLOOR FROM THE 2" TRAP TO 1/2" DRAIN FOR MECH RM. TERMINATE PIPE 2" ABOVE THE FINISHED FLOOR LEVEL.
- 2 1-1/4" CW AND 1" HW UP TO SECOND FLOOR.
- 3 DROP DOWN IN WALL WITH 1" CW AND 1" HW TO HB-1. IN PROP. TEE OFF WITH 1/2" CW & HW TO S-1. THEN TRANSITION TO 3/4" FOR CONNECTION TO HB-1.
- 4 1" DOWN TO WC-1 AND U-1.
- 5 FOR CONTINUATION, REFER TO SECOND FLOOR PLAN.
- 6 FOR CONTINUATION, REFER TO FLOOR PLAN - DOMESTIC & OTHER PIPING.
- 7 PITCH COMPRESSED AIR PIPING DOWN TOWARDS THE END OF THE BUILDING.
- 8 EXISTING FLOOR DRAIN (EFD) TO REMAIN, NO NEW WORK.
- 9 2" SANITARY DOWN IN WALL, 1-1/2" VENT UP TO CEILING TO CONNECT TO 2" MAIN VENT.
- 10 1-1/2" VENT UP FROM 2" SANITARY DRAIN FOR SH-1. CONNECT 1-1/2" VENT TO 2" MAIN VENT.
- 11 1-1/4" PIPE FOR PROPANE DOWN TO BOILER BURNERS. TEE OFF WITH VALVES IN VERTICAL DROPS AND UNIONS AT CONNECTIONS TO BOILER BURNERS.
- 12 PROPANE REGULATOR AND TANK(S) TO BE PROVIDED BY PROPANE SUPPLIER. OWNER TO CONTRACT AND COORDINATE WITH PROPANE SUPPLIER. PC TO CONNECT PIPING FROM REGULATOR AND RUN AS SHOWN ON DRAWINGS. PC TO PROVIDE UNION FOR CONNECTION AT REGULATOR.
- 13 1/2" PIPE FOR PROPANE DOWN TO INFRA-RED HEATER (H-1). PROVIDE CONNECTION TO BALL VALVE FOR SHUT-OFF AND UNION FOR CONNECTION TO MANUFACTURER'S INSTALLATION INSTRUCTIONS FOR PIPING CONNECTIONS, ACCESSORIES AND RECOMMENDATIONS.
- 14 3/4" COLD WATER LINE DOWN TO HOSE BIBB (HB-3). MOUNT HB-3 AT 36" AFF.

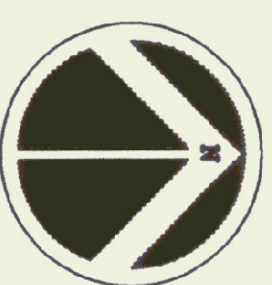

Gossens Bachman
Architecture and Interior Design

Gossens Bachman, Inc.
95 Granite Street, Suite 03602
North Ferrisburgh, Vermont 05602
Tel: 802.229.1894
Fax: 802.229.4822
Email: GossBach@aol.com

Pedron & Associates
MECHANICAL & ELECTRICAL ENGINEERS
111 North Ferrisburgh Road
North Ferrisburgh, Vermont 05602
Tel: 802.229.1894
Fax: 802.229.4822
Email: pedron@pedron.com



Project Title:
STATE OF VERMONT
AGENCY OF TRANSPORTATION
DISTRICT NO. 9
MAINTENANCE GARAGE

DESIGNER:
DERBY, VERMONT

Revisions:
Job Number: AOT9
File Name: AOT9
Drawn By: TTY
Checked By: EZP
Seal: As Shown
Date: August 1999

Sheet Title:
Plumbing Plans

Sheet Number:

P1