


FUEL OIL TANK & PIPING


N.T.S.

NOTE: CAP ALL UNUSED OPENINGS IN TANK

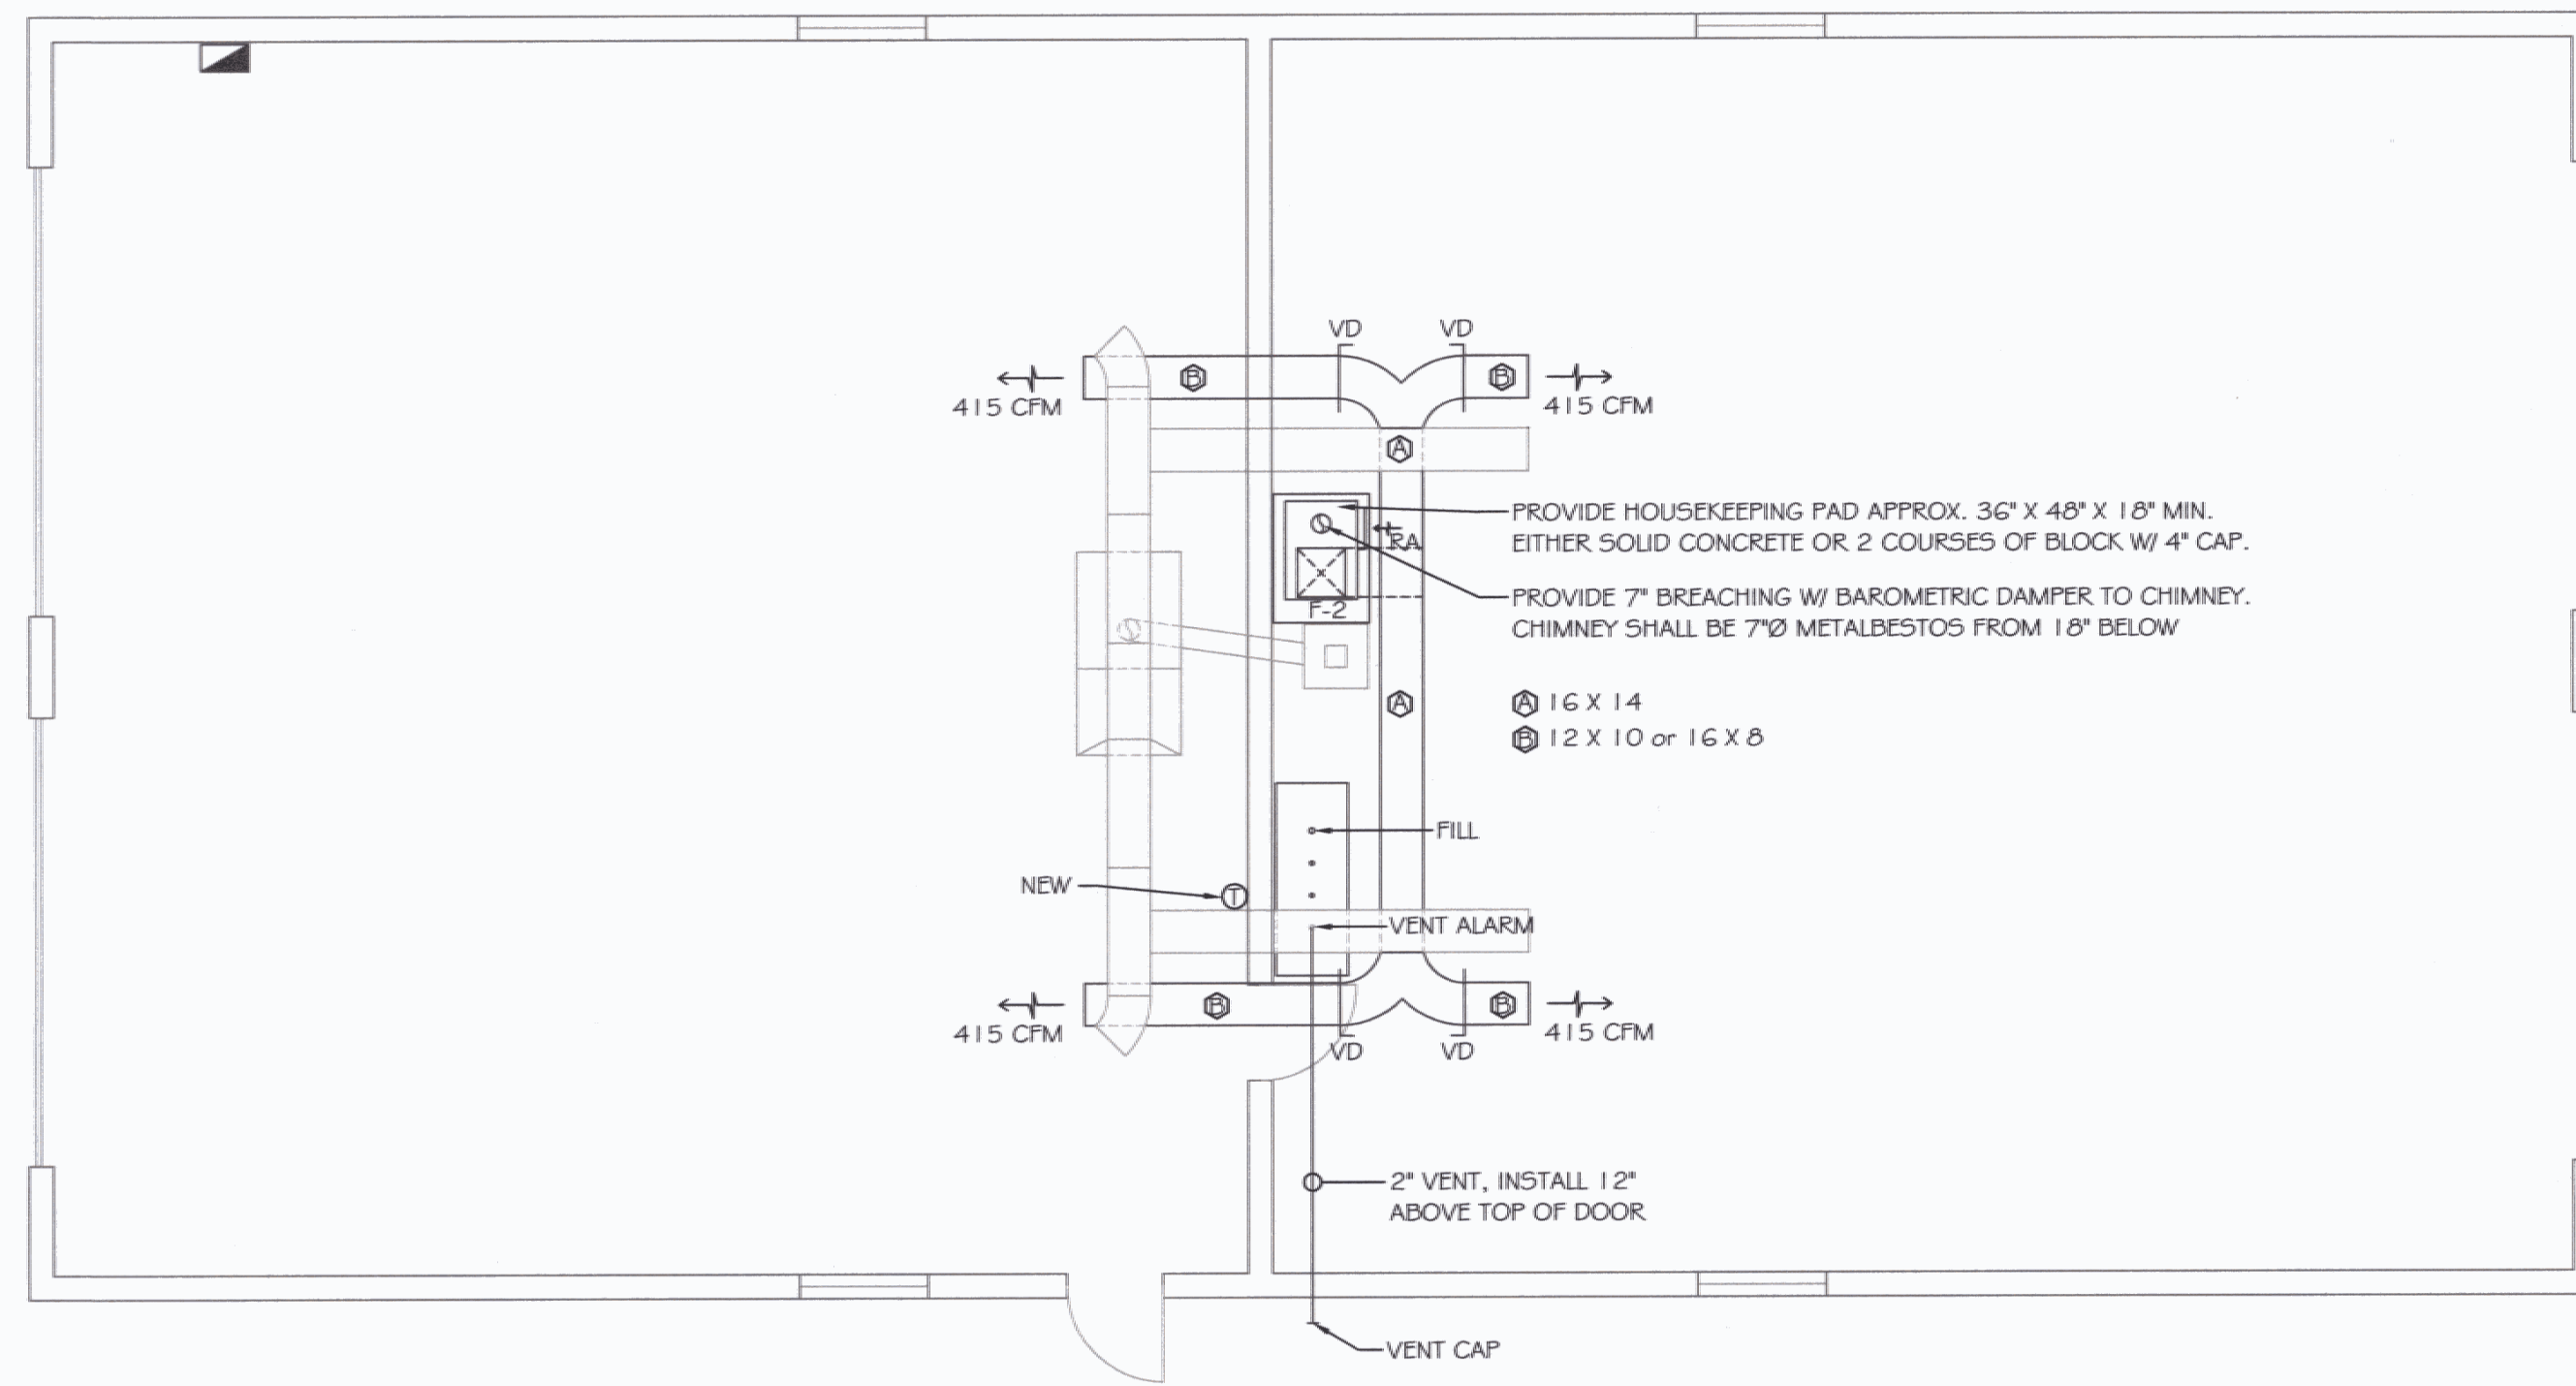

4 BAY GARAGE

SCALE : 3/16 = 1'-0"

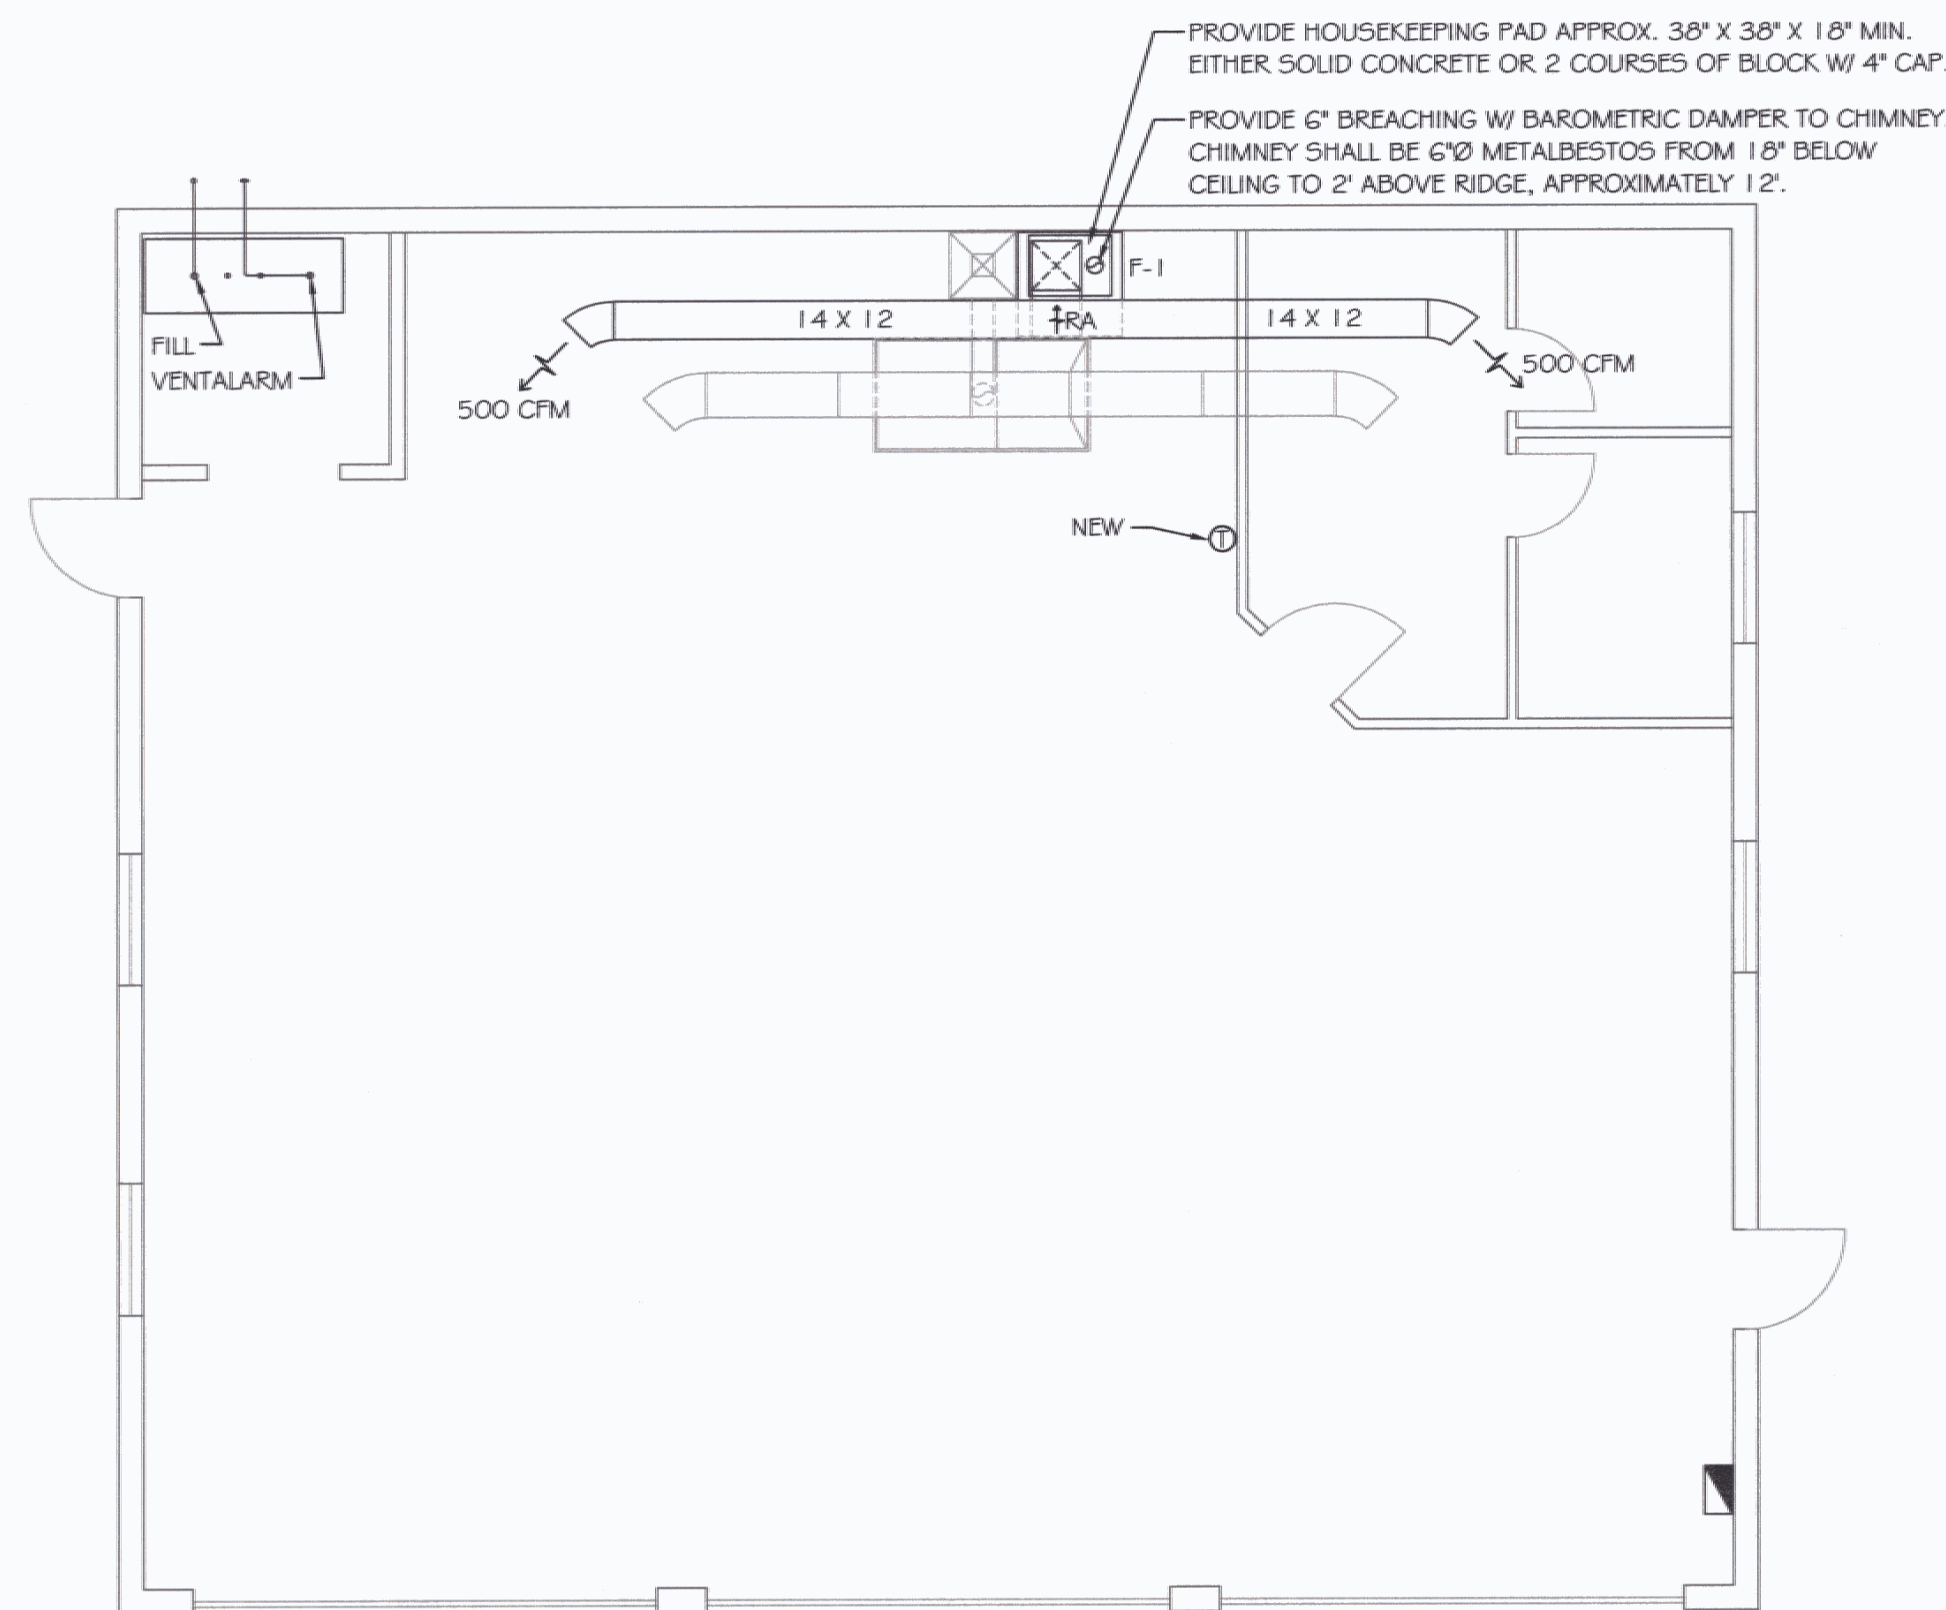

3 BAY GARAGE


SCALE : 3/16 = 1'-0"

FURNACE SCHEDULE


ITEM	MODEL / MAKE	BTU INPUT	FUEL	CFM	FUEL SIZE
F-1	THERMOPRIDE / OH-3	91,000	#2 OIL	1000	6"
F-2	THERMOPRIDE / OH-16	154,000	#2 OIL	1660	7"

ELECTRICAL NOTES:


1. PROVIDE NEW BREAKERS FOR FURNACE.
2. ALL WIRING FROM PANEL TO FURNACE TO BE IN EMT.
3. FINAL CONNECTION TO FURNACE TO BE IN FLEXIBLE CONDUIT.
4. PROVIDE FIREMATIC AT EACH FURNACE.
5. ALL WORK SHALL BE IN ACCORDANCE WITH NEC.
6. LABEL NEW THERMOSTATS AS BEING FOR OIL FURNACE.

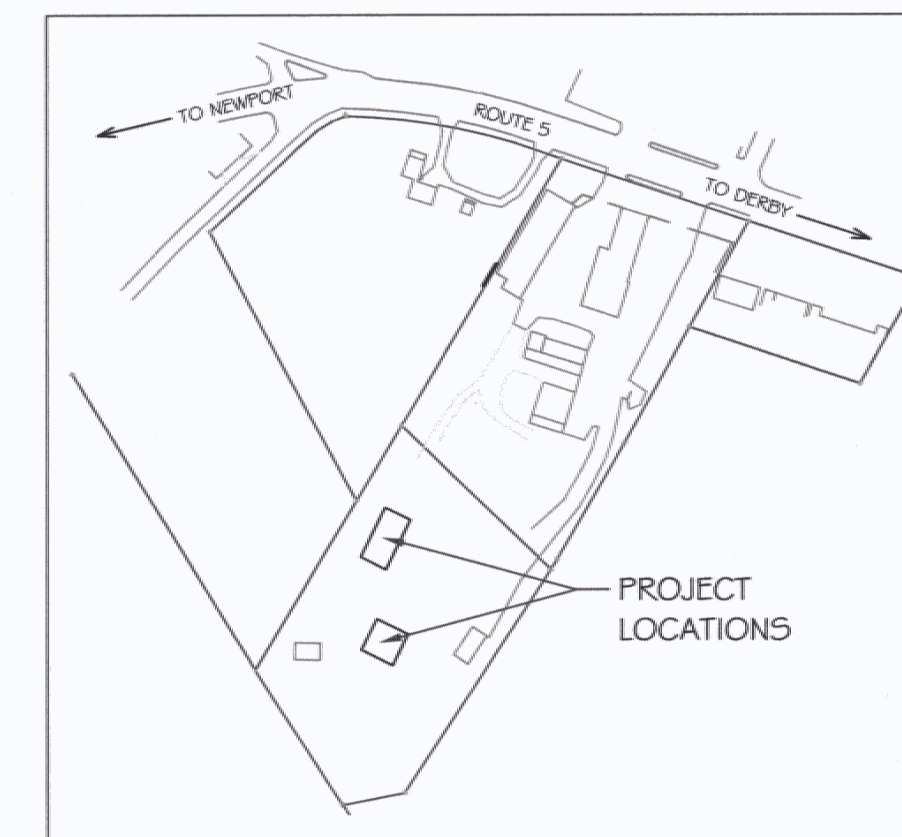


SITE PLAN

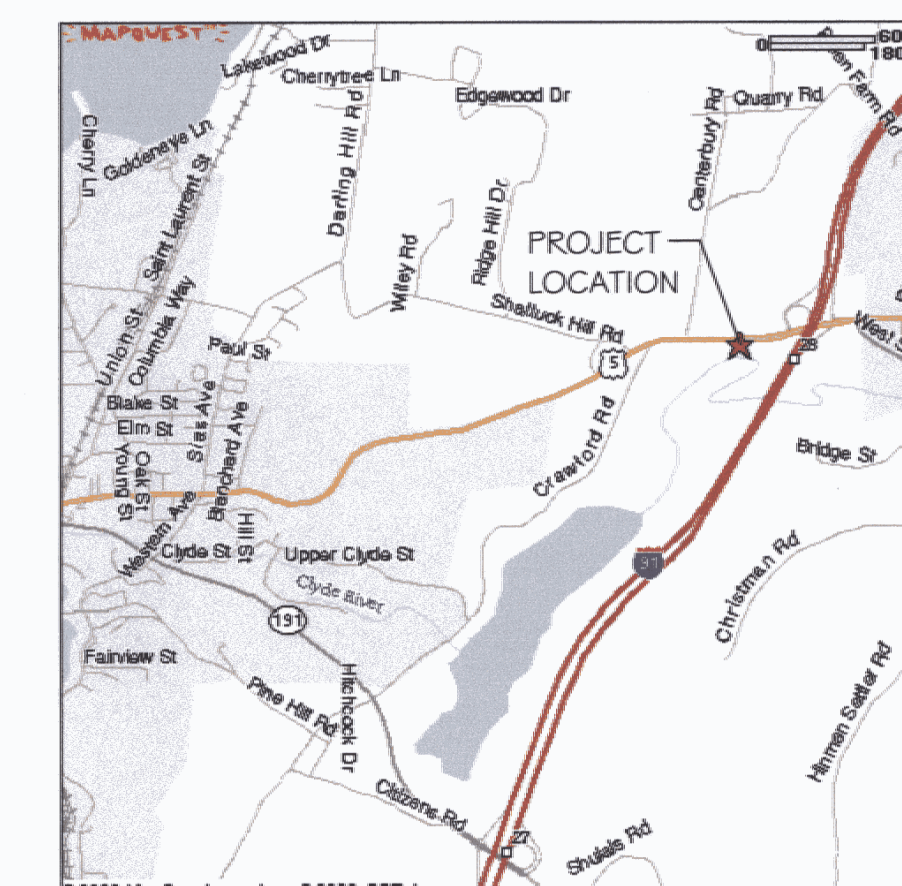

PROJECT LOCATION

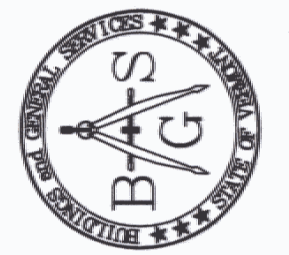

STATE OF VERMONT
 Department of Buildings
 and General Services
 Agency of Administration
 Montpelier, Vermont

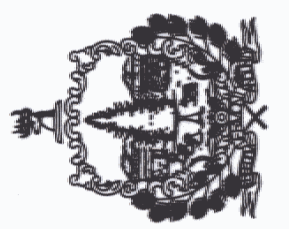

VERMONT

**DERBY A.O.T. GARAGE
 3 AND 4 BAY GARAGES
 FLOOR PLANS**

DERBY.

REVISIONS

SCALE: AS NOTED
DATE: NOVEMBER 2003
DRAWN BY: N. HERSEY
APPR. BY: TEIGH

DERBY A.O.T.
 GARAGE
 3 AND 4 BAY
 GARAGES
 FLOOR PLANS

A-1

1 OF 1