


**FUEL OIL TANK & PIPING**


N.T.S.

NOTE: CAP ALL UNUSED OPENINGS IN TANK

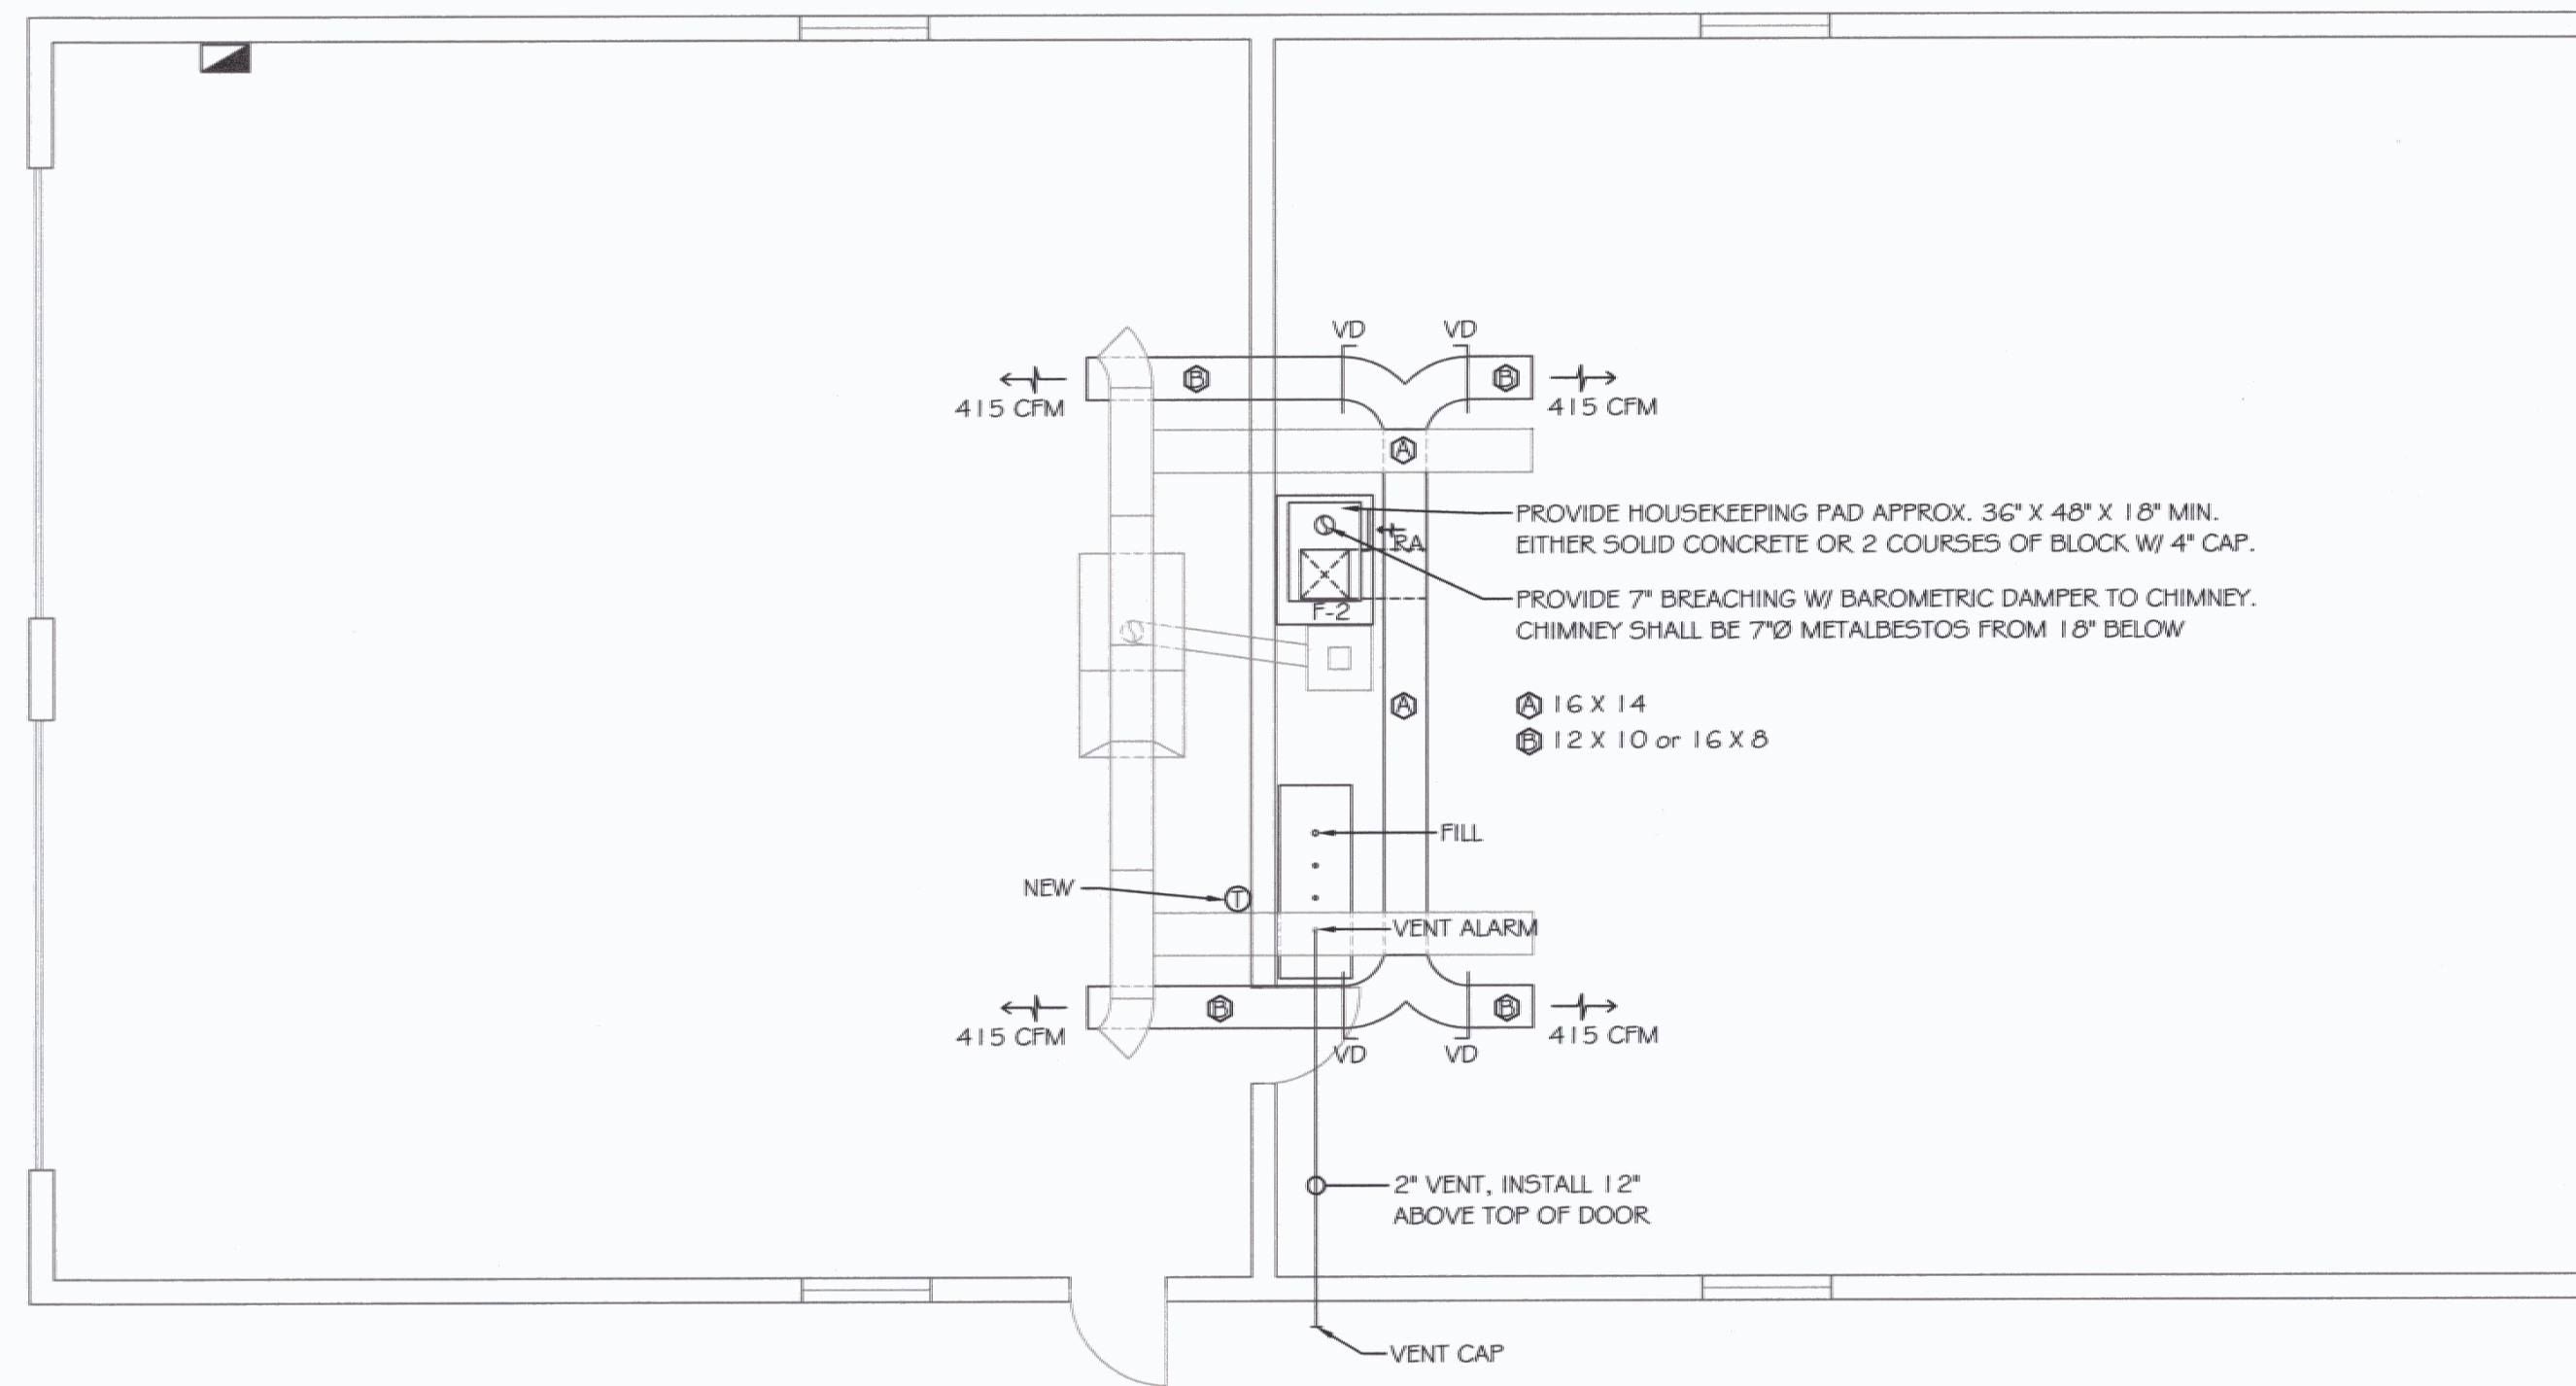

**4 BAY GARAGE**

SCALE: 3/16" = 1'-0"

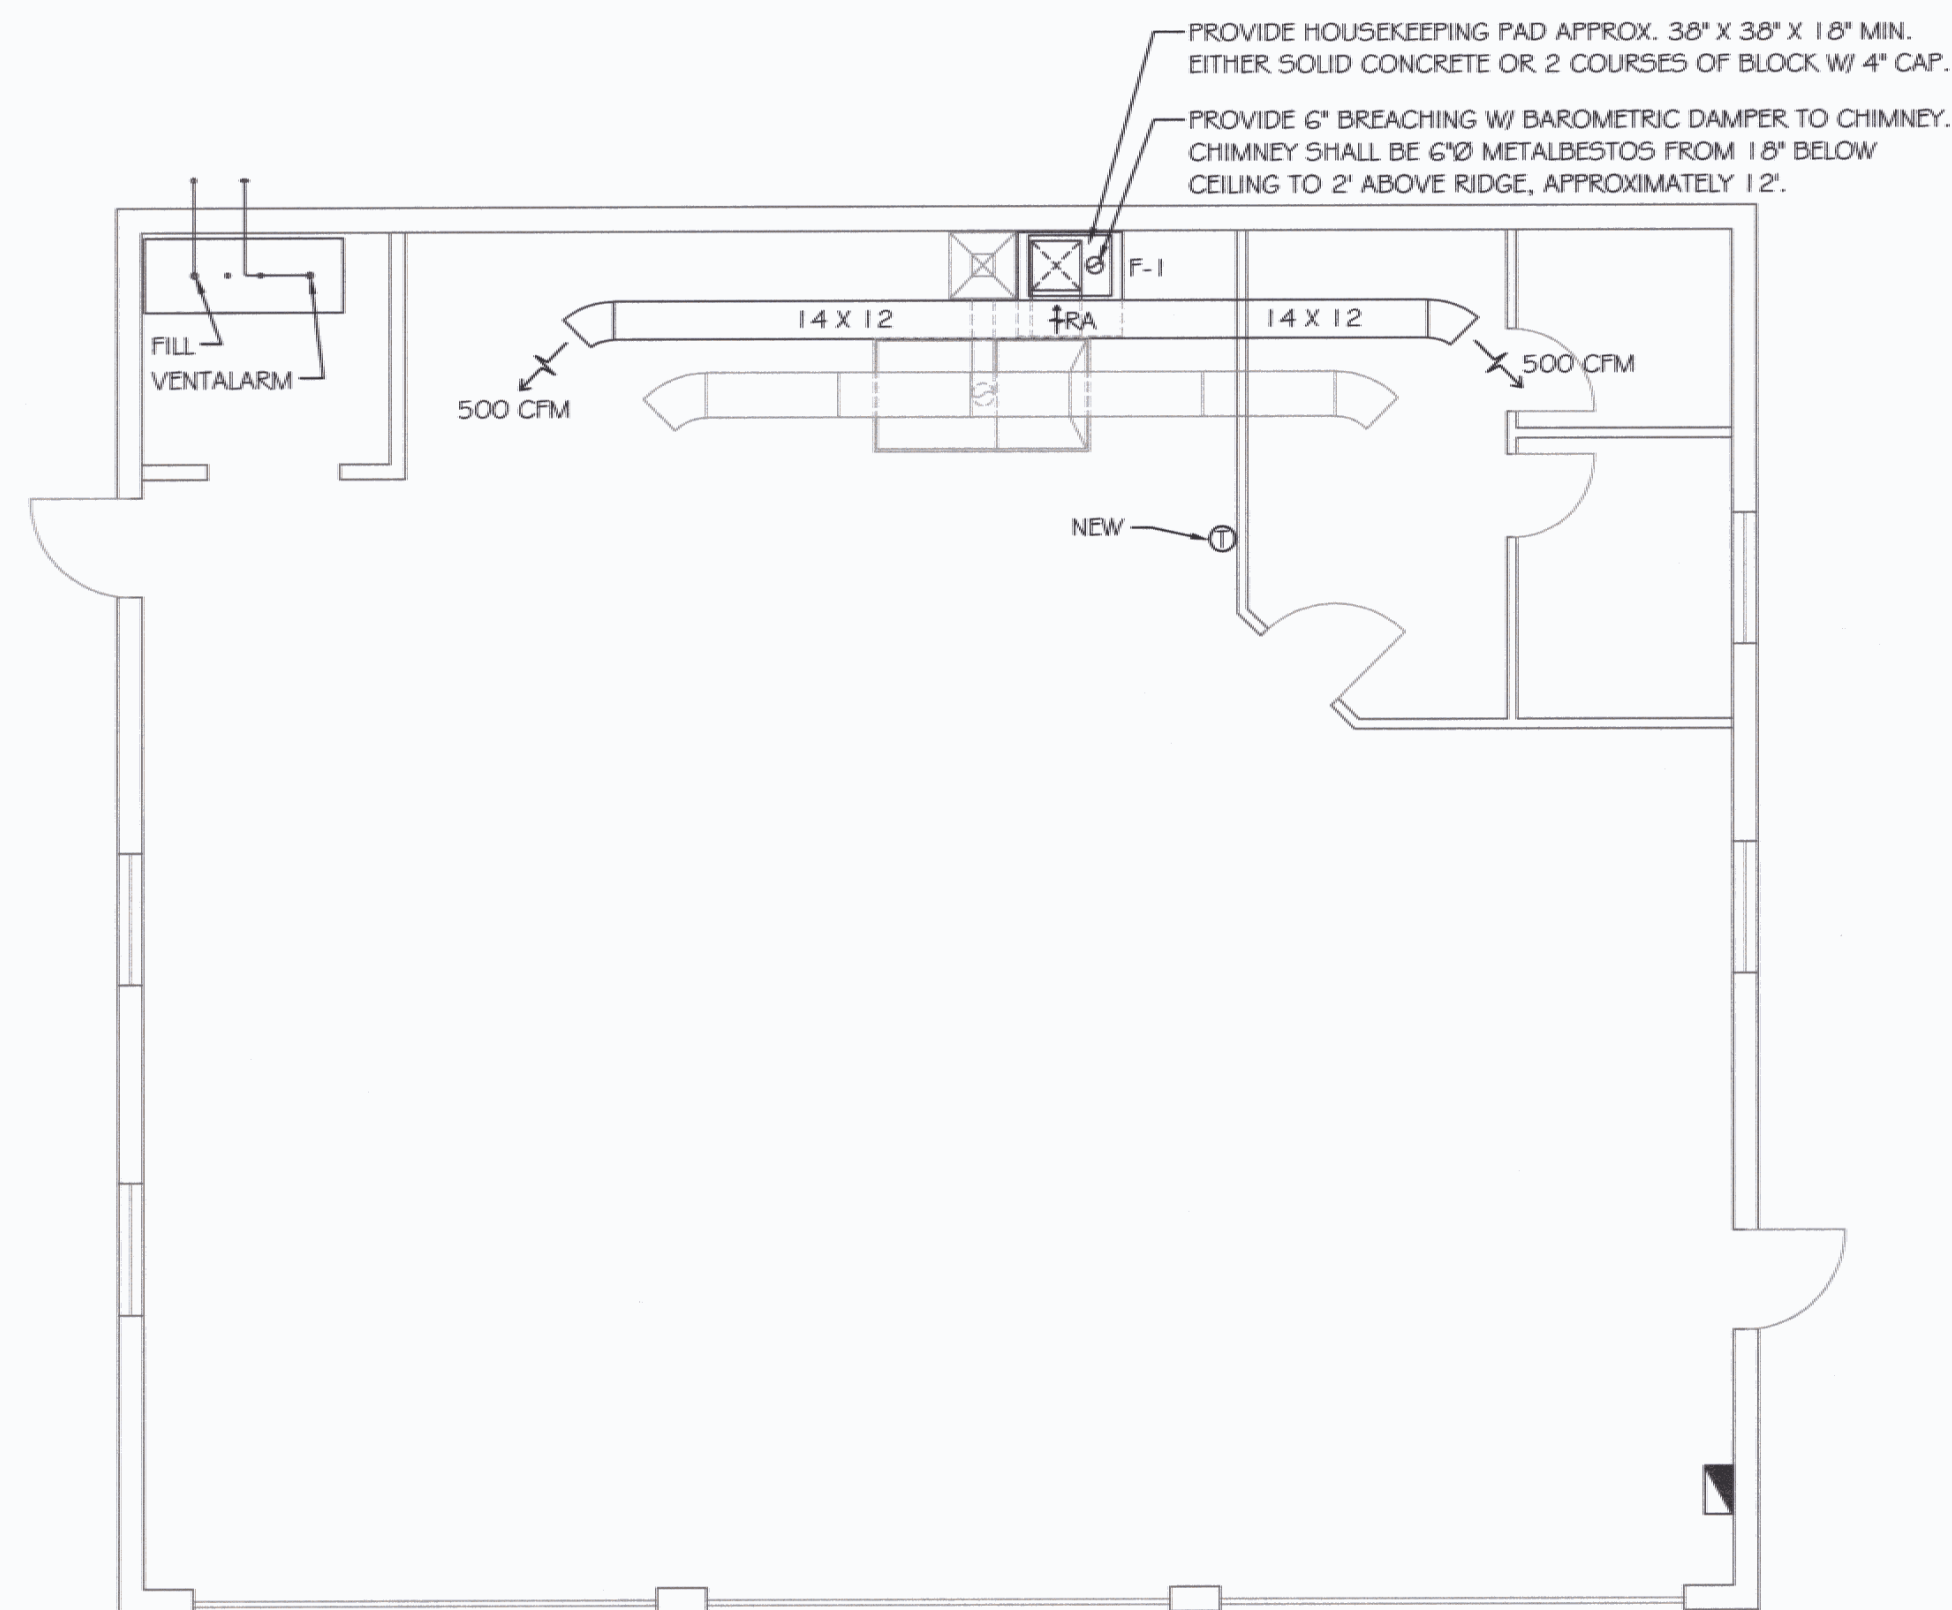

**3 BAY GARAGE**


SCALE: 3/16" = 1'-0"

**FURNACE SCHEDULE**


ITEM	MODEL / MAKE	BTU INPUT	FUEL	CFM	FUEL SIZE
F-1	THERMOPRIDE / OH-3	91,000	#2 OIL	1000	6"
F-2	THERMOPRIDE / OH-16	154,000	#2 OIL	1660	7"

**ELECTRICAL NOTES:**


1. PROVIDE NEW BREAKERS FOR FURNACE.
2. ALL WIRING FROM PANEL TO FURNACE TO BE IN EMT.
3. FINAL CONNECTION TO FURNACE TO BE IN FLEXIBLE CONDUIT.
4. PROVIDE FIREMATIC AT EACH FURNACE.
5. ALL WORK SHALL BE IN ACCORDANCE WITH NEC.
6. LABEL NEW THERMOSTATS AS BEING FOR OIL FURNACE.

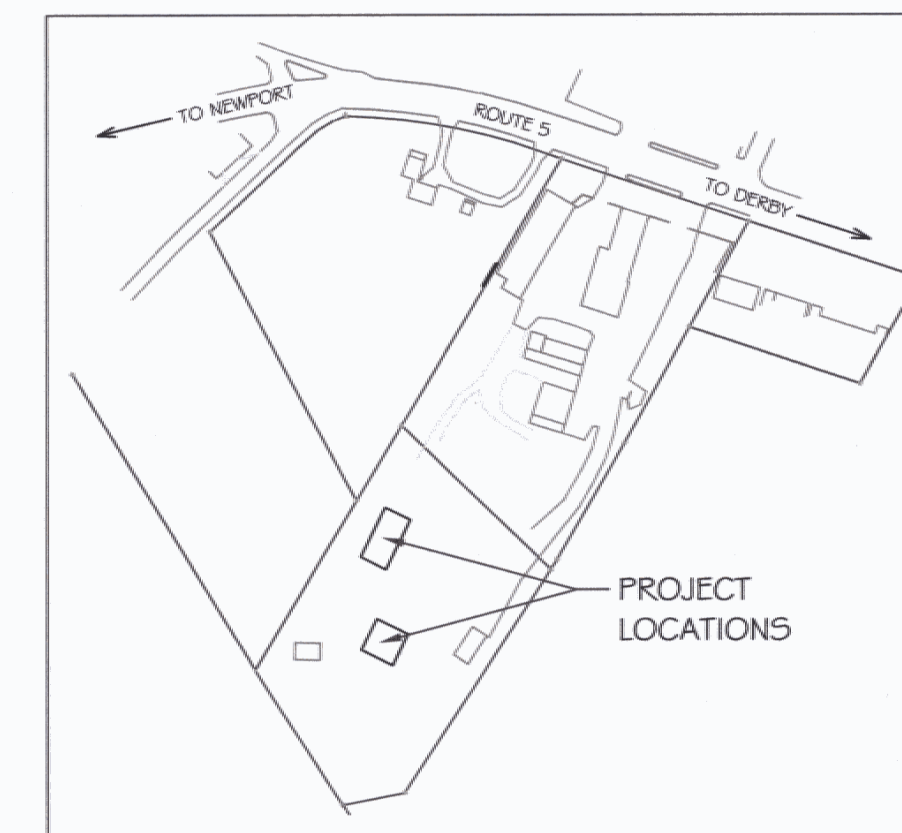


**SITE PLAN**

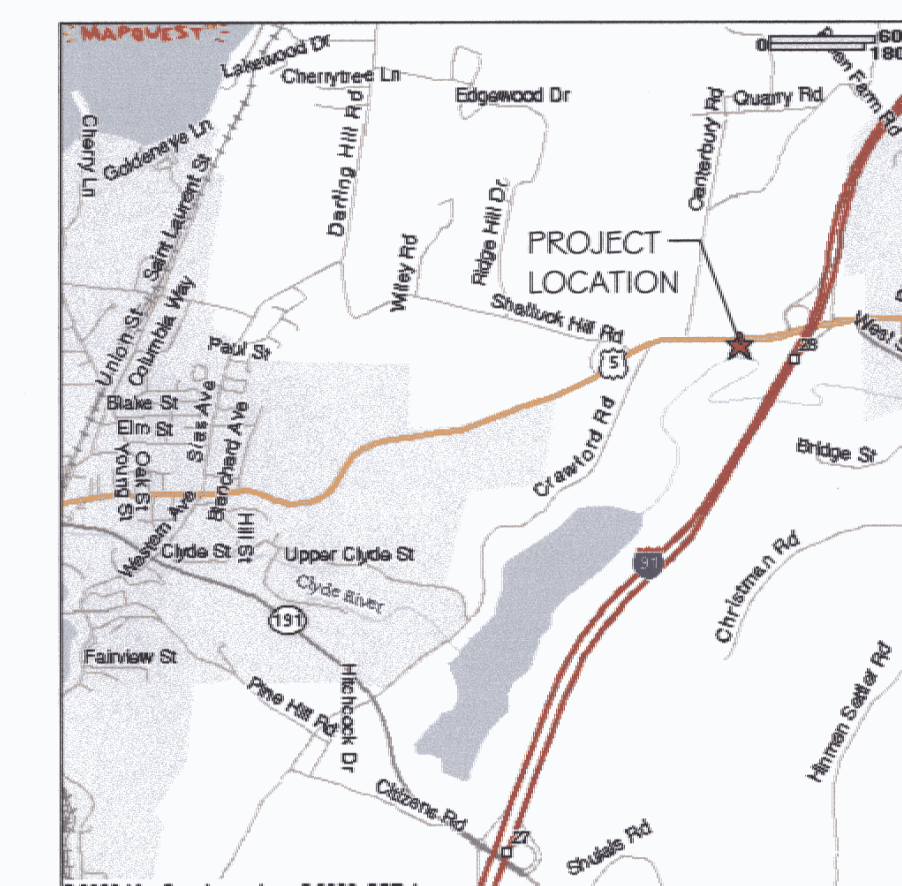

**PROJECT LOCATION**

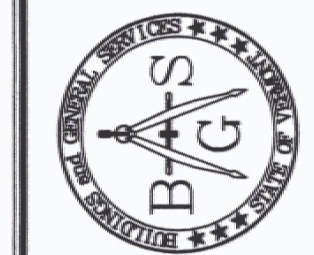

STATE OF VERMONT  
 Department of Buildings  
 and General Services  
 Agency of Administration  
 Montpelier, Vermont

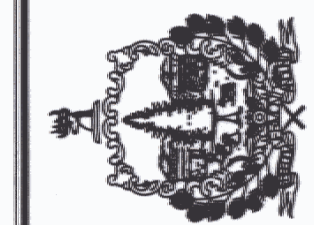

VERMONT

**DERBY A.O.T. GARAGE  
 3 AND 4 BAY GARAGES  
 FLOOR PLANS**

DERBY.

REVISIONS

SCALE: AS NOTED	DATE: NOVEMBER 2003
DRAWN BY: N. HERSEY	APPR. BY: TEIGH

DERBY A.O.T.  
 GARAGE  
 3 AND 4 BAY  
 GARAGES  
 FLOOR PLANS

**A-1**

1 OF 1