
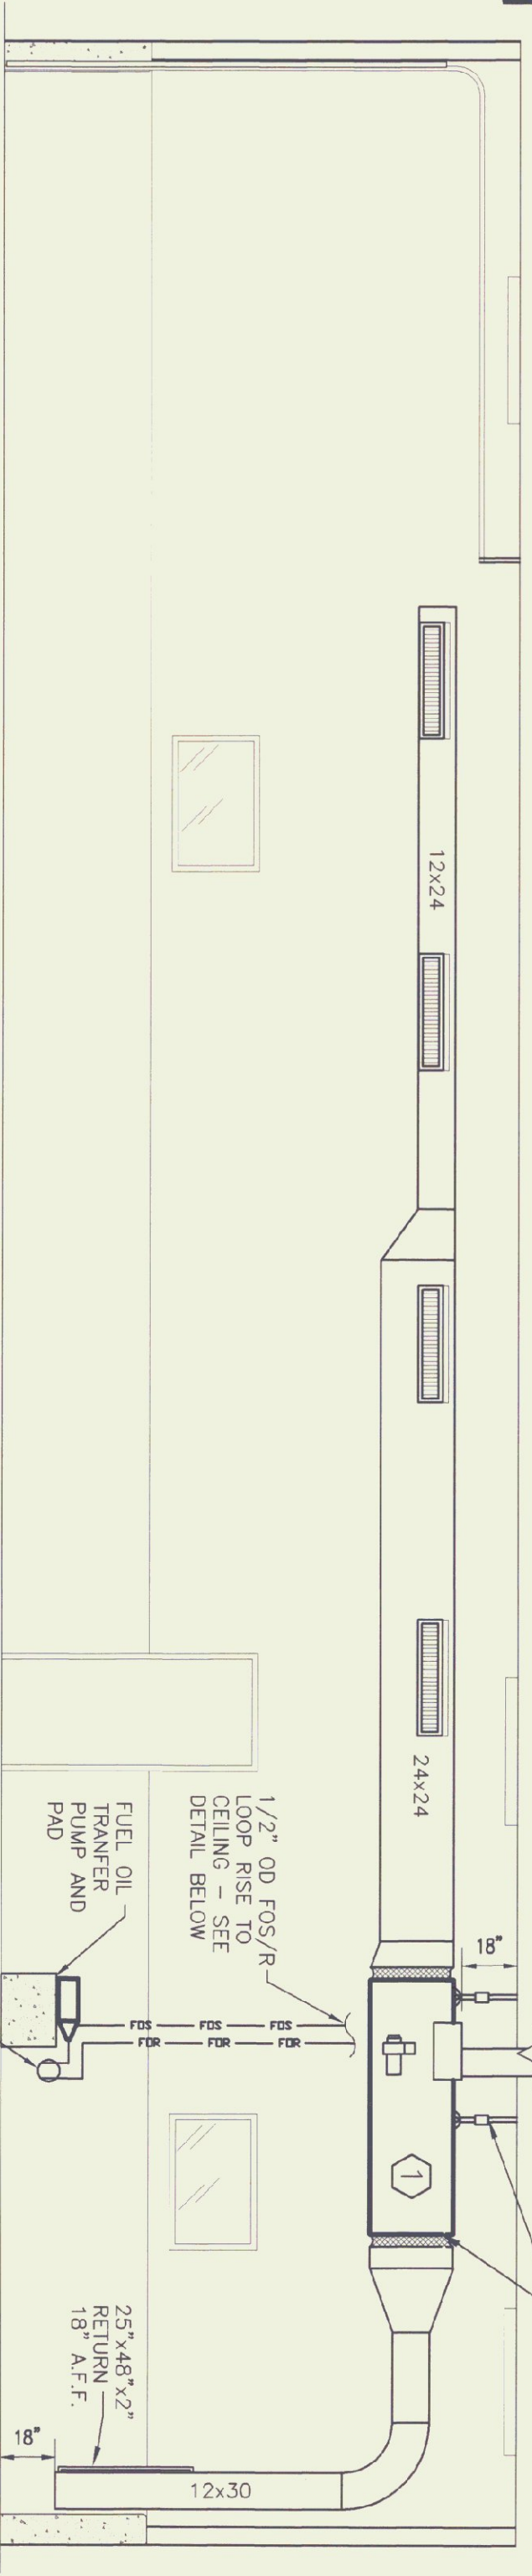
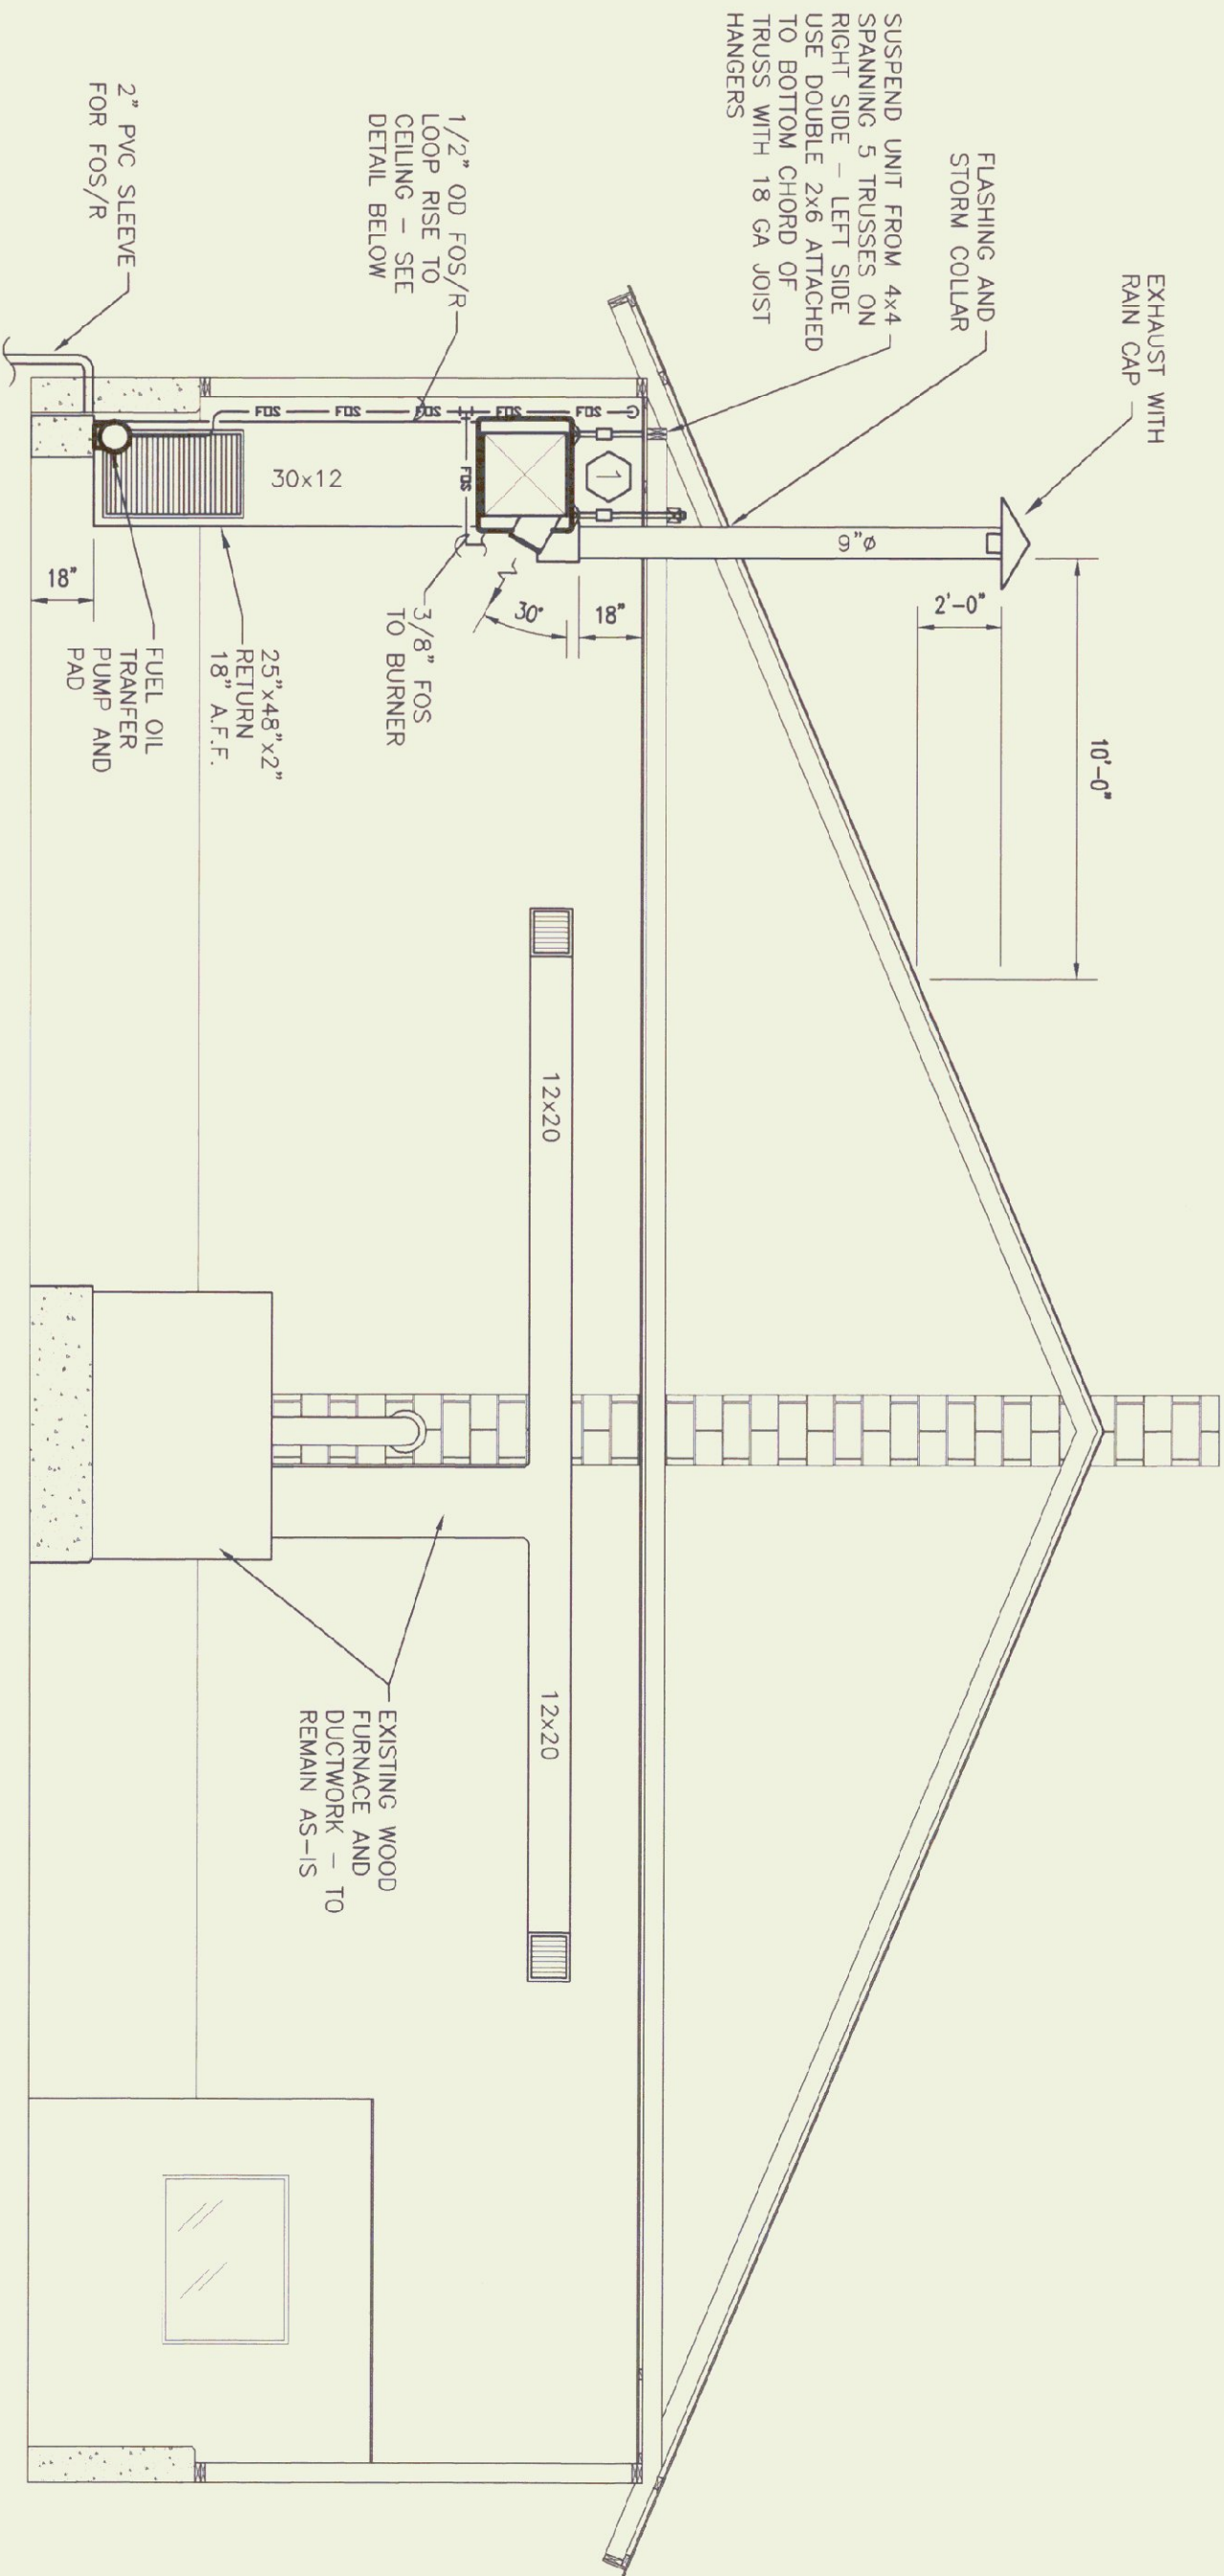


FLOOR PLAN

SCALE: 1/4" = 1'-0"

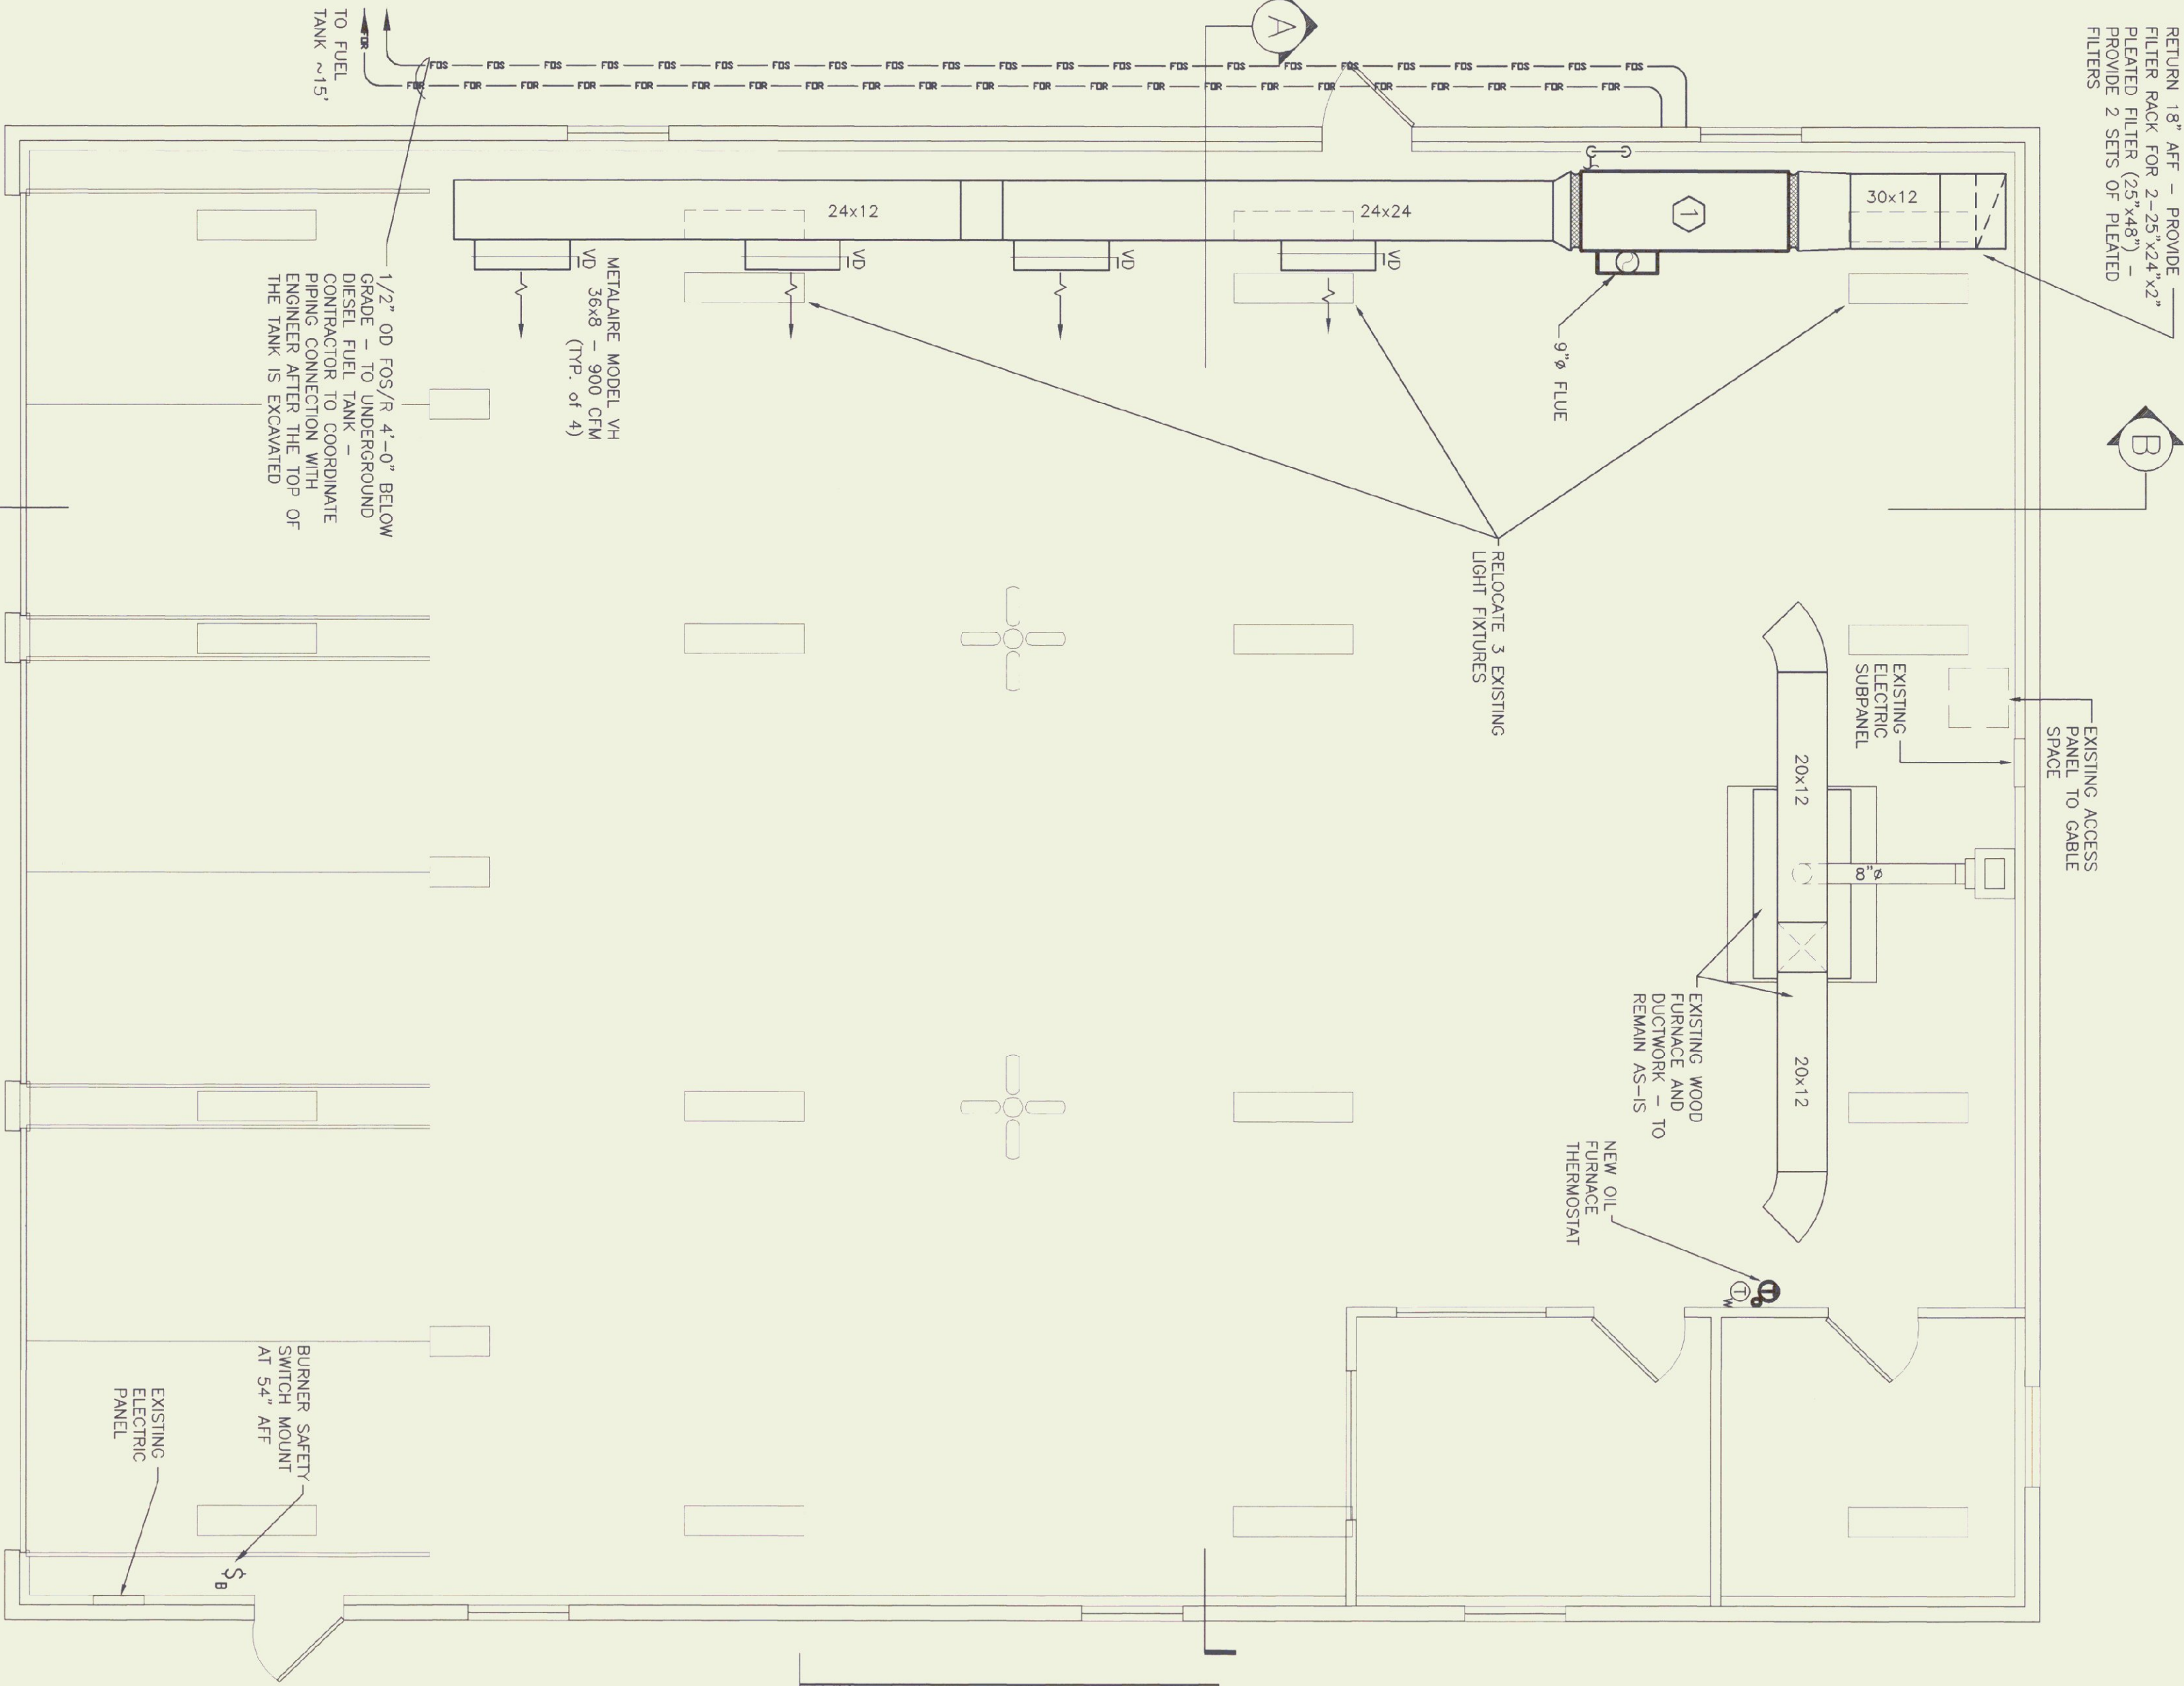

LEGEND



- FD FIRE DAMPER
- VD VOLUME DAMPER
- TX THERMOSTAT X: 0 = OIL, W = WOOD
- FL FULL PORTED BALL VALVE
- FW FURNACE VALVE, SPRING LOADED W/LEVER & WIRE TO FOSBLE LINK @ BURNER
- WS WESTER OSY
- PV PRESSURE VACUUM GAUGE
- UN UNION
- AA AUTOMATIC AIR VENT ON 6" AIR CHAMBER
- SA STOP ON ADJUST SET @ 120"
- ST STRAINER
- DR DRAIN
- VI VIBRATION ISOLATOR
- PO FUEL OIL TRANSFER PUMP
- BS BURNER SAFETY SWITCH

FURNACE SCHEDULE


	MAKE / MODEL	BTU OUTPUT	FUEL	GPM	BLOWER HP	VOLTAGE	FLUE
1	JACKSON - CHURCH 350S-28	280,000	# 2 OIL	3050	3/4	115	9"

FUEL PIPING SCHEMATIC

N.T.S.

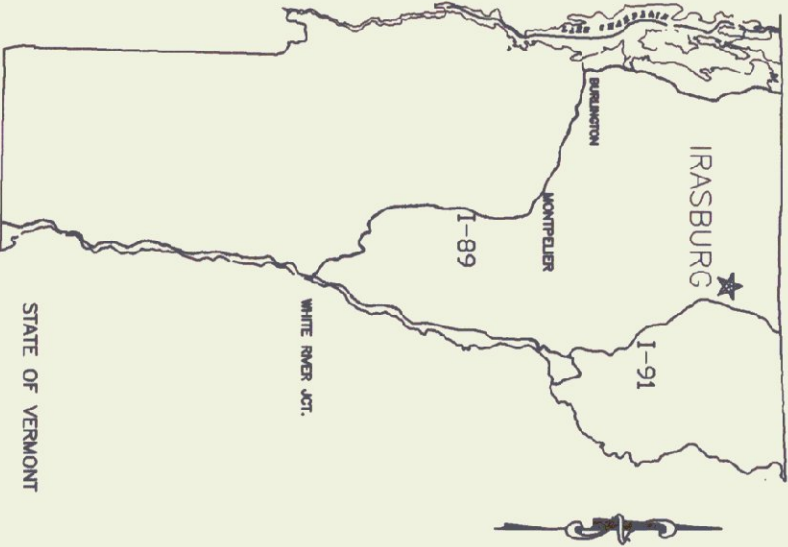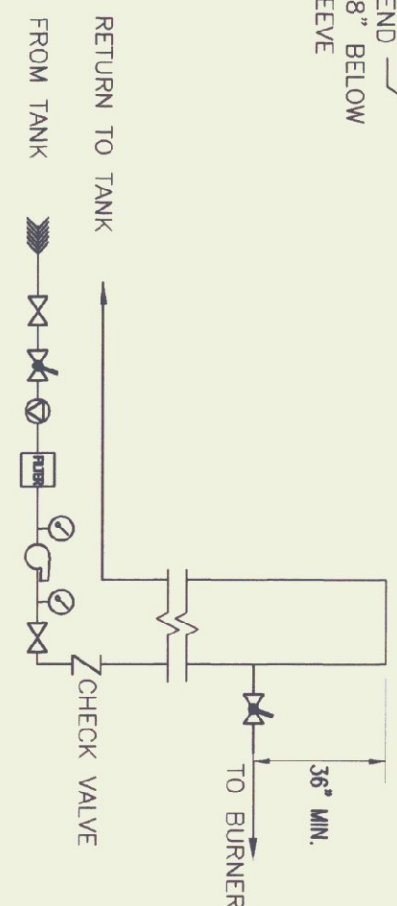

STATE LOCATION

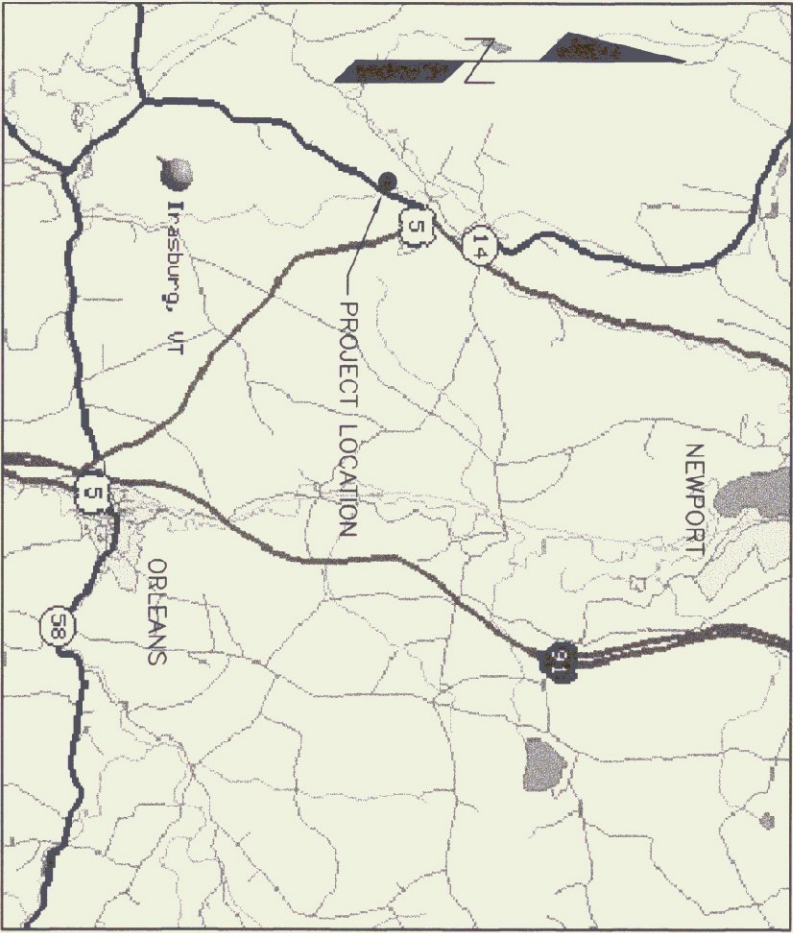

PROJECT LOCATION MAP

IRASBURG - A.O.T. GARAGE
FURNACE INSTALLATION
PLAN & SECTIONS

IRASBURG,

VERMONT



STATE OF VERMONT
Department of Buildings
and General Services
Agency of Administration
Montpelier, Vermont



PLAN & SECTIONS

FURNACE
INSTALLATION

SCALE: AS NOTED
DATE: MAY 14, 1999
DRAWN BY: R. PRATT
APPR. BY:

REVISIONS