




EXPOSED REGISTER DUCT TAKE-OFF DETAIL
SCALE: NONE

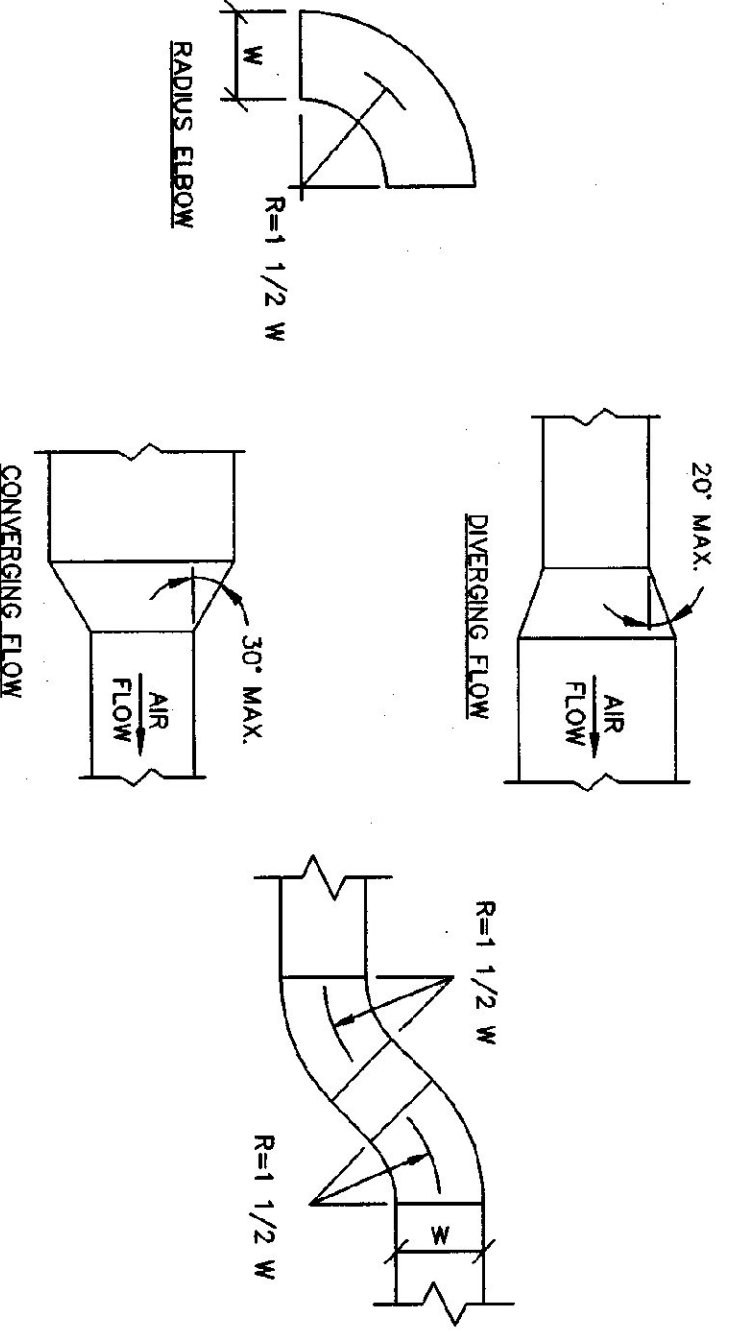


DUCT TRANSITIONS, OFFSETS, AND ELBOWS
SCALE: NONE

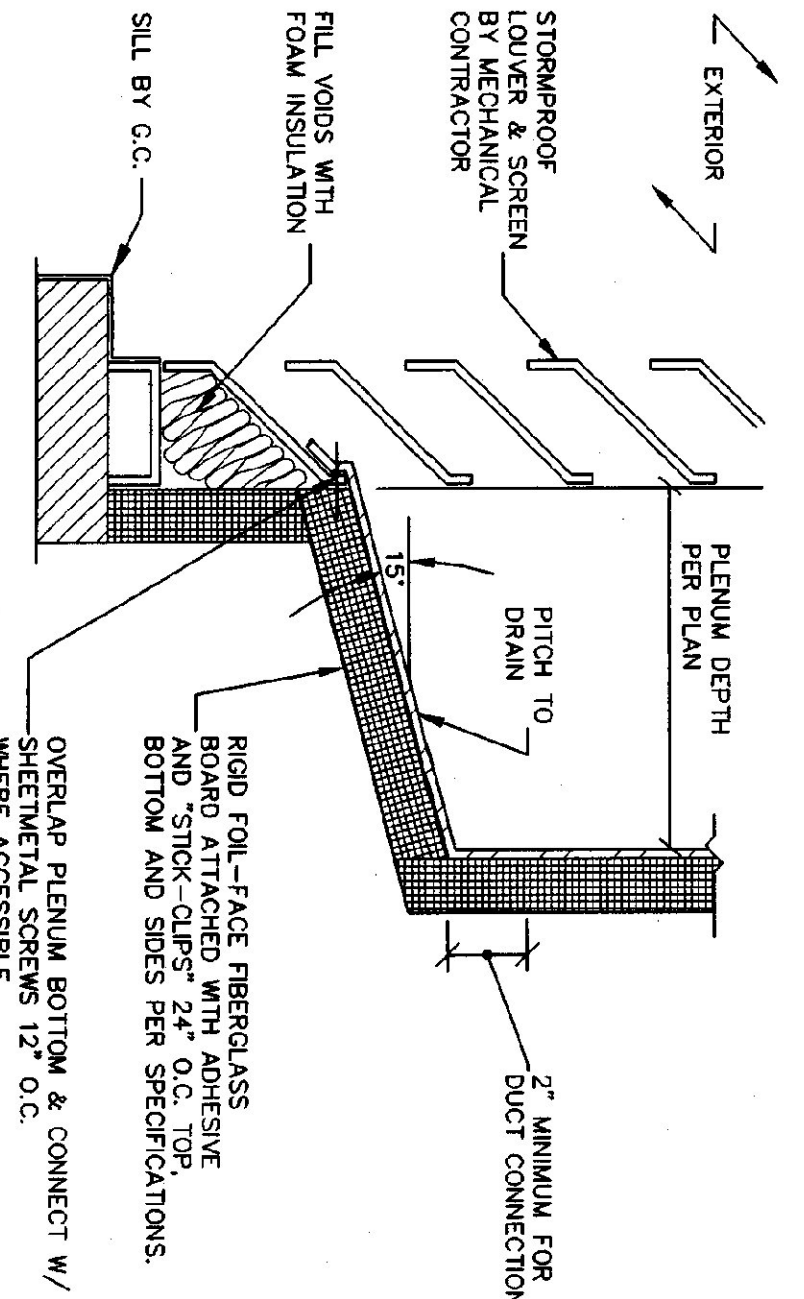


PLENUM AT LOUVER DETAIL
SCALE: NONE

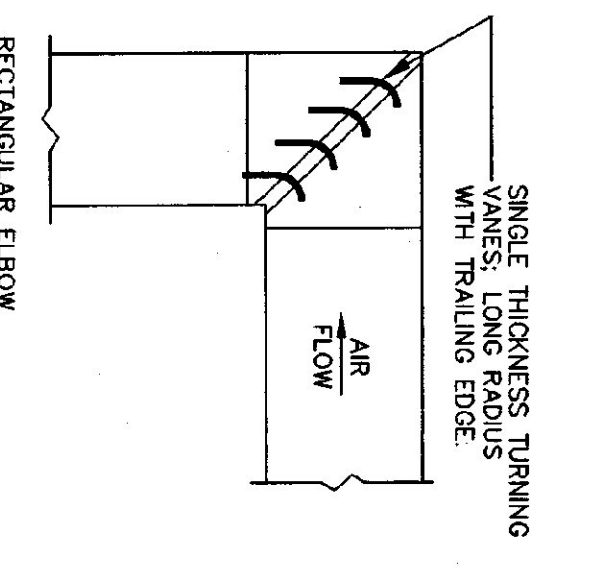


TURNING VANES FOR SQUARE ELBOW
SCALE: NONE

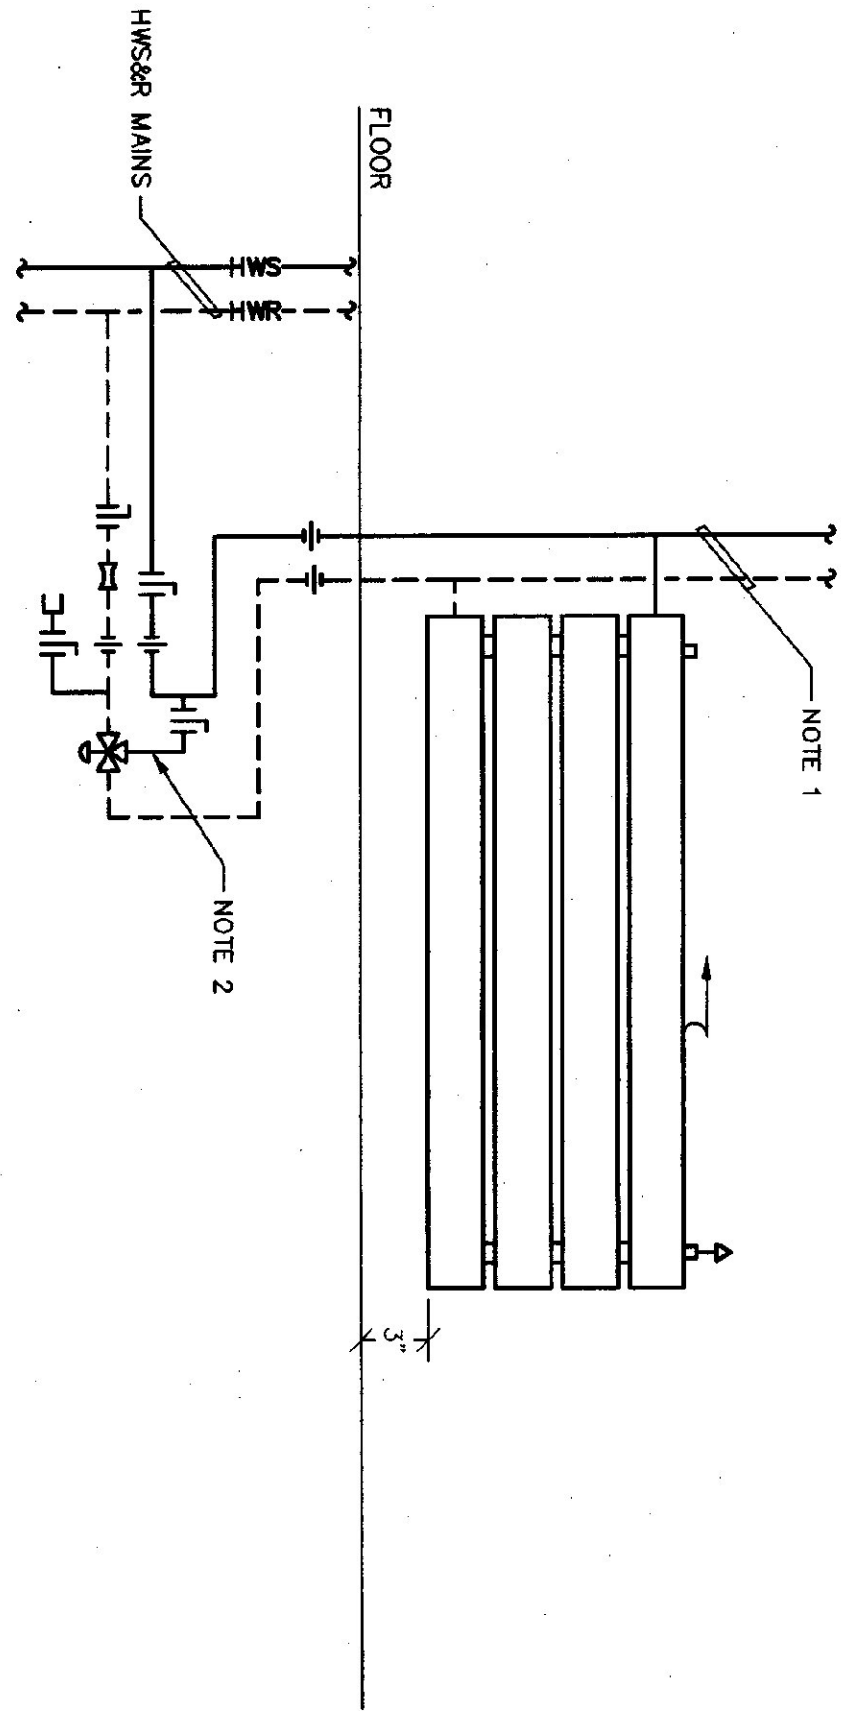



HEATING RADIATOR DETAIL
SCALE: NONE

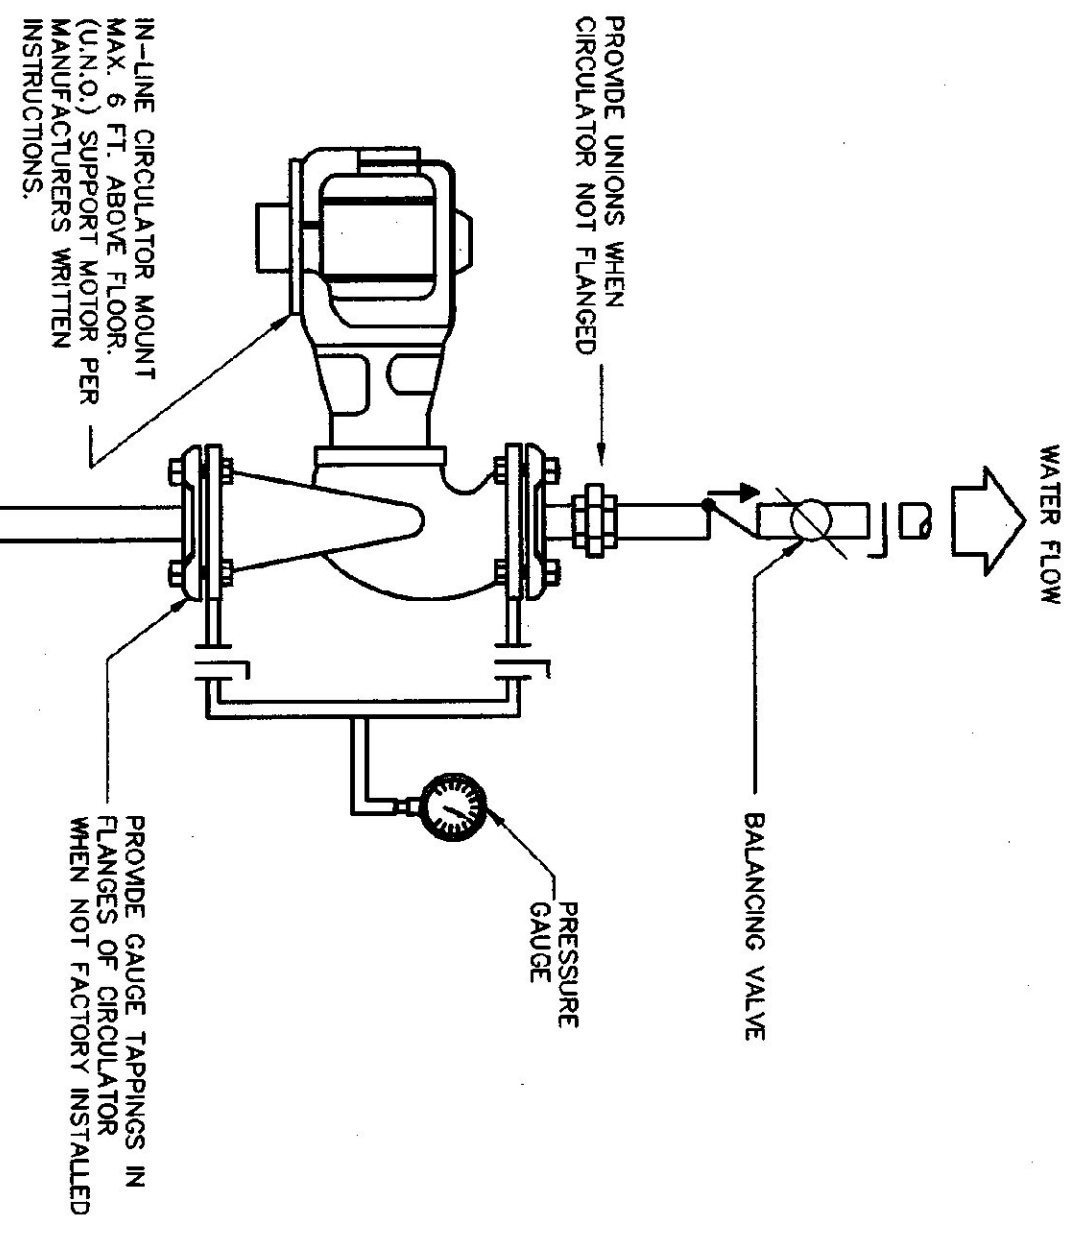

IN - LINE CIRCULATOR PIPING DETAIL
SCALE: NONE

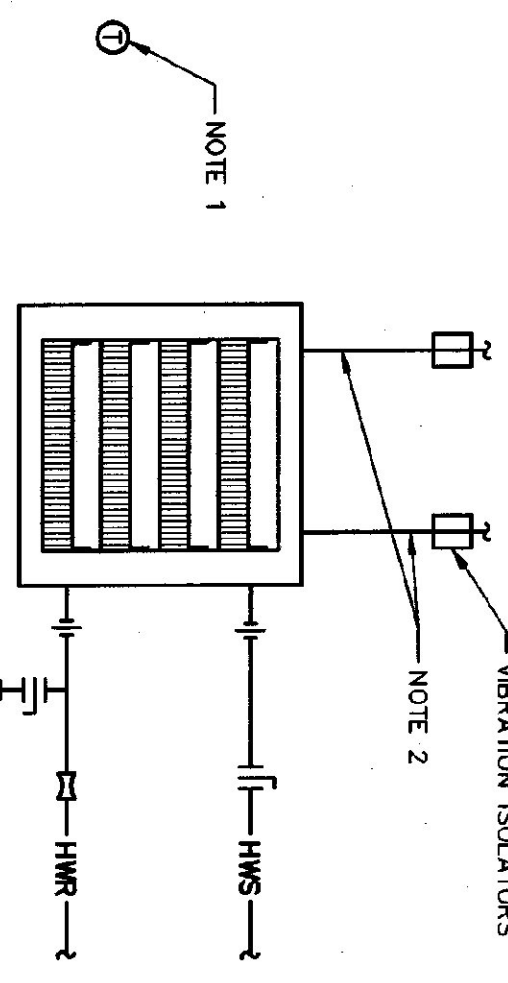


HOT WATER UNIT HEATER PIPING DETAIL
SCALE: NONE

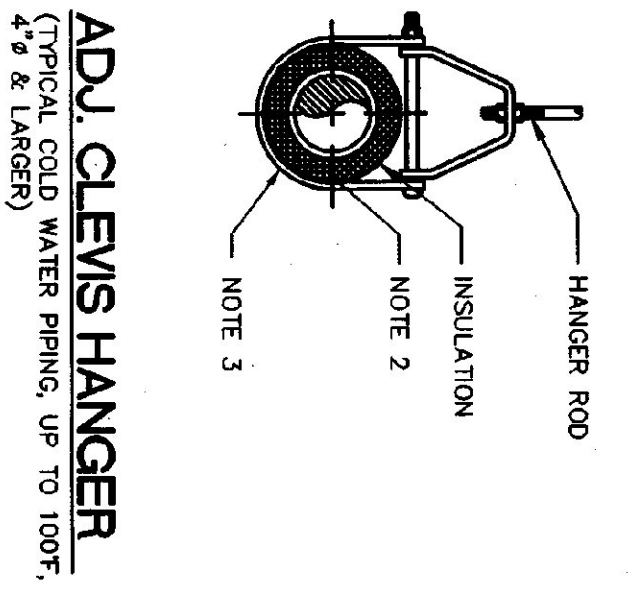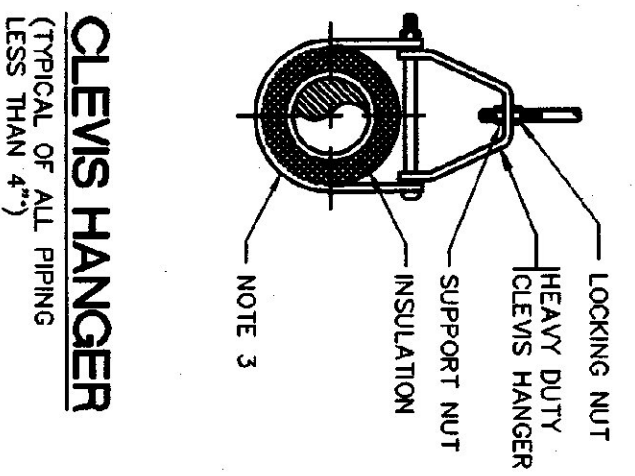


PIPE HANGER DETAILS
SCALE: NONE


- NOTES:**
- COORDINATE THESE DETAILS WITH REQUIREMENTS OF SPECIFICATIONS.
 - PROVIDE CALCIUM SILICATE INSULATION INSERT UNDER INSULATION. SHIELD LENGTH: 3x PIPE & EXPAND PIPING INSULATION VAPOR BARRIER.
 - 16 GA. ZINC COATED SHEET STEEL SADDLE AT LEAST 12" LONG W/ BANDS.

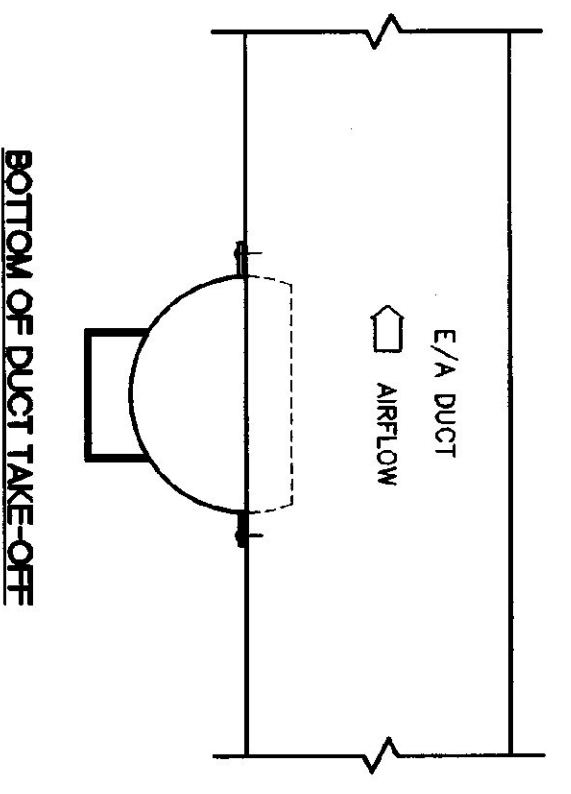

BOTTOM OF DUCT TAKE-OFF

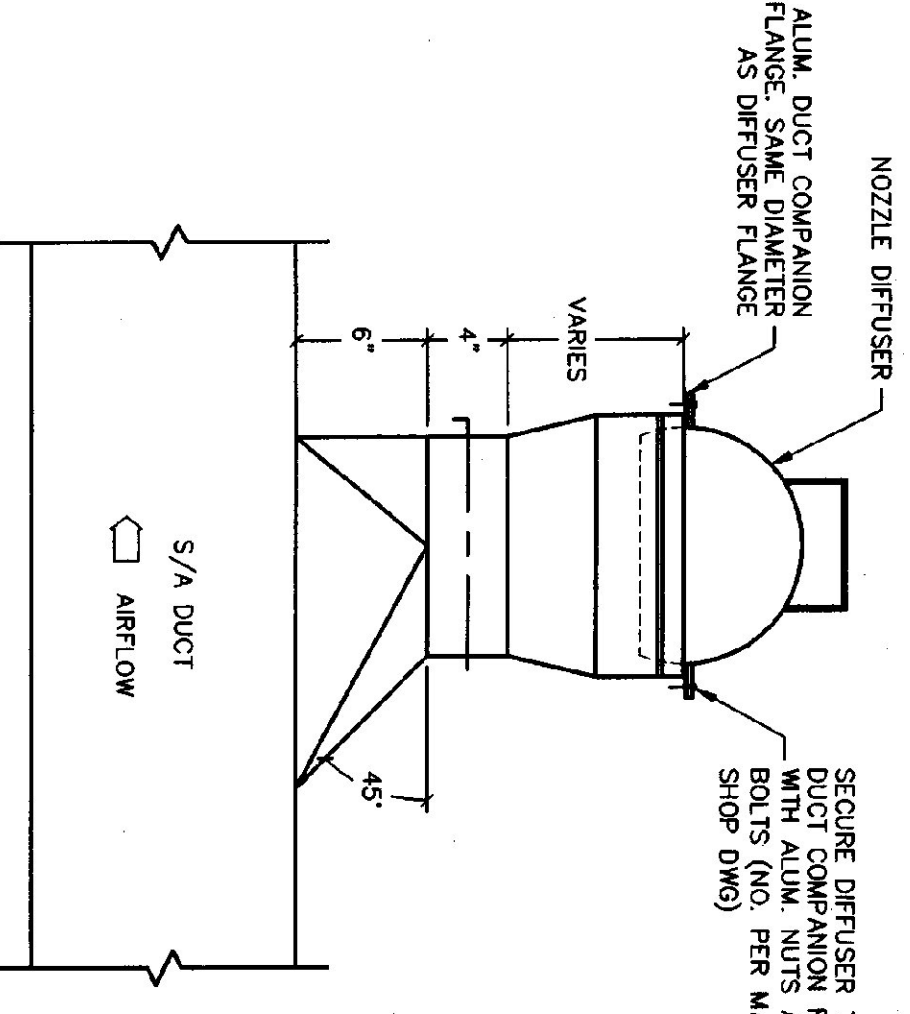

EXPOSED DETAIL

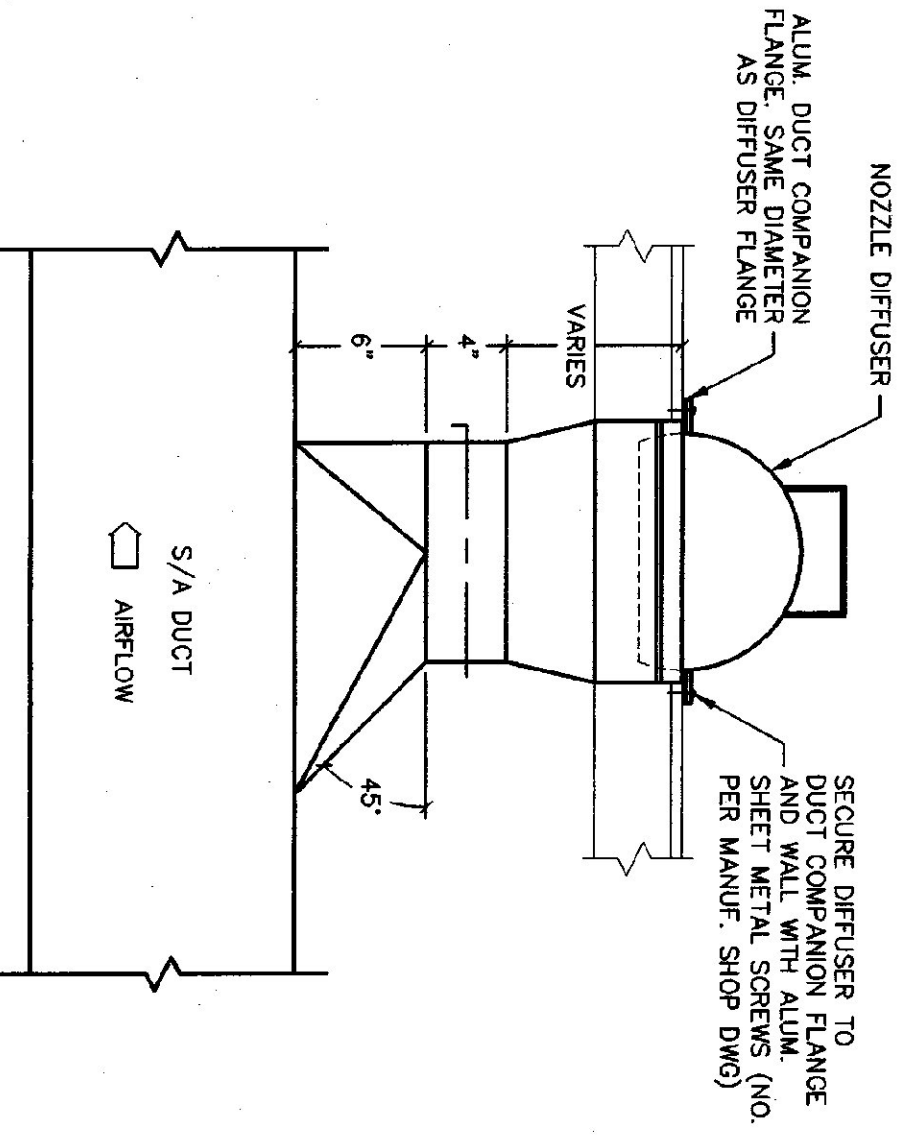

SURFACE MOUNTED DETAIL

NOZZLE TYPE SUPPLY/RETURN/EXHAUST CONNECTION DETAIL
SCALE: NONE

No.	DATE	REVISION

DUNCAN • WISNIEWSKI ARCHITECTURE
255 SOUTH CHAMPLAIN STREET, BURLINGTON, VERMONT 05401 (802) 864-6683

Hallam Associates
60 Farrell Street, Suite 300
So. Burlington, Vermont 05403
(802) 858-4881

WILLISTON INFORMATION CENTER
189 SOUTHBOUND
STATE PROJECT # IM-BLDG (4)

HVAC DETAILS

H-958

DRAWN: JLL/MO/THE
CHECKED: 10215
DATE: JAN 15, 2001
W/CORR:

