
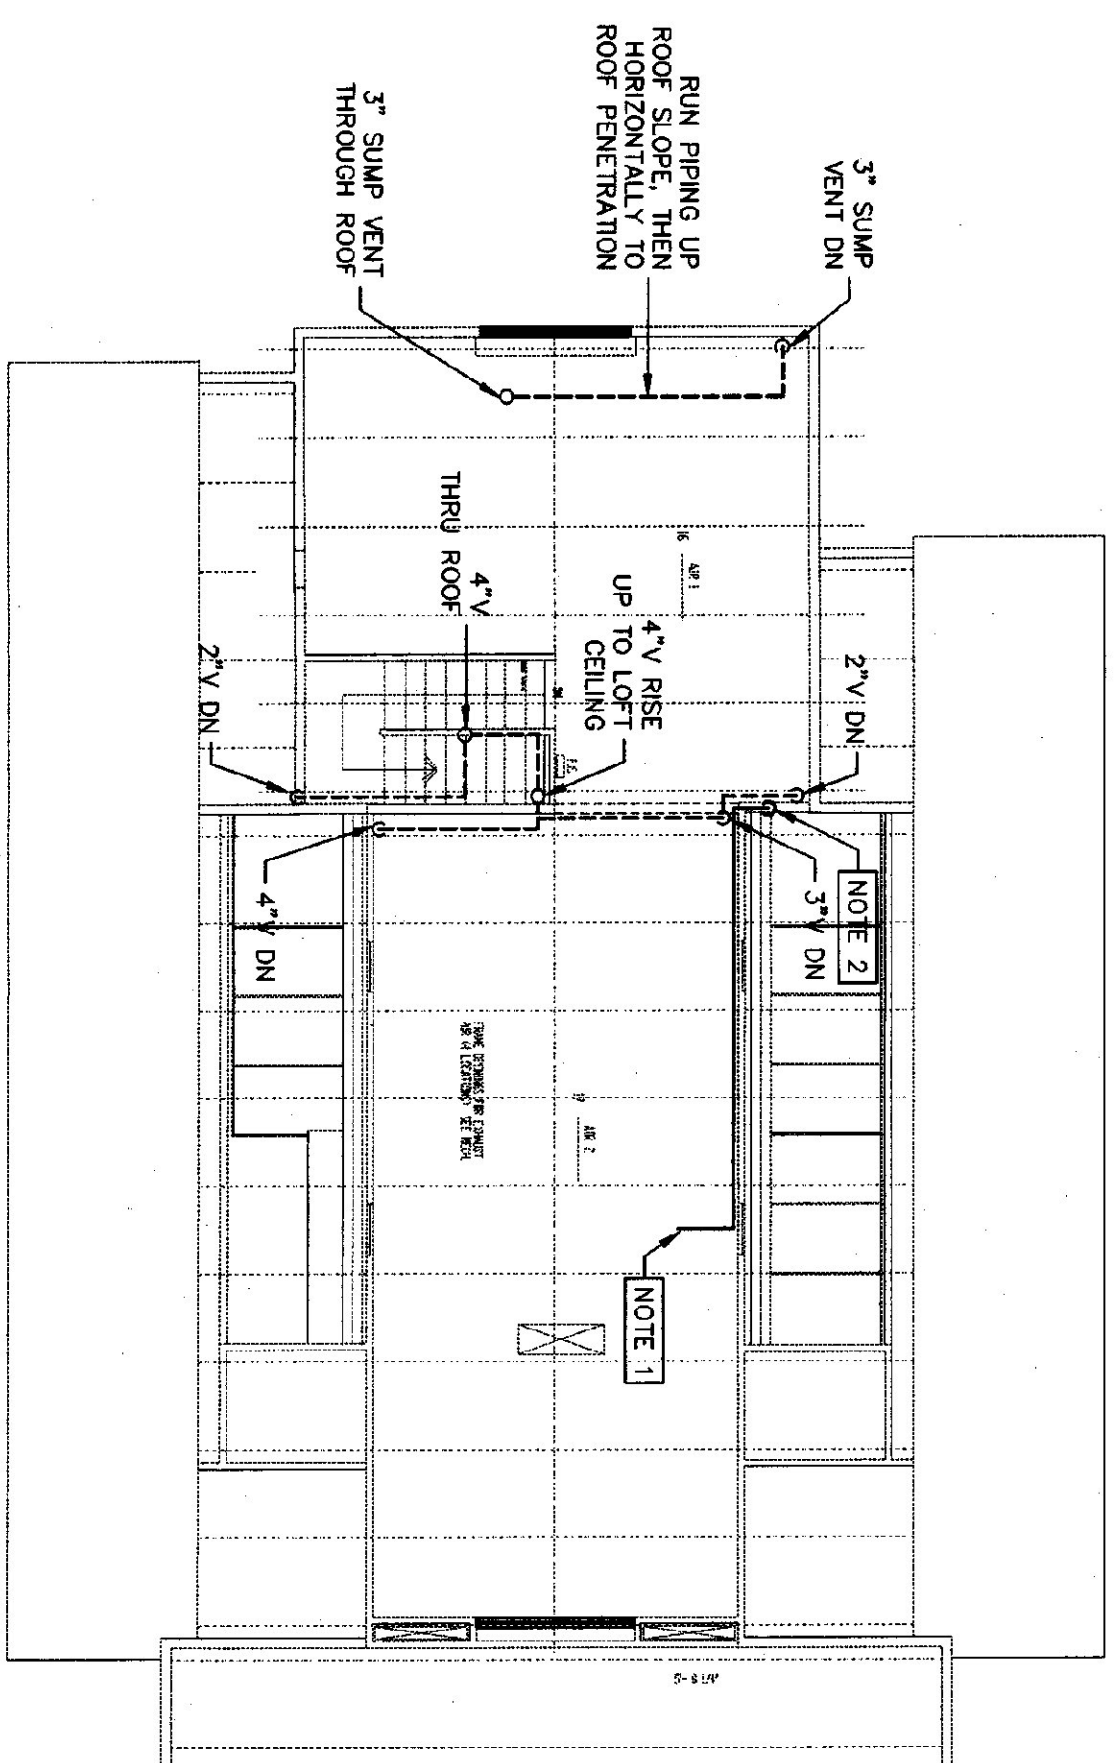


NOTE:
FOR INDIVIDUAL FITTER CONNECTION
SIZES, REFER TO SCHEDULE ON DRAWING P-1sb

CRAWL SPACE AND MAIN LEVEL SANITARY RISER
NO SCALE


NOTES:
1. FOR CONTINUATION SEE ATTIC PLAN THIS DRAWING.

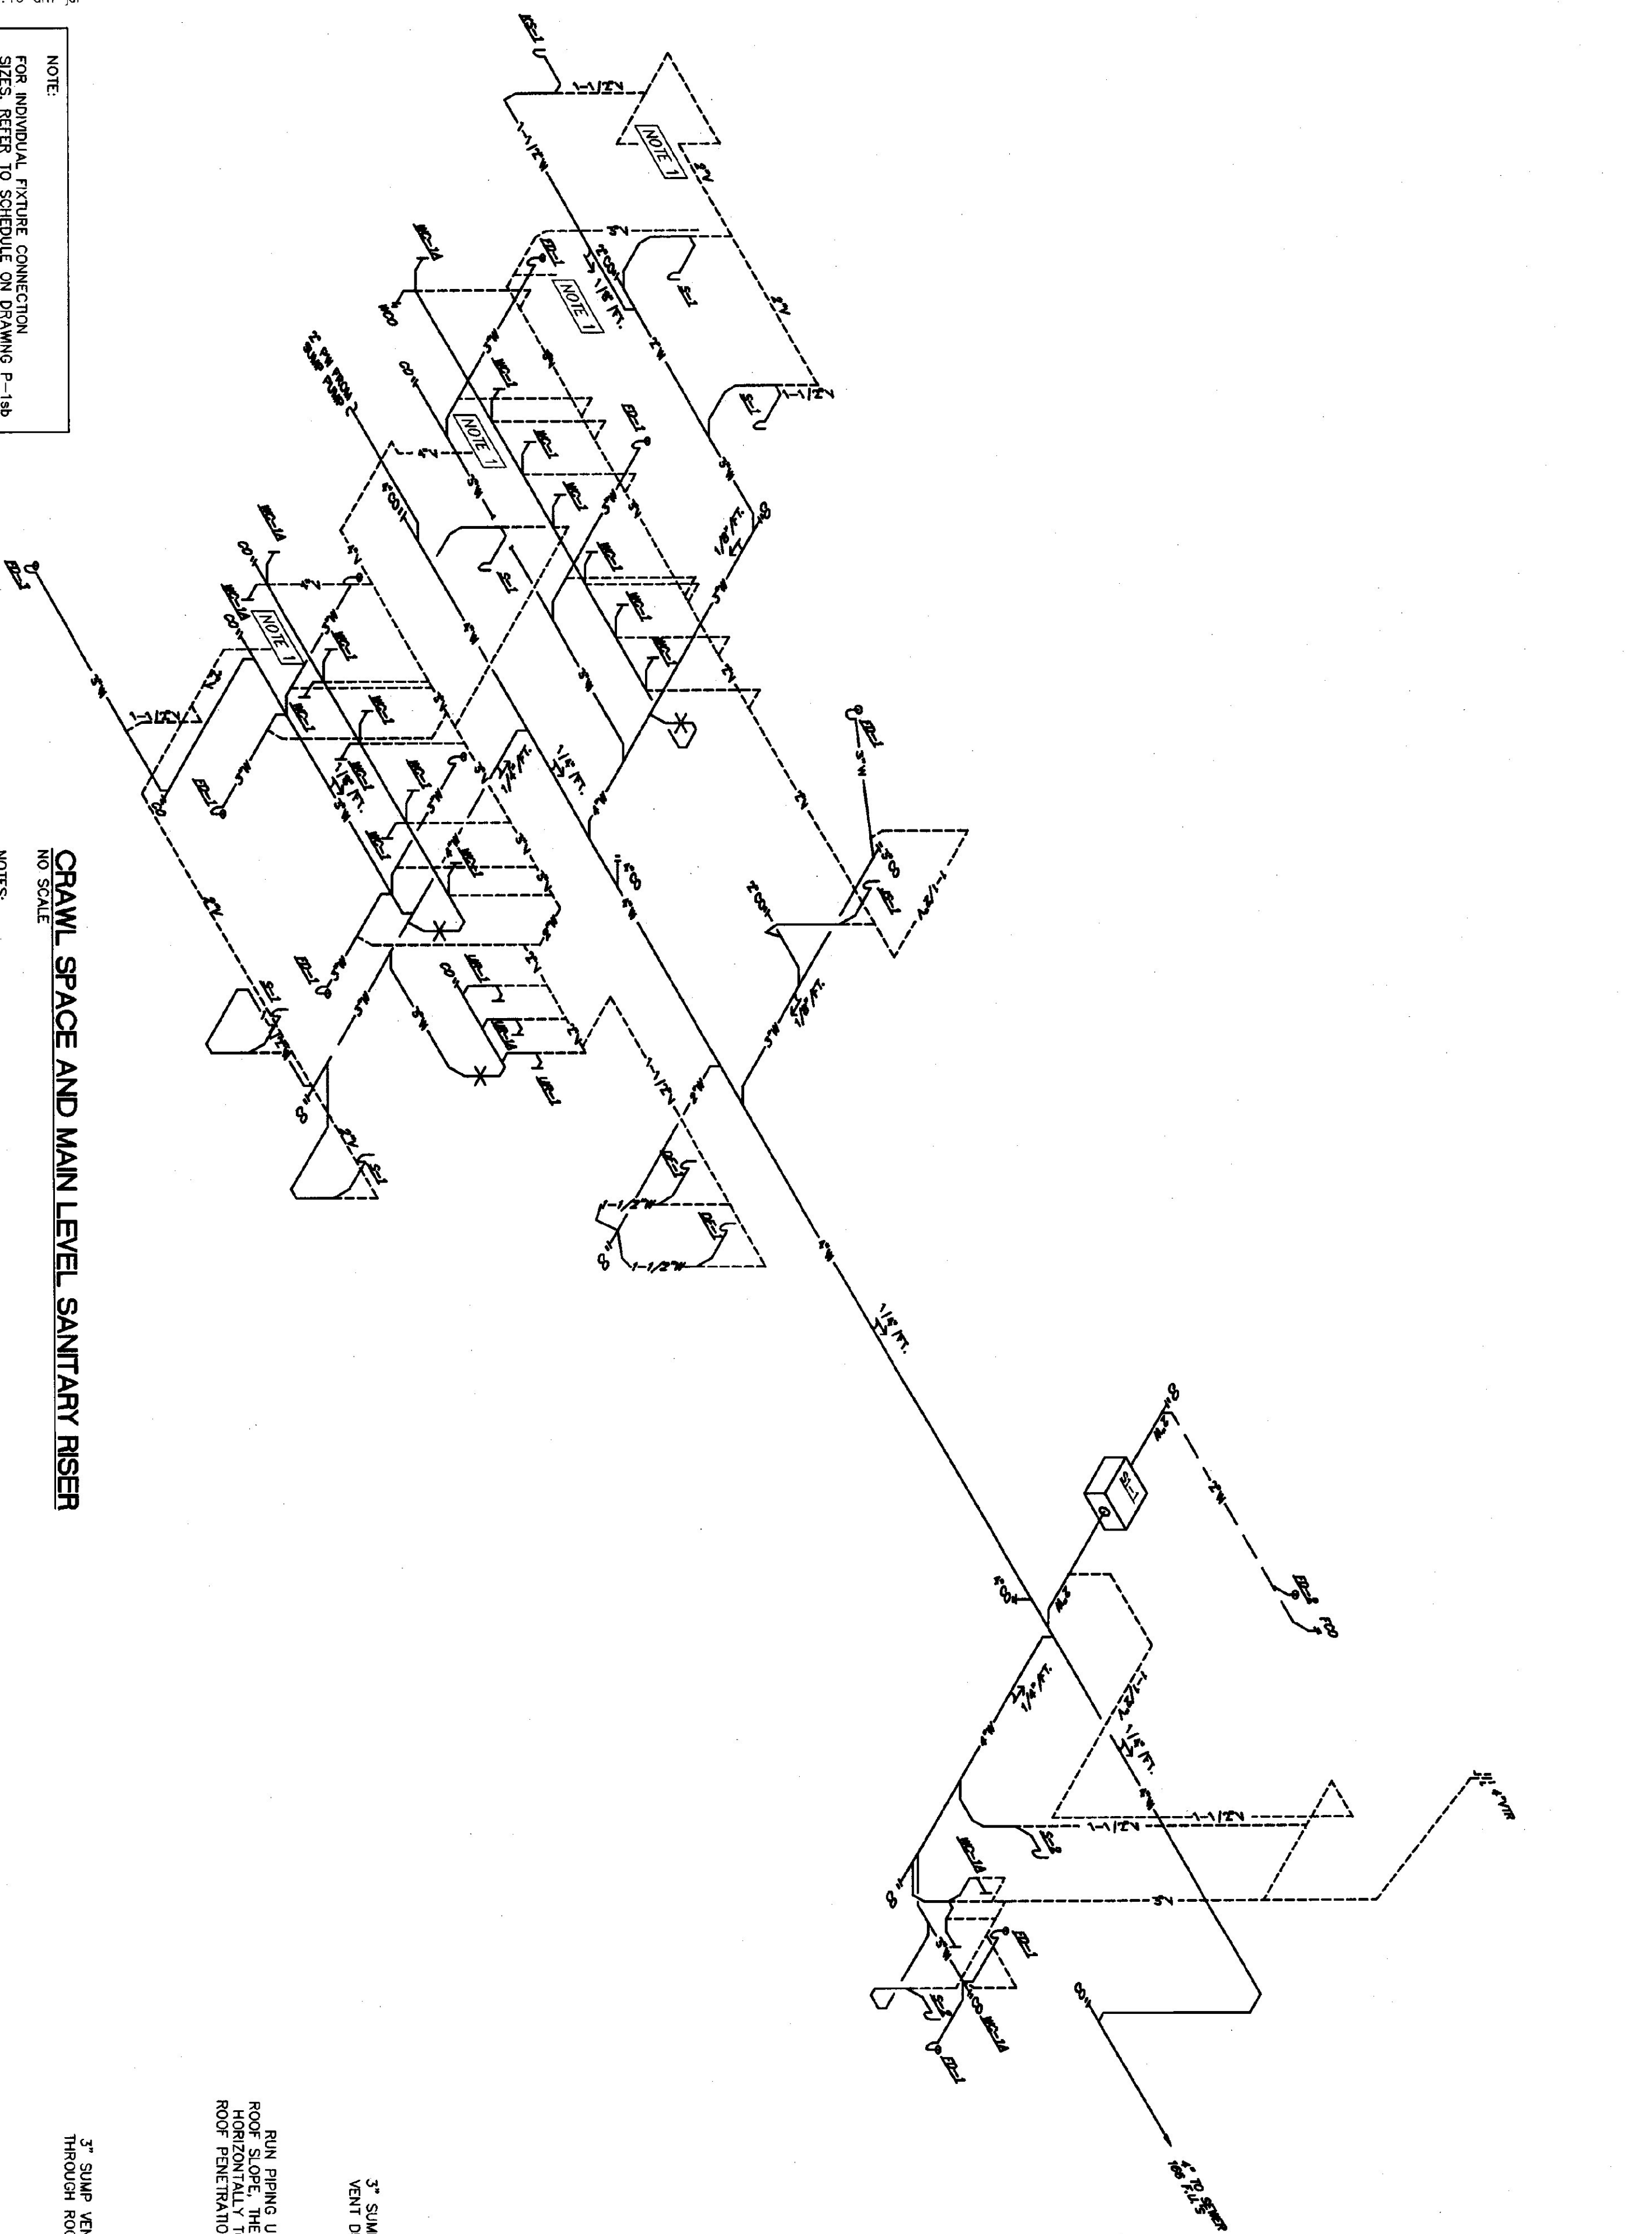

LOFT PLUMBING PLAN
SCALE: 1/8"=1'-0"

- NOTES:
1. PROVIDE FULL SIZE CONDENSATE DRAIN LINE FROM AIR NEXT TO DOWNSTREAM DRAIN. ROUTE PIPING ALONG WALL FLOW.
 2. ROUTE PIPING DOWN THROUGH FLOOR AND TERMINATE OPEN ENDED ABOVE RECESSED FLOOR AREA 12" ± ABOVE FLOOR.

CRAWL SPACE WASTE COLLECTION SYSTEM RISER
NO SCALE

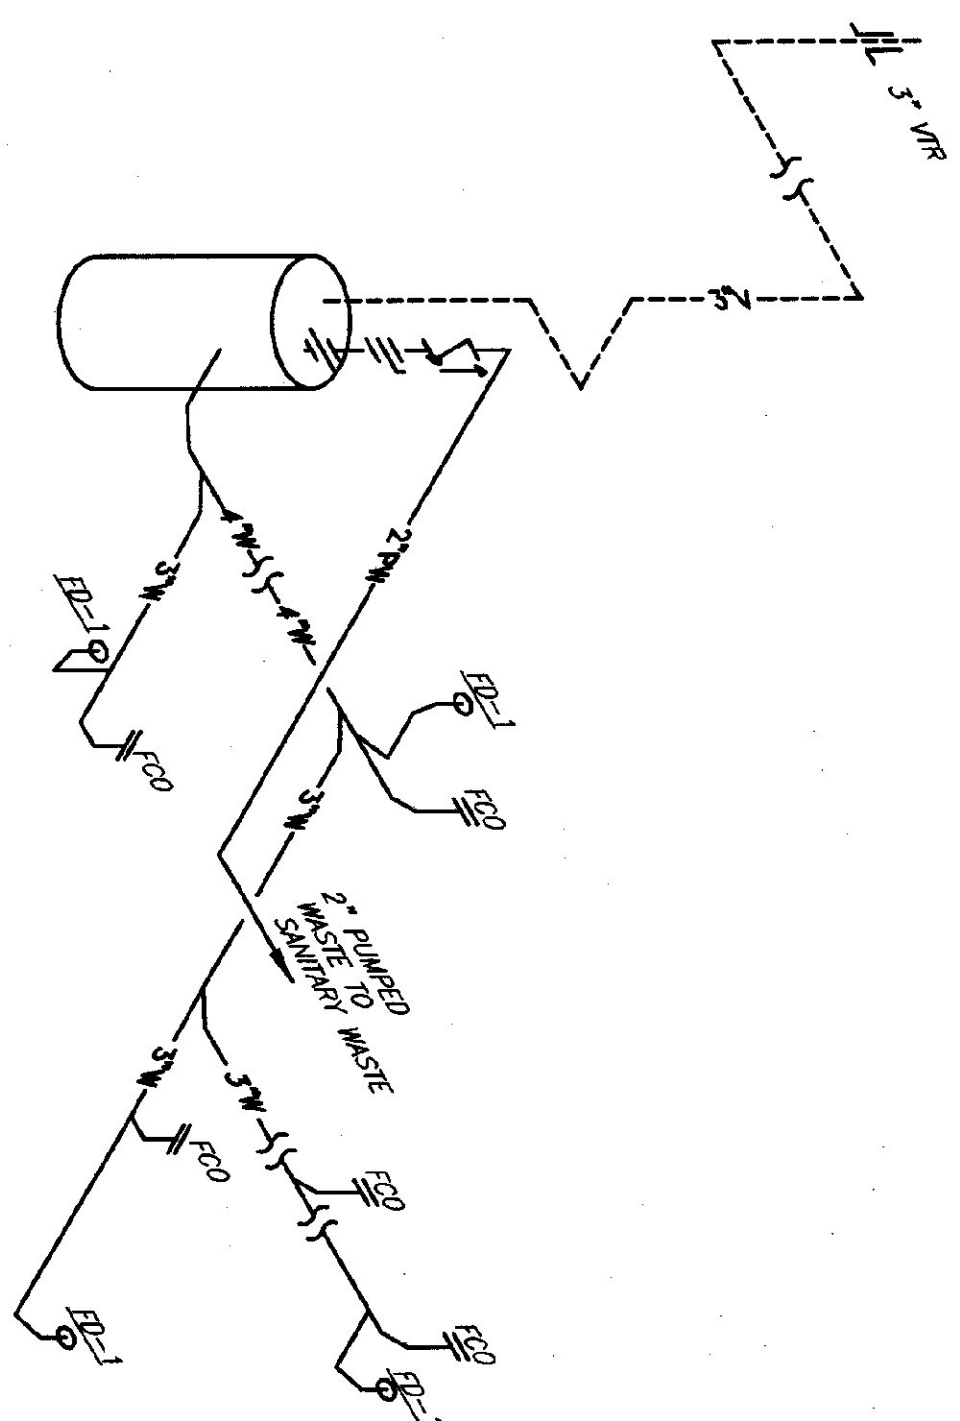

P-4sb

WILLISTON INFORMATION CENTER
189 SOUTHBOUND
STATE PROJECT # IM-BLDG (4)

**SANITARY RISERS AND DETAILS
AND LOFT PLUMBING PLAN**

DUNCAN • WISNIEWSKI ARCHITECTURE
255 SOUTH CHAMPLAIN STREET, BURLINGTON, VERMONT 05401 (802) 864-8898

Halam Associates
80 Farrell Street, Suite 300
So. Burlington, Vermont 05403
(802) 658-4891

No.	DATE	REVISION

