



LOFT LIGHTING PLAN
SCALE: 1/4" = 1'-0"

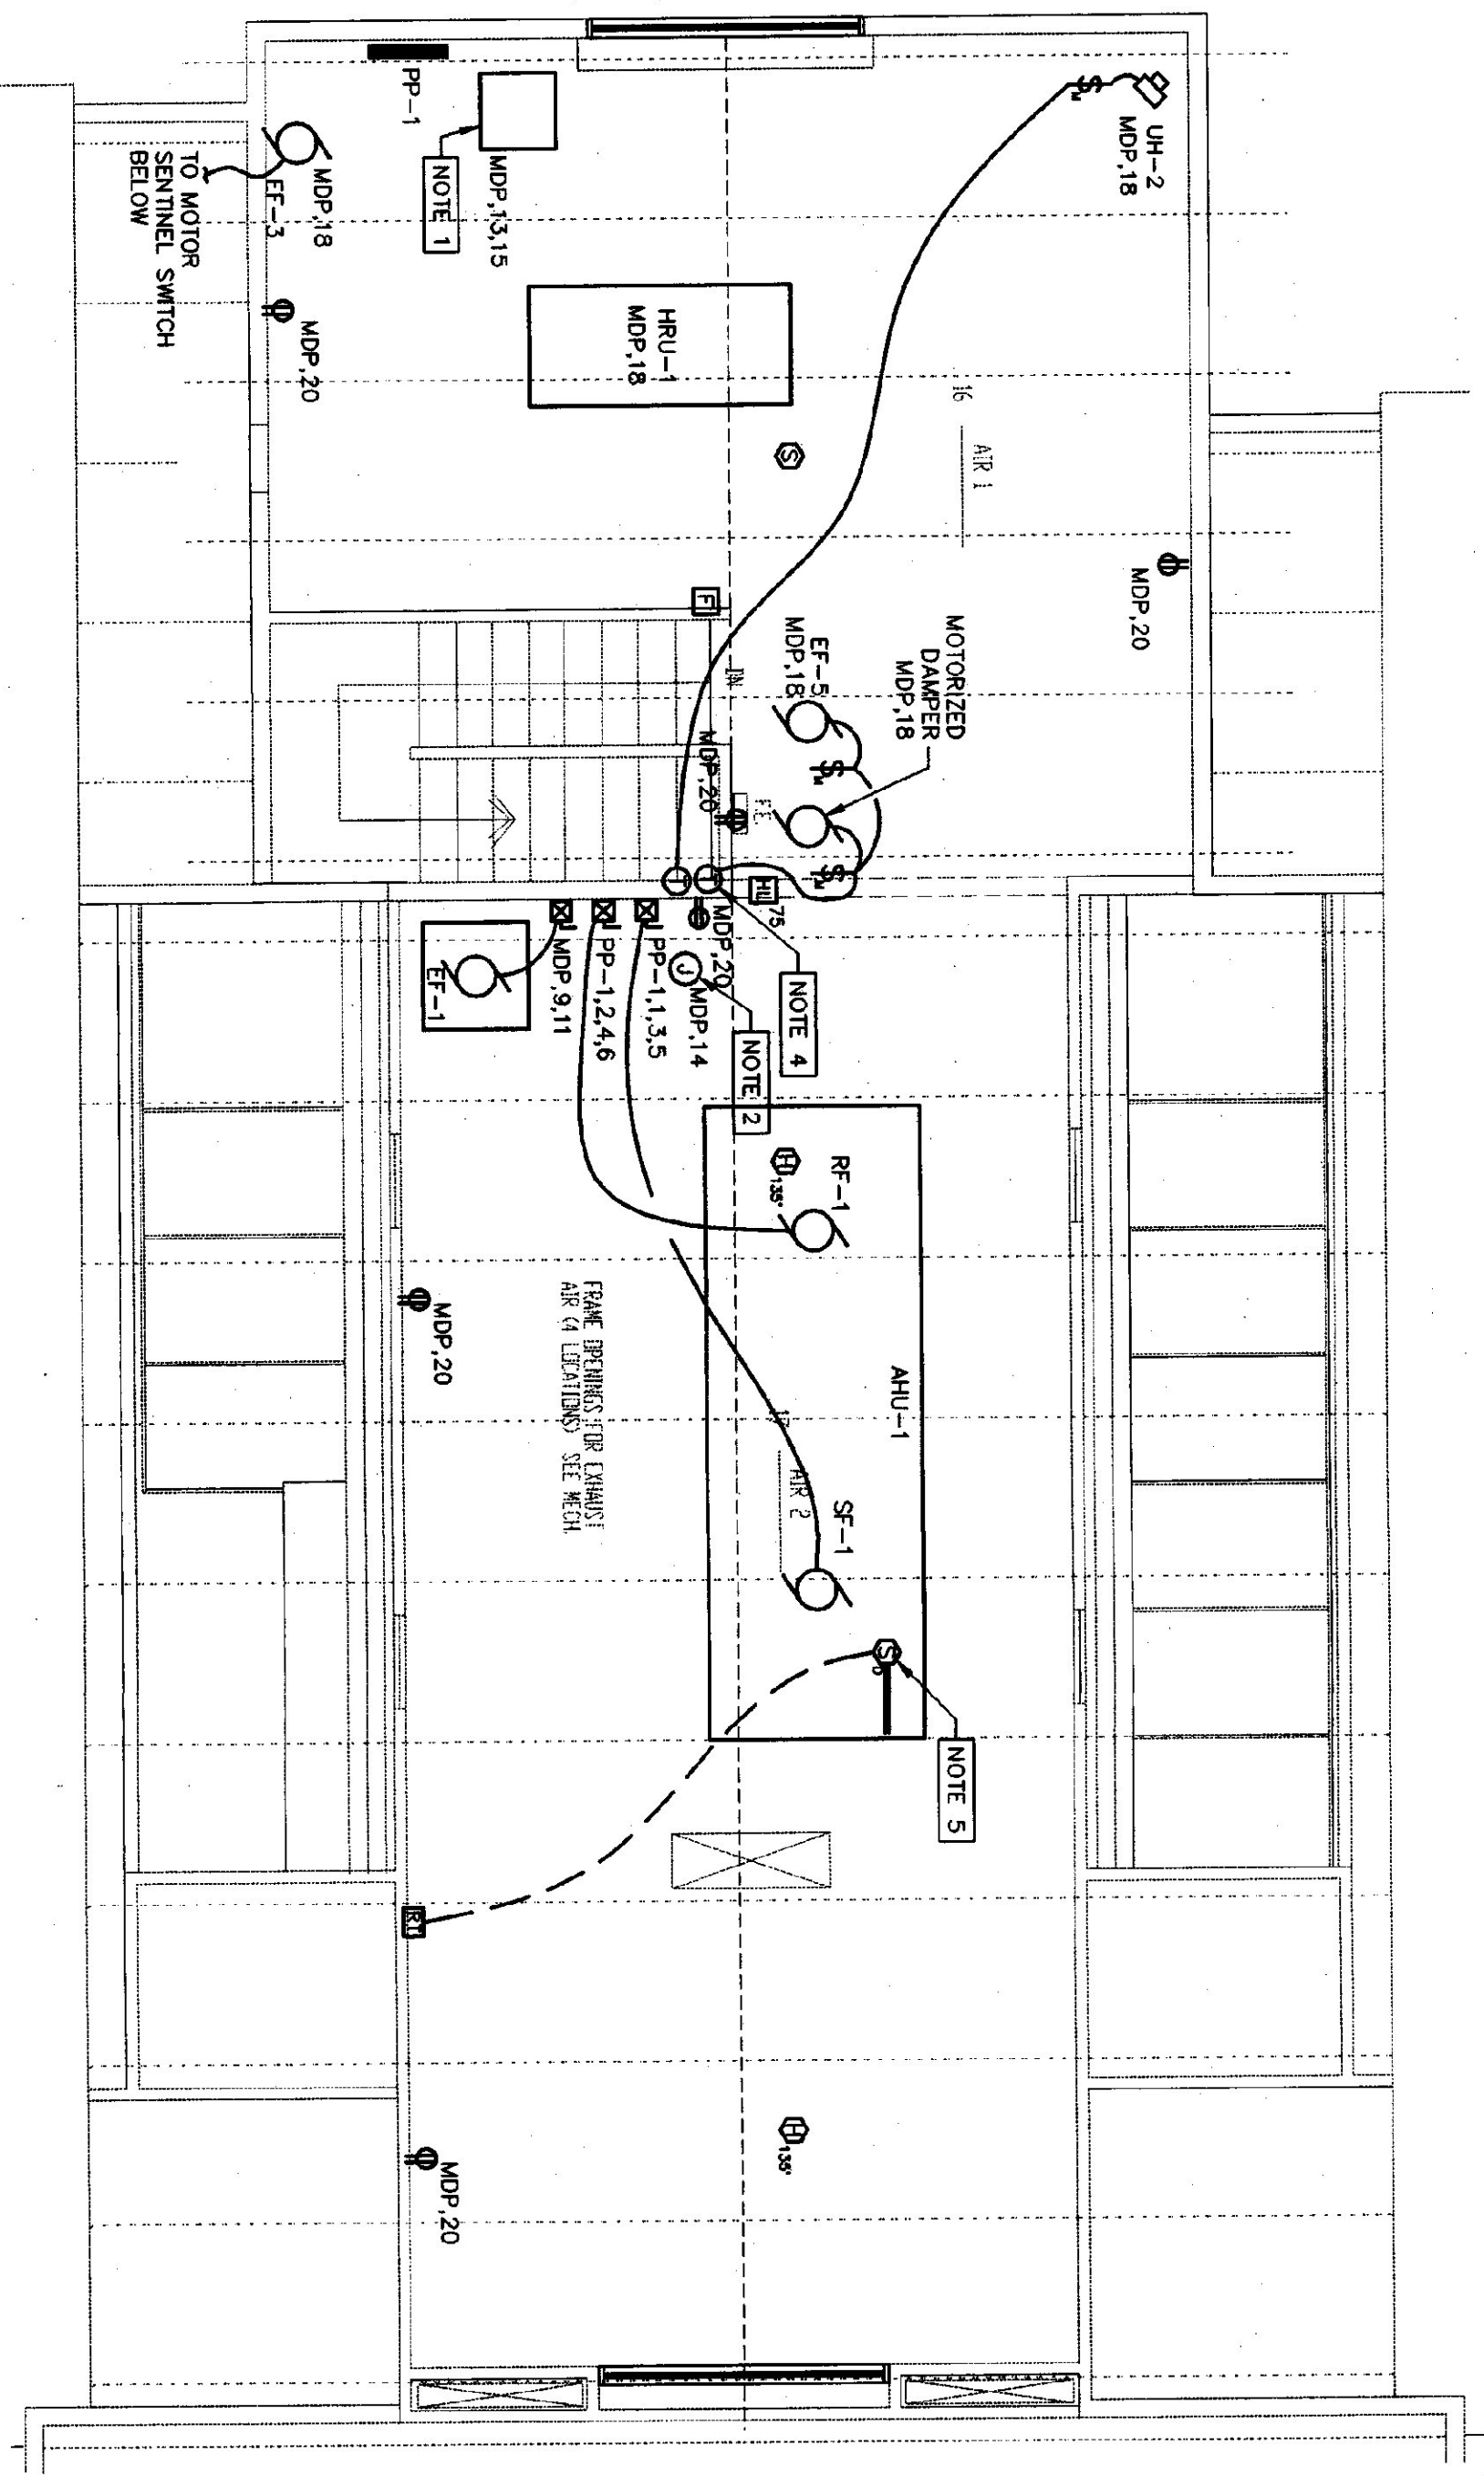


LOFT POWER PLAN
SCALE: 1/4" = 1'-0"

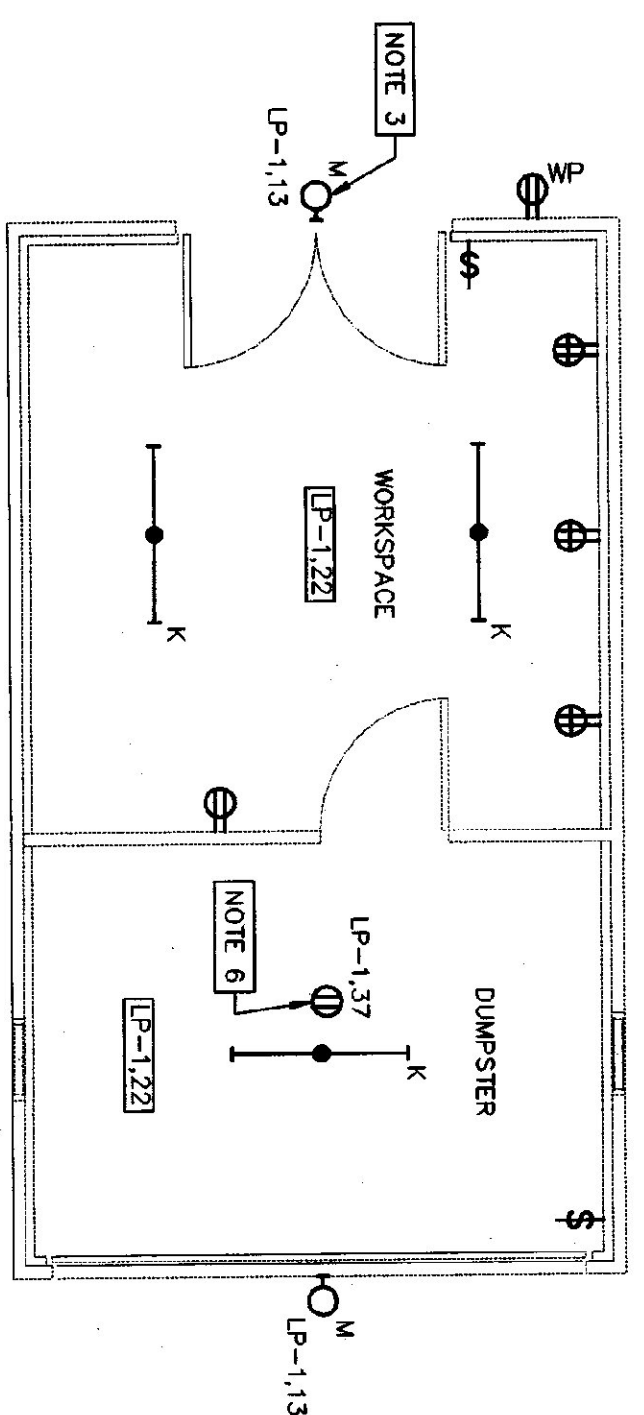


SERVICE BUILDING LIGHTING AND POWER PLAN
SCALE: 1/4" = 1'-0"

- NOTES: (APPLY TO LOFT AND SERVICE BUILDING PLANS)
- FURNISH AND INSTALL ROTARY PHASE CONVERTER. REFER TO WIRING DIAGRAM BELOW AND SPECIFICATIONS FOR MORE DETAIL.
 - FURNISH AND INSTALL JUNCTION BOX FOR CONTROL POWER.
 - ALL FIXTURES FED FROM PANEL UP-1. CIRCUIT 13 SHALL BE CONTROLLED BY PHOTOCELL AND LIGHTING CONTACTOR AS SHOWN ON WIRING DIAGRAM ON DRAWING E-7.
 - THERMOSTAT FOR EXHAUST FAN TO BE FURNISHED BY MECHANICAL CONTRACTOR AND INSTALLED BY ELECTRICAL CONTRACTOR AT LOCATION SHOWN. REFER TO EXHAUST FAN #5 WIRING DIAGRAM BELOW FOR MORE INFORMATION.
 - PROVIDE A DUCT MOUNTED SMOKE DETECTOR IN EACH SUPPLY DUCT OF MULTI-ZONE UNIT. LOCATE DUCT SMOKE DETECTORS AND ASSOCIATED REMOTE TEST SWITCHES IN MECHANICAL ROOM. TYPICAL OF (7) DUCT SMOKE DETECTORS AT THIS LOCATION.
 - FURNISH AND INSTALL DEDICATED RECEPTACLE FOR ELECTRIC GARAGE DOOR.

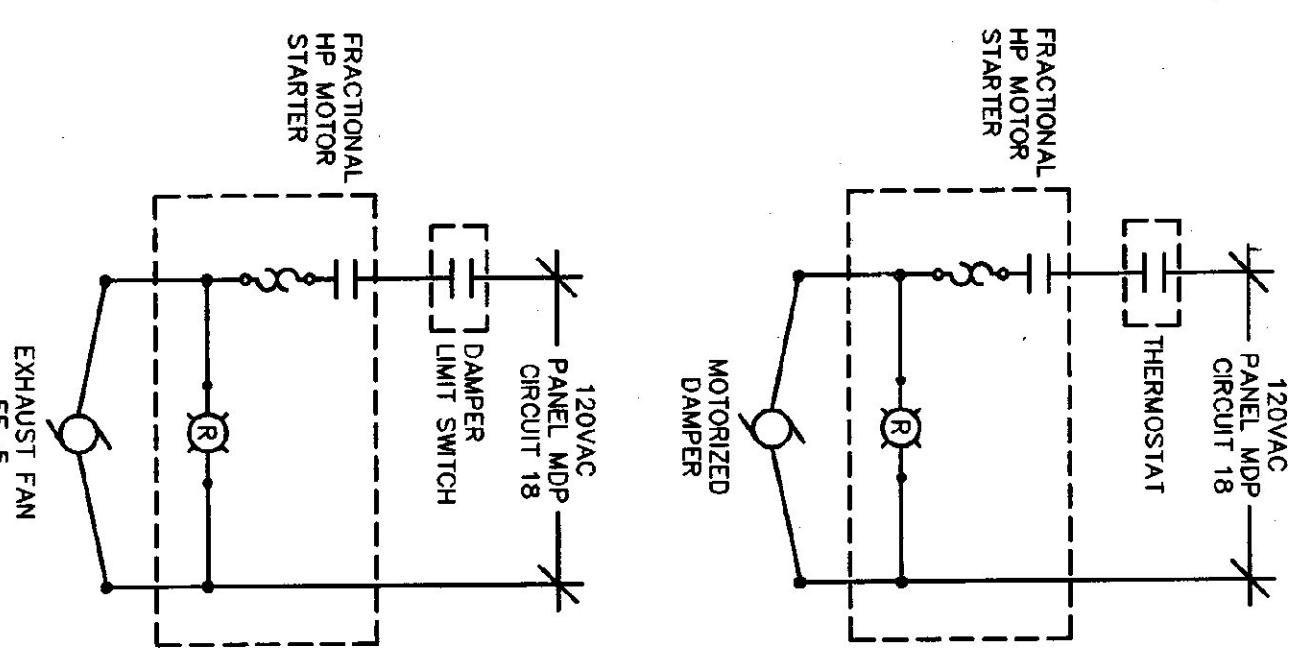


EXHAUST FAN #5 WIRING DIAGRAM
SCALE: NONE

- NOTES:
- LIMIT SWITCH SHALL BE PROVIDED BY MECHANICAL CONTRACTOR.
 - THERMOSTAT SHALL BE PROVIDED BY MECHANICAL CONTRACTOR AND INSTALLED BY ELECTRICAL CONTRACTOR.

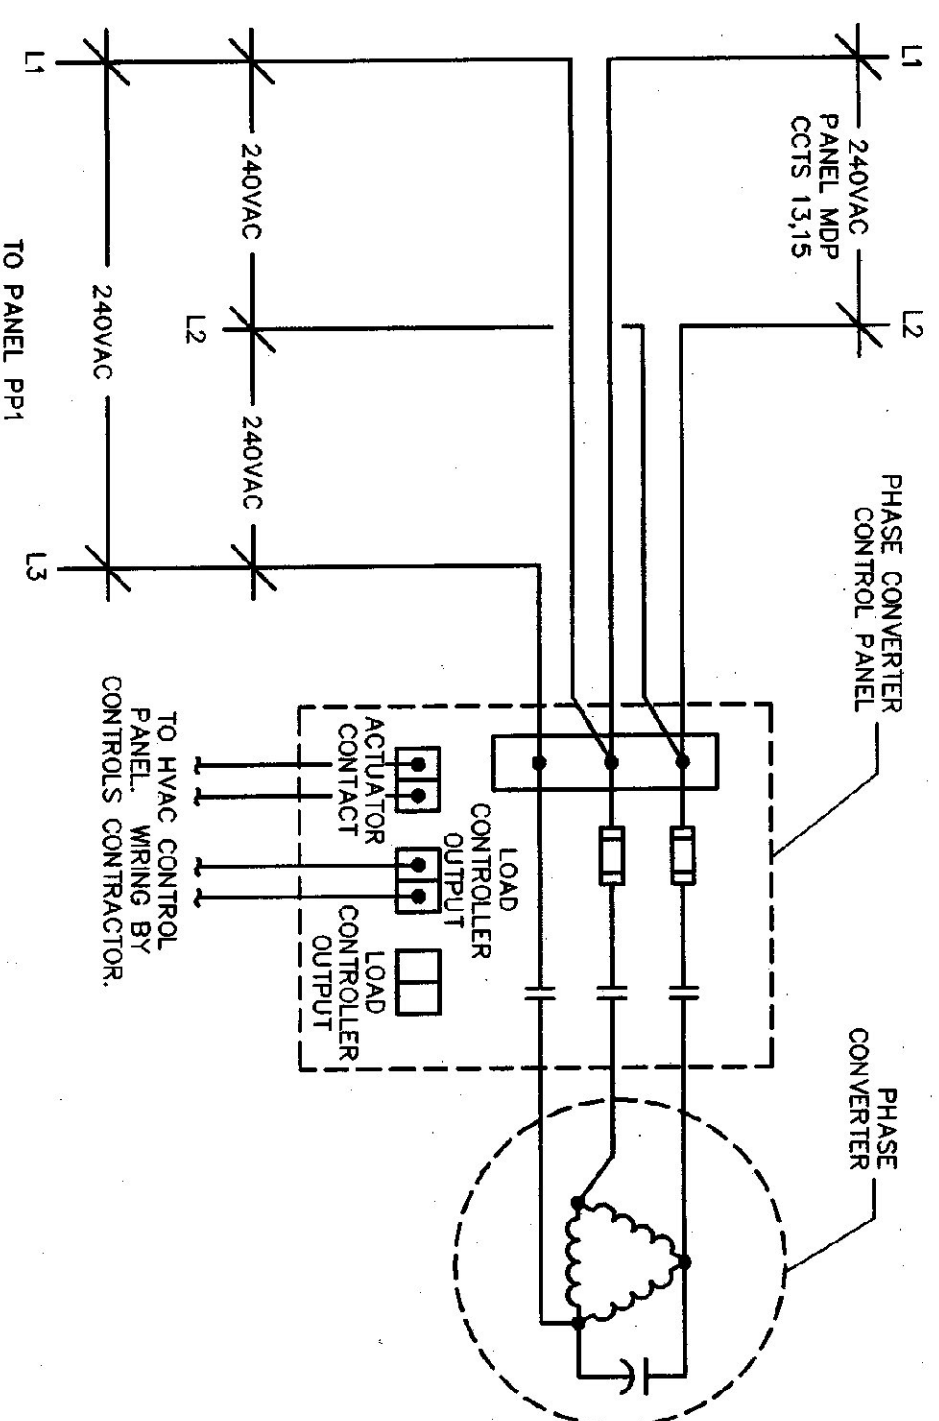

PHASE CONVERTER WIRING DIAGRAM
SCALE: NONE

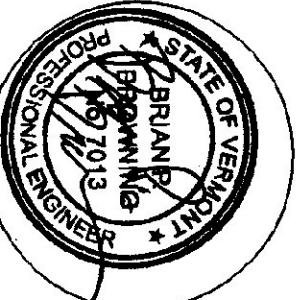

DUNCAN • WISNIEWSKI ARCHITECTURE
255 SOUTH CHAMPLAIN STREET, BURLINGTON, VERMONT 05401 (802) 864-9693

Hallam Associates
60 Farrell Street, Suite 300
So. Burlington, Vermont 05403
(802) 656-4851

WILLISTON INFORMATION CENTER
189 SOUTHBOUND
STATE PROJECT # IM-BLDG (4)

LOFT LIGHTING AND POWER PLAN

DRAWN: LCS
CHECKED: BPP
DATE: JAN 16, 2001
PROJNO: 10215

E-5sb

No.	DATE	REVISION