

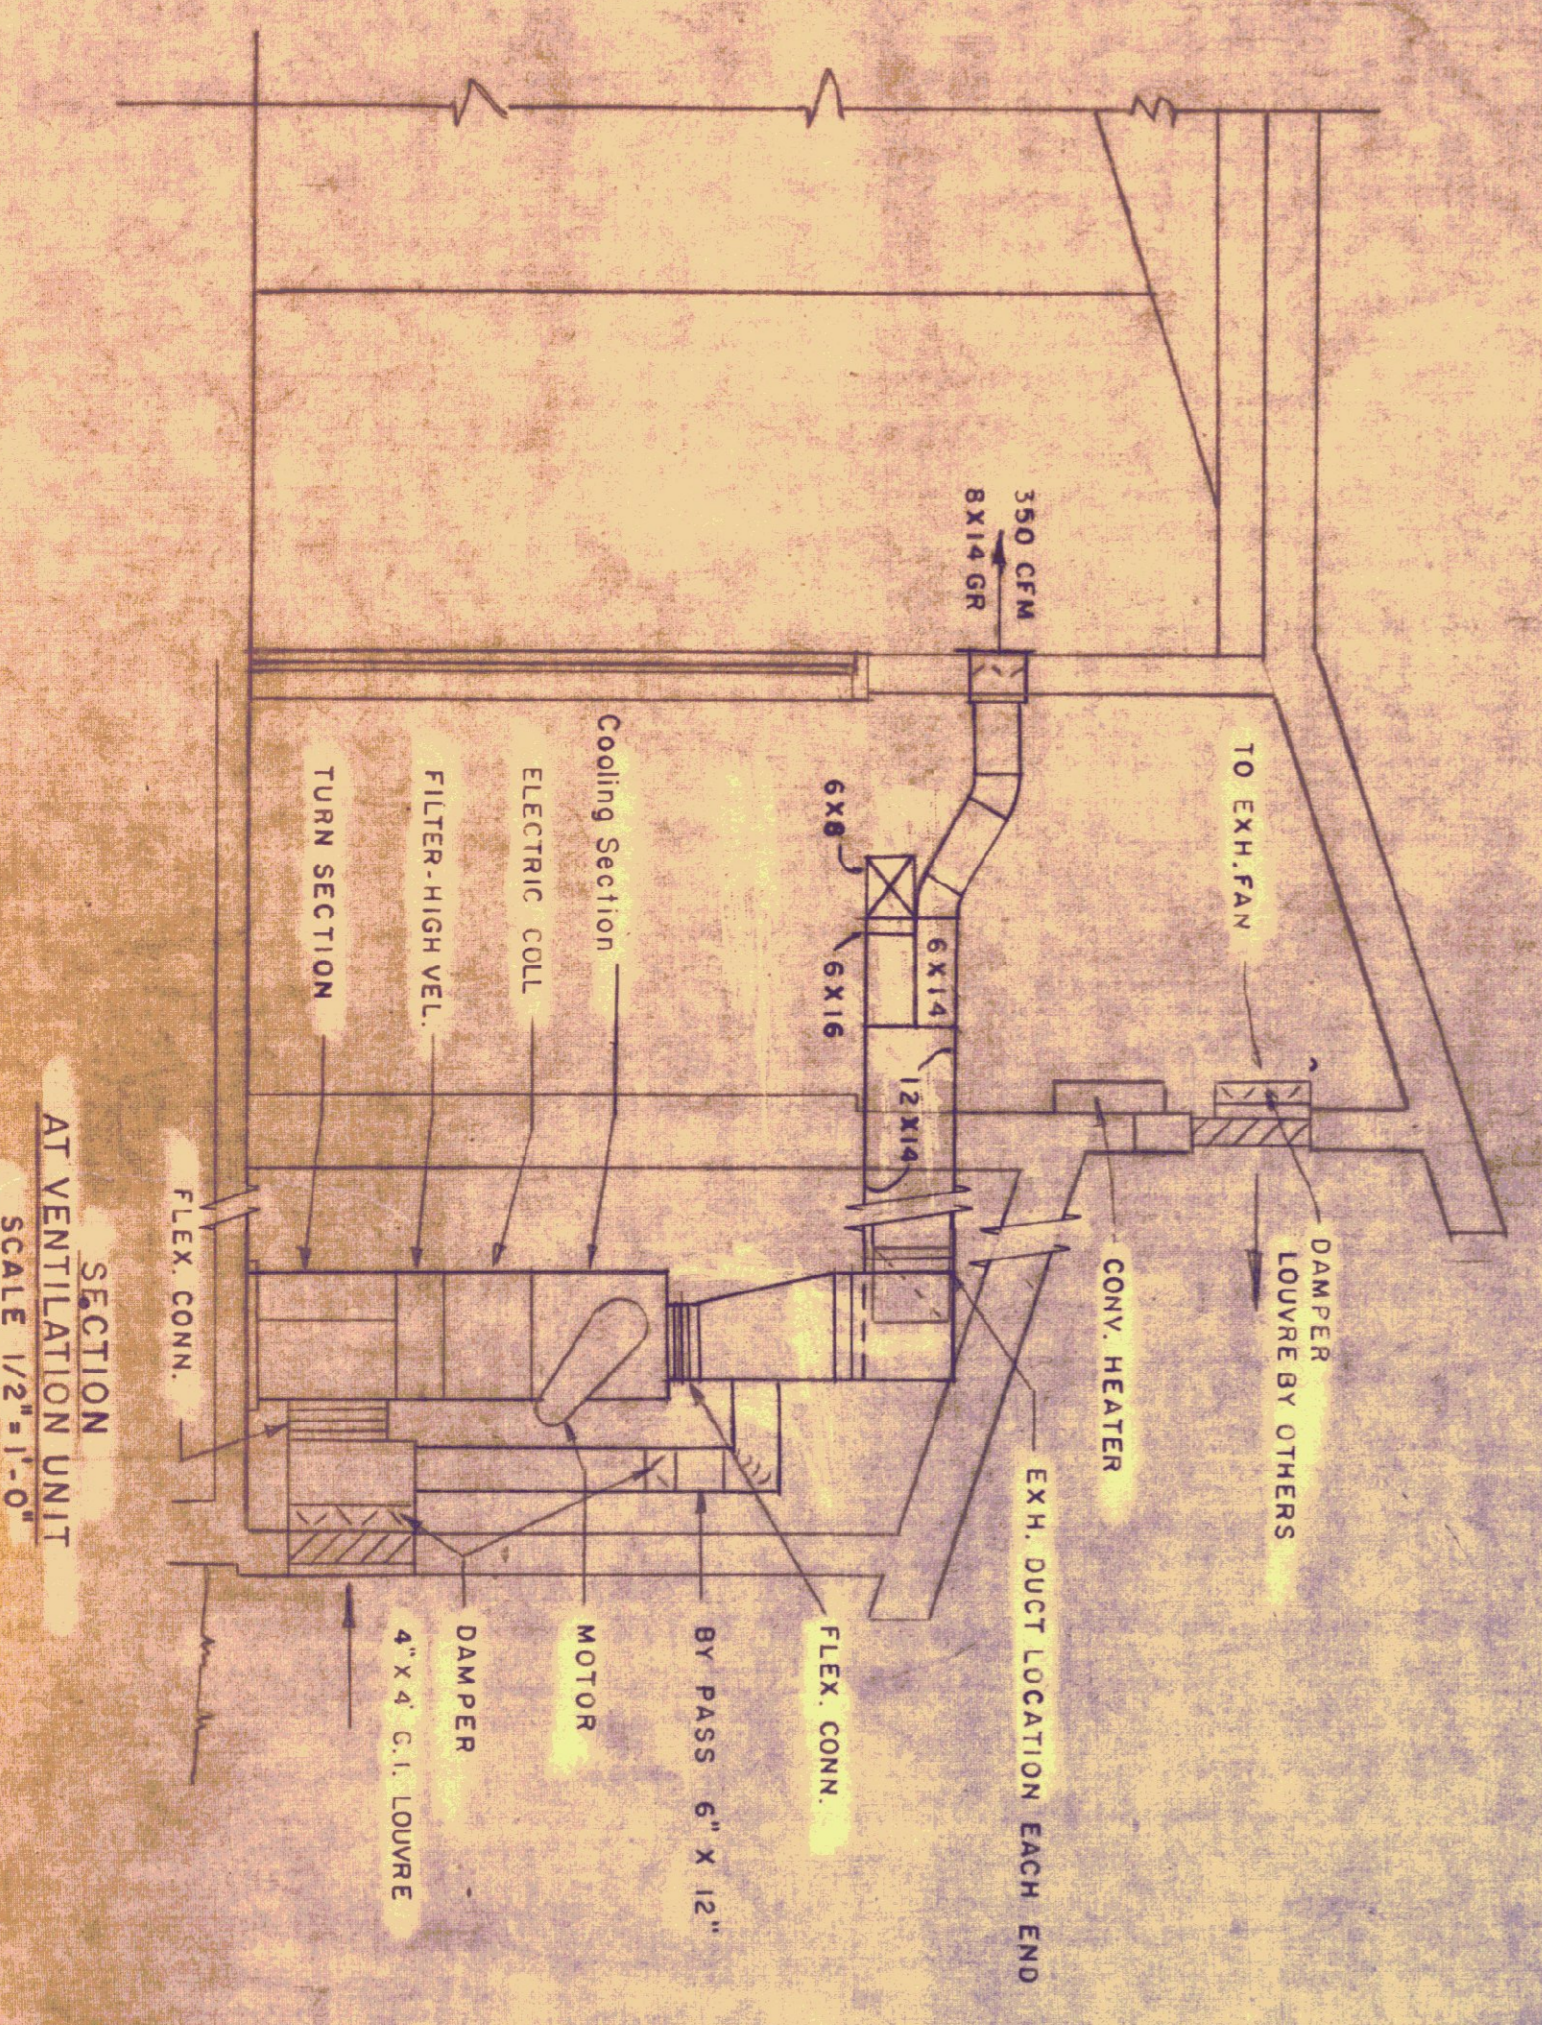


NOTE
SEE ARCH. SECTIONS FOR HEATER LOCATIONS

HEATING PLAN
SCALE 1/4" = 1'-0"


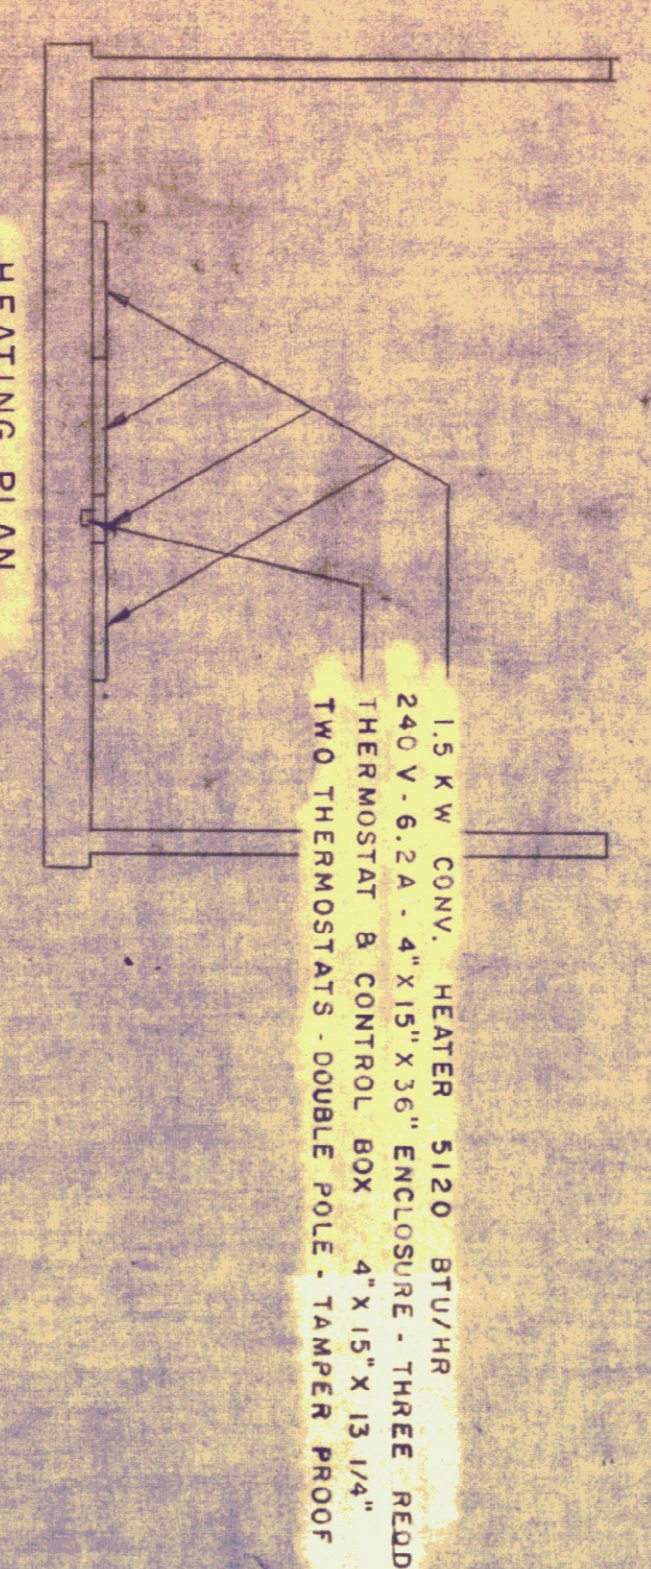


SECTION AT VENTILATION UNIT
SCALE 1/2" = 1'-0"

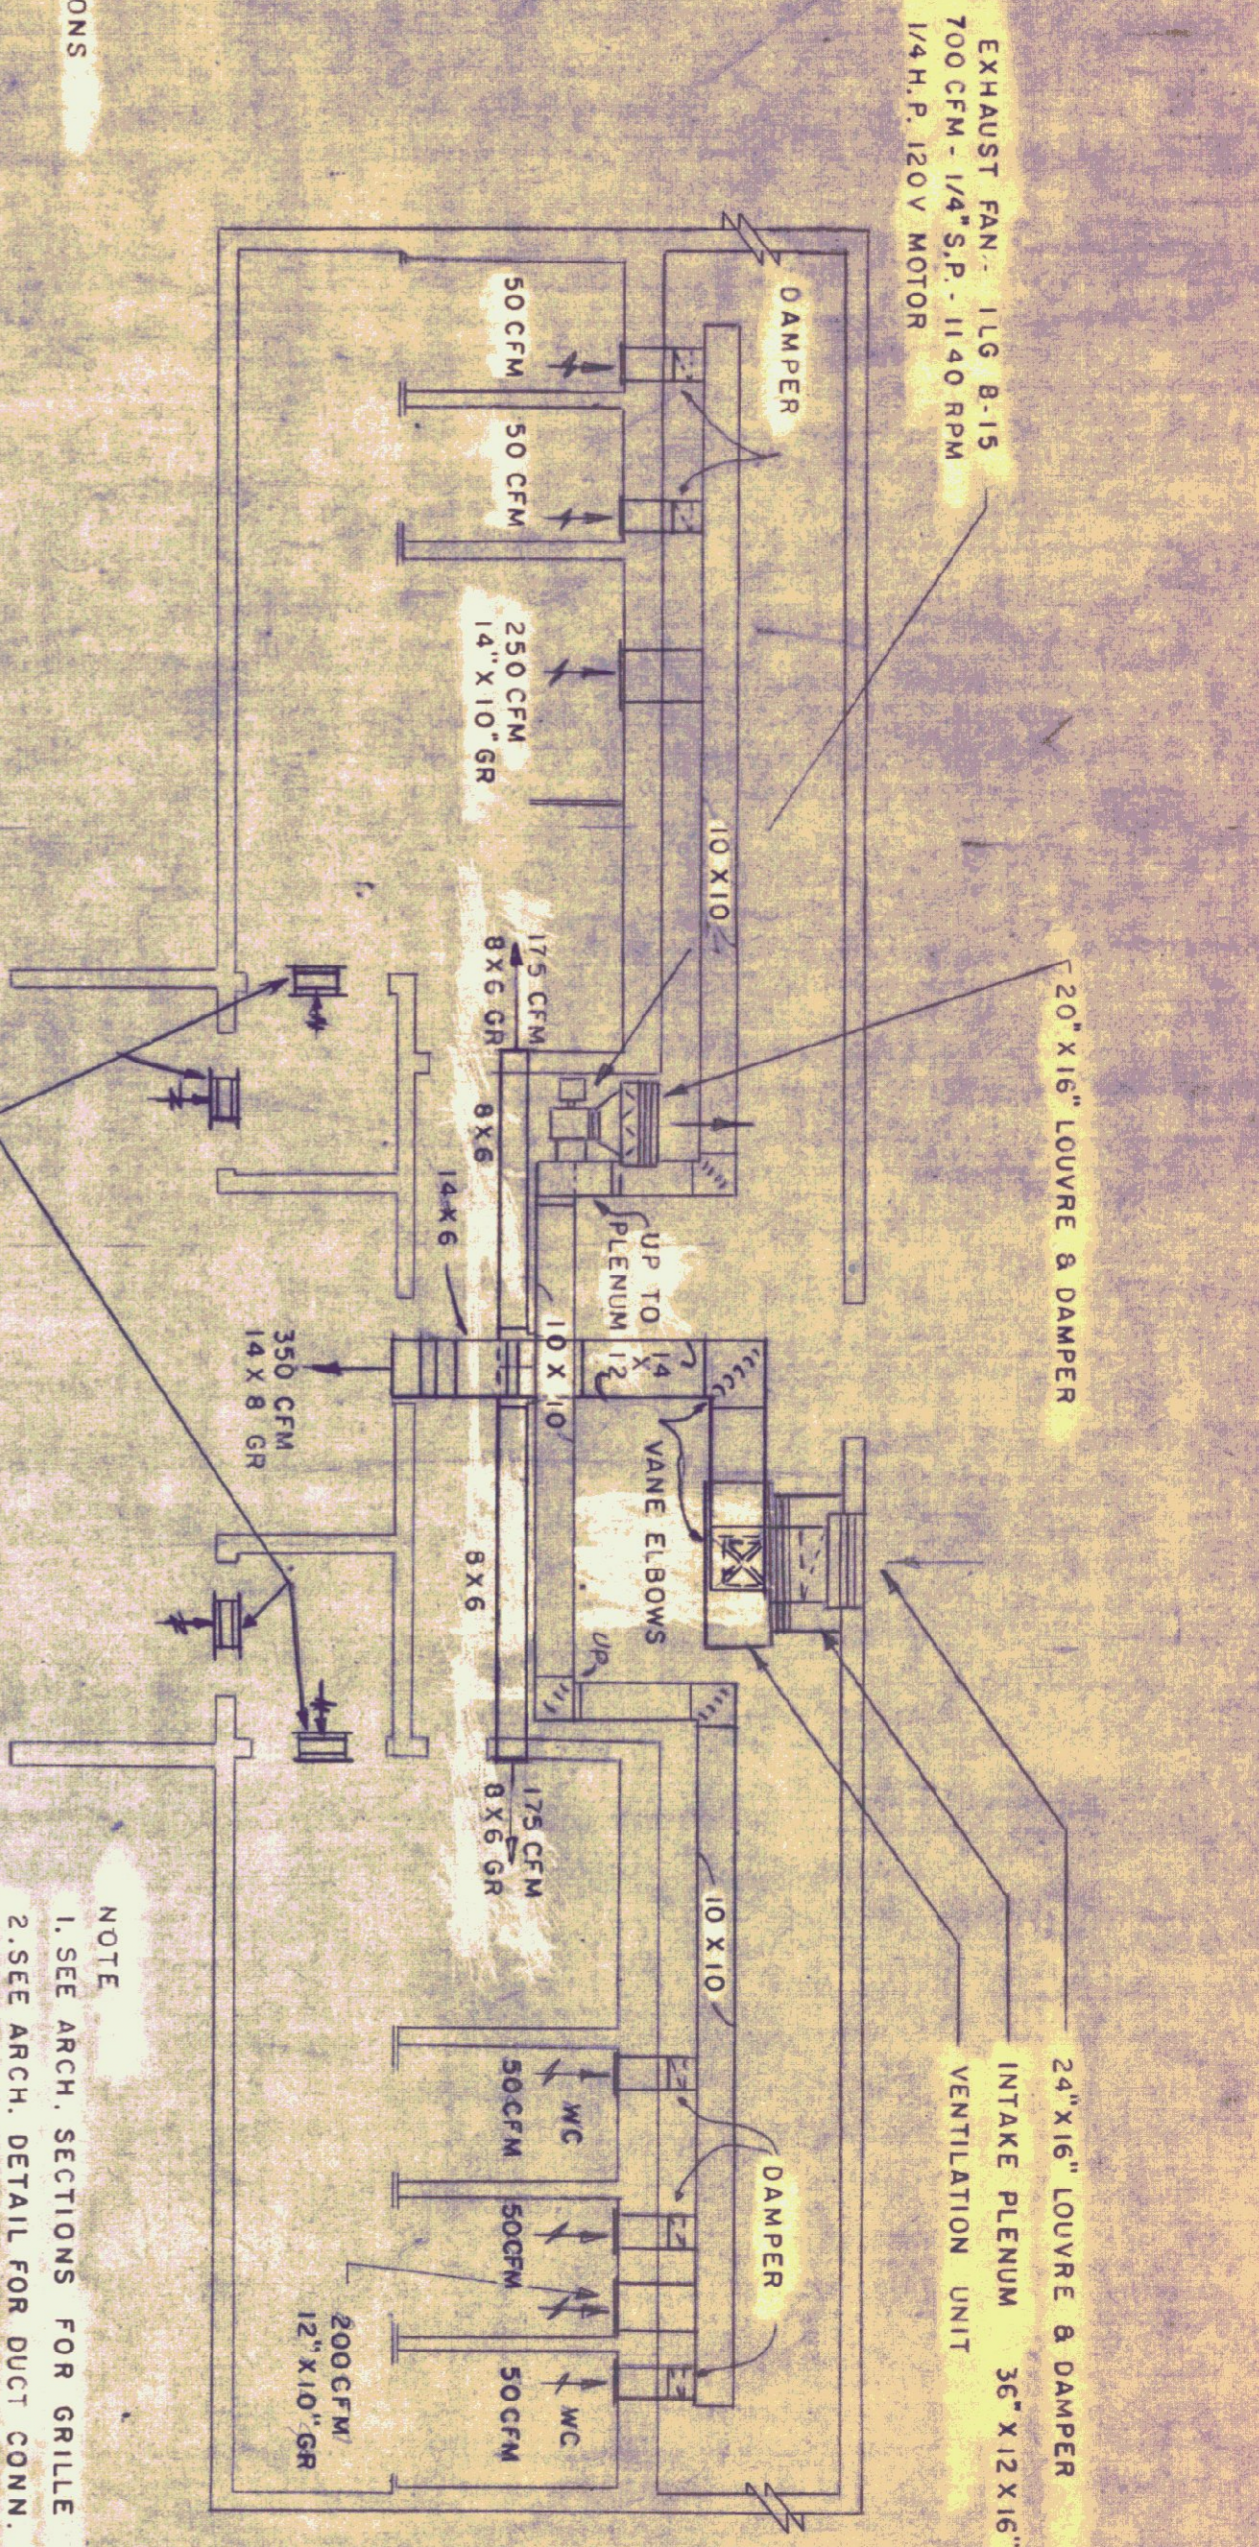

NOTE
1. SEE ARCH. SECTIONS FOR GRILLE LOCATIONS
2. SEE ARCH. DETAIL FOR DUCT CONN. AT WATER CLOSERS.

VENTILATION PLAN
SCALE 1/4" = 1'-0"

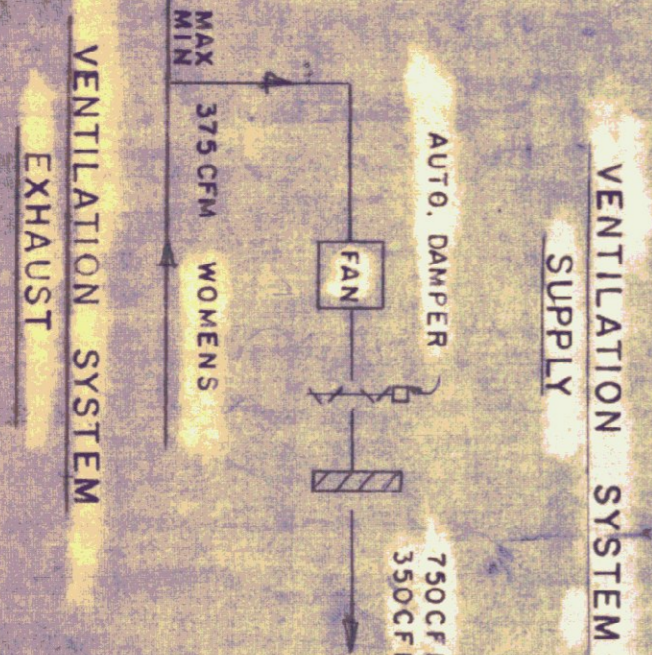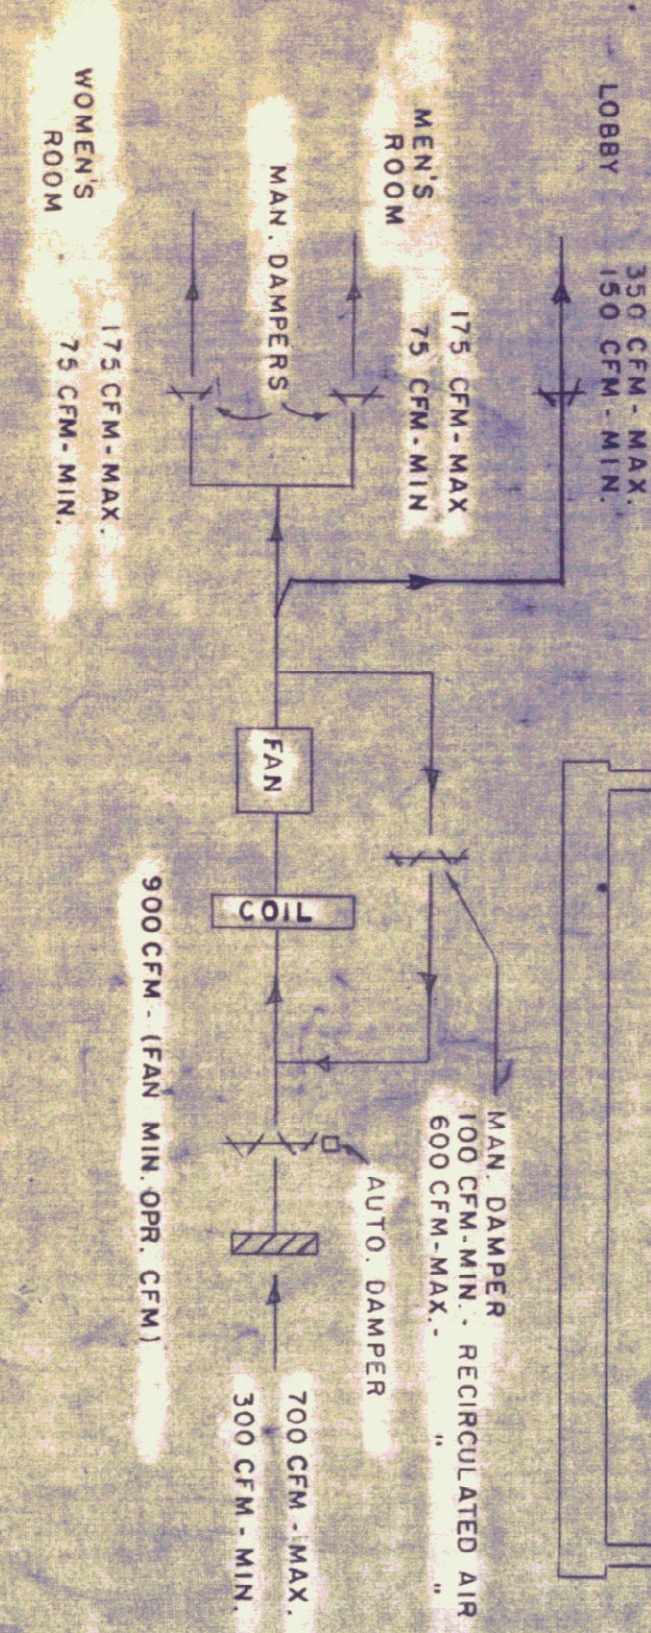

FLOW DIAGRAMS
NO SCALE