


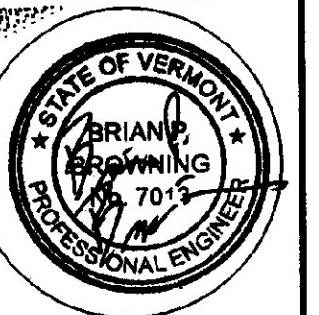

No.	DATE	REVISION

DUNCAN • WISNIEWSKI ARCHITECTURE
285 SOUTH CHAMPLAIN STREET, BURLINGTON, VERMONT 05401 (802) 864-0663


Hallam Associates
60 Farrell Street, Suite 300
Burlington, Vermont 05403
(802) 855-4381

WILLISTON INFORMATION CENTER
189 NORTHBOUND
STATE PROJECT # IM-BLDG (4)


LOFT LIGHTING AND POWER PLAN

DRAWN: LCS
CHECKED: BPB
PROJ.No: 10215
DATE: JAN 15, 2001


E-5nb

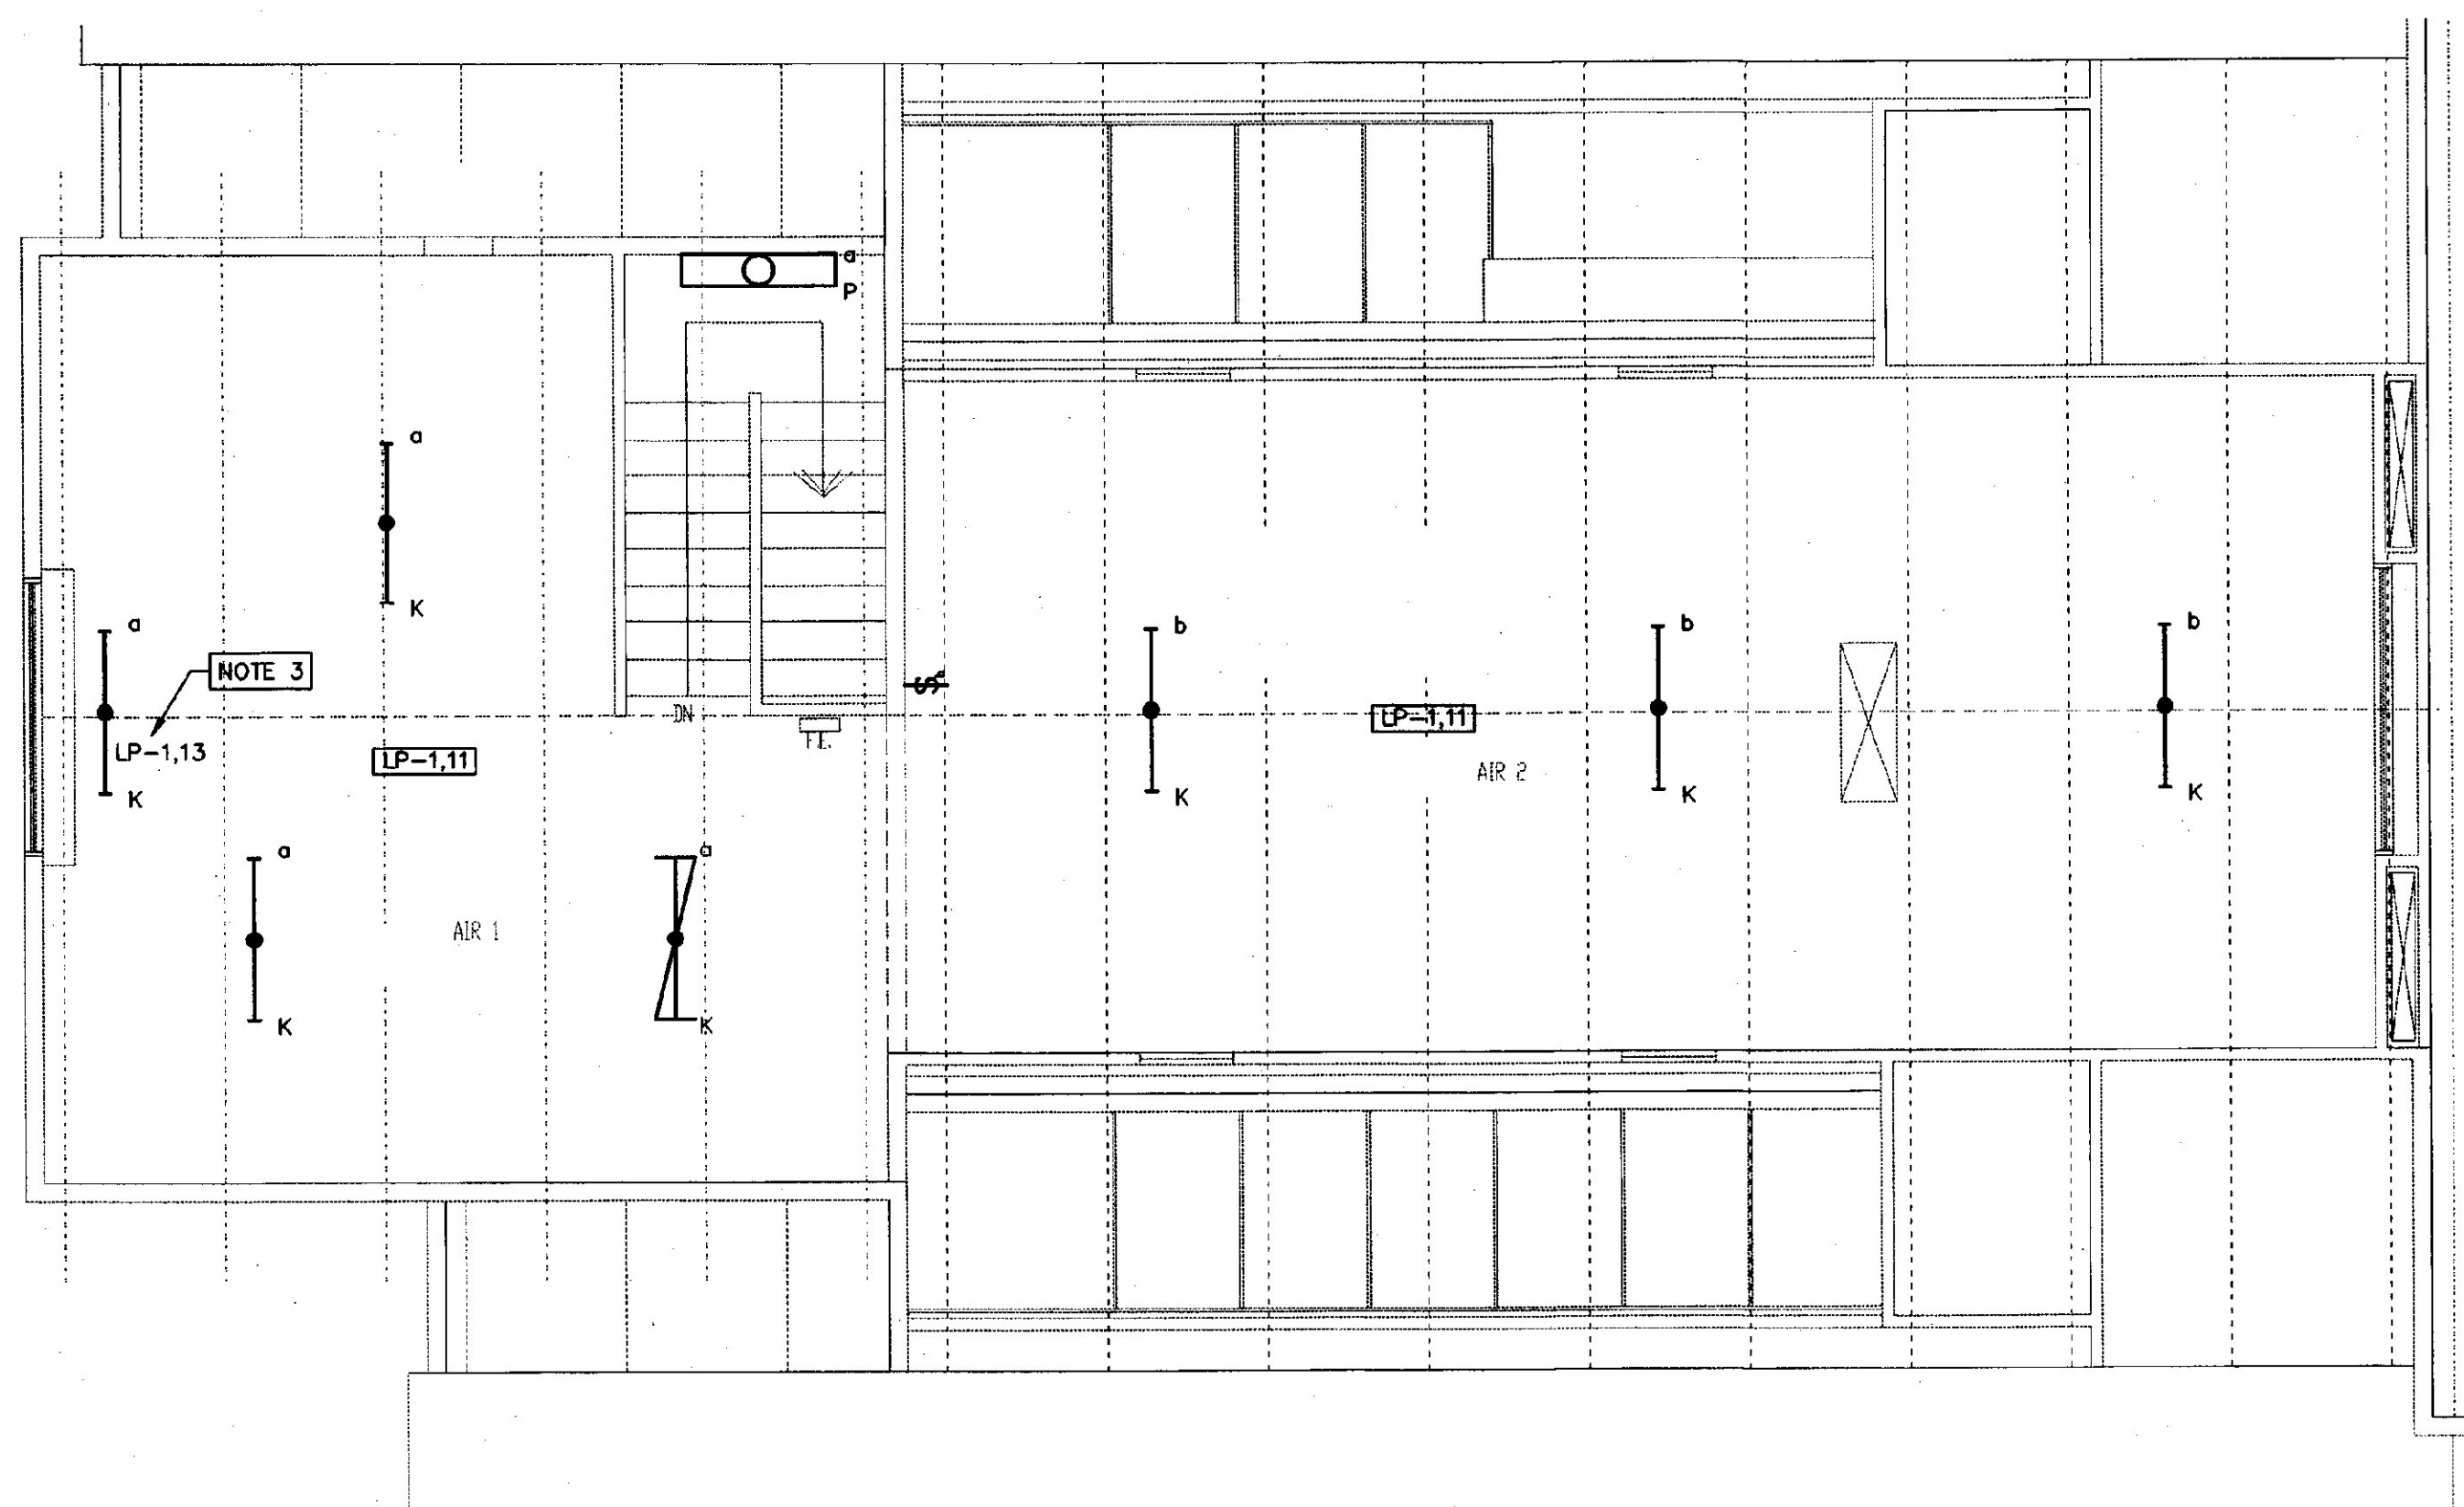

LOFT LIGHTING PLAN
SCALE: 1/4"=1'-0"

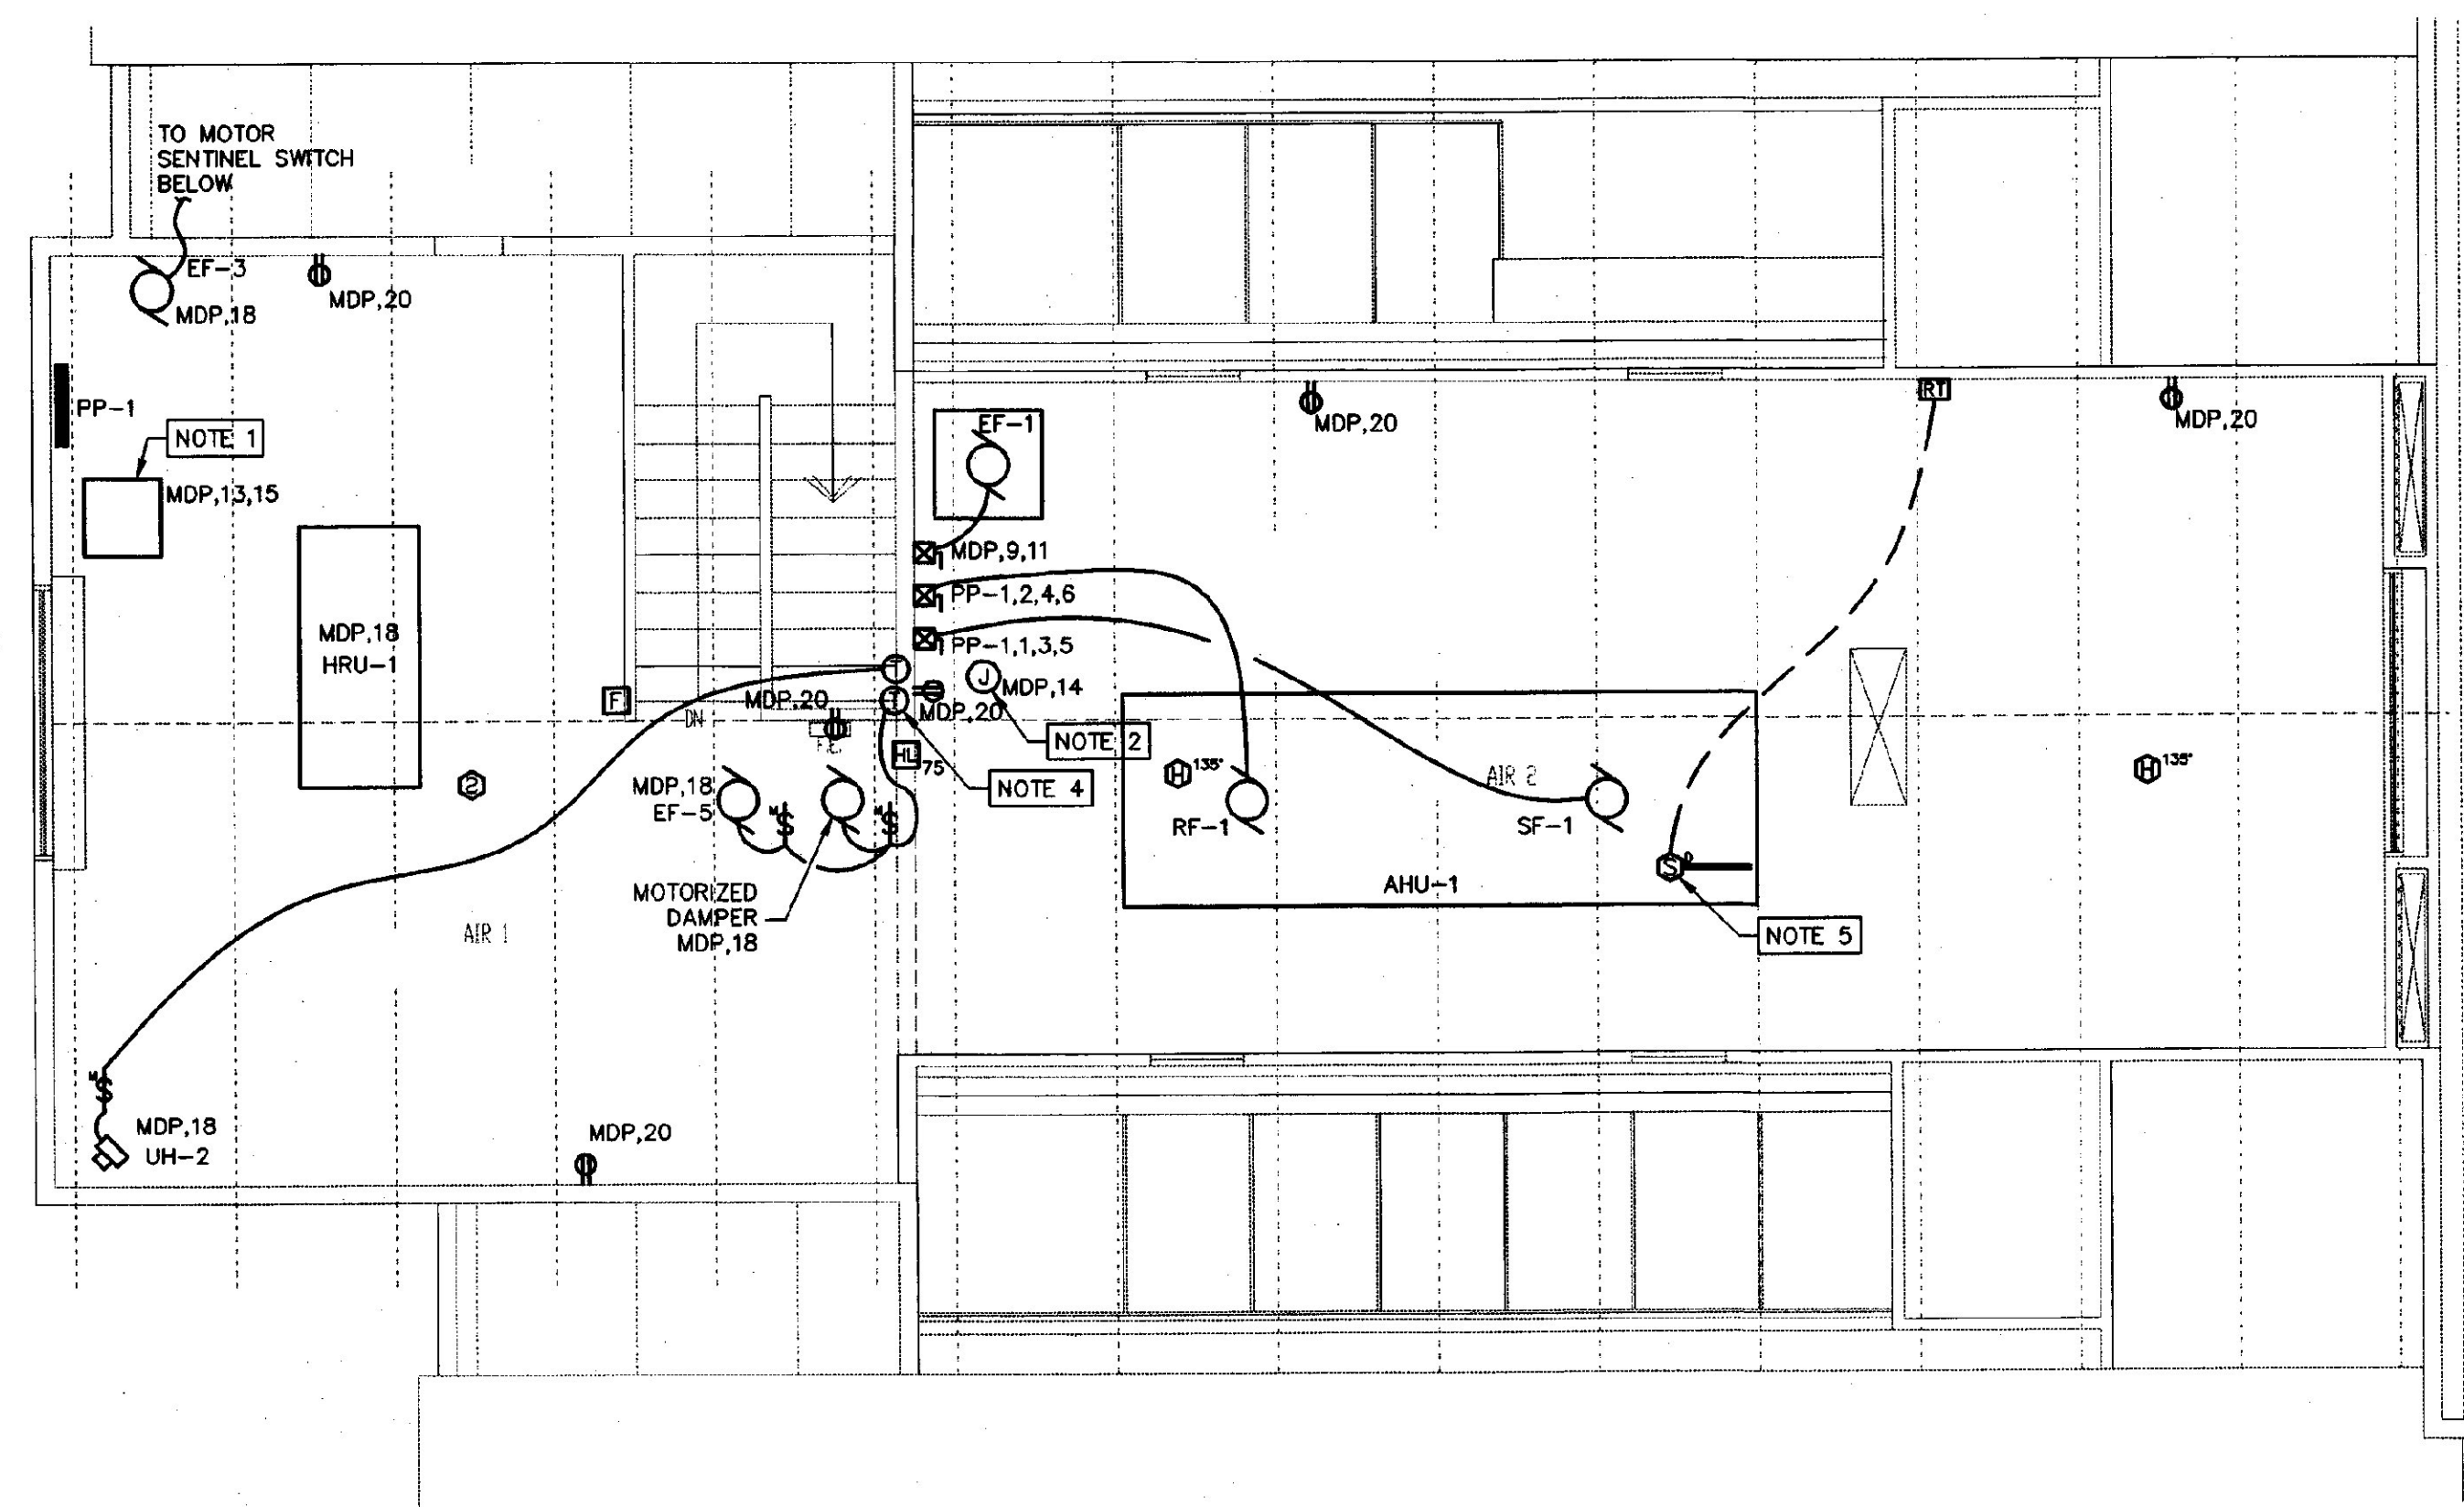


LOFT POWER PLAN
SCALE: 1/4"=1'-0"

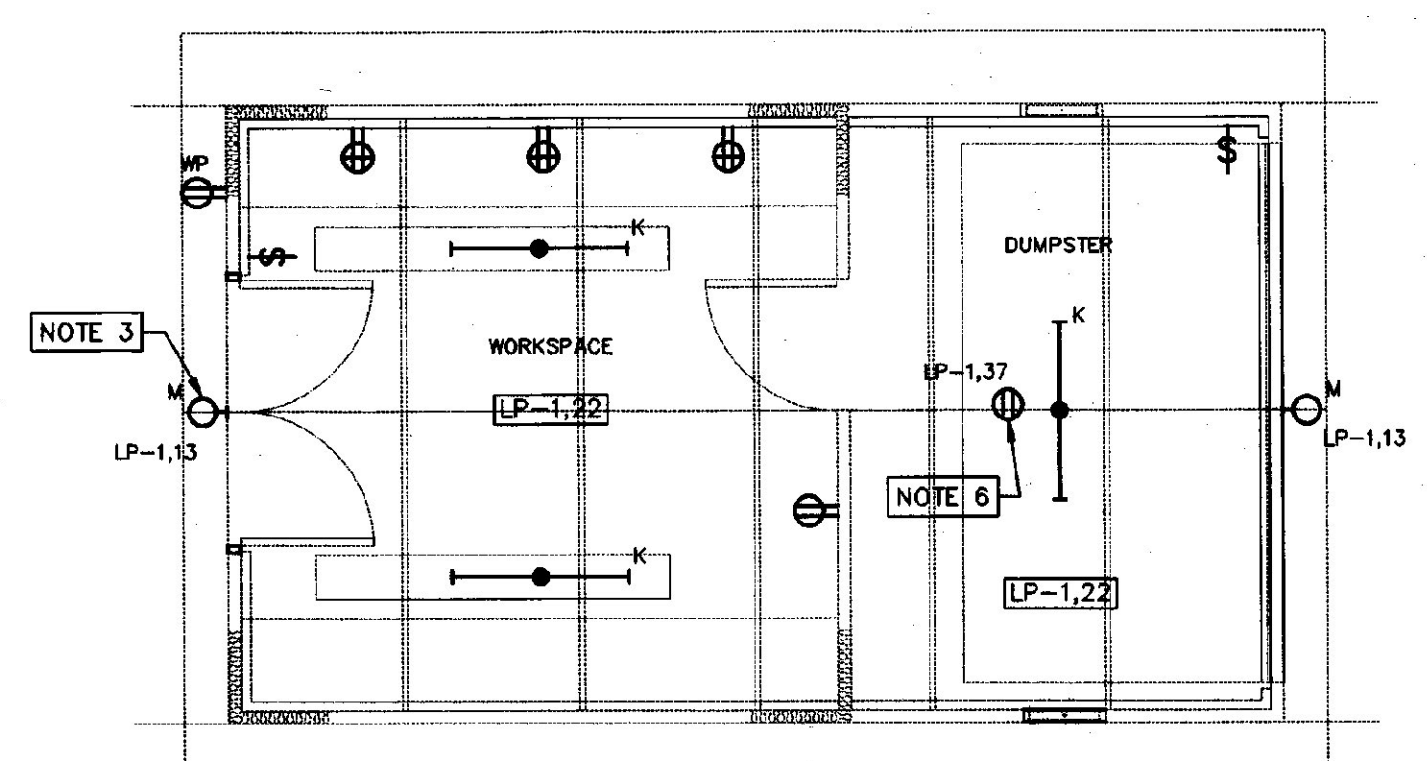

SERVICE BUILDING LIGHTING AND POWER PLAN
SCALE: 1/4"=1'-0"


NOTES: (APPLY TO LOFT AND SERVICE BUILDING PLANS)

1. FURNISH AND INSTALL ROTARY PHASE CONVERTER. REFER TO WIRING DIAGRAM BELOW AND SPECIFICATIONS FOR MORE DETAIL.
2. FURNISH AND INSTALL JUNCTION BOX FOR CONTROL POWER.
3. ALL FIXTURES FED FROM PANEL LP-1, CIRCUIT 13 SHALL BE CONTROLLED BY PHOTOCELL AND LIGHTING CONTACTOR AS SHOWN ON WIRING DIAGRAM ON DRAWING E-7.
4. THERMOSTAT FOR EXHAUST FAN TO BE FURNISHED BY MECHANICAL CONTRACTOR AND INSTALLED BY ELECTRICAL CONTRACTOR AT LOCATION SHOWN. REFER TO EXHAUST FAN #5 WIRING DIAGRAM BELOW FOR MORE INFORMATION.
5. PROVIDE A DUCT MOUNTED SMOKE DETECTOR IN EACH SUPPLY DUCT OF MULTI-ZONE UNIT. LOCATE DUCT SMOKE DETECTORS AND ASSOCIATED REMOTE TEST SWITCHES IN MECHANICAL ROOM. TYPICAL OF (7) DUCT SMOKE DETECTORS AT THIS LOCATION.
6. FURNISH AND INSTALL DEDICATED RECEPTACLE FOR ELECTRIC GARAGE DOOR.

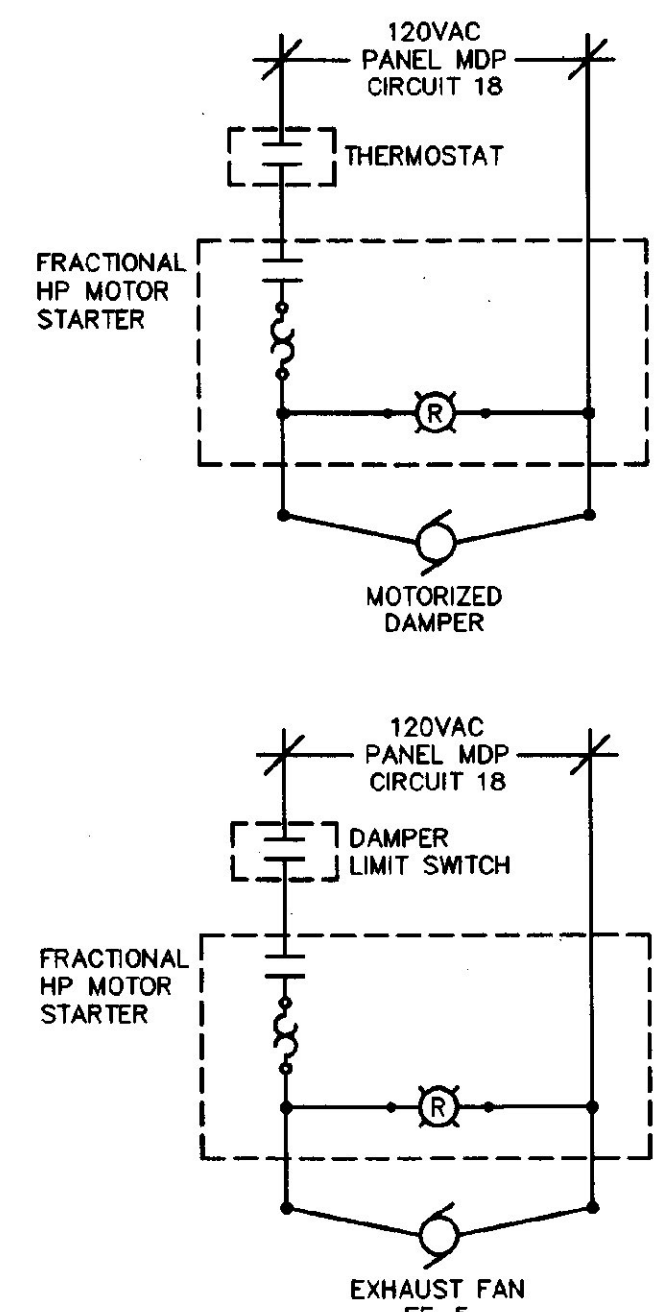

EXHAUST FAN #5 WIRING DIAGRAM
SCALE: NONE

- NOTES:**
1. LIMIT SWITCH SHALL BE PROVIDED BY MECHANICAL CONTRACTOR.
 2. THERMOSTAT SHALL BE PROVIDED BY MECHANICAL CONTRACTOR AND INSTALLED BY ELECTRICAL CONTRACTOR.

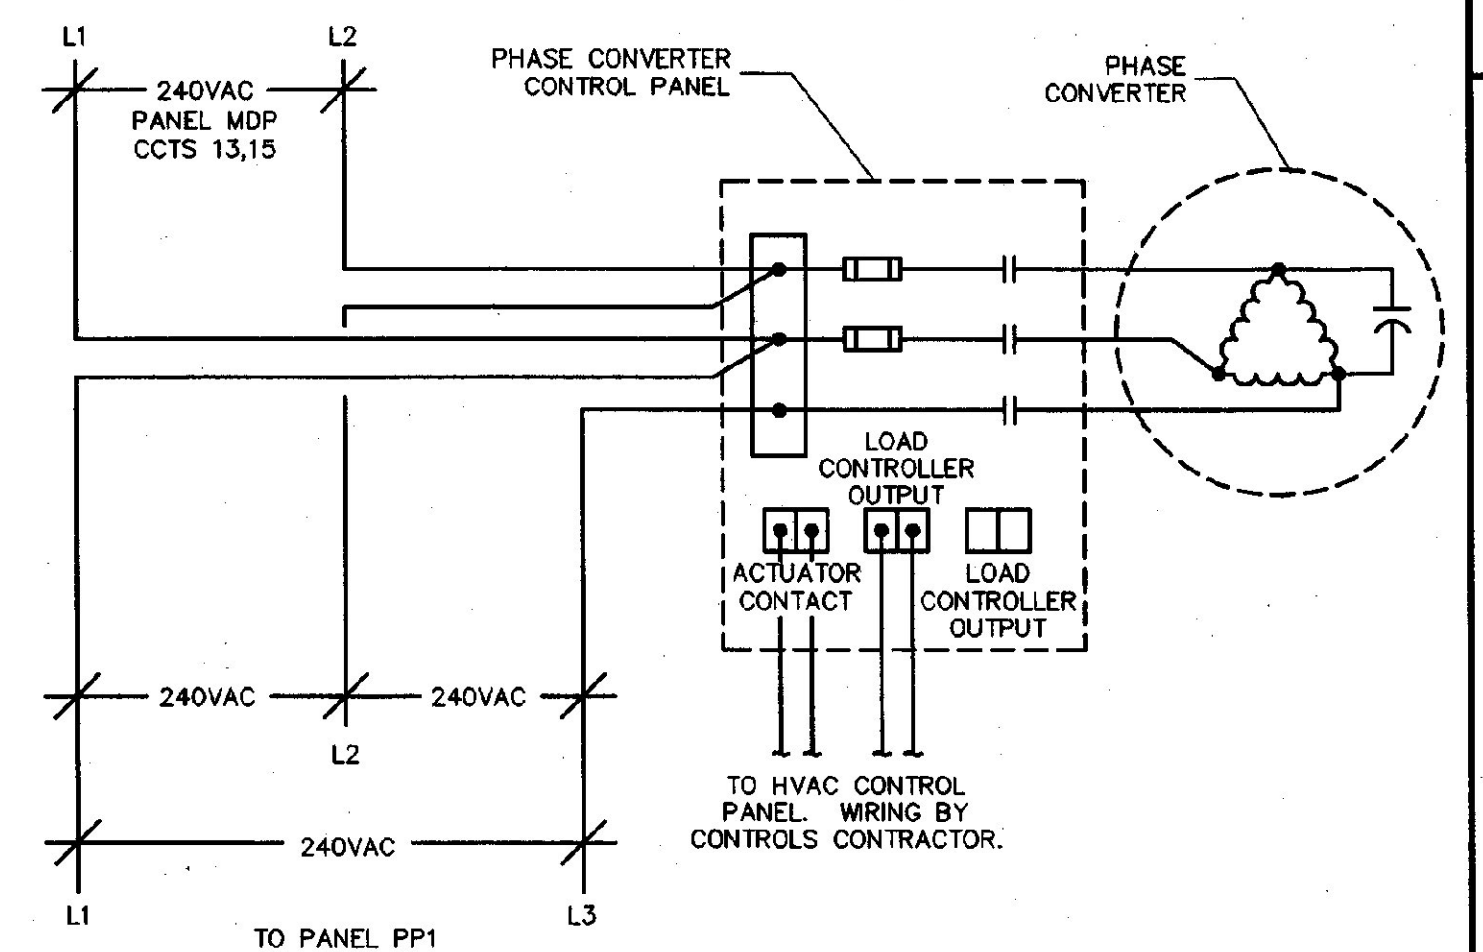

PHASE CONVERTER WIRING DIAGRAM
SCALE: NONE