




DETAIL OF FLUSH FLOOR CLEANOUT
NOT TO SCALE

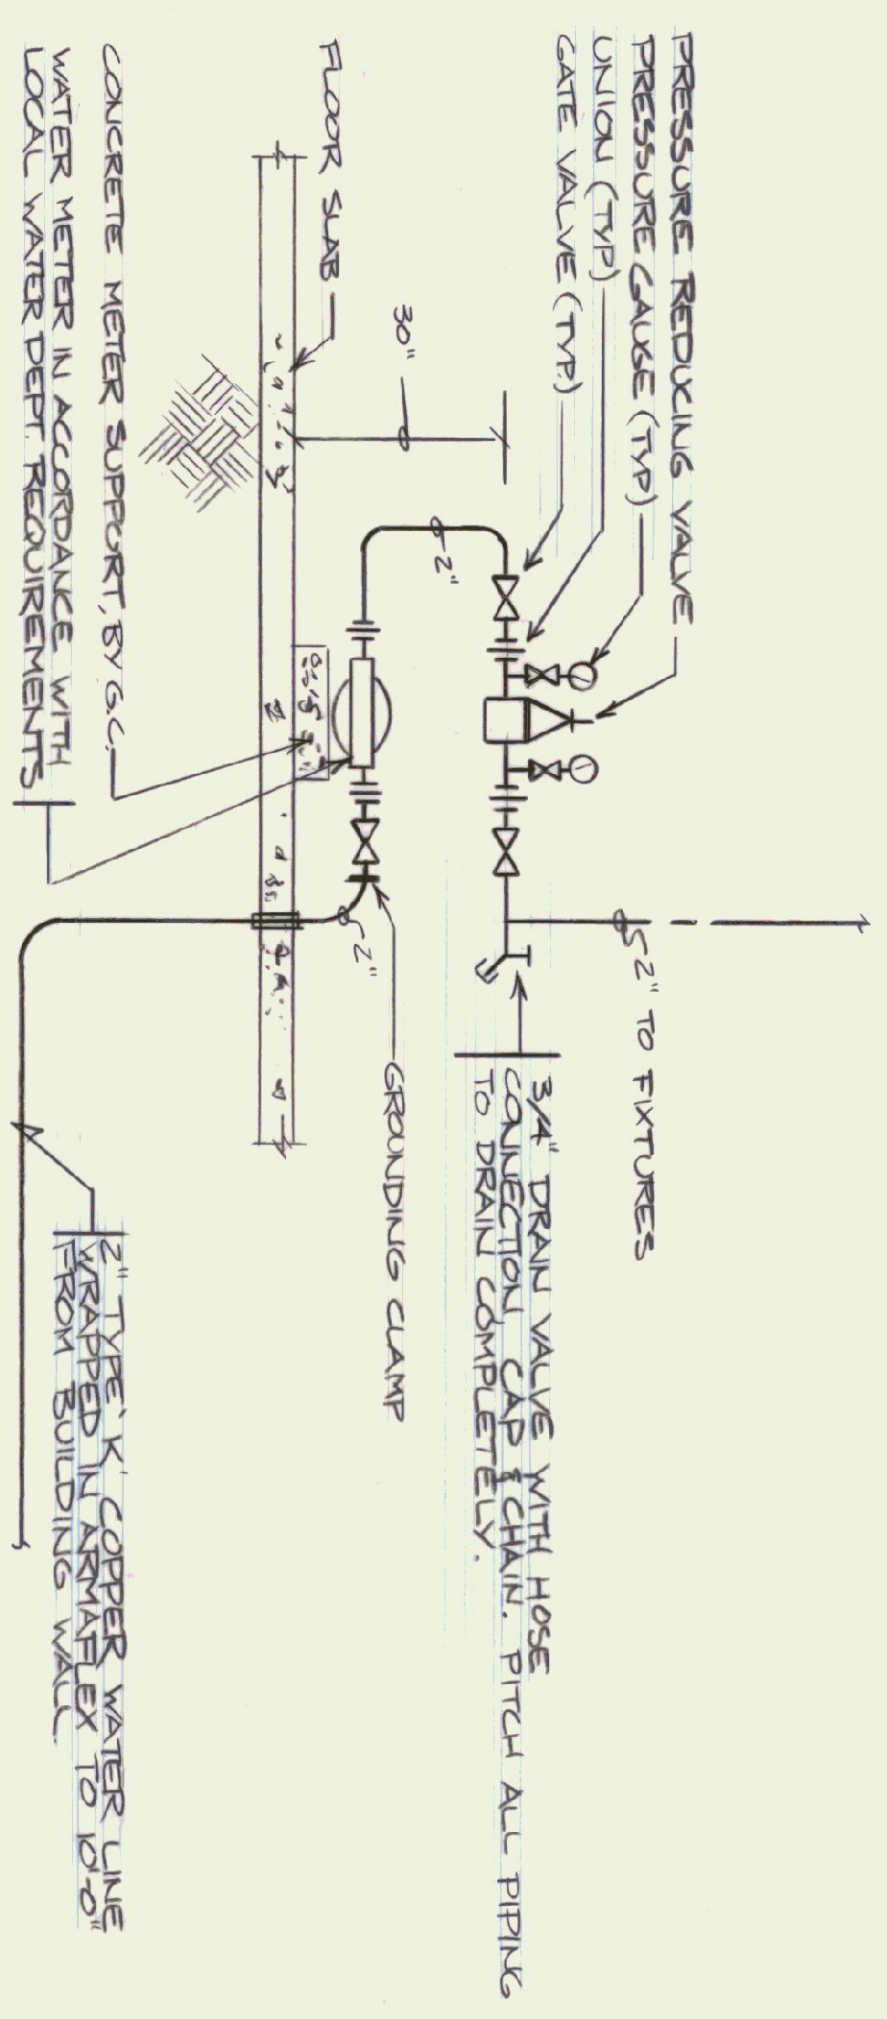


INCOMING WATER SERVICE DETAIL
NOT TO SCALE

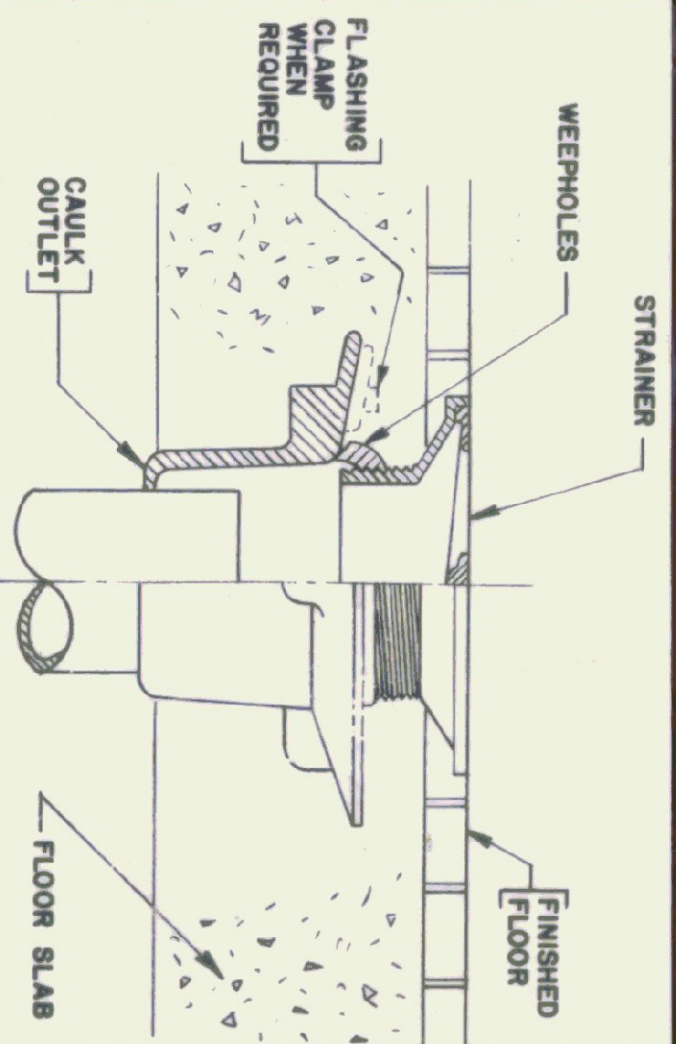


FLOOR DRAIN DETAIL
NOT TO SCALE

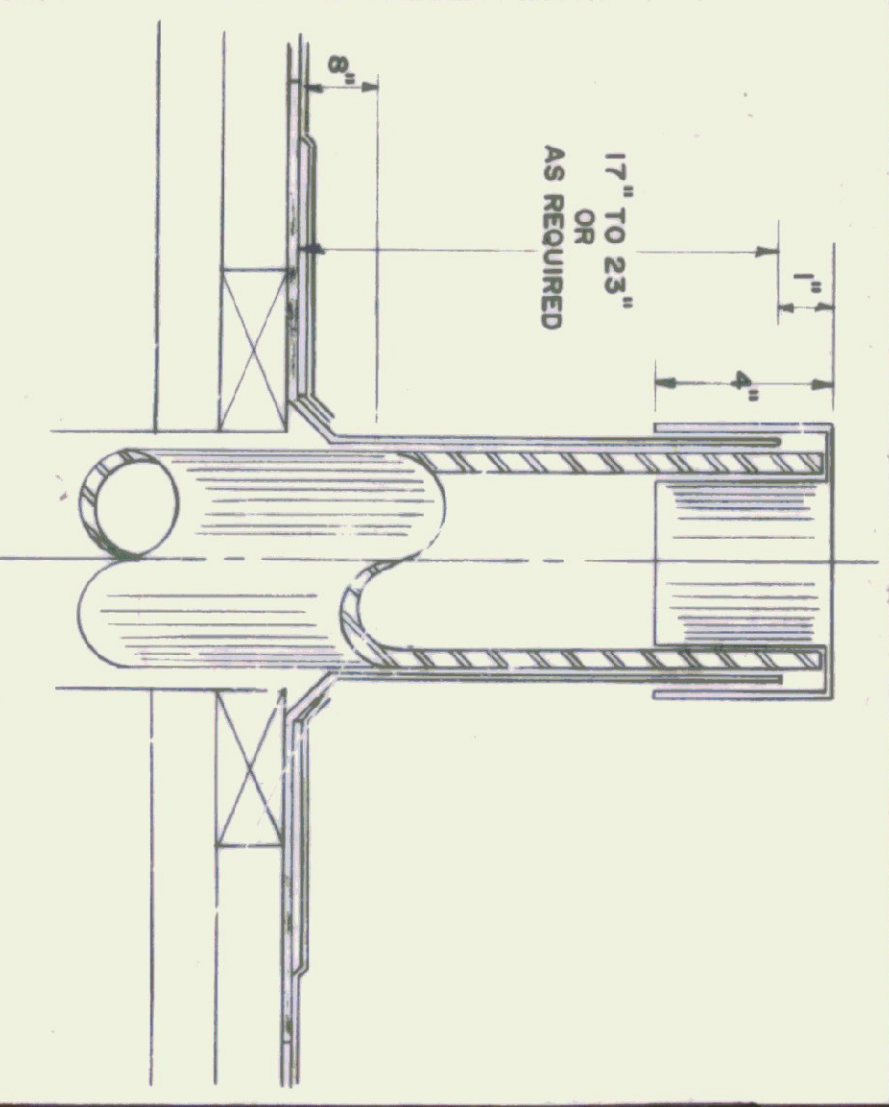


ROOF VENT DETAIL
NOT TO SCALE

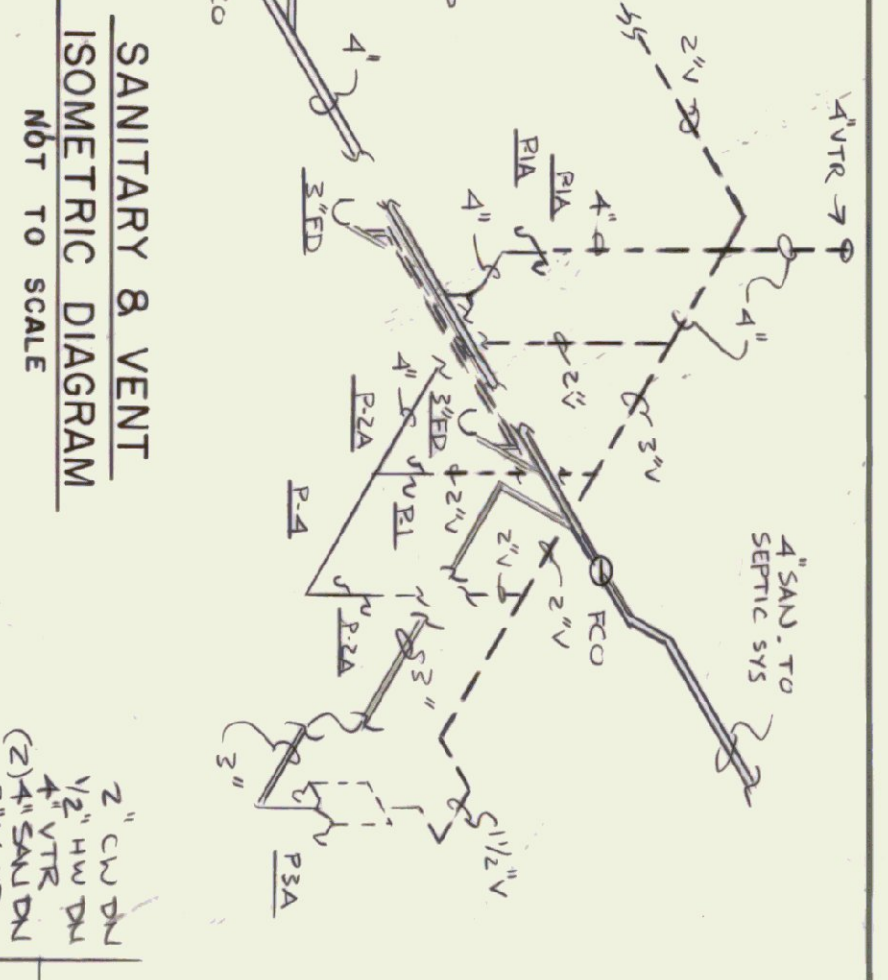

SANITARY & VENT
ISOMETRIC DIAGRAM
NOT TO SCALE

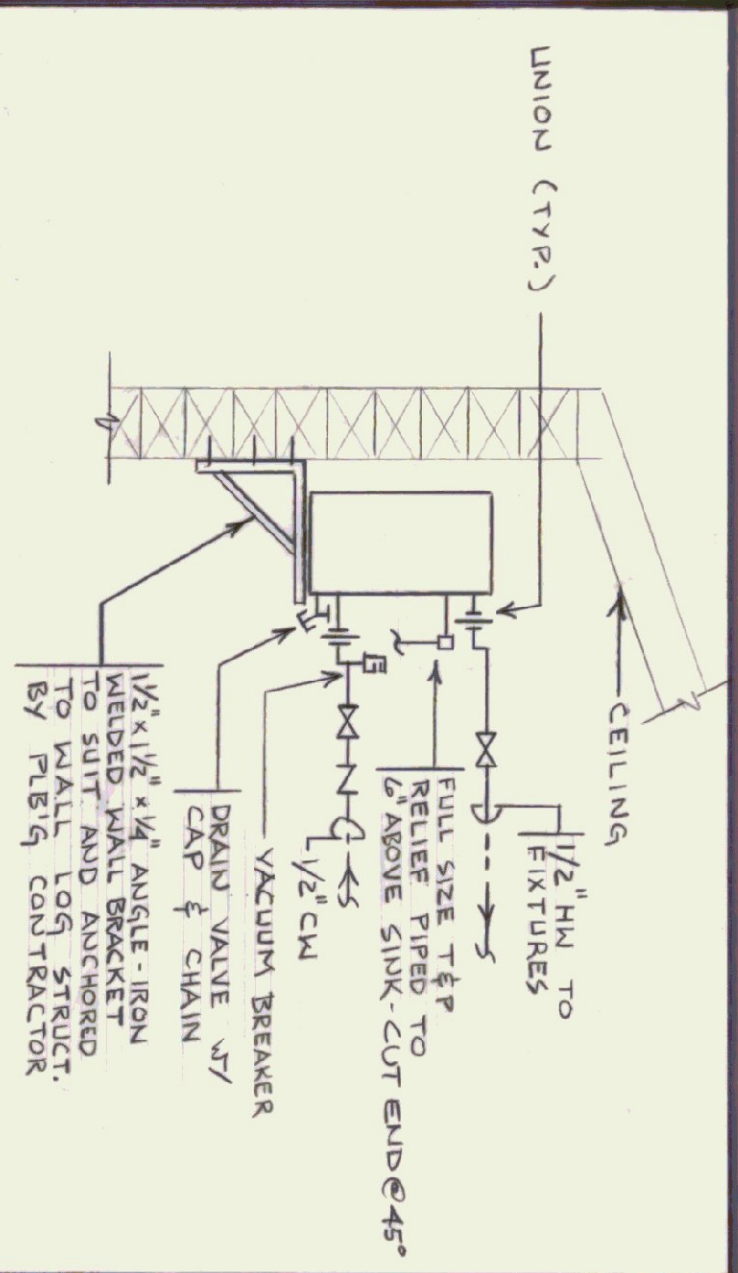


DOMESTIC HOT WATER HEATER DETAIL
NOT TO SCALE

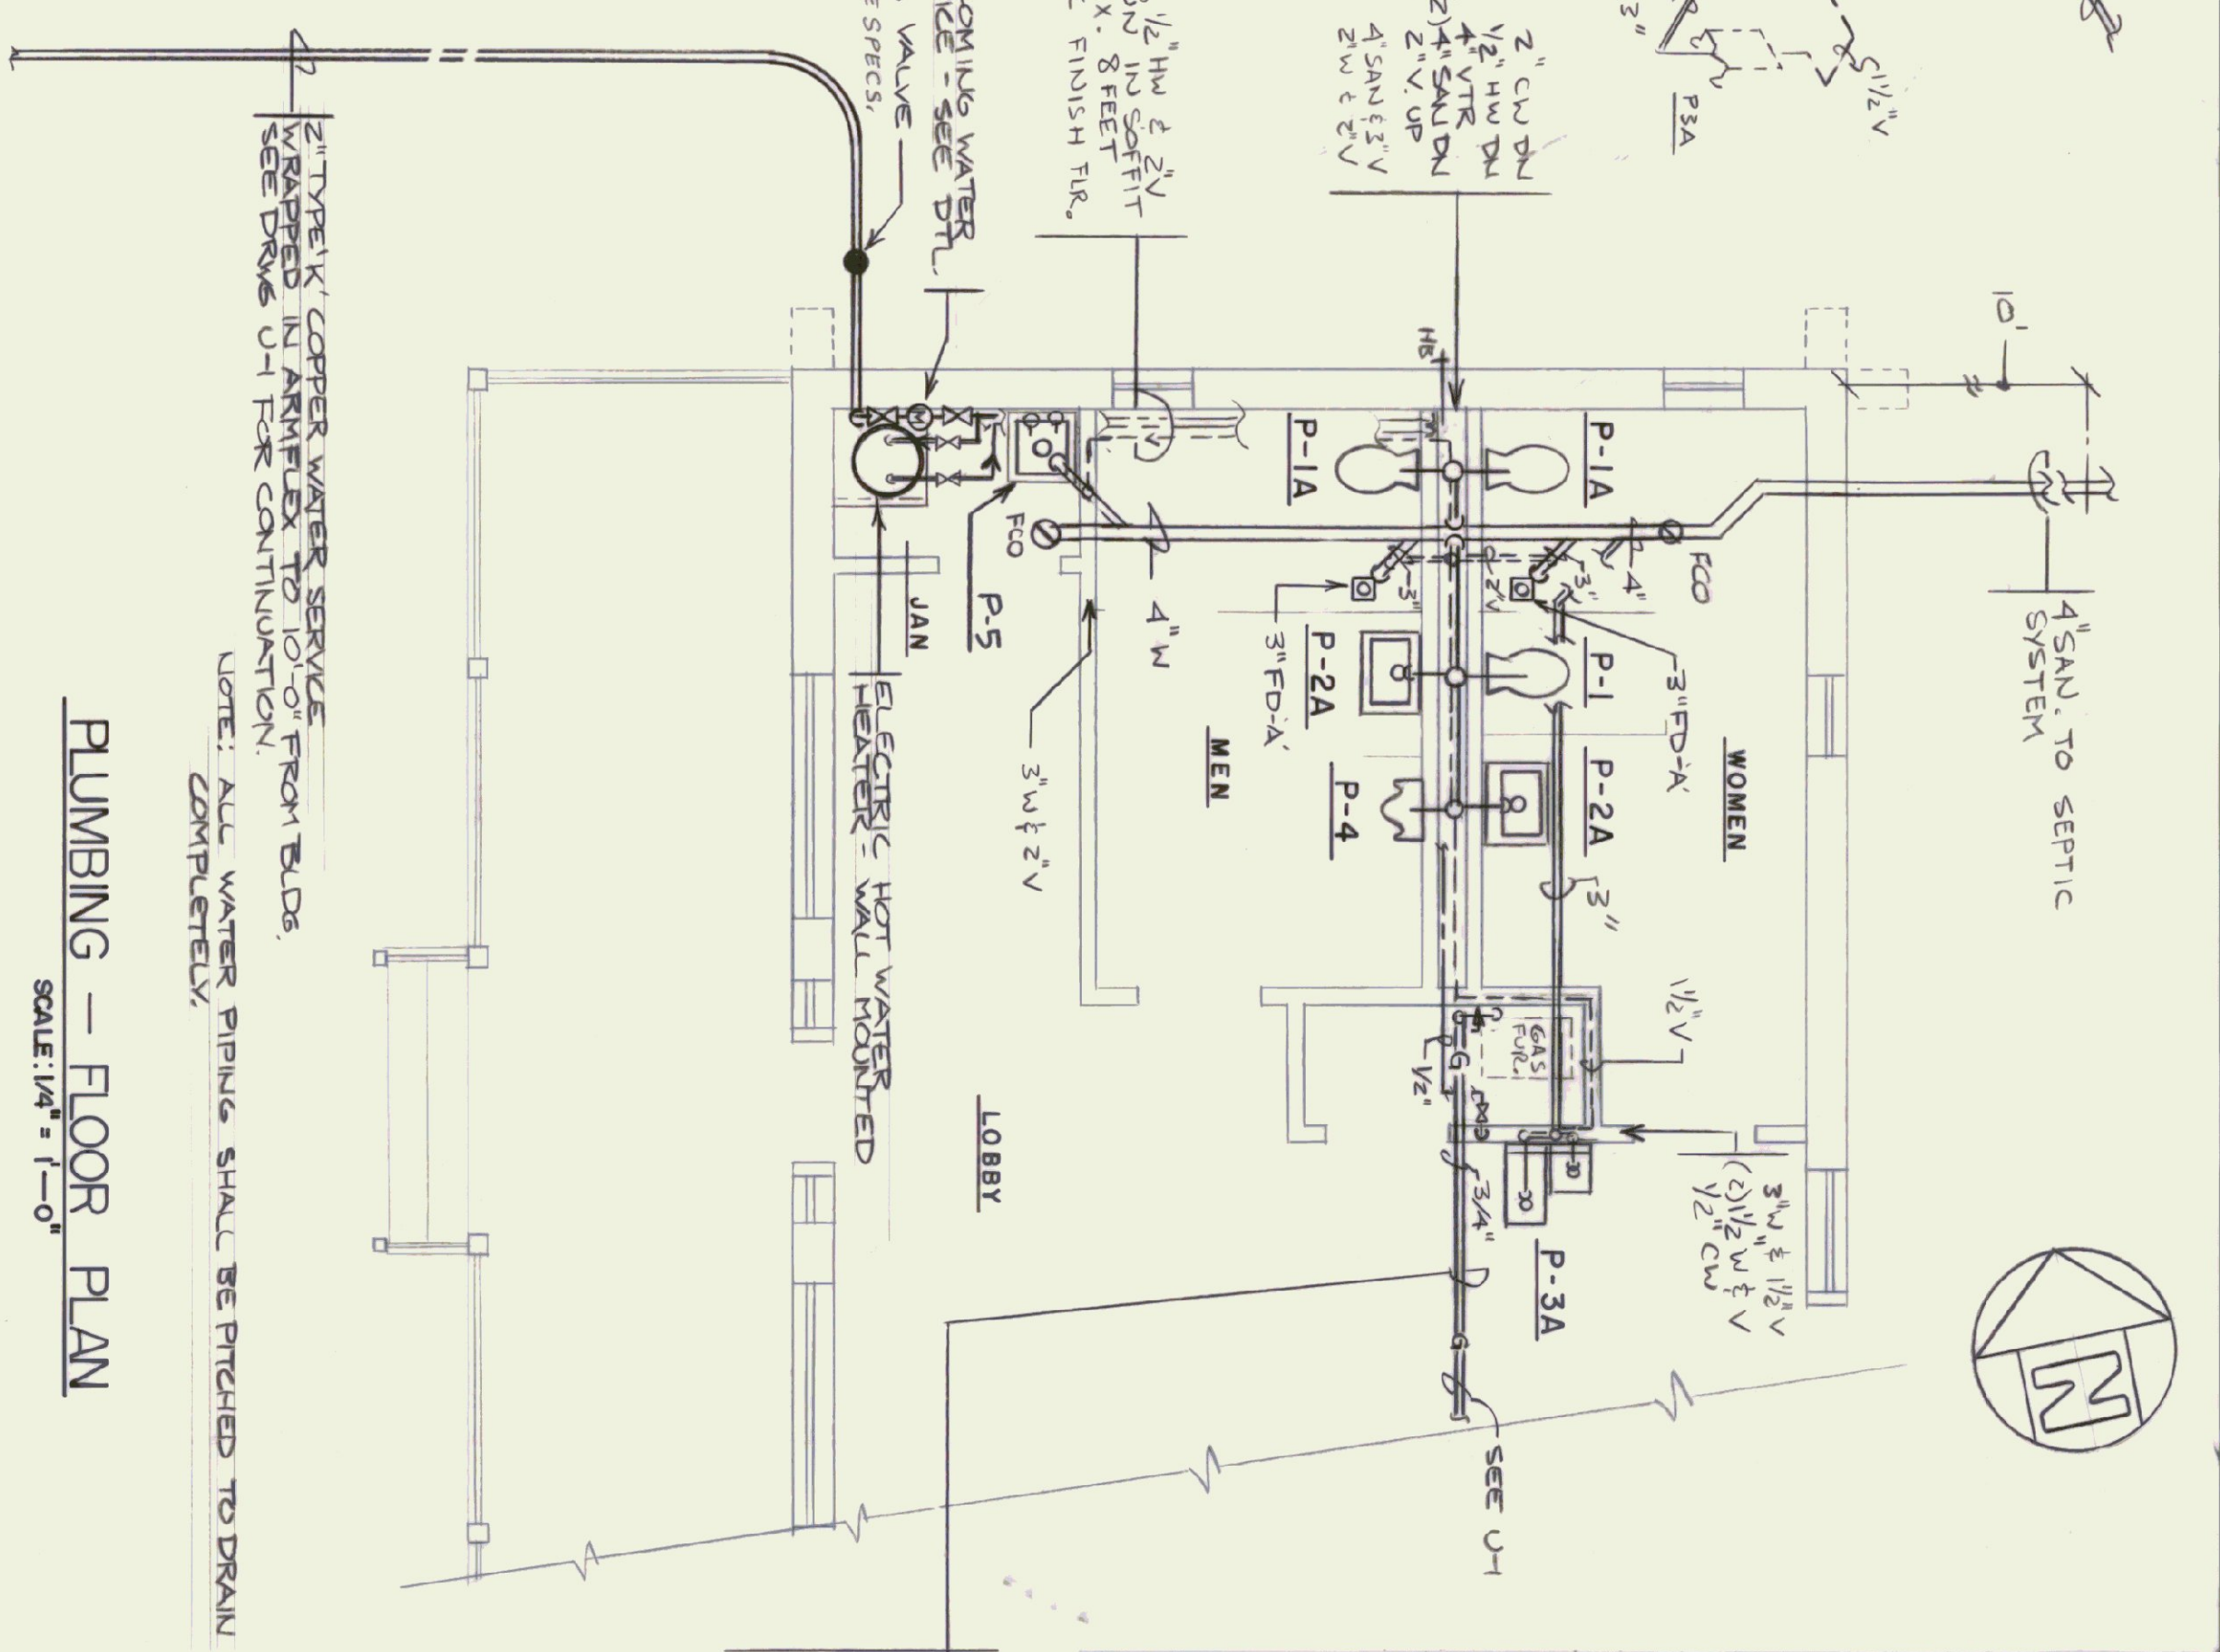

PLUMBING - FLOOR PLAN
SCALE: 1/4" = 1'-0"


PLUMBING FIXTURE & RUNOUT SCHEDULE				
MARK	FIXTURE	DESCRIPTION	COLD WATER	HOT WATER
P-1	WATER CLOSET (REG. USED)	WATER CLOSET (REG. USED)	1 1/4"	1 1/4"
P-2A	WATER CLOSET (HANDI-CAP USE)	WATER CLOSET (HANDI-CAP USE)	1/2"	1/2"
P-3A	LAVATORY (WALL HUNG) HANDI-CAP USE	LAVATORY (WALL HUNG) HANDI-CAP USE	1/2"	1/2"
P-4	URINAL (WALL HUNG) HANDI-CAP	URINAL (WALL HUNG) HANDI-CAP	3/4"	3/4"
P-5	JANITOR SINK	JANITOR SINK	1/2"	1/2"

HOT & COLD WATER RISER DIAGRAM
NOT TO SCALE

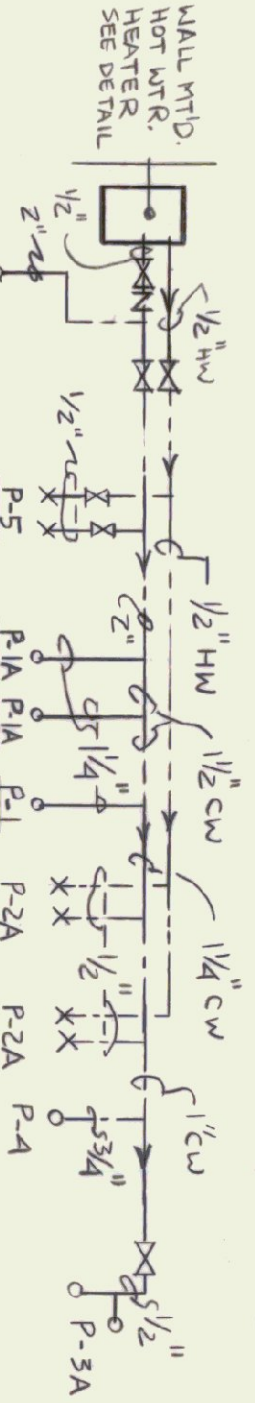

PLUMBING LEGEND	
SYMBOLS USED ARE INDICATED BY A CHECK (✓)	
✓	SANITARY OR WASTE LINE (ABOVE GROUND)
✓	SANITARY OR WASTE LINE (BELOW GROUND)
✓	STORM LINE (ABOVE GROUND)
✓	STORM LINE (BELOW GROUND)
✓	GAS LINE (C.P. GAS)
✓	COMPRESSED AIR LINE
✓	FINE LINE (ABOVE GROUND)
✓	VENT LINE (BELOW GROUND)
✓	COLD WATER LINE (ABOVE GROUND)
✓	COLD WATER LINE (BELOW GROUND)
✓	HOT WATER RECIRCULATING LINE
✓	CLEAN OUT
✓	FLOOR CLEAN OUT
✓	WALL HYDRANT OR HOSE BIBS
✓	GLOBE VALVE
✓	CHECK VALVE
✓	GATE VALVE
✓	FLOOR DRAIN WITH TRAP
✓	NEW
✓	EXISTING
✓	POINT OF PLUMBING CONNECTION TO
✓	SANITARY LINE
✓	STORM LINE
✓	VENT LINE
✓	WASTE LINE
✓	TRAP
✓	ROOF DRAIN
✓	ROOF LEADER

RUN 3/4" TYPE 'V' COPPER W/ 3/4" ARMORFLEX IN 5'0" GALVANIZED STEEL CONDUIT w/ LONG ELBOWS UNDER BUILDING (BY PLUMBING CONTRACTOR). RUN 1/2" MECH. ROOM & CONNECT 3/4" STEEL GAS PIPING (SEE SPEC) W/ GAS SHUT OFF & DIRT LEG TO GAS FIRED HOT AIR FURNACE (FURNACE BY H.V. CONTRACTOR)

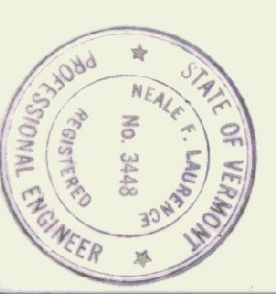

STATE OF VERMONT
DEPARTMENT OF STATE BUILDINGS
AGENCY OF ADMINISTRATION
MONTPELIER, VERMONT

ALBURG WELCOME CENTER
ALBURG

PLUMBING - PARTIAL FLOOR PLAN,
DETAILS, SCHEDULES, DIAGRAMS & LEGENDS

DATE: 3-19-96
SCALE: AS NOTED
DRAWN BY: NH 028-1075
GN, KA

REVISIONS:
3-16-96
P-1

DWG. NO. 11 OF 21