




DEMOLITION - PLUMBING-EXISTING FLOOR PLAN
SCALE: 1/4"=1'-0"

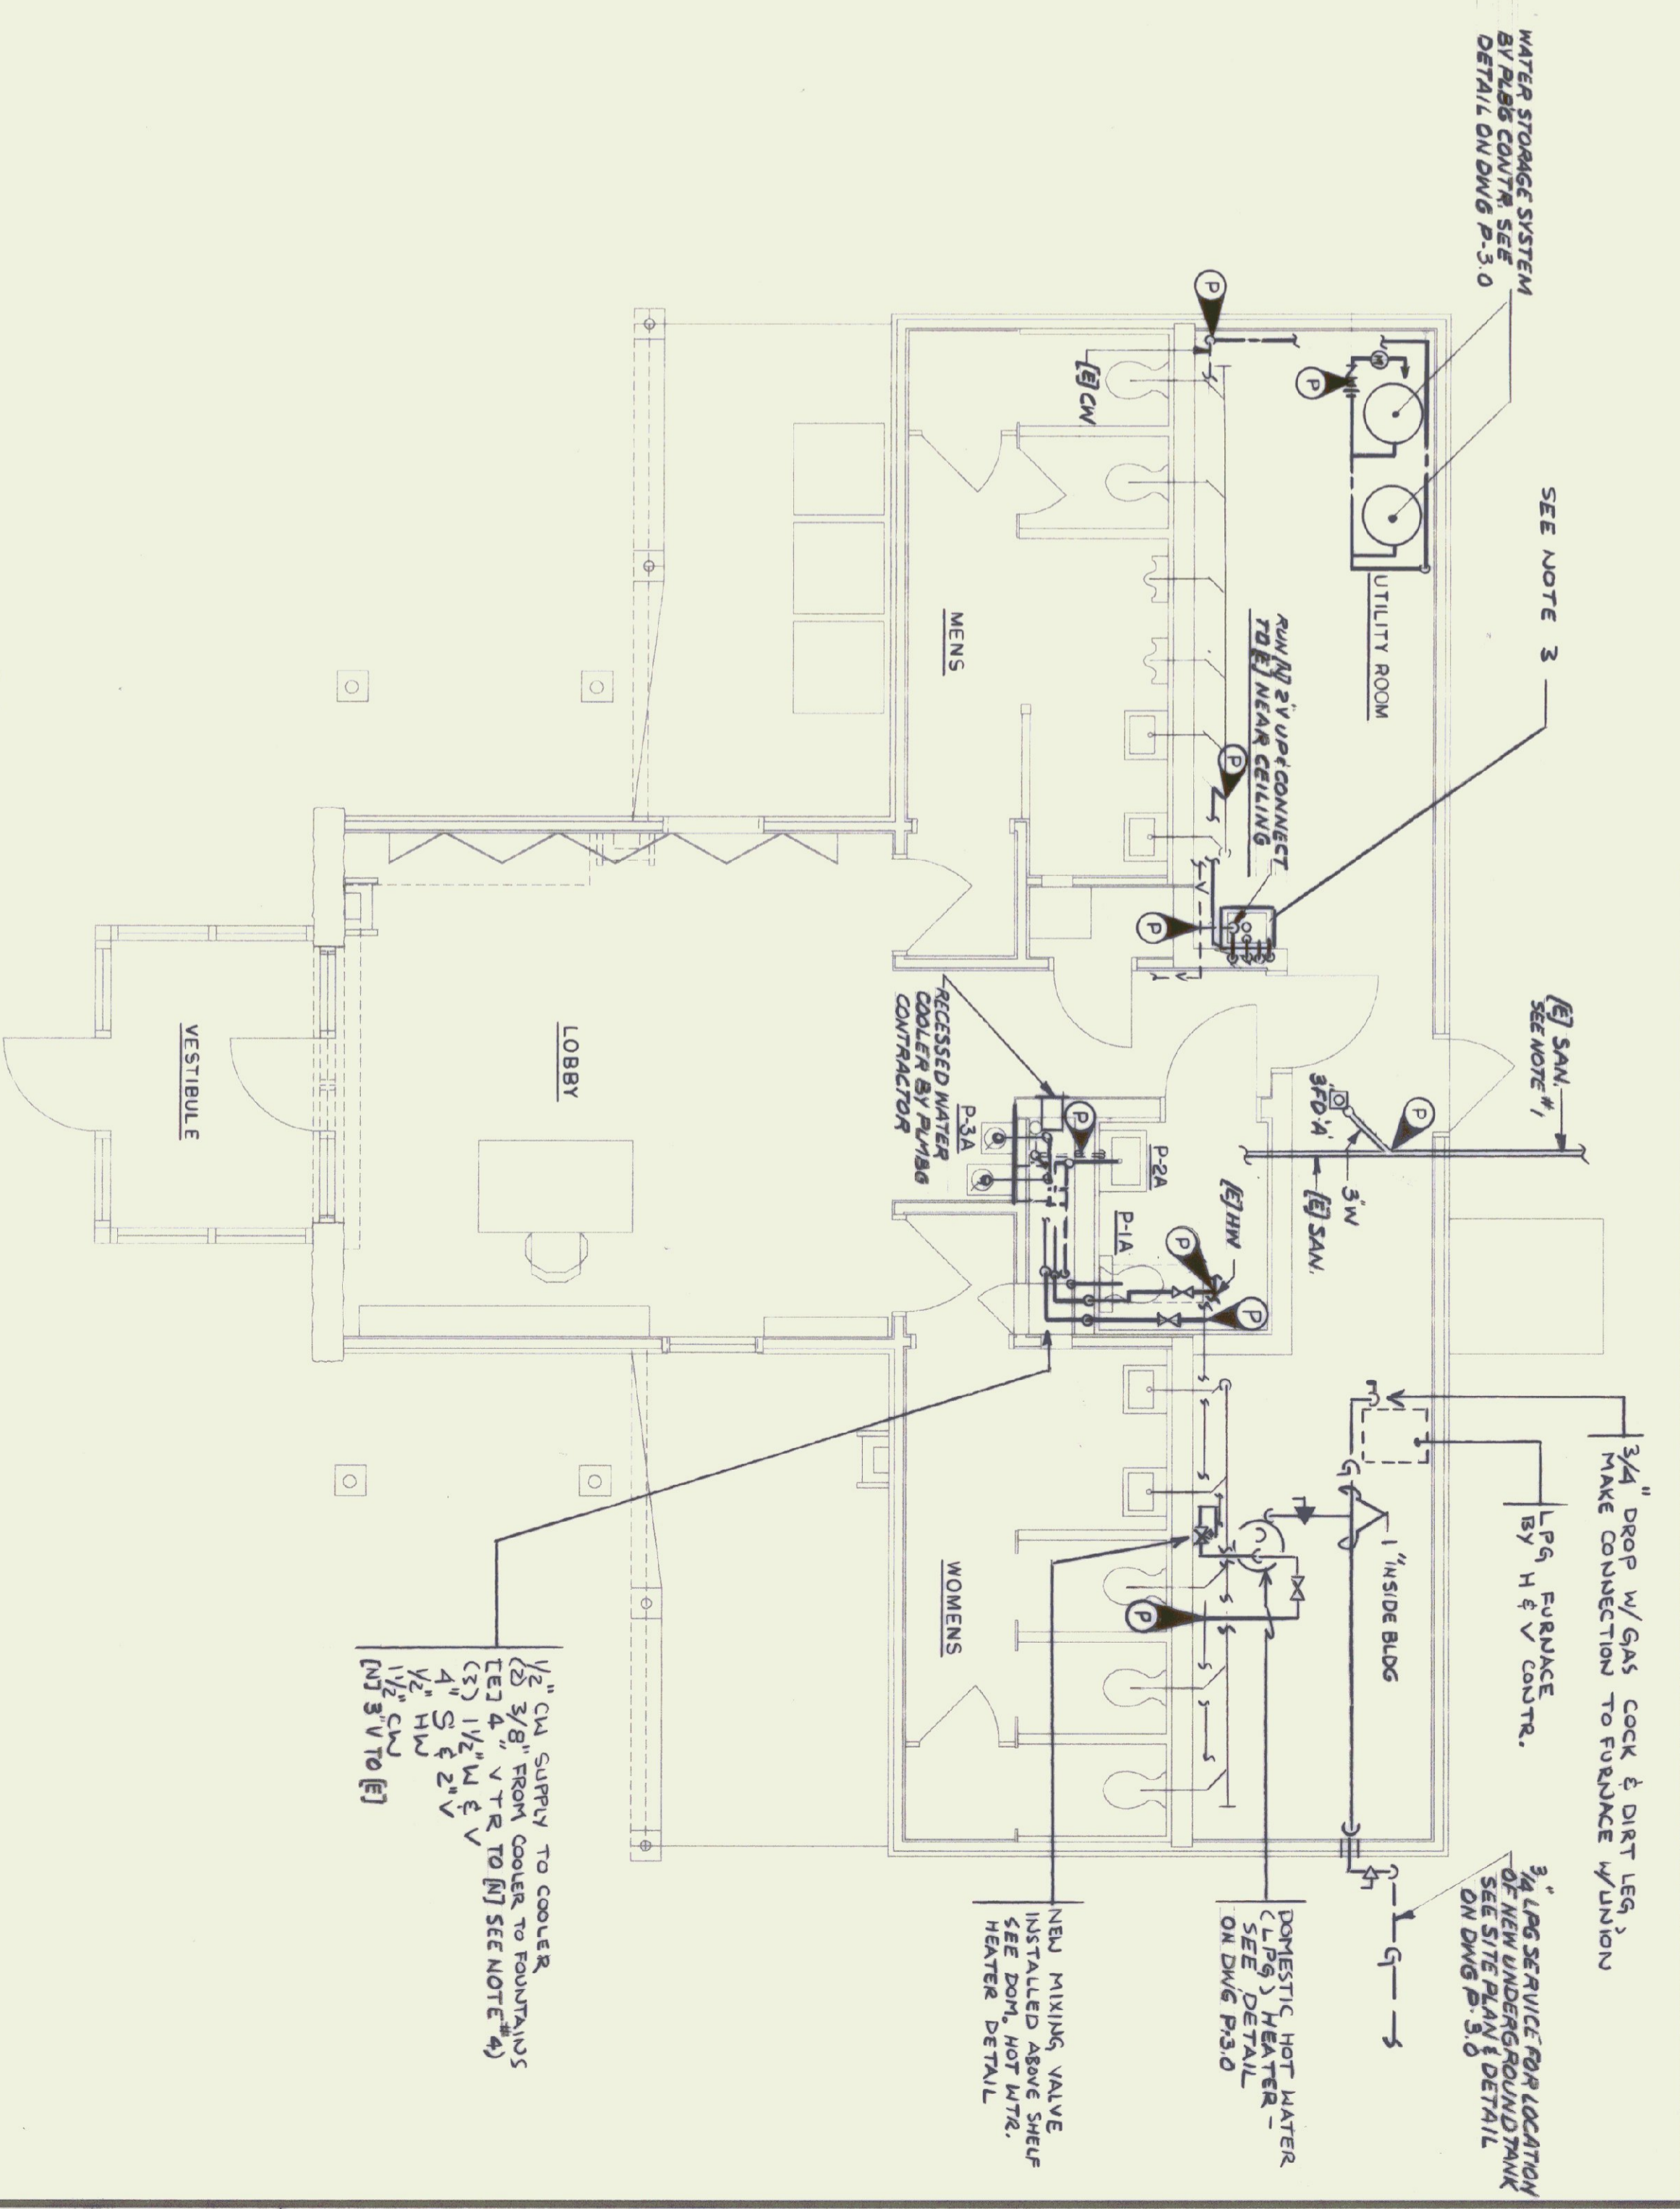

RENOVATION - PLUMBING-FLOOR PLAN
SCALE: 1/4"=1'-0"

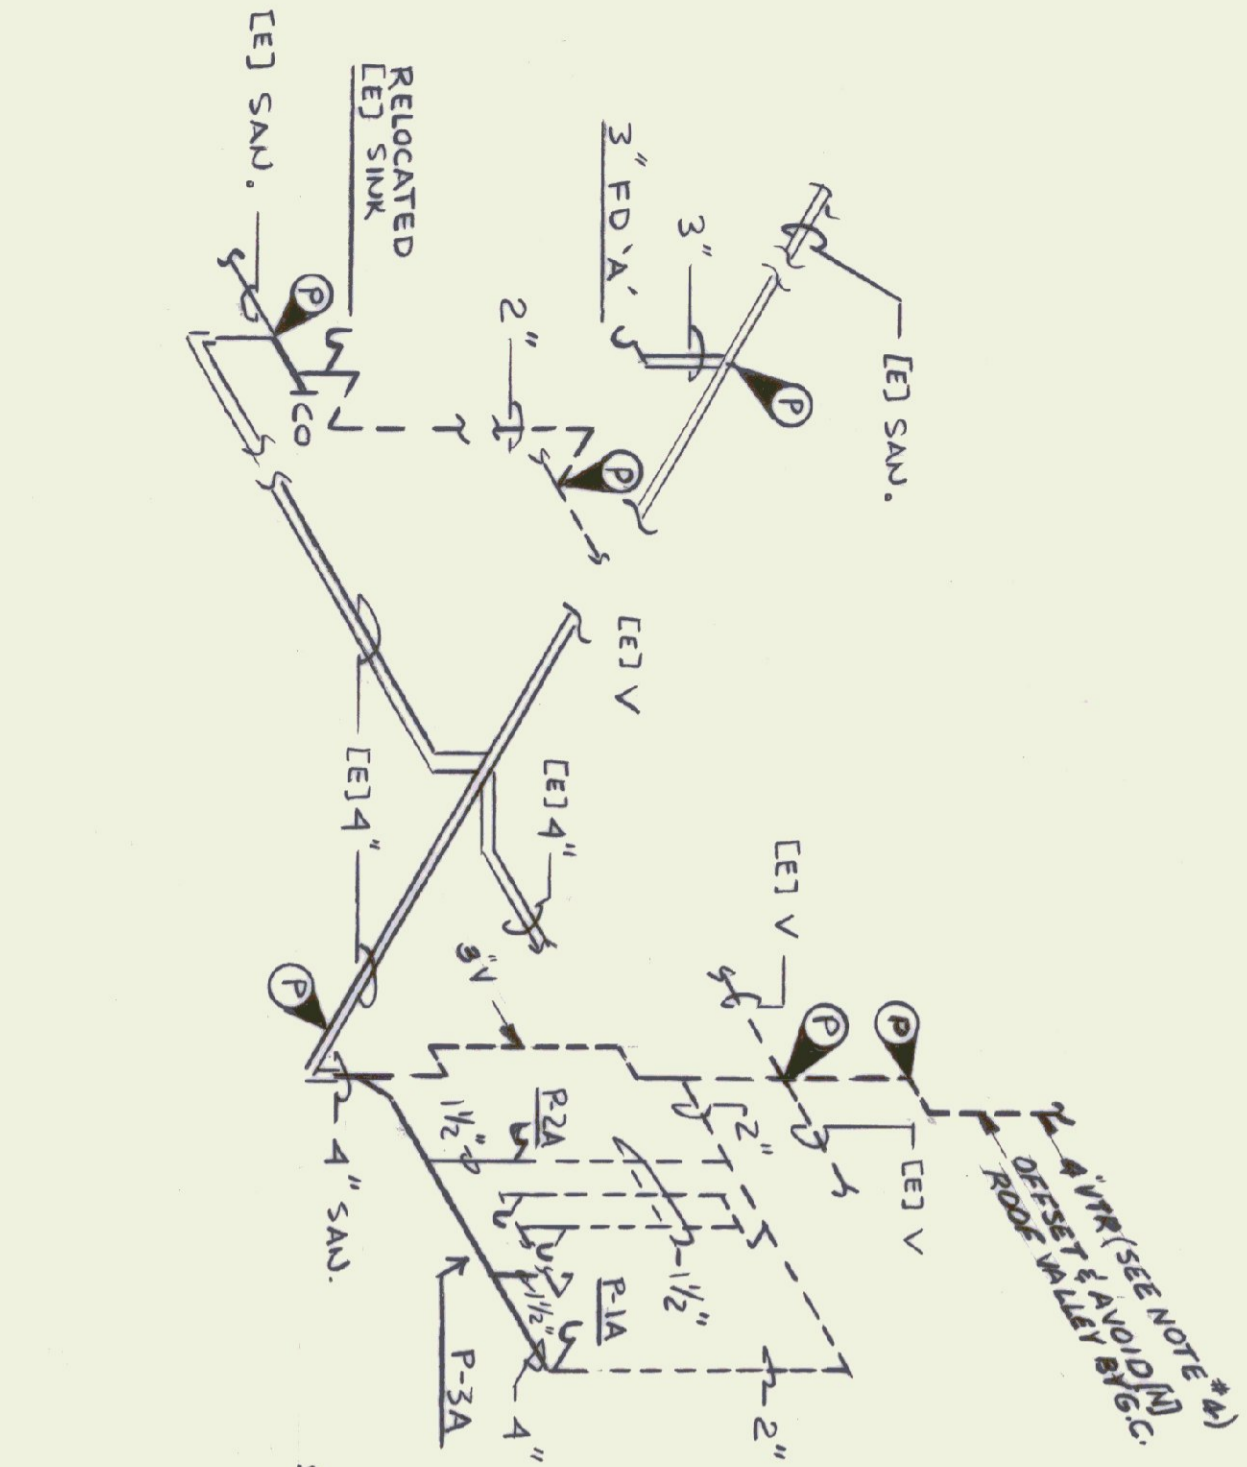

SANITARY & VENT ISOMETRIC DIAGRAM RENOVATIONS
NOT TO SCALE

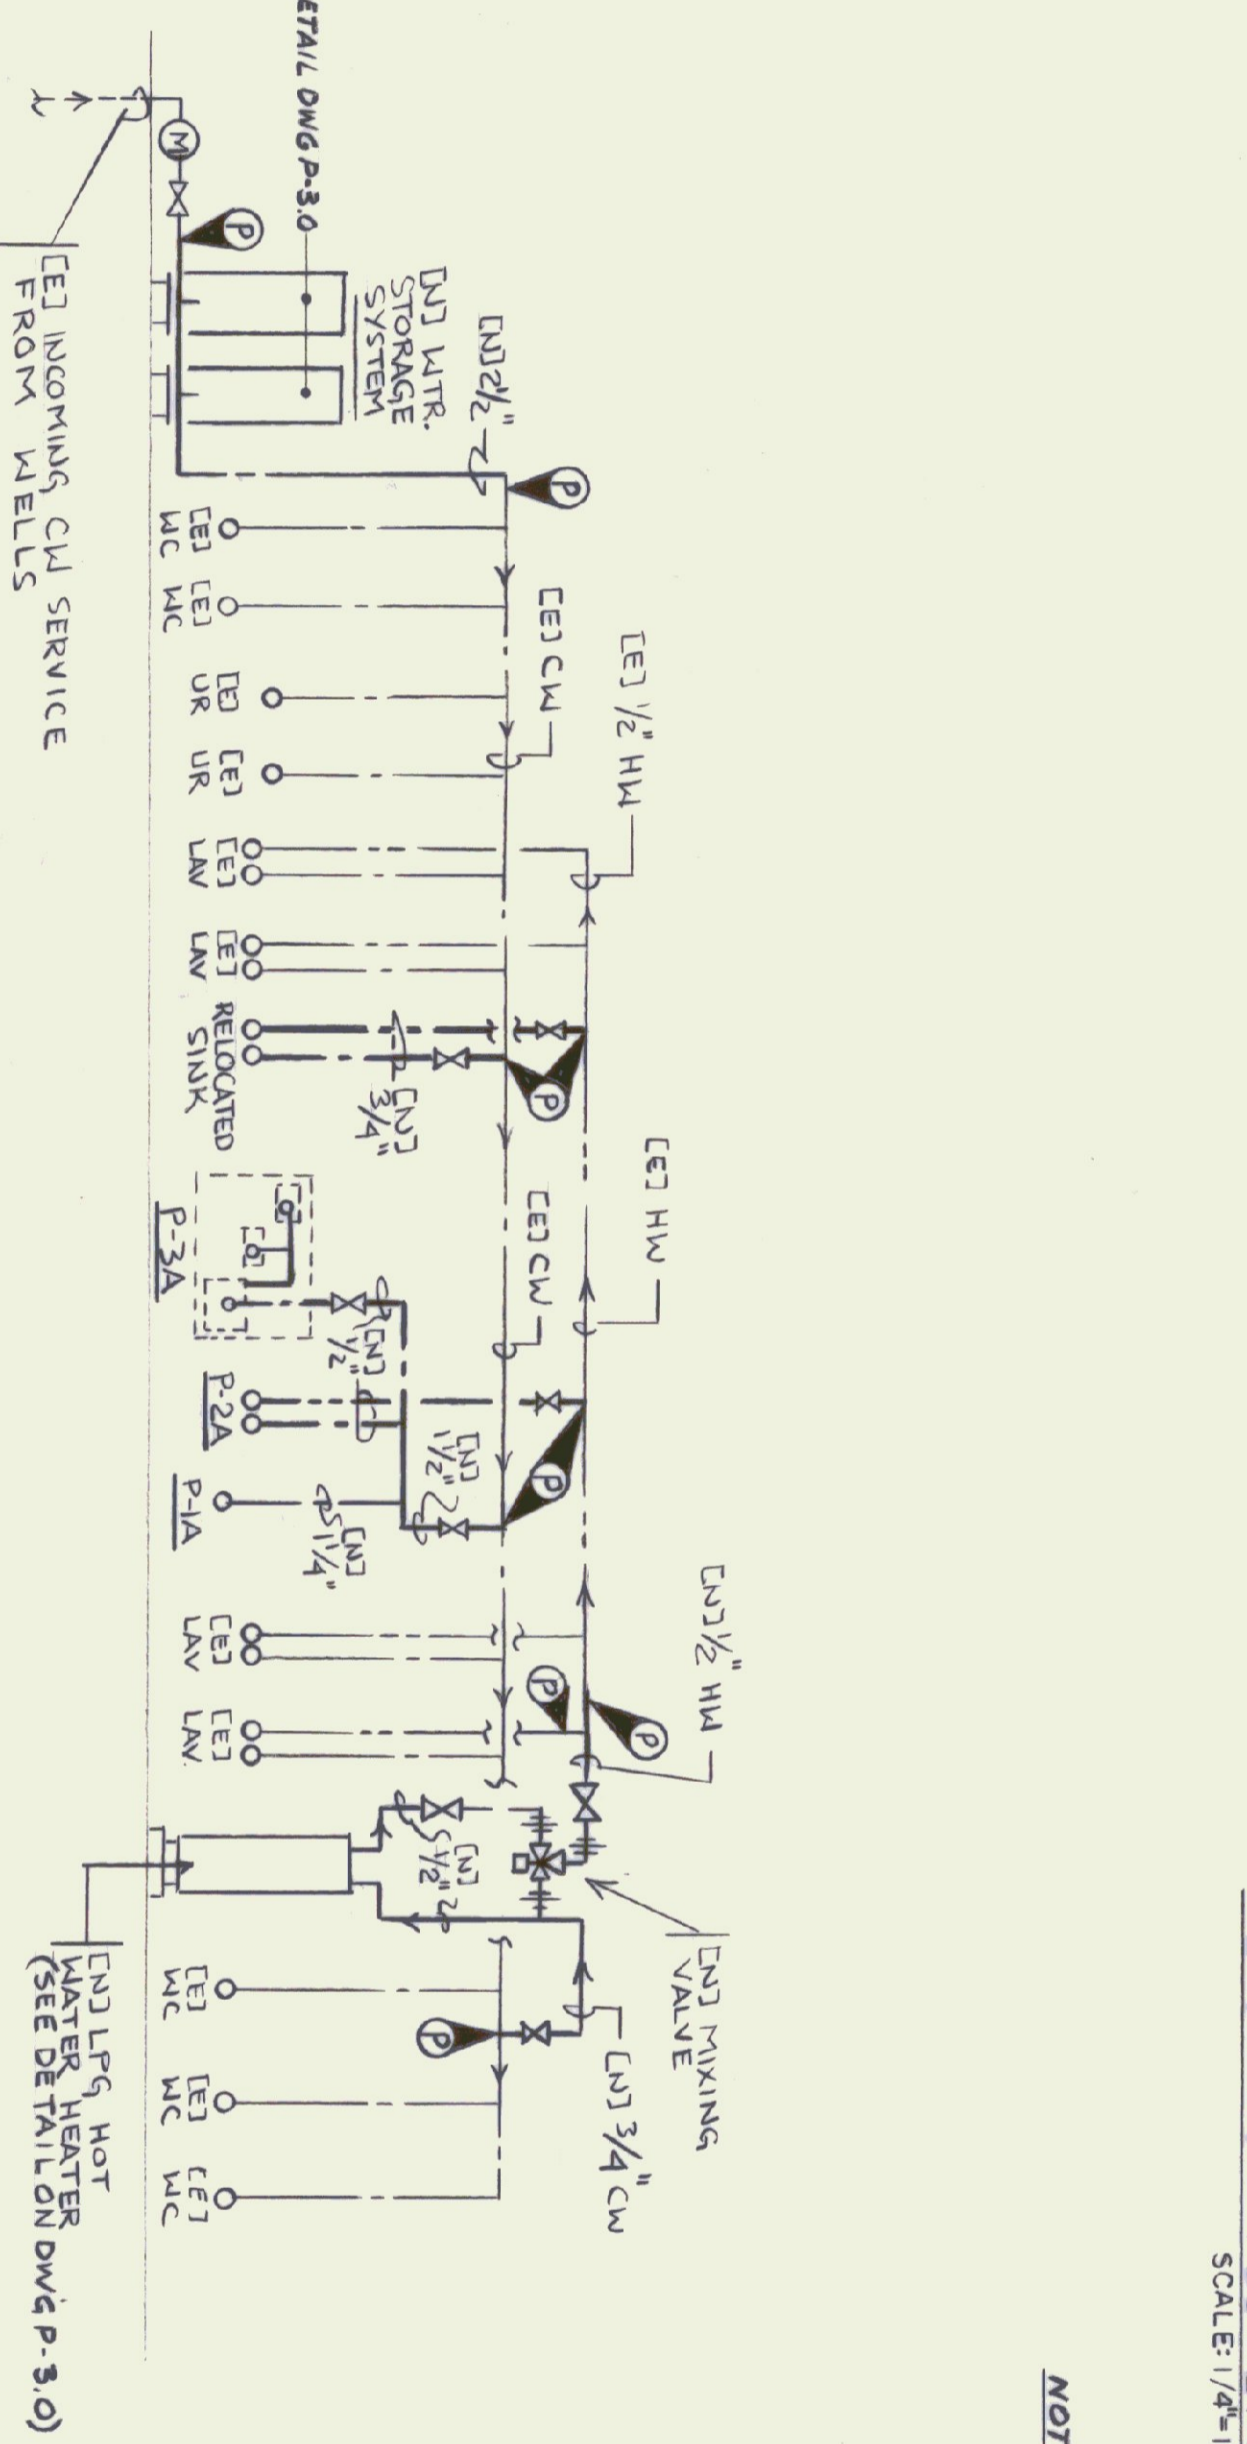


HOT & COLD WATER RISER DIAGRAM RENOVATIONS
NOT TO SCALE

NOTES:

1. THE UNDERFLOOR SANITARY SYSTEM PIPING IS ASSUMED TO BE APPROX. CORNER, HOWEVER, THE PLUMBING SUB CONTRACTOR SHALL VERIFY THE LOCATION PRIOR TO THE GENERAL CONTRACTOR BEGINNING WORK ON THE FLOOR.
2. COORDINATE ALL WORK W/ EXISTING CONDITIONS & (R) WORK BY OTHER TRADES.
3. RELOCATE (E) SINK W/ ALL (L) HOT & COLD WATER PIPING W/ SHUT-OFFS. VENT, WASTE W/ TRAP PIPING SYSTEMS (P) PIPING SIZED TO (E) SINKS. VENT, WASTE W/ TRAP PIPING SYSTEMS (P) PIPING SIZED TO (E) SINKS. VENT, WASTE W/ TRAP PIPING SYSTEMS (P) PIPING SIZED TO (E) SINKS. VENT, WASTE W/ TRAP PIPING SYSTEMS (P) PIPING SIZED TO (E) SINKS.
4. EXTEND (E) VENT UP THRU NEW ROOF STRUCTURE & OFFSET AS REQ'D TO AVOID (L) ROOF VALLEY THIS CONTRACTOR TO FURNISH NEW (O) GA CORNER ROOF SLEEVE TO ROOFING SUB CONTRACTOR.
5. SEE DWG P-3.0 FOR LEGEND, FIXTURE SCHEDULE & DETAILS.

RECORD DRAWING

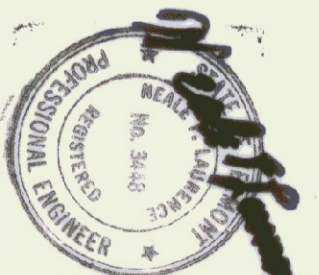

STATE OF VERMONT DEPARTMENT OF STATE BUILDINGS AGENCY OF ADMINISTRATION MONTPELIER, VERMONT		REST AREA REHABILITATION GEORGIA I-89 SOUTHBOUND PLUMBING - DEMOLITION & RENOVATION FLOOR PLANS, SCHEDULE, DETAIL & LEGEND	
DATE: 8-21-98	SCALE: 1/4"=1'-0"	REVISIONS:	DRAWING NO.: P-2.0
DRAWN BY: DG	APPROVED BY: NFL	DRAWING NAME: PLUMBING	SHEET: OF