

NORTHERN ARCHITECTS
 SUITE 3
 207 KING STREET
 BURLINGTON, VERMONT
 05401-4502
 802-688-1953

CONSULTANTS
 CIVIL
 KREBS AND LANGING
 10 Main Street
 Colchester VT 05446
 (802)-878-0315
 LANDSCAPE ARCHITECT
OHKW
 7 Marble Ave.
 Burlington VT 05401
 (802)-864-0010
 STRUCTURAL
 RICHARD M. DOHERTY, P.E.
 117 St. Paul Street
 Burlington VT 05401
 (802)-660-4212
 PLUMBING, MECHANICAL,
 AND ELECTRICAL
 DUFRESNE-HENRY
 Precision Park
 North Springfield VT 05150-0024
 (802)-866-2261


REVISIONS

PROJECT
DERBY WELCOME CENTER
 PROJECT #101-3(8)
 NEW FACILITY
 DERBY VERMONT

DATE: 01/01/02
 SCALE: AS NOTED
 CHECKED:
 PROJECT NO: 2003

WASTE & VENT PIPING PLAN


P2.2

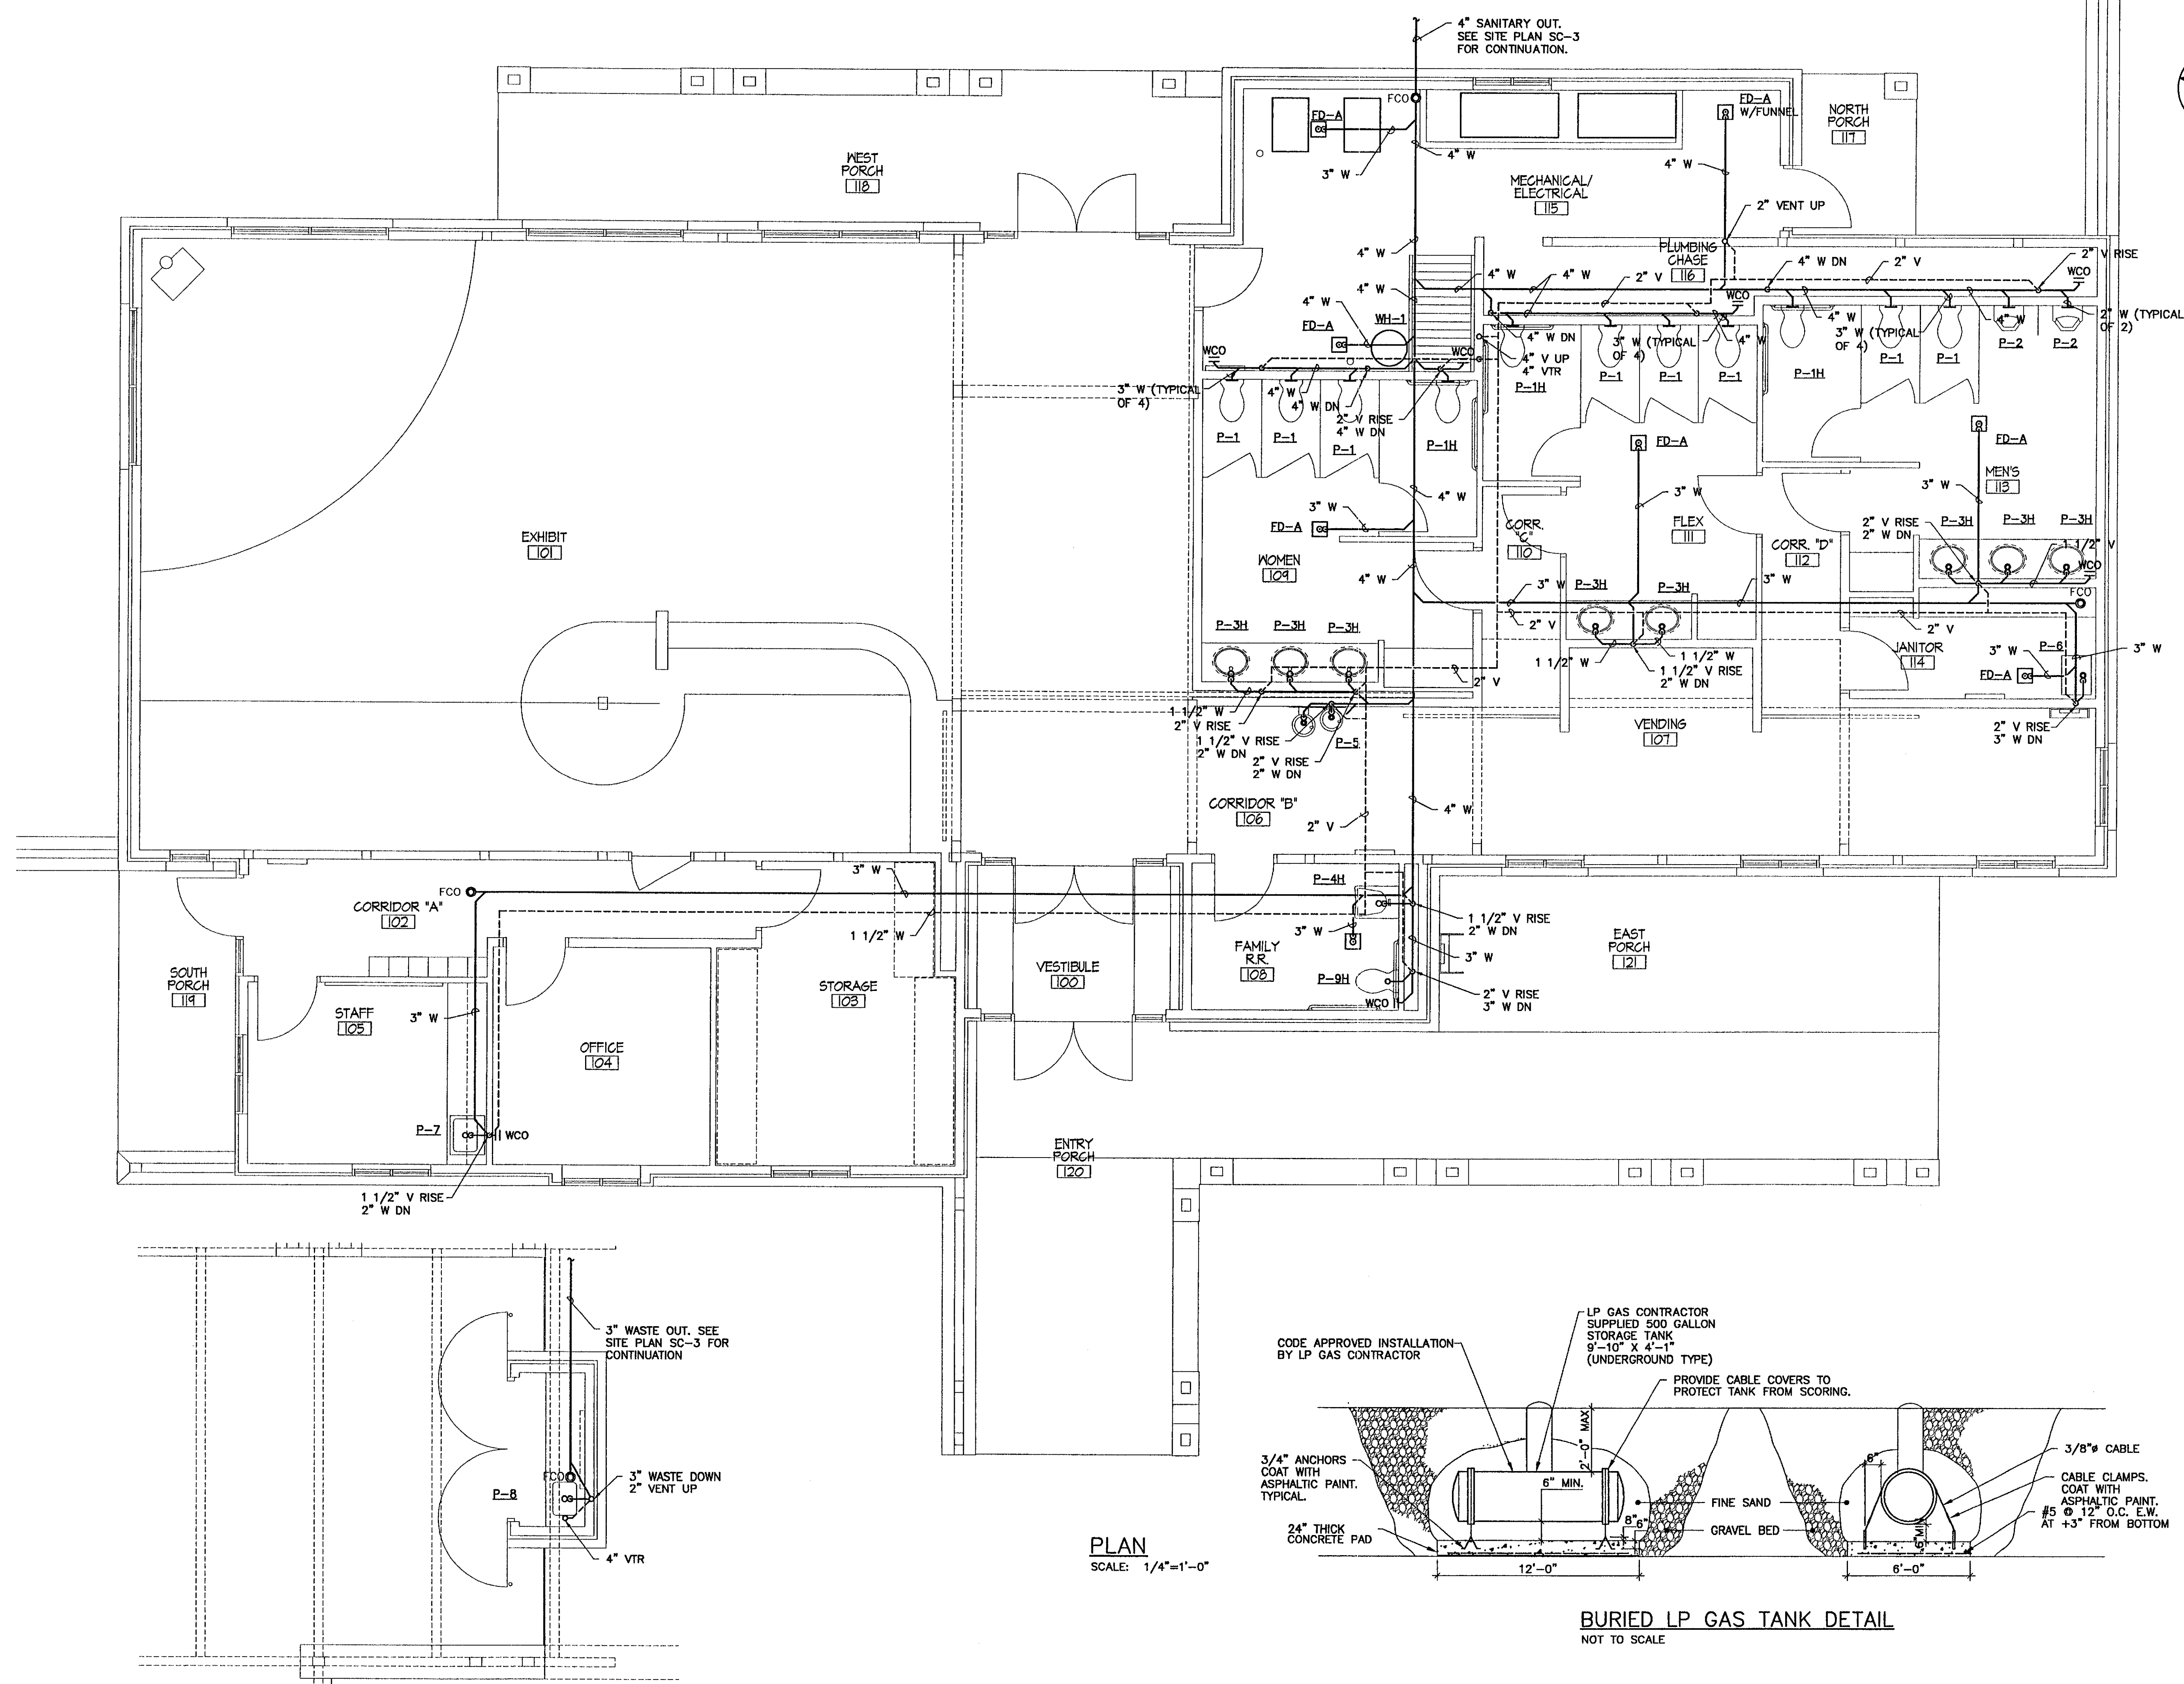

N:\VERMONT - STATE OF\DERBY WELCOME CENTER\MECH\2.2-SAN.DWG 1-4-02 12:19:17 pm EST

WASTE AND VENT PIPING PLAN - PAVILION
 SCALE: 1/4"=1'-0"

PLAN
 SCALE: 1/4"=1'-0"

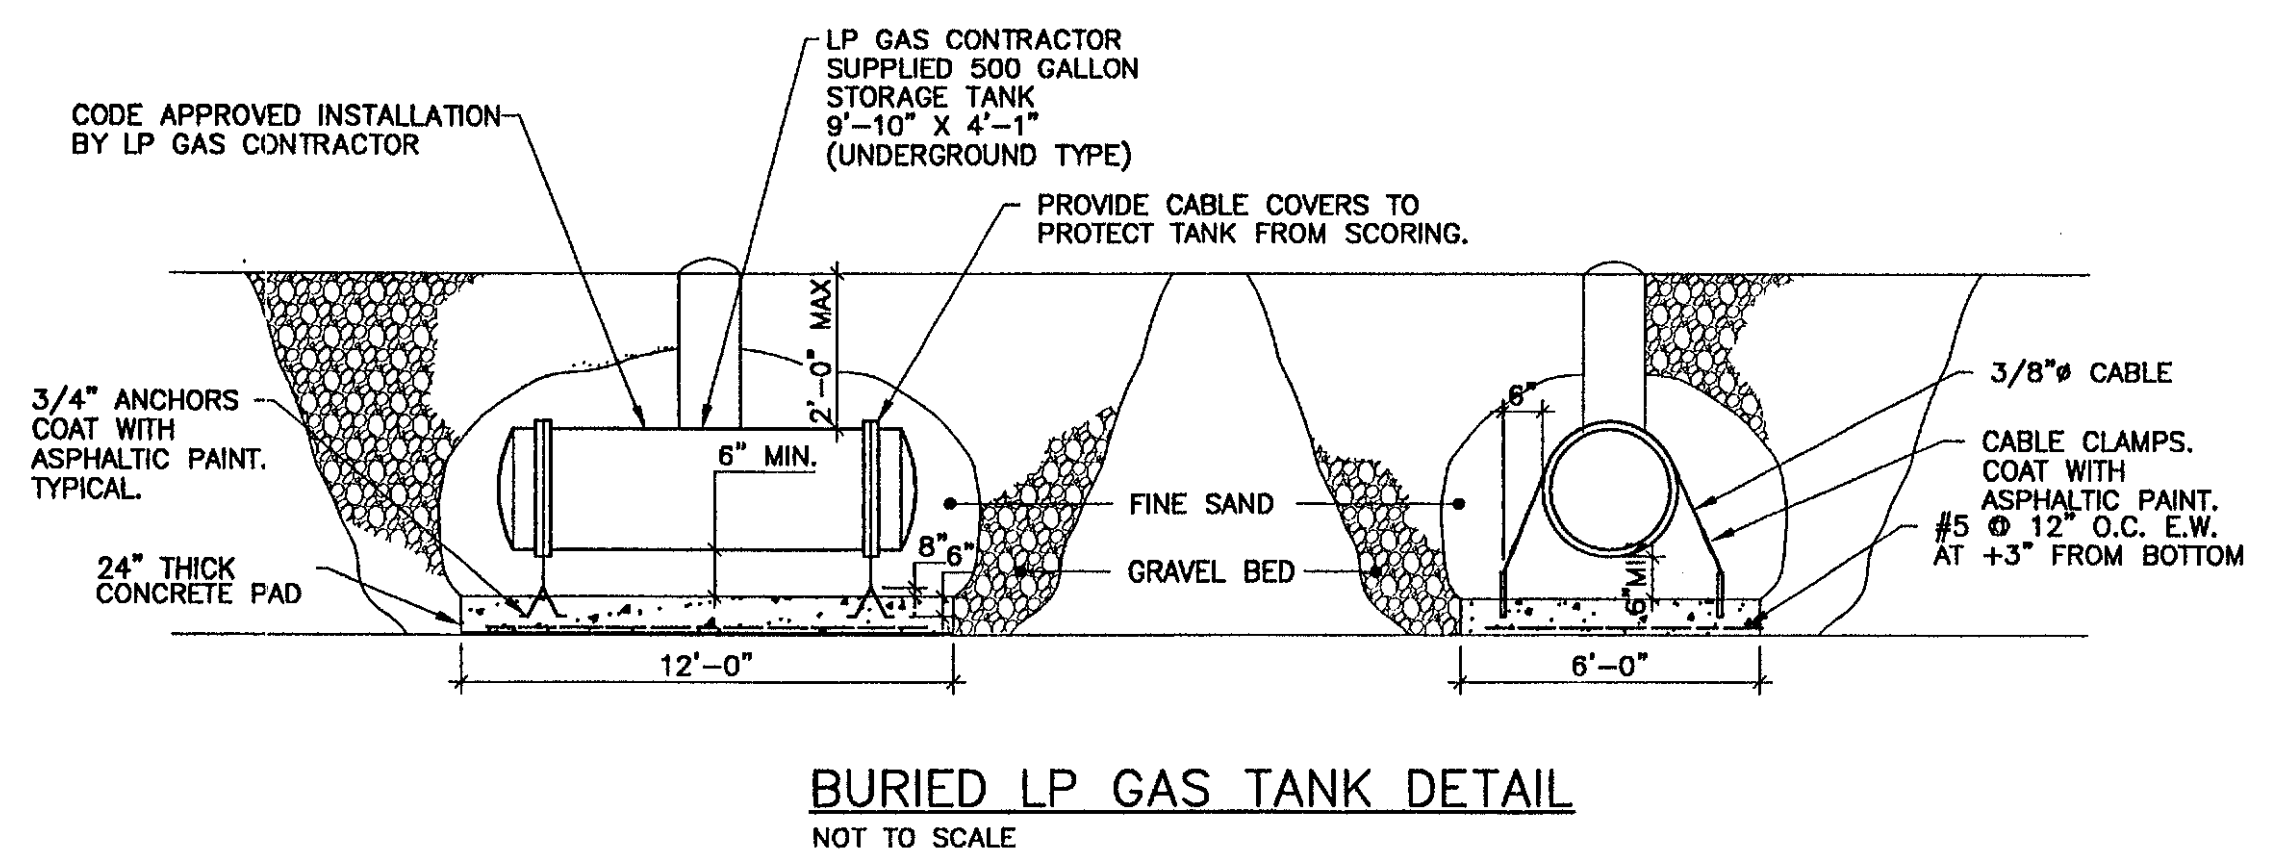

BURIED LP GAS TANK DETAIL
 NOT TO SCALE