

NORTHERN ARCHITECTS

207 KING STREET
SUITE 3
BURLINGTON, VERMONT
05401-4502
802-658-1953

CONSULTANTS
CIVIL
KREBS AND LANSING
10 Main Street
Colchester VT 05446
(802)-818-0515
LANDSCAPE ARCHITECT
OHKW
OFFICE OF J. R. KEITH WAGNER
7 Marble Ave.
Burlington VT 05401
(802)-864-0010
STRUCTURAL
RICHARD M. DOHERTY, P.E.
117 St. Paul Street
Burlington VT 05401
(802)-860-4312
PLUMBING, MECHANICAL,
AND ELECTRICAL
D'JFRENE-HENRY
Precision Park
North Springfield VT 05150-0024
(802)-886-2261

REVISIONS

PROJECT

DERBY WELCOME CENTER
PROJECT #101-3(8)


NEW FACILITY

DERBY
VERMONT

DATE: 01/01/02
SCALE: AS SHOWN
CHECKED:
PROJECT NO: 2003

LIGHTING PLAN

E1.1

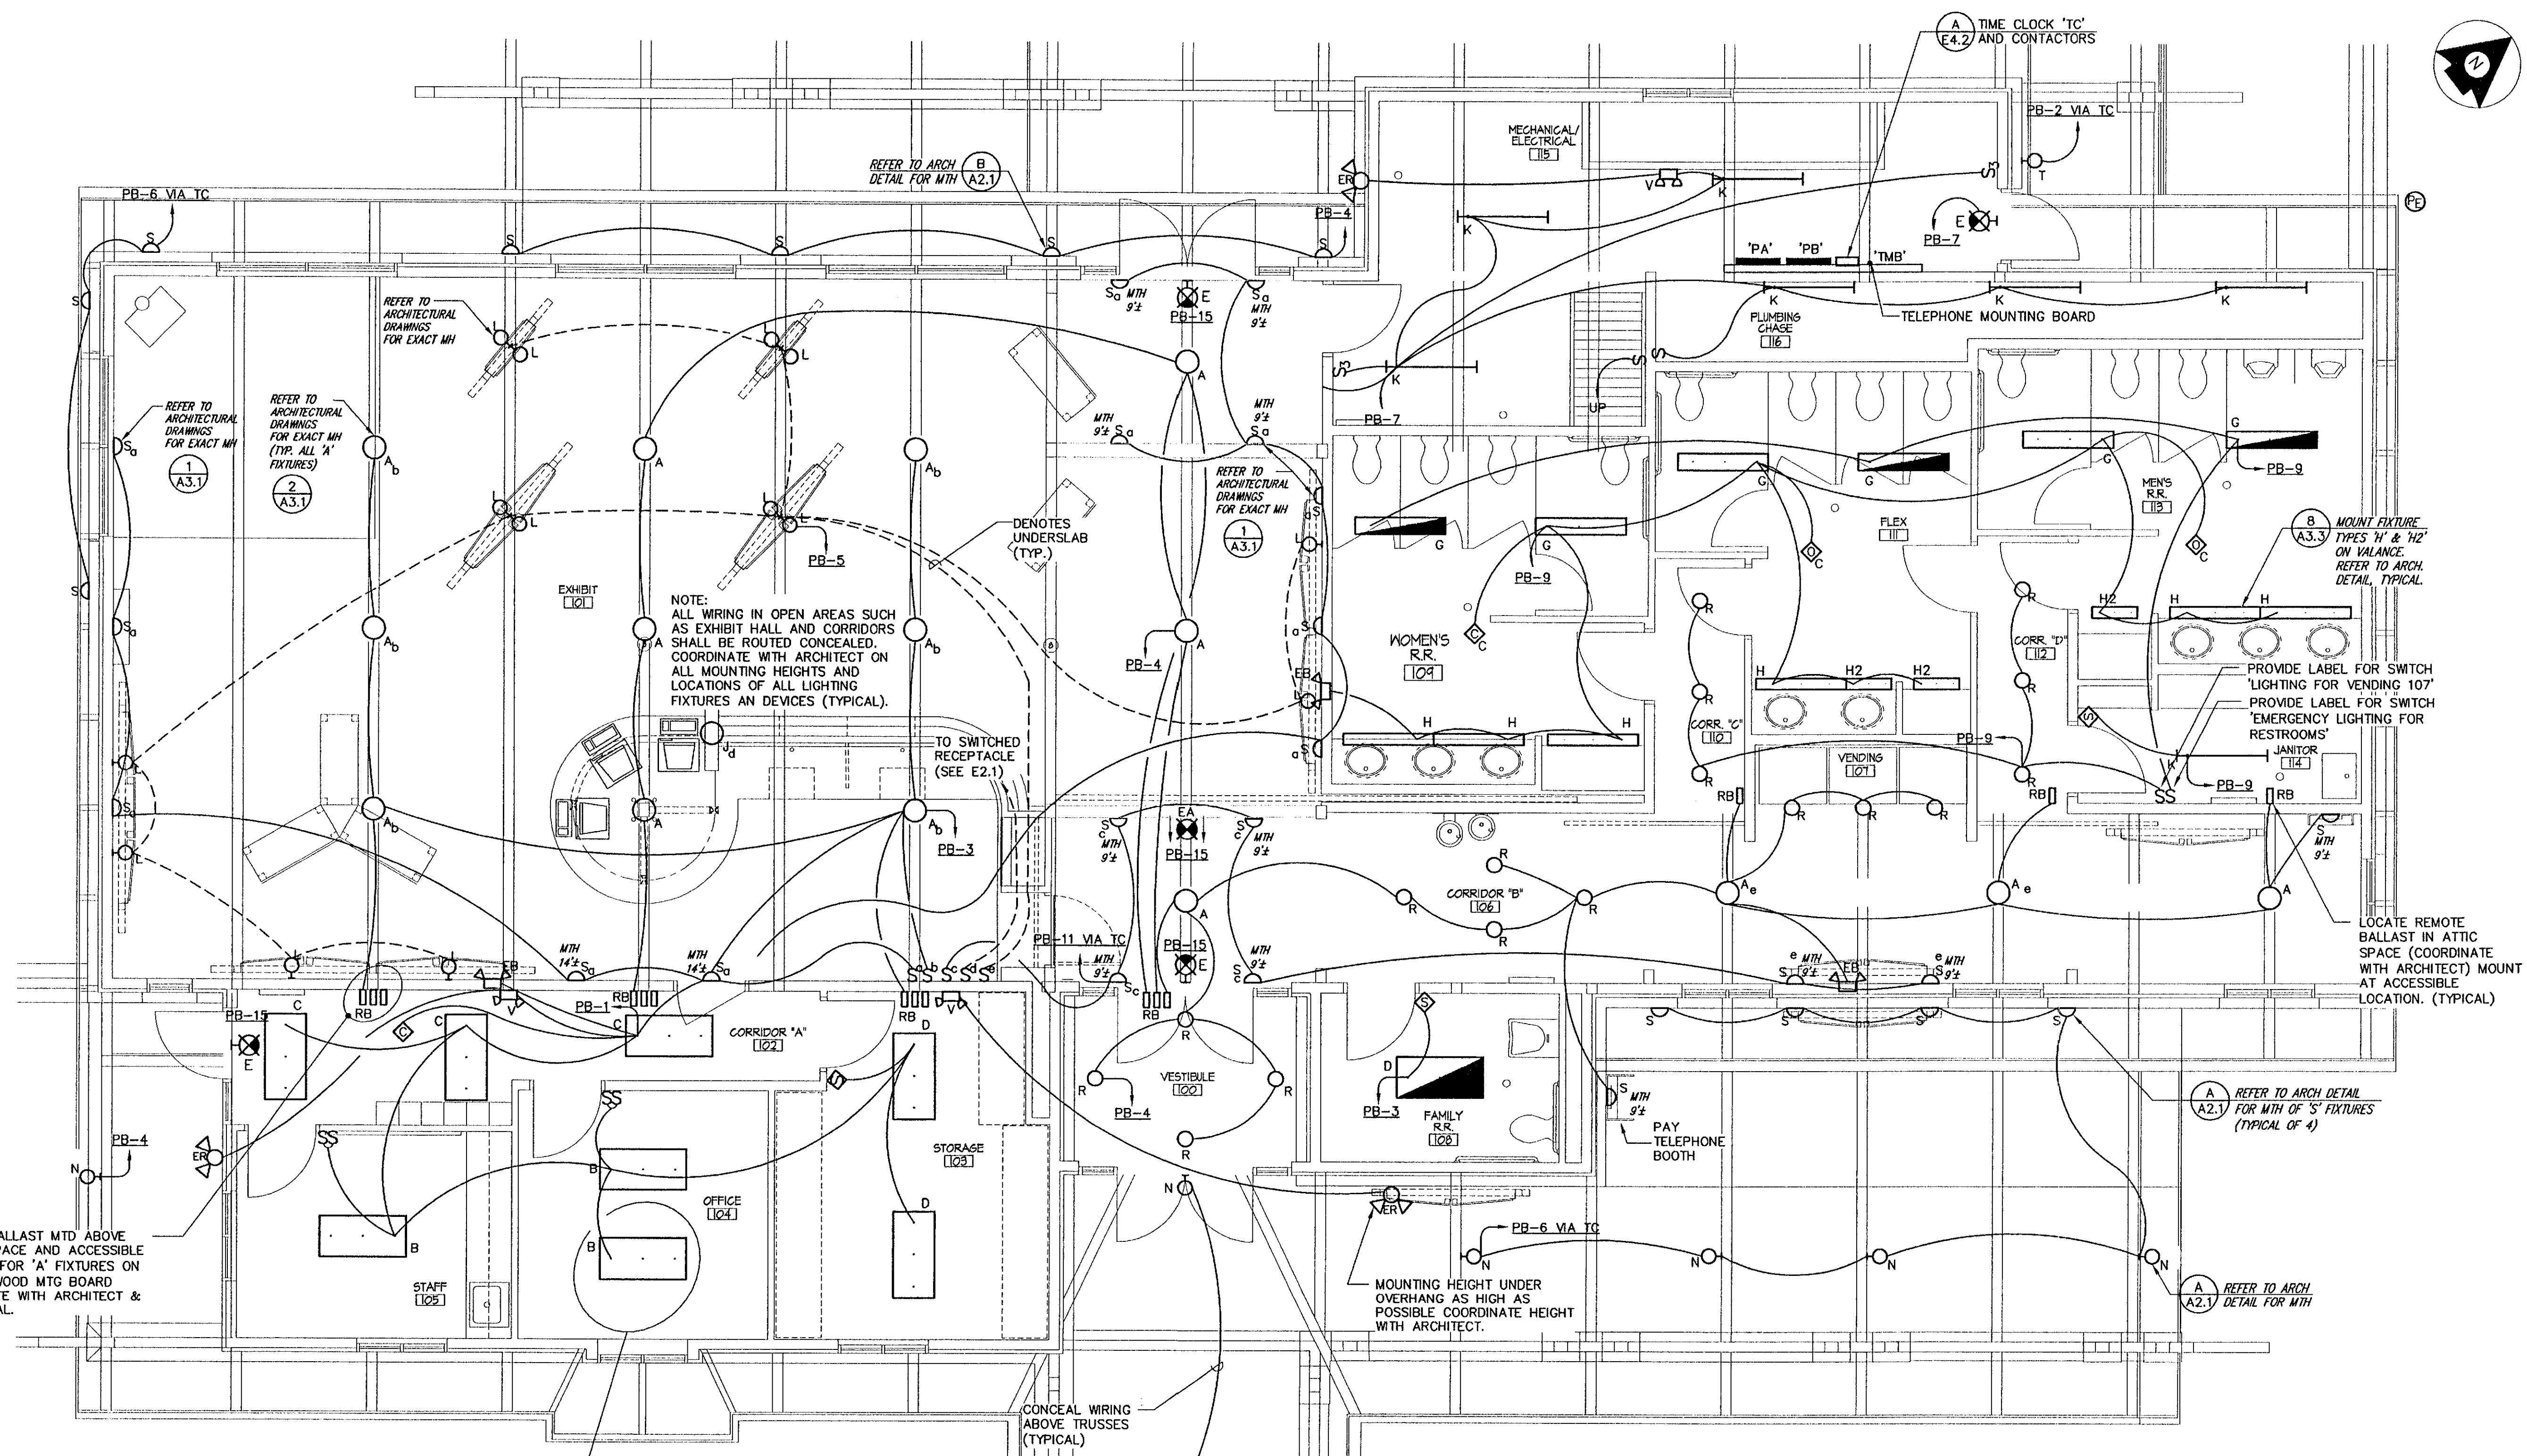


NOTE: ALL WIRING IN OPEN AREAS SUCH AS EXHIBIT HALL AND CORRIDORS SHALL BE ROUTED CONCEALED. COORDINATE WITH ARCHITECT ON ALL MOUNTING HEIGHTS AND LOCATIONS OF ALL LIGHTING FIXTURES AND DEVICES (TYPICAL).

REMOTE BALLAST MTD ABOVE CEILING SPACE AND ACCESSIBLE LOCATION FOR 'A' FIXTURES ON 3/4" PLYWOOD MTD BOARD COORDINATE WITH ARCHITECT & MECHANICAL.


TYPE	MANUFACTURER	CATALOG NUMBER	TYPE	COLOR	MOUNTING	VOLTAGE	LAMPS	REMARKS	TOTAL
A	AAL	UCS-SR-STR-PM5	MH	BY ARCH	PENDANT	120	(1) 70W MH ED-17	SEE ARCH FOR MH (SEE NOTE 6)	94
B	METALUX	2EP3GX-332-S-36-120-EB82	FLOOR	WHITE	RECESSED	120	(3) F32T8	DUAL BALLASTS FOR DUAL SWITCHING	96
C	METALUX	2GC-332-A128-120-EB82	FLOOR	WHITE	RECESSED	120	(3) F32T8		96
D	METALUX	2EP3GX-232-S-16-120-EB81	FLOOR	WHITE	RECESSED	120	(2) F32T8		62
E	SURE-LITES	CAX-7170-R-SD	LED	BLACK	WALL	120	L.E.D. (FURNISHED)	MOUNT AT 100" A.F.F..	6
EA	SURE-LITES	CAX-7270-R-SD	LED	BLACK	WALL	120	L.E.D. (FURNISHED)	MOUNT AT 100" A.F.F..	6
EB	LIGHTGUARD	11-A-0TTP	EMERG	ALUM	WALL	120	(2) 35W MR16		39
ER	SURE-LITES	12T-12-DWXX	EMERG	BY ARCH	WALL	12	(2) 12W - 12V #Q29-79		24
G	KURTZON LIGHTING	VL-F-1-1x4-2/OCT-120-1/13	FLOOR	WHITE	CEILING	120	(2) F32T8		64
H	METALUX	SS-132-120-EB1	FLOOR	WHITE	WALL	120	(1) F32T8	W/ SSL4INREV4FTREFLSR	32
H2	METALUX	SS-117T8-120-EB1	FLOOR	WHITE	WALL	120	(1) F17T8	W/ SSL4INREV4FTREFLSR	17
J	POULSON	PH4-3	BY ARCH	BY ARCH	TABLE	120		WIRE TO SWITCHED RECEPTACLE	
K	METALUX	DCIM-232-120-EB81	FLOOR	WHITE	SURFACE	120	(2) F32T8		64
L	ABOLITE LIGHTING	URB100-INC-120-BRU-GBD3BRU	INCAN	ALUM	SURFACE	120	100W	GOOSENECK = TO GBD3 WITH 9" RADIUS	300
M	LITHONIA	TWAC50M-120	MH	WHITE	WALL	120	(1) 50W MH		73
N	AAL	UCS-SR-STR-WST	MH	BY ARCH	WALL	120	(1) 70W MH ED-17	SEE ARCH FOR MH	94
R	BEGA	1129/S40	FLOOR	STEEL	RECESSED	120	(1) 20W G4, 12W	W/ GUARD	40
S	BEGA	3016P	FLOOR	STEEL	WALL	120	(2) 9W PL	W/ COLD TEMP. BALLAST. SEE NOTE 5	21
T	BEGA	2114	FLOOR	STEEL	WALL	12	(1) 20W G4, 12V	W/ GUARD	25
V	SURE-LITES	CC-7	EMERG		WALL@7'-0"	120	W/ UNIT		25

- ALL EXIT SIGNS ('E' AND 'EA') ARE CIRCUITED TO PANEL PB-15, TYPICAL.
- CONTRACTOR TO COORDINATE ALL FIXTURES WITH LOCATIONS INDICATED ON THE ARCHITECTURAL DRAWINGS.
- ALL FLUORESCENT FIXTURES SHALL CONTAIN ELECTRONIC BALLAST, METAL-HALIDE FIXTURES SHALL BE PULSE-START.
- LAMP COLORS SHALL BE 35K TYPICAL FOR ALL FLUORESCENT FIXTURES.
- COORDINATE W/ ARCHITECT WHICH 'S' FIXTURES SHALL BE UPLIGHT OR DOWNLIGHT, TYPICAL.
- PROVIDE WITH REMOTE BALLAST (LOCATIONS AS SHOWN ON PLANS) ([] RB - DENOTES REMOTE BALLAST)

■ DENOTES LIGHTING FIXTURE COMPLETE WITH FLUORESCENT EMERGENCY BATTERY PACK EQUAL TO SURE-LITES FBP SERIES OR APPROVED EQUAL.

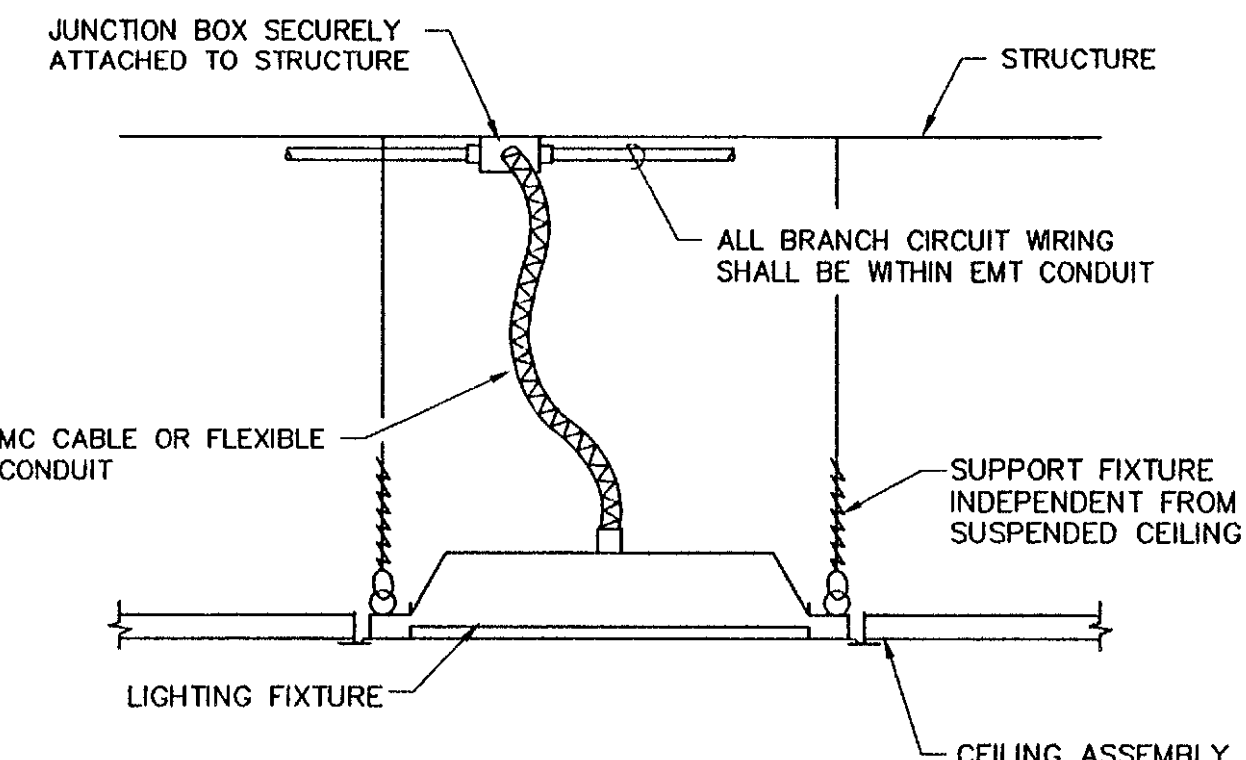

TYPICAL MOUNTING DETAIL FOR LIGHTING FIXTURE TYPES 'B', 'C' AND 'D'
NOT TO SCALE

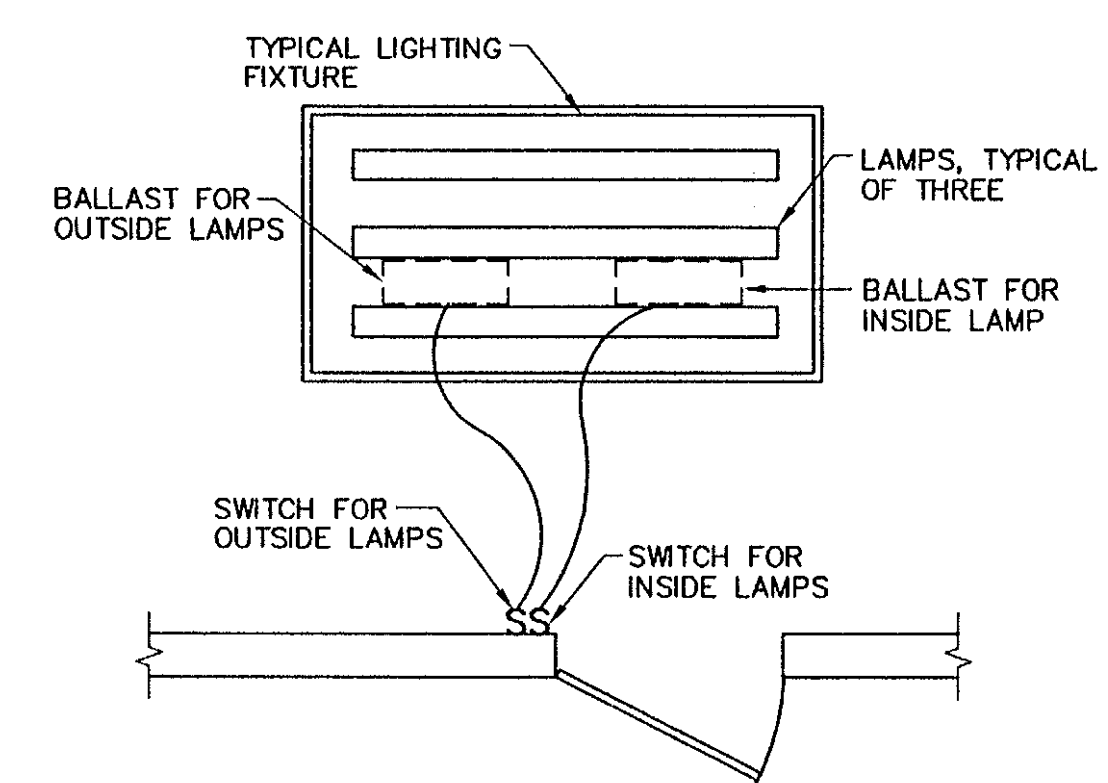

2-SWITCH CONTROL OF LIGHT FIXTURES
NOT TO SCALE

LIGHTING PLAN
SCALE = 1/4" = 1'-0"